

REVISIONS		APPROVED BY	
NO.	DATE	BY	DATE
1			
2			
3			



  

REVIEWED BY SECTIONS	DATE	APPROVED BY
ARCHITECTURAL	3-2-59	H. C. [Signature]
ENGINEERING	3-2-59	ASSISTANT CHIEF IN CHARGE
LANDSCAPE	3-2-59	OF DESIGN

DRAWN BY	CHECKED BY	DATE
J.R.	N.A.M.G.	

STATE GAME REFUGE

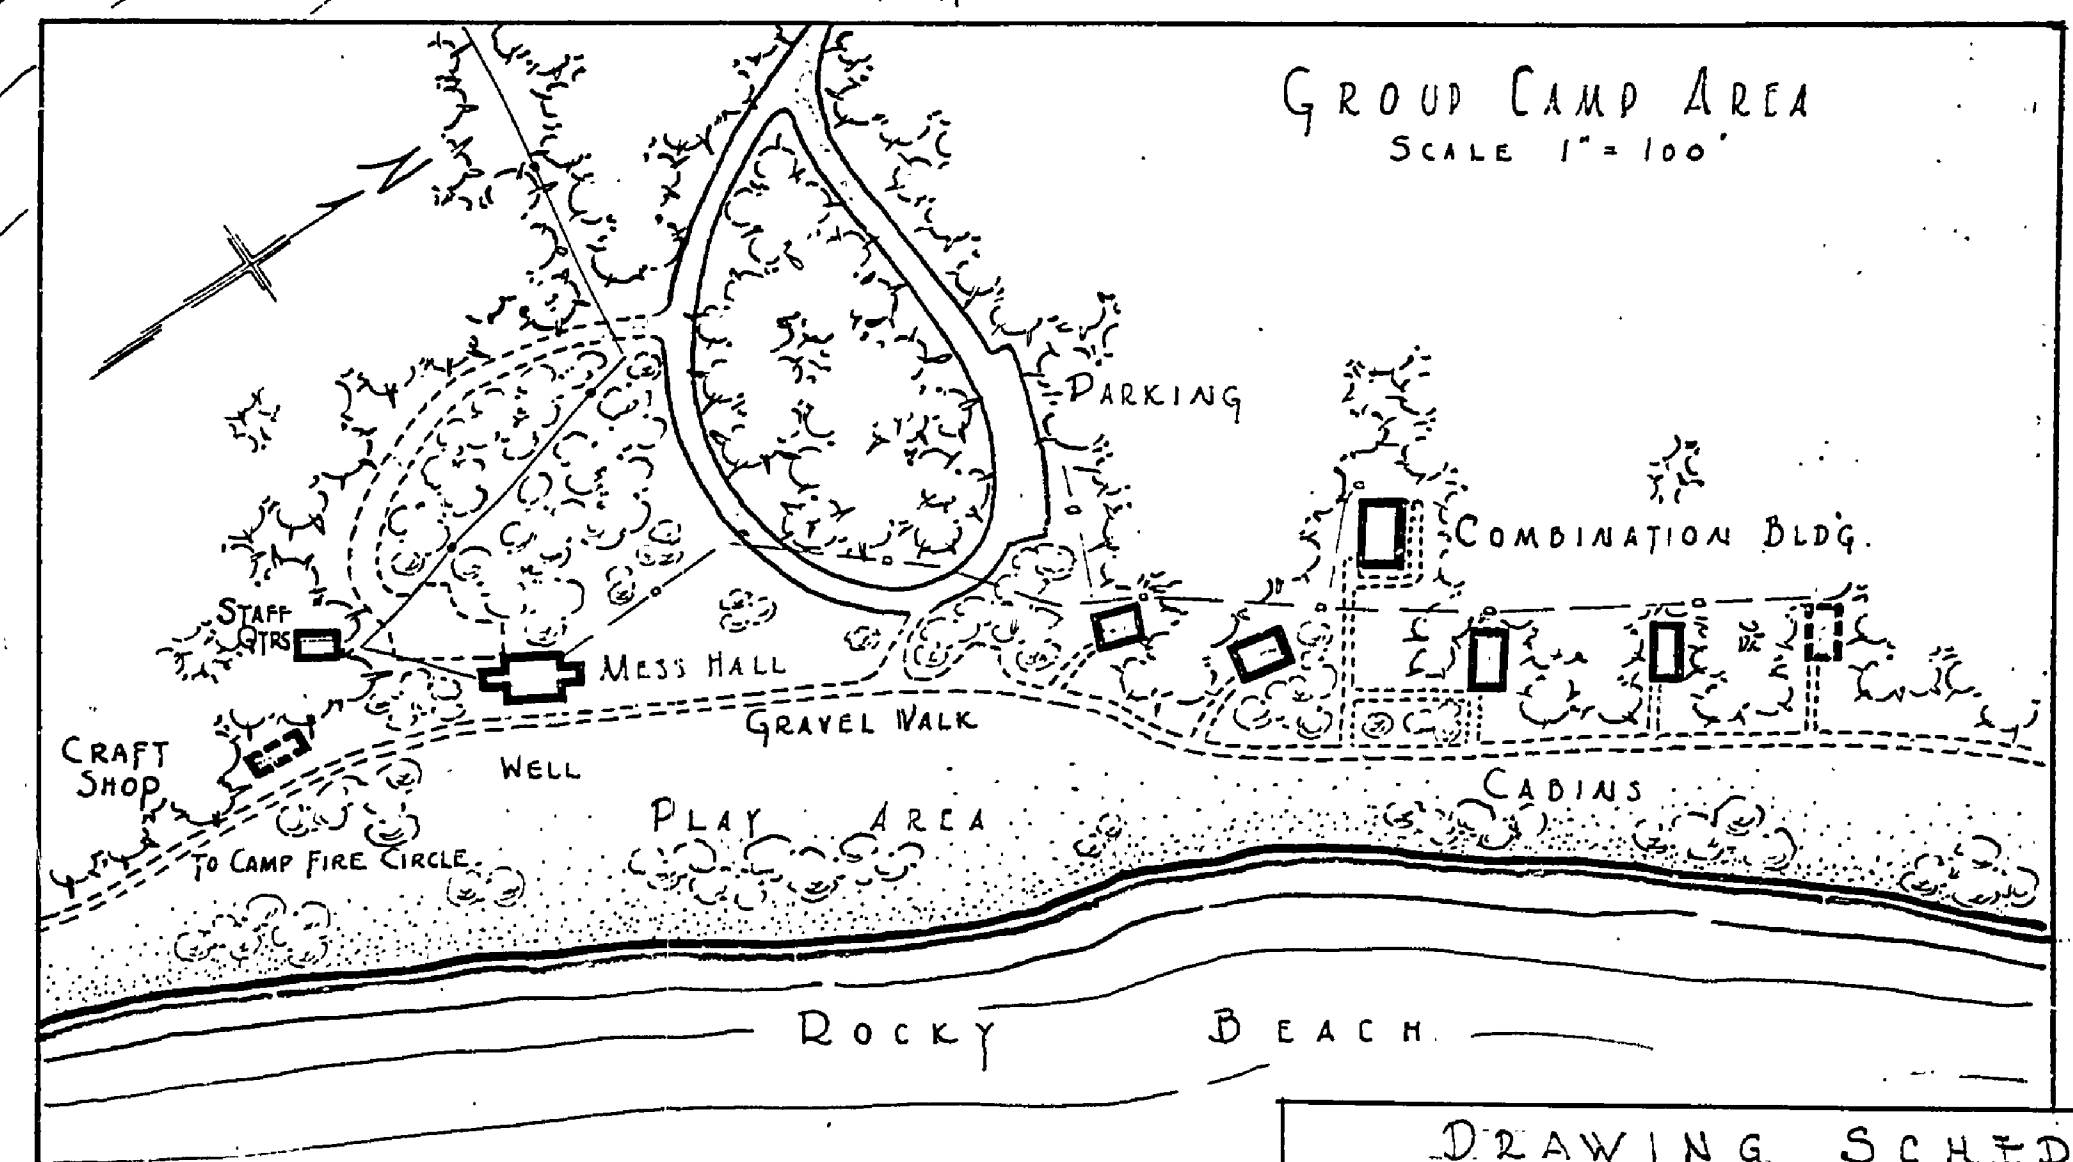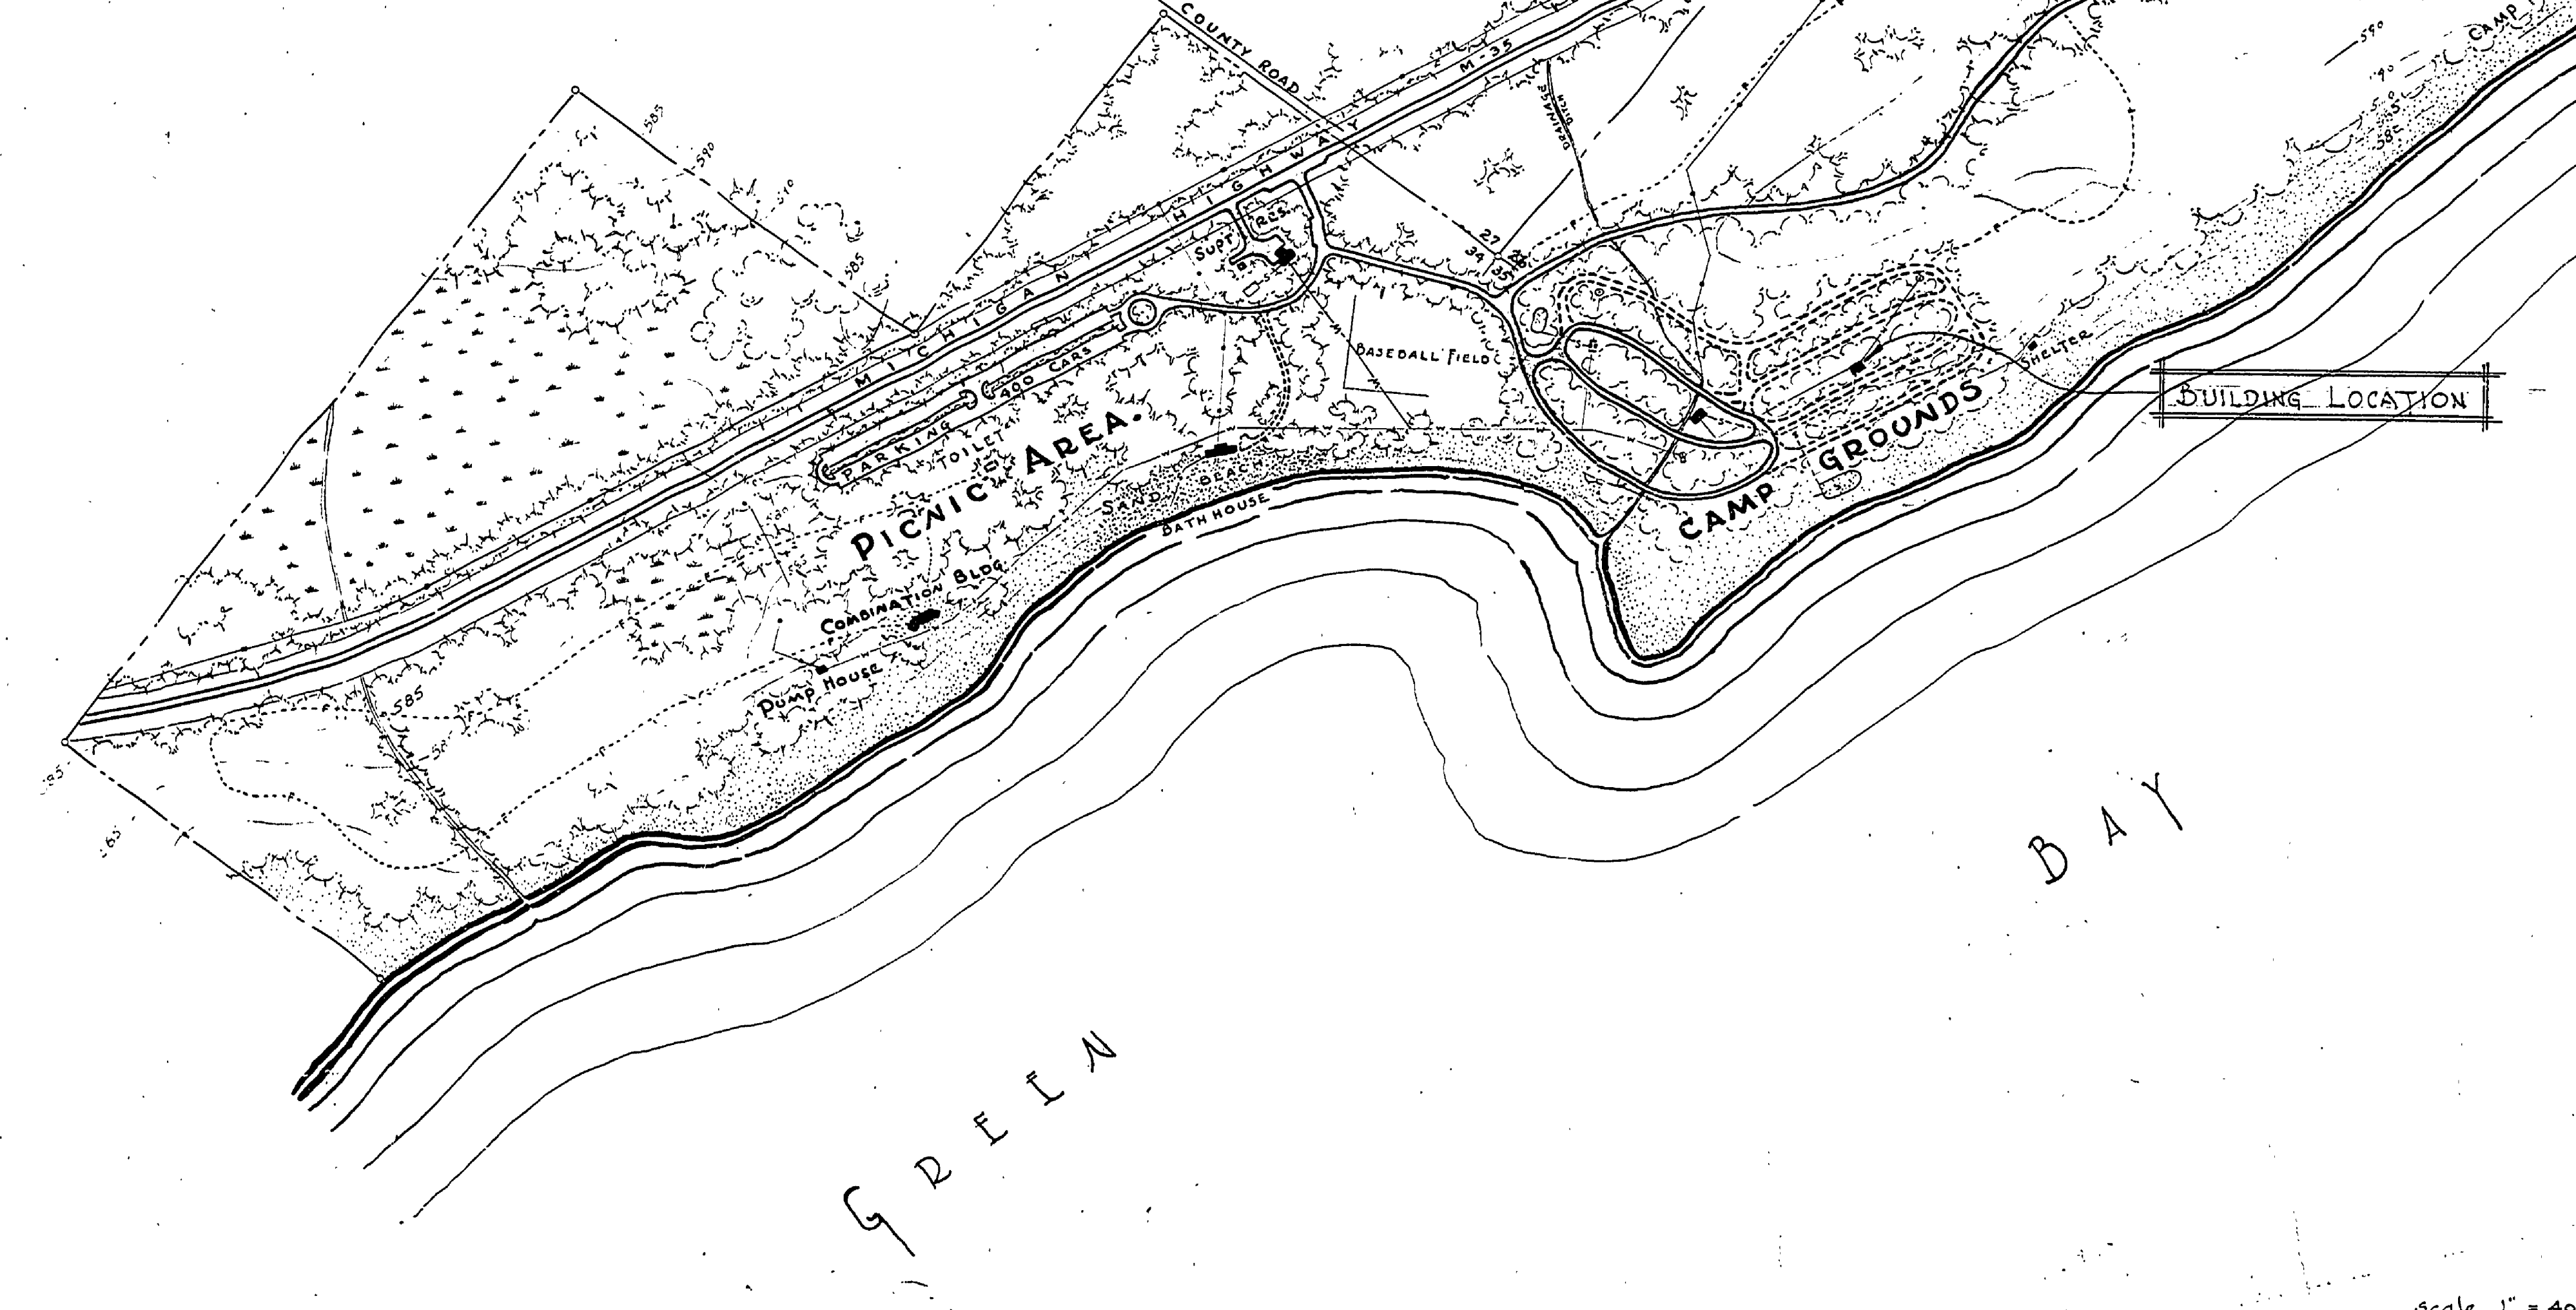

- LEGEND**
- Power Line
  - Water Line
  - Sewer Line
  - Disposal DED
  - Drinking Fountain
  - Well
  - Proposed Power Line
  - Water Line
  - Sewer Line
  - Buildings
  - Roads

Scale 1" = 400'

DRAWING SCHEDULE		
PLAN No.	SHEET No.	TITLE
A-107	1	Location Plan
A-107	2	Plans and Elevations and Schedule
A-107	3	Section and Details
A-107	4	Framing & Electrical Plans & Details

MICHIGAN DEPARTMENT OF CONSERVATION PARKS AND RECREATION DIVISION		LOCATION PLAN AND SCHEDULE J.W. WELLS STATE PARK TOILET, LAUNDRY AND SHOWER BUILDING	
SHEET NO.	1	PLAN NO.	A-107
OF	4		