


DESIGNED BY	DATE	REVIEWED	DATE	APPROVED	DATE	NO.	DATE	BY	REVISIONS	DATE	BY
L.M.C.	10-2-60	ARCHITECTURAL	12-9-60	<i>[Signature]</i>	1	1	12-9-60	W.A.C.	Replace Laundry Rm with 2 Showers	4	
J.I.R.	10-2-60	ENGINEERING	11-19-60	<i>[Signature]</i>	2	2	11-19-60	W.A.C.	Additional Site Information	5	
		LANDSCAPE	11-29-60	<i>[Signature]</i>	3	3	11-29-60			6	

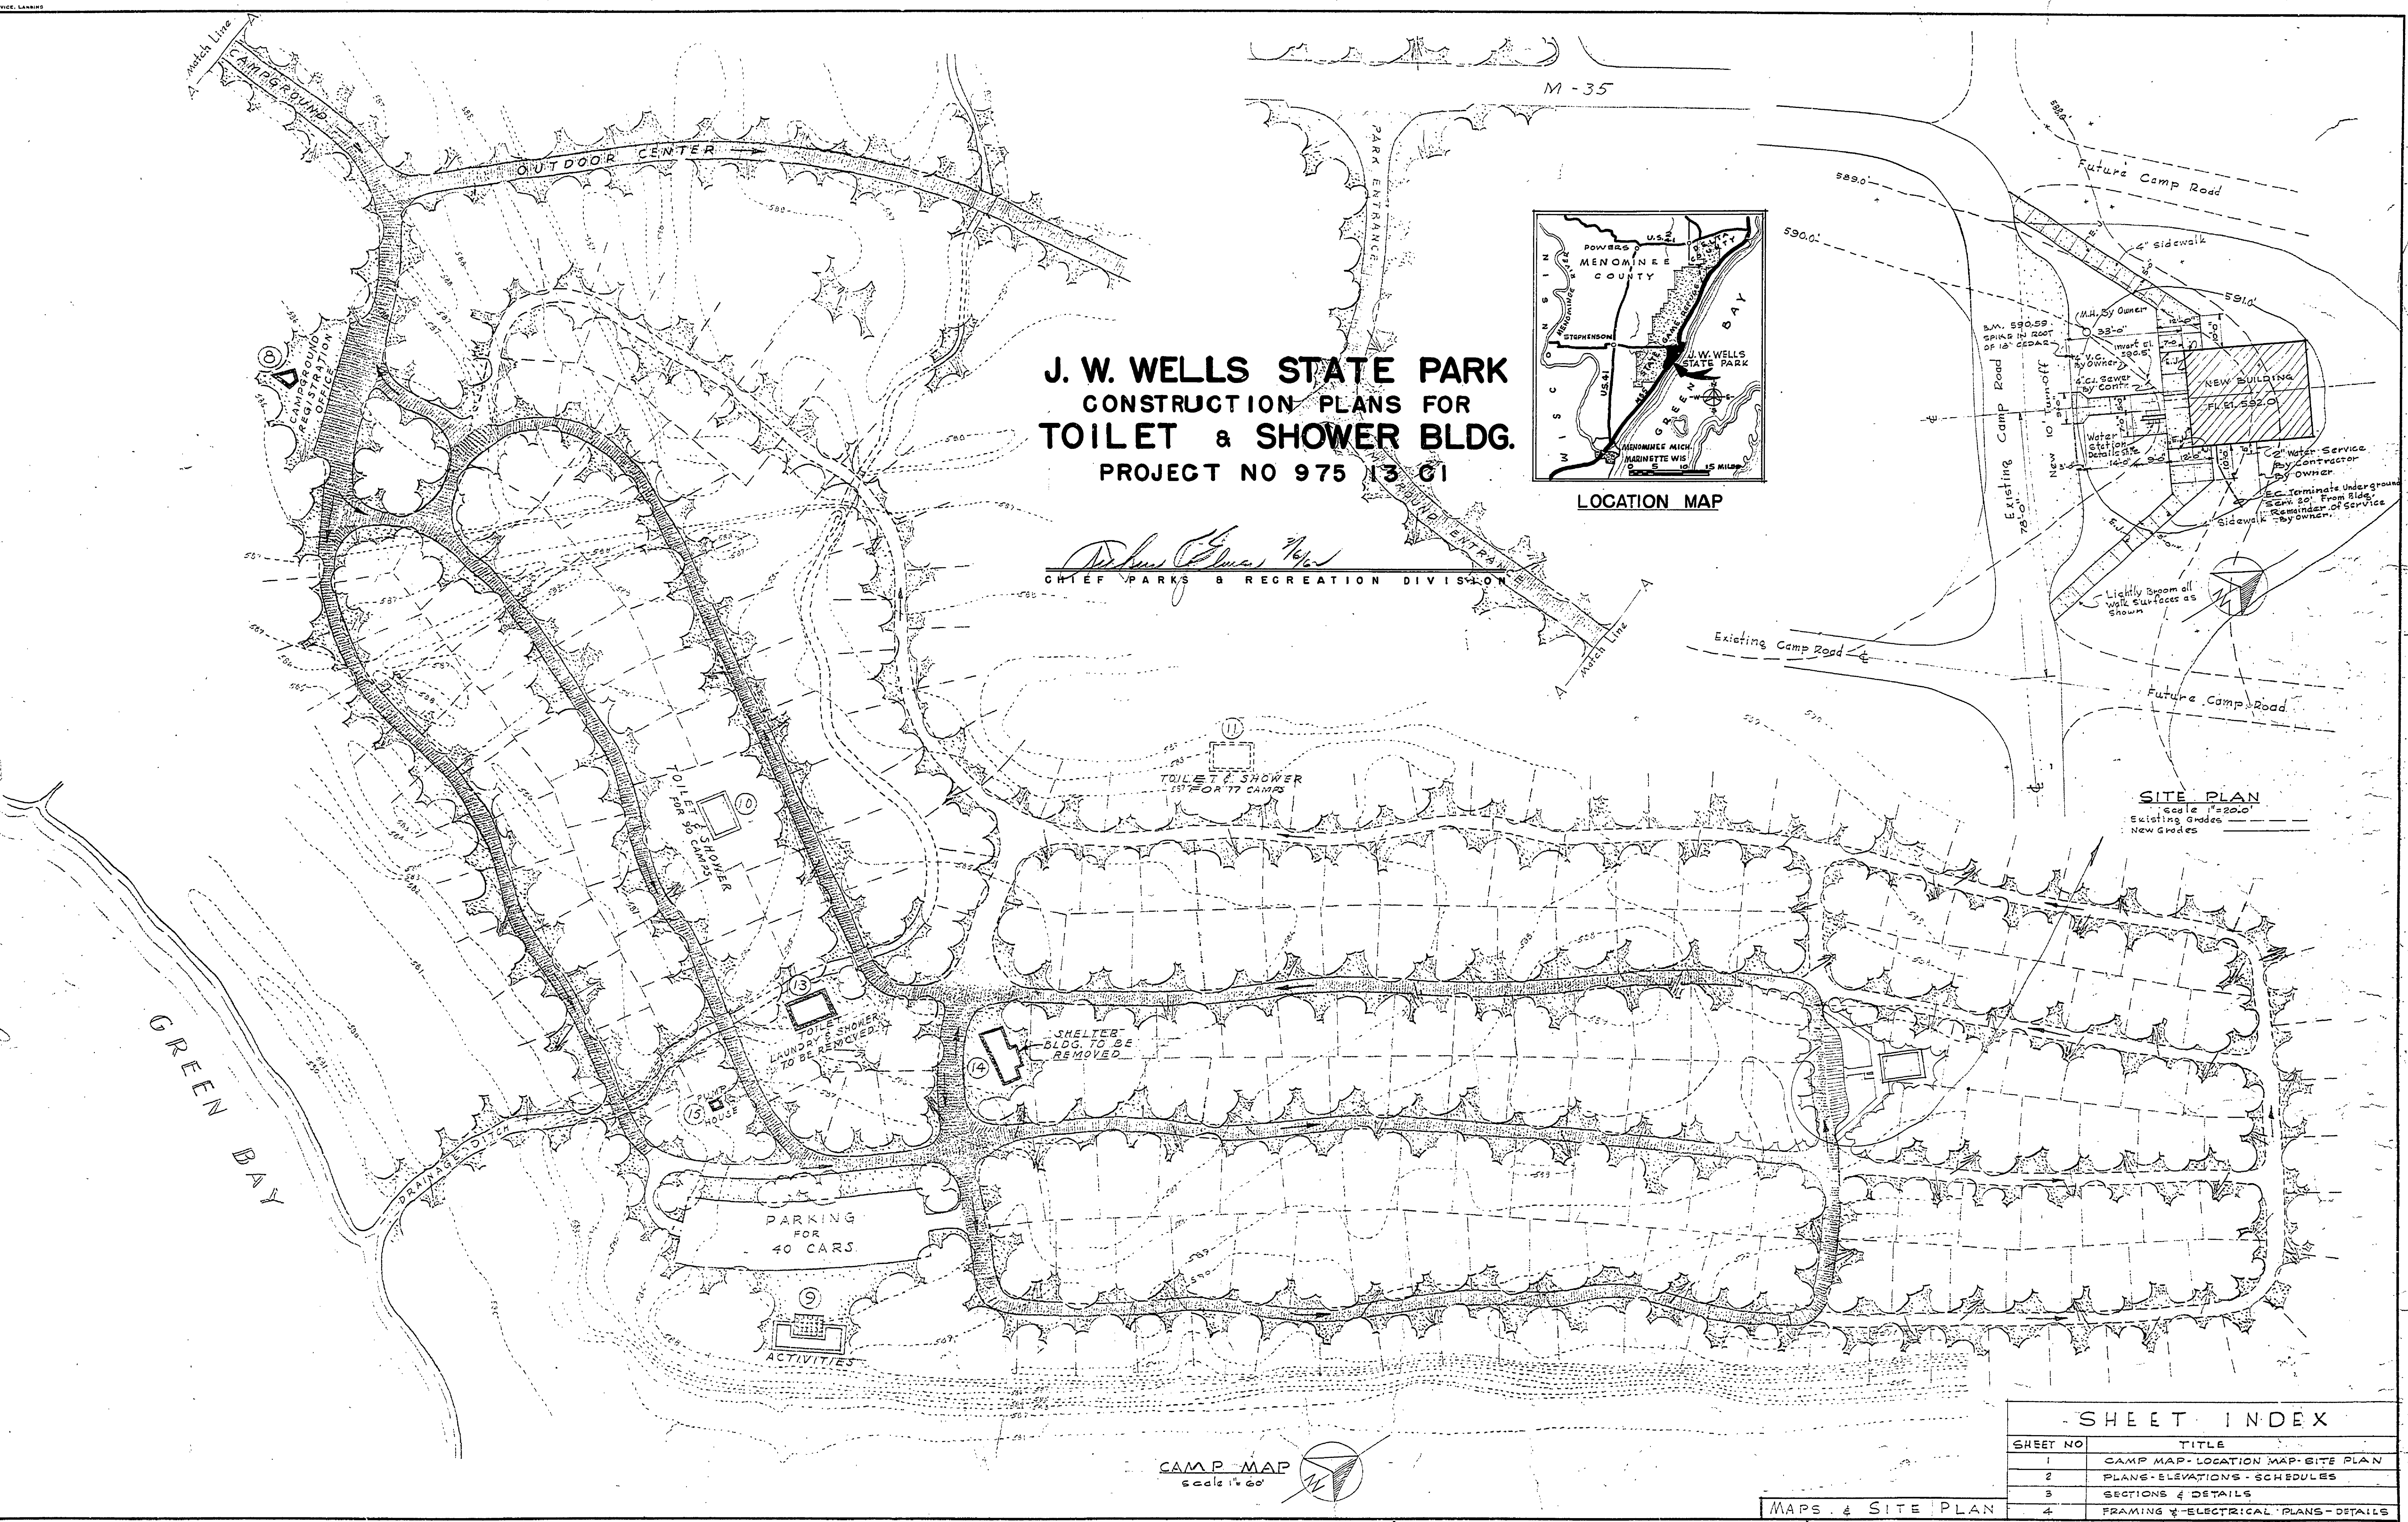

SHEET INDEX	
SHEET NO	TITLE
1	CAMP MAP-LOCATION MAP-SITE PLAN
2	PLANS-ELEVATIONS-SCHEDULES
3	SECTIONS & DETAILS
4	FRAMING & ELECTRICAL PLANS-DETAILS

MICHIGAN
DEPARTMENT OF CONSERVATION
PARKS AND RECREATION DIVISION

**J. W. WELLS STATE PARK
NEW TOILET BUILDING**

SHEET NO. 1 OF 5 PLAN NO. A-107