



DESIGNED BY	DATE	REVIEWED	DATE	APPROVED	DATE	NO.	DATE	BY	REVISIONS	DATE	BY
DRAWN BY: W.A.C.	3-12-62	ARCHITECTURAL	3-14-62			1			4		
CHECKED BY: L.N.C.	3-14-62	ENGINEERING	3-14-62			2			5		
		LANDSCAPE	3-14-62			3			6		

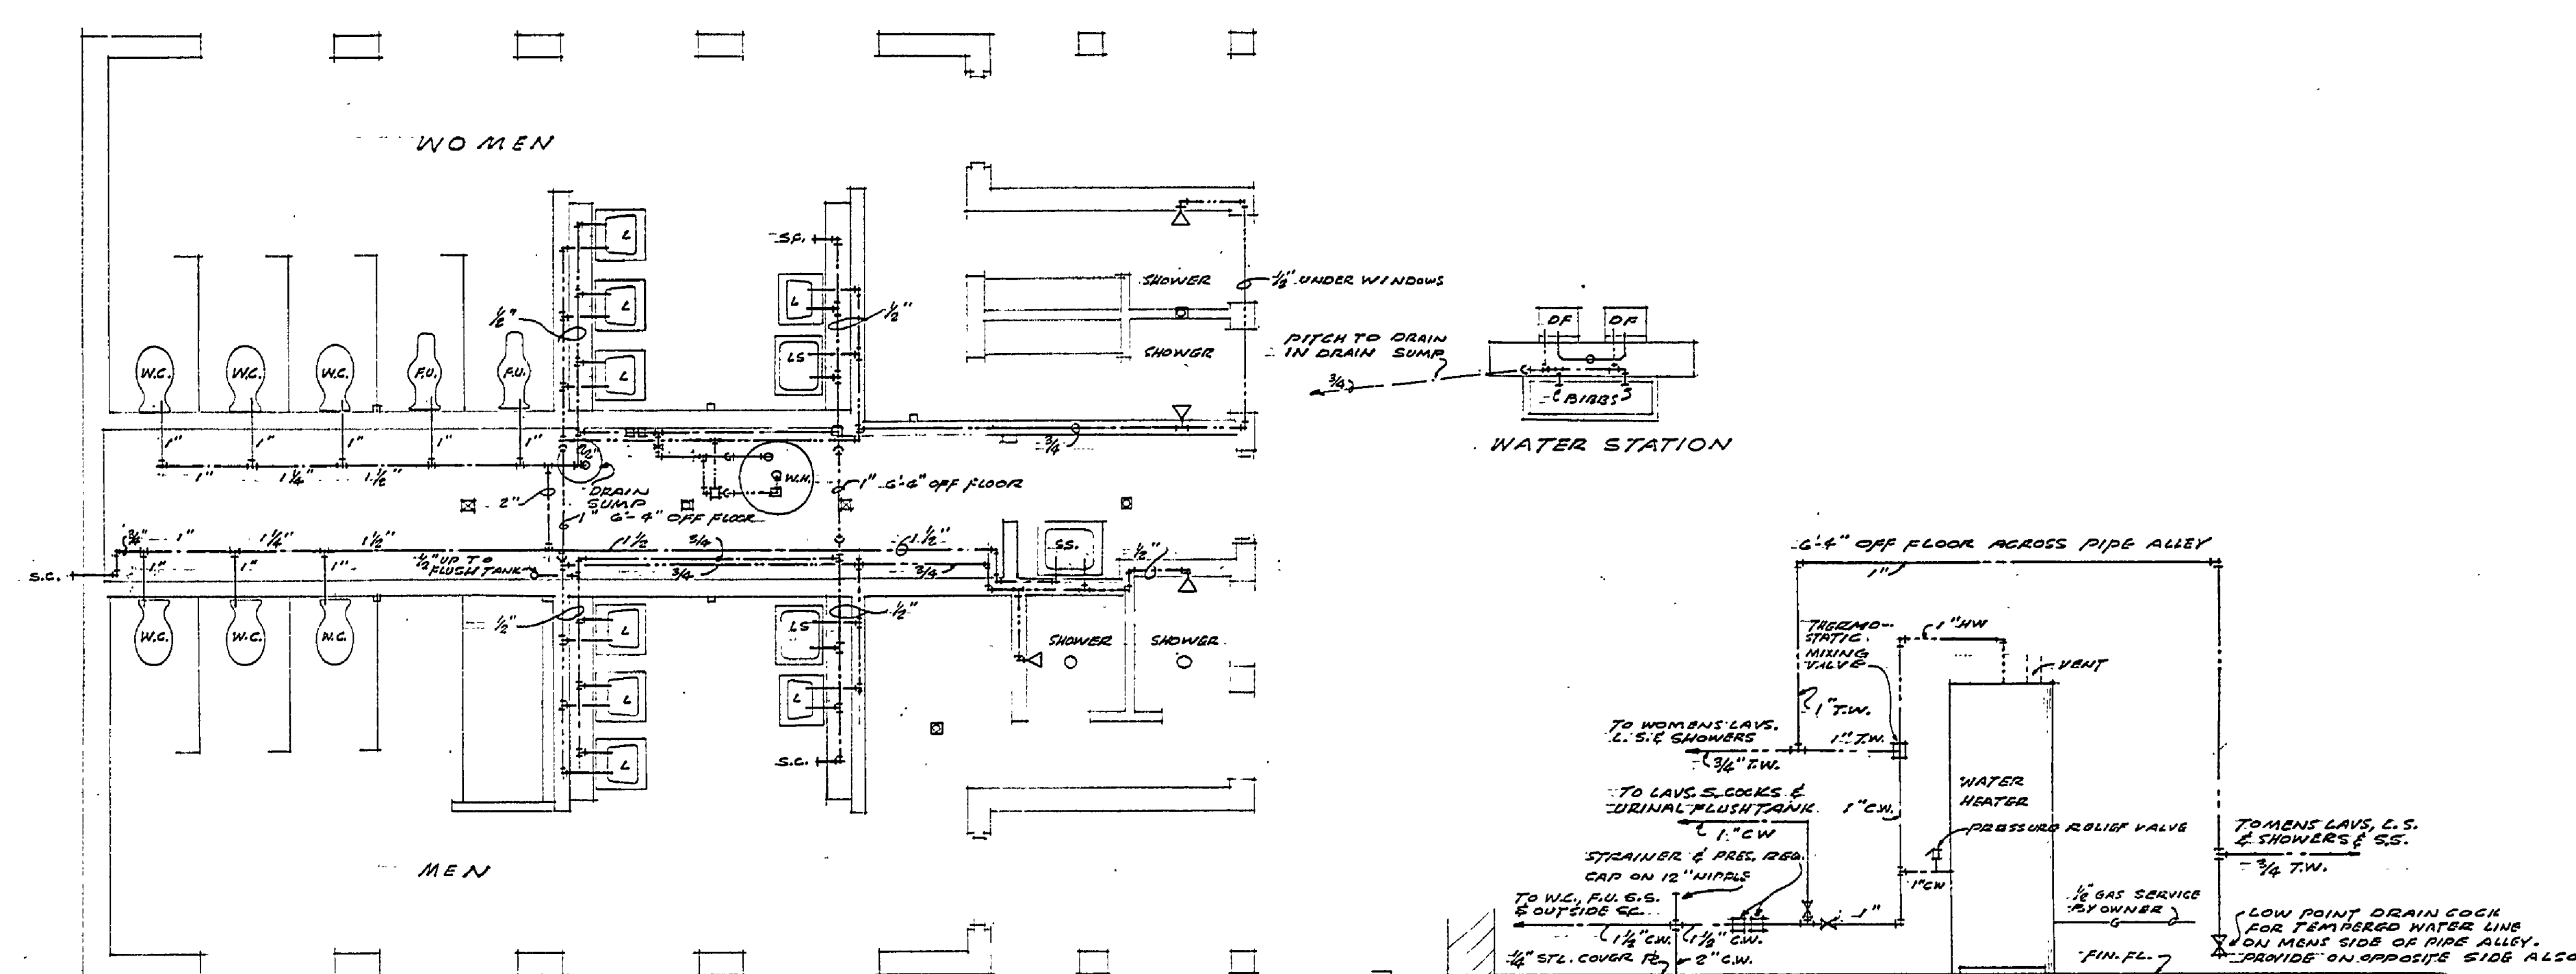

PLUMBING SUPPLY FLOOR PLAN
SCALE 1/4" = 1'-0"

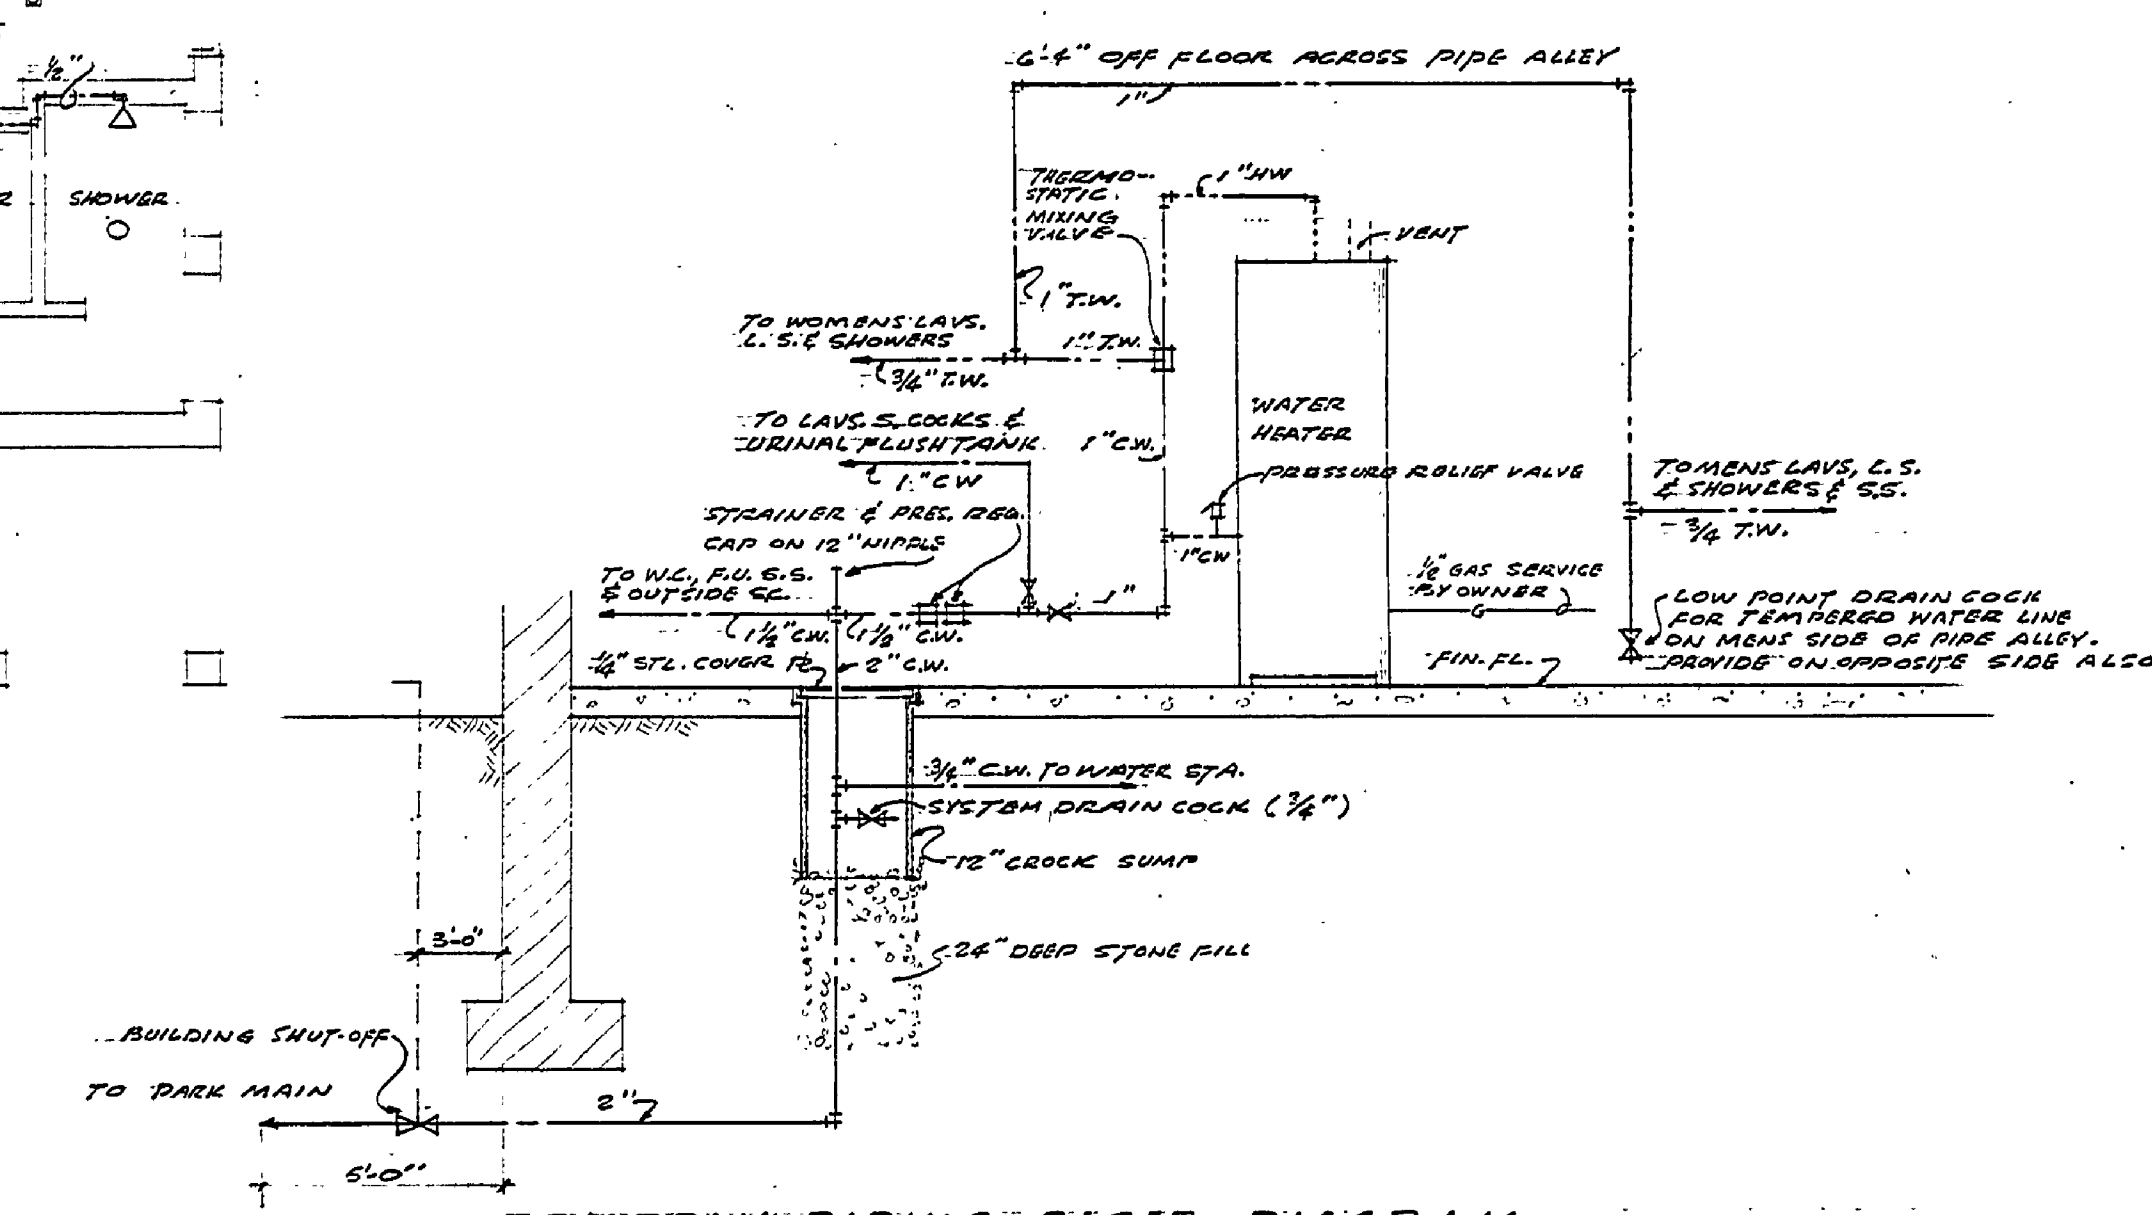

SUPPLY PIPING RISER DIAGRAM
NO SCALE

NOTE: ALL SUPPLY LINES SHALL DRAIN TO SUMP OR PIPE ALLEY

— COLD WATER
- - - TEMPERED WATER
... HOT WATER

MICHIGAN DEPARTMENT OF CONSERVATION PARKS AND RECREATION DIVISION

PLUMBING SUPPLY PLAN & RISER DIAG.
J. W. WELLS STATE PARK
NEW TOILET BUILDING
SHEET NO. 5 OF 5
PLAN NO. A-107