




DATE	REVIEWED	DATE	APPROVED	DATE	NO.	DATE	BY
4-11-82	W. J. K.	4-12-82	[Signature]	4/16/82	1	4/16/82	W. J. K.
4-11-82	W. J. K.	4-12-82	[Signature]	4/17-82	2	4/17-82	W. J. K.
4-11-82	W. J. K.	4-12-82	[Signature]	4/17-82	3	4/17-82	W. J. K.
4-11-82	W. J. K.	4-12-82	[Signature]	4/17-82	4	4/17-82	W. J. K.
4-11-82	W. J. K.	4-12-82	[Signature]	4/17-82	5	4/17-82	W. J. K.
4-11-82	W. J. K.	4-12-82	[Signature]	4/17-82	6	4/17-82	W. J. K.
4-11-82	W. J. K.	4-12-82	[Signature]	4/17-82	7	4/17-82	W. J. K.
4-11-82	W. J. K.	4-12-82	[Signature]	4/17-82	8	4/17-82	W. J. K.
4-11-82	W. J. K.	4-12-82	[Signature]	4/17-82	9	4/17-82	W. J. K.

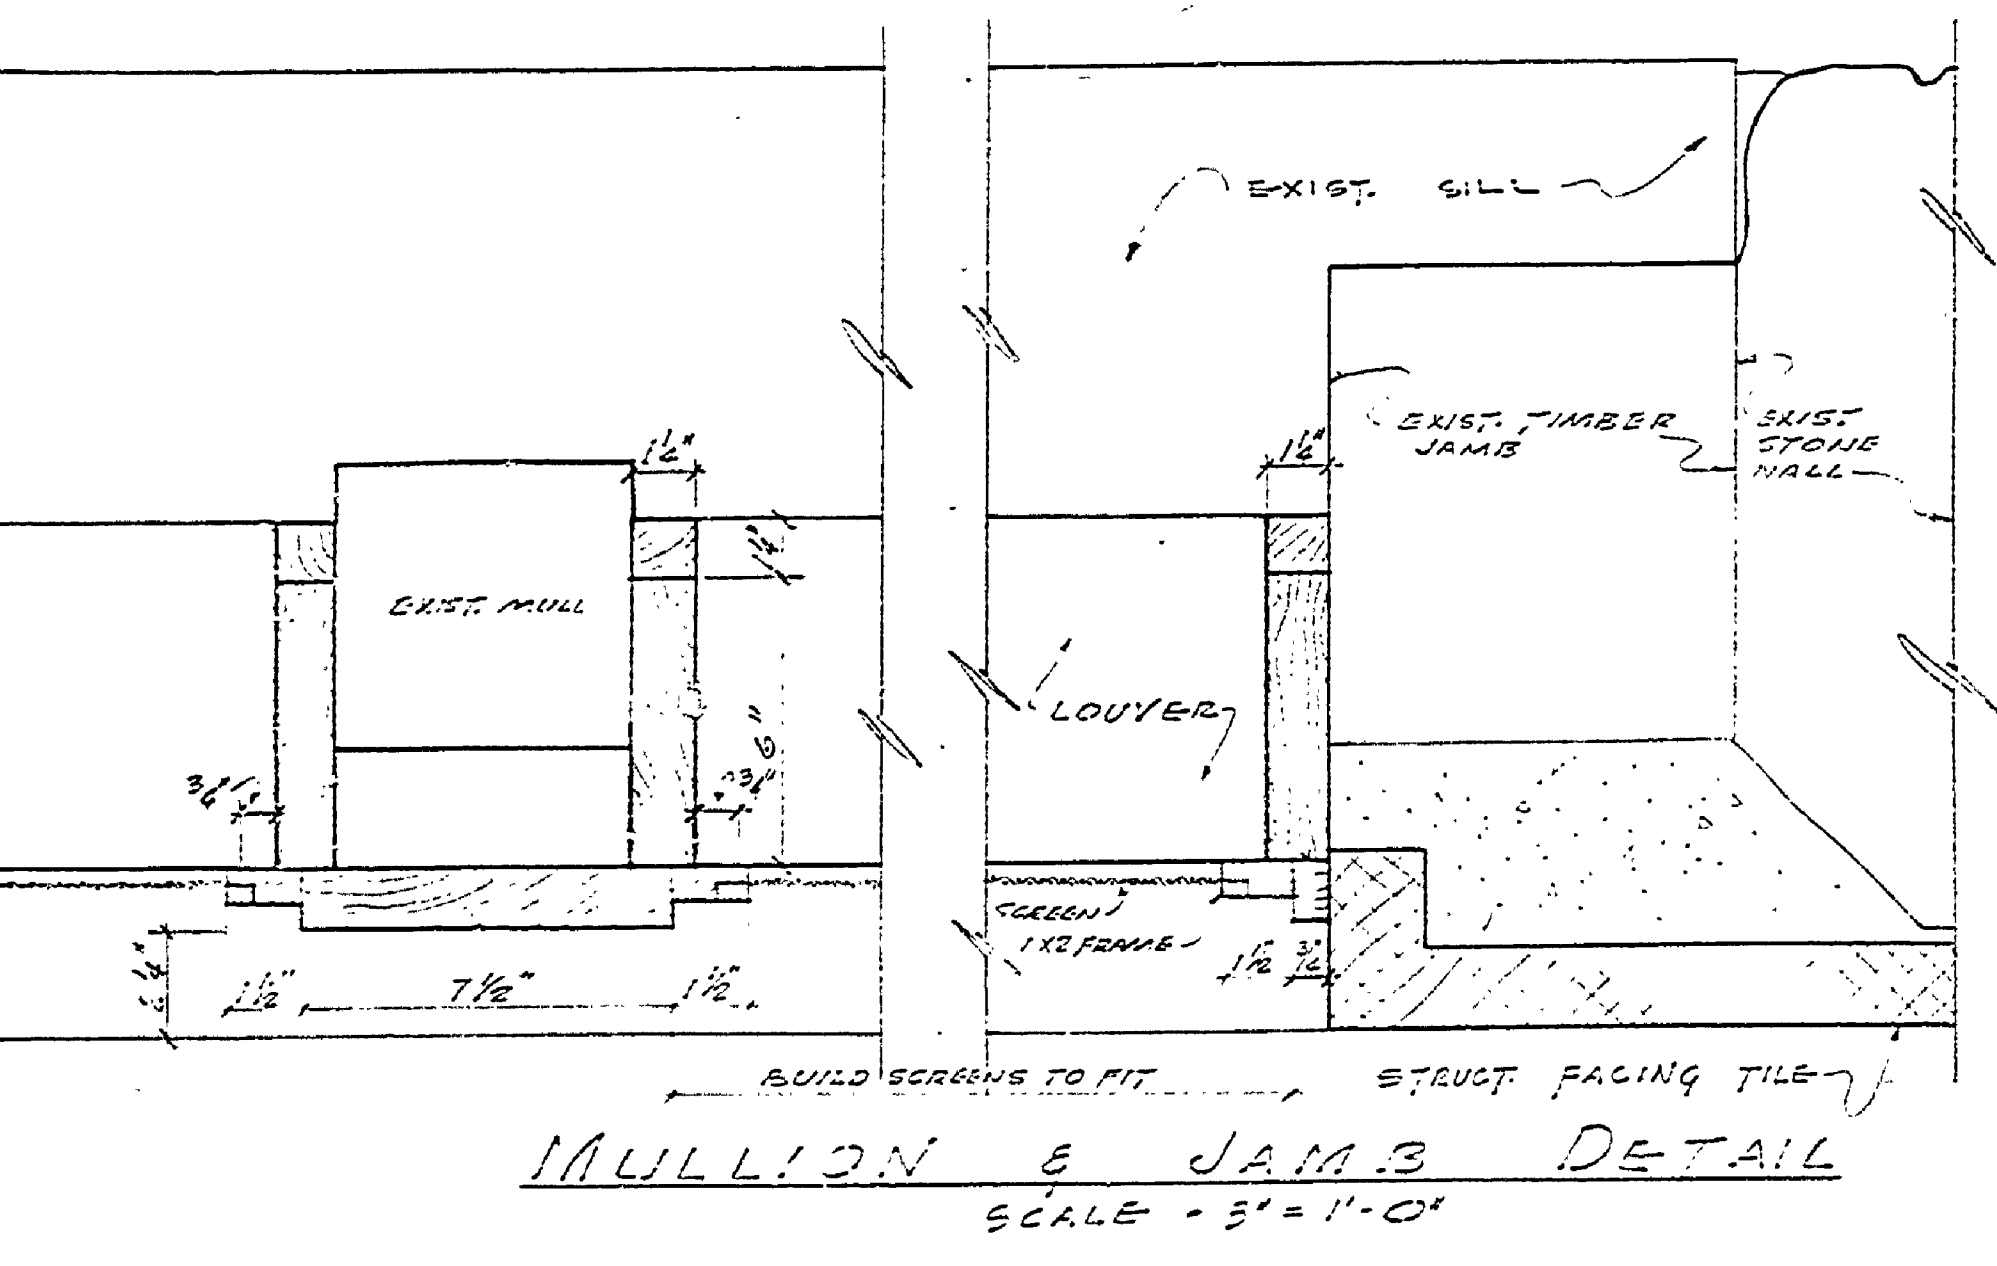


MULLION & JAMB DETAIL
SCALE - 3" = 1'-0"

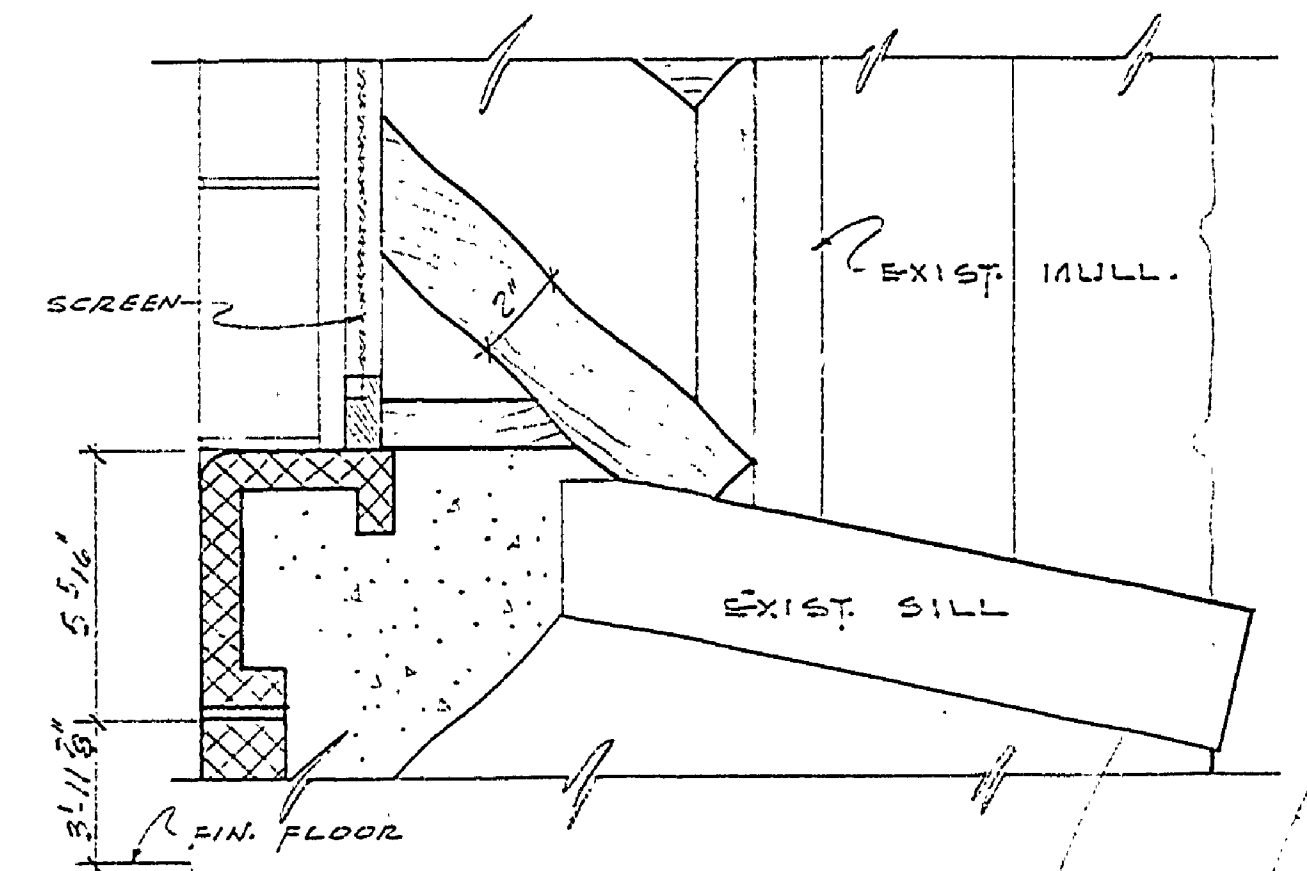


SILL DETAIL
SCALE - 3" = 1'-0"

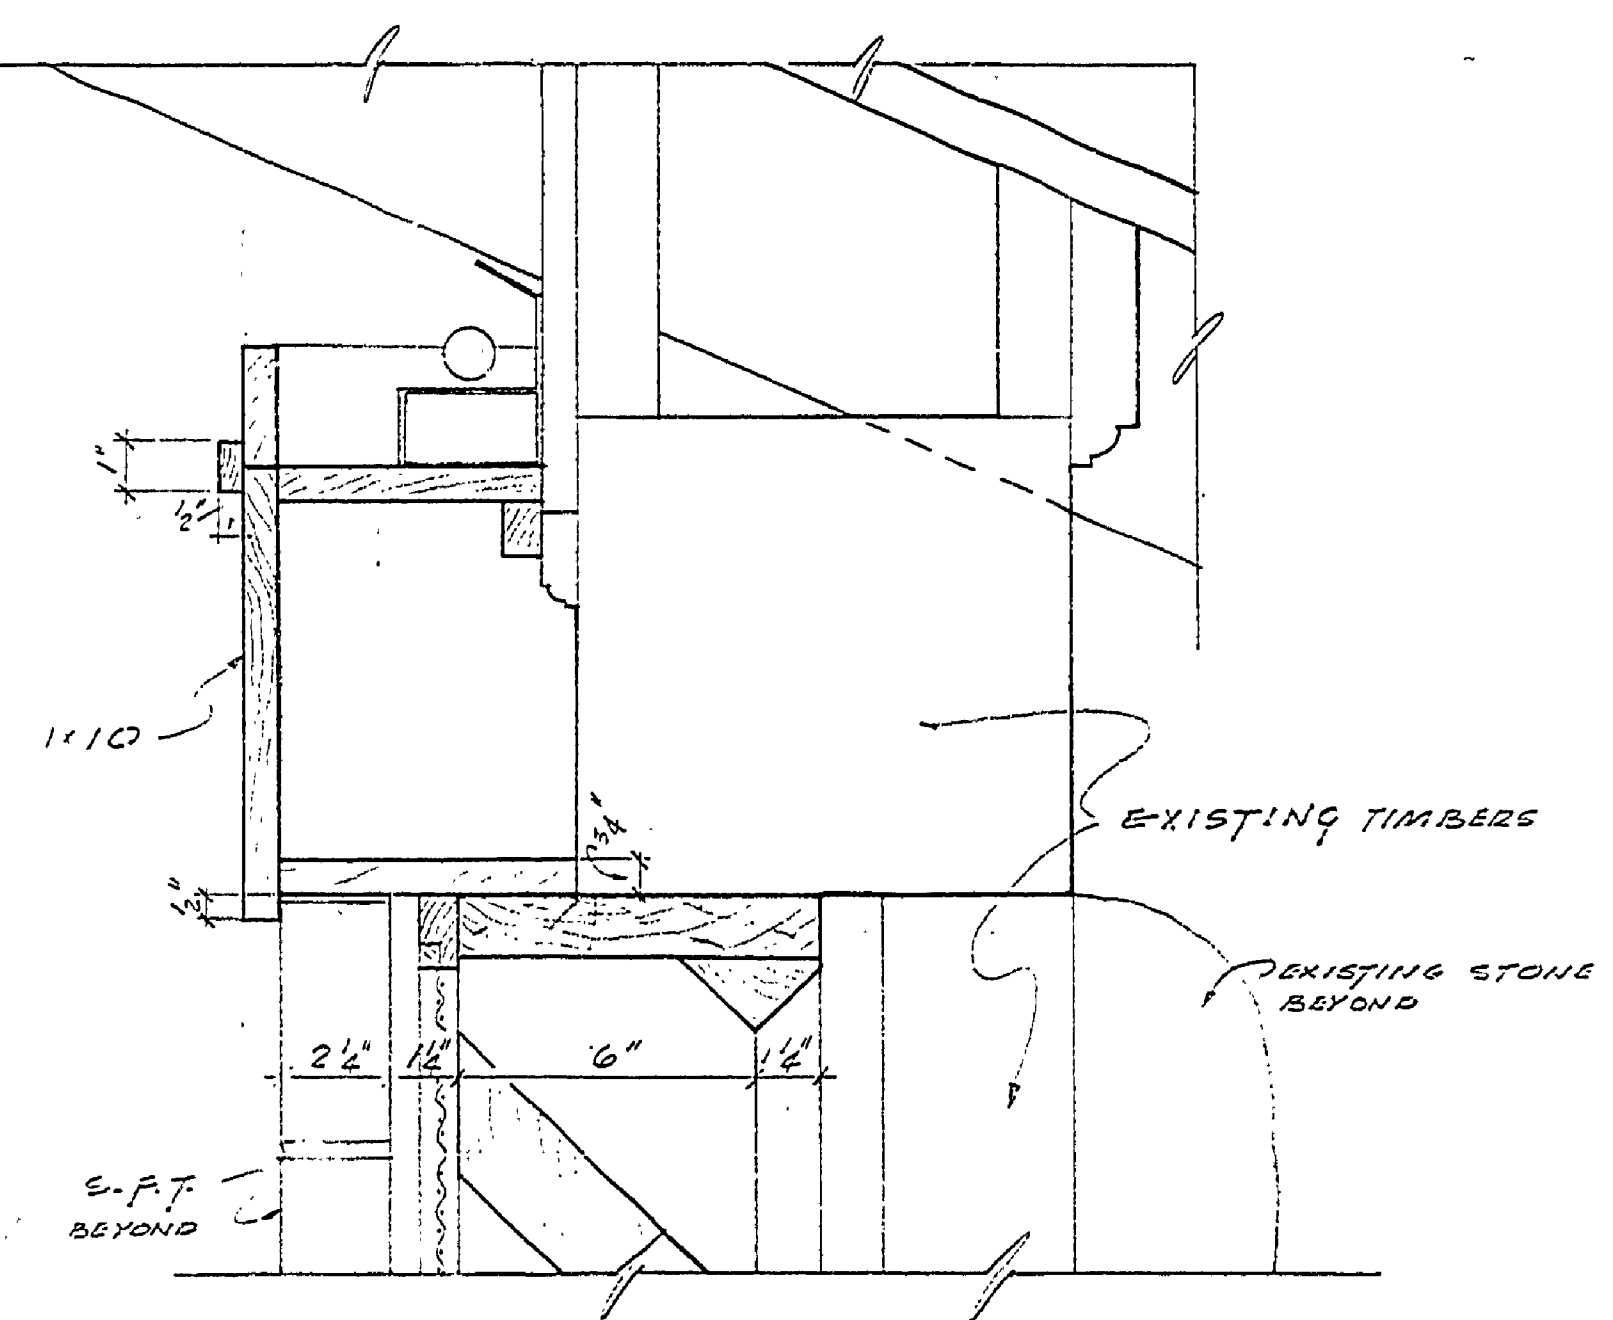


HEAD DETAIL
SCALE - 3" = 1'-0"

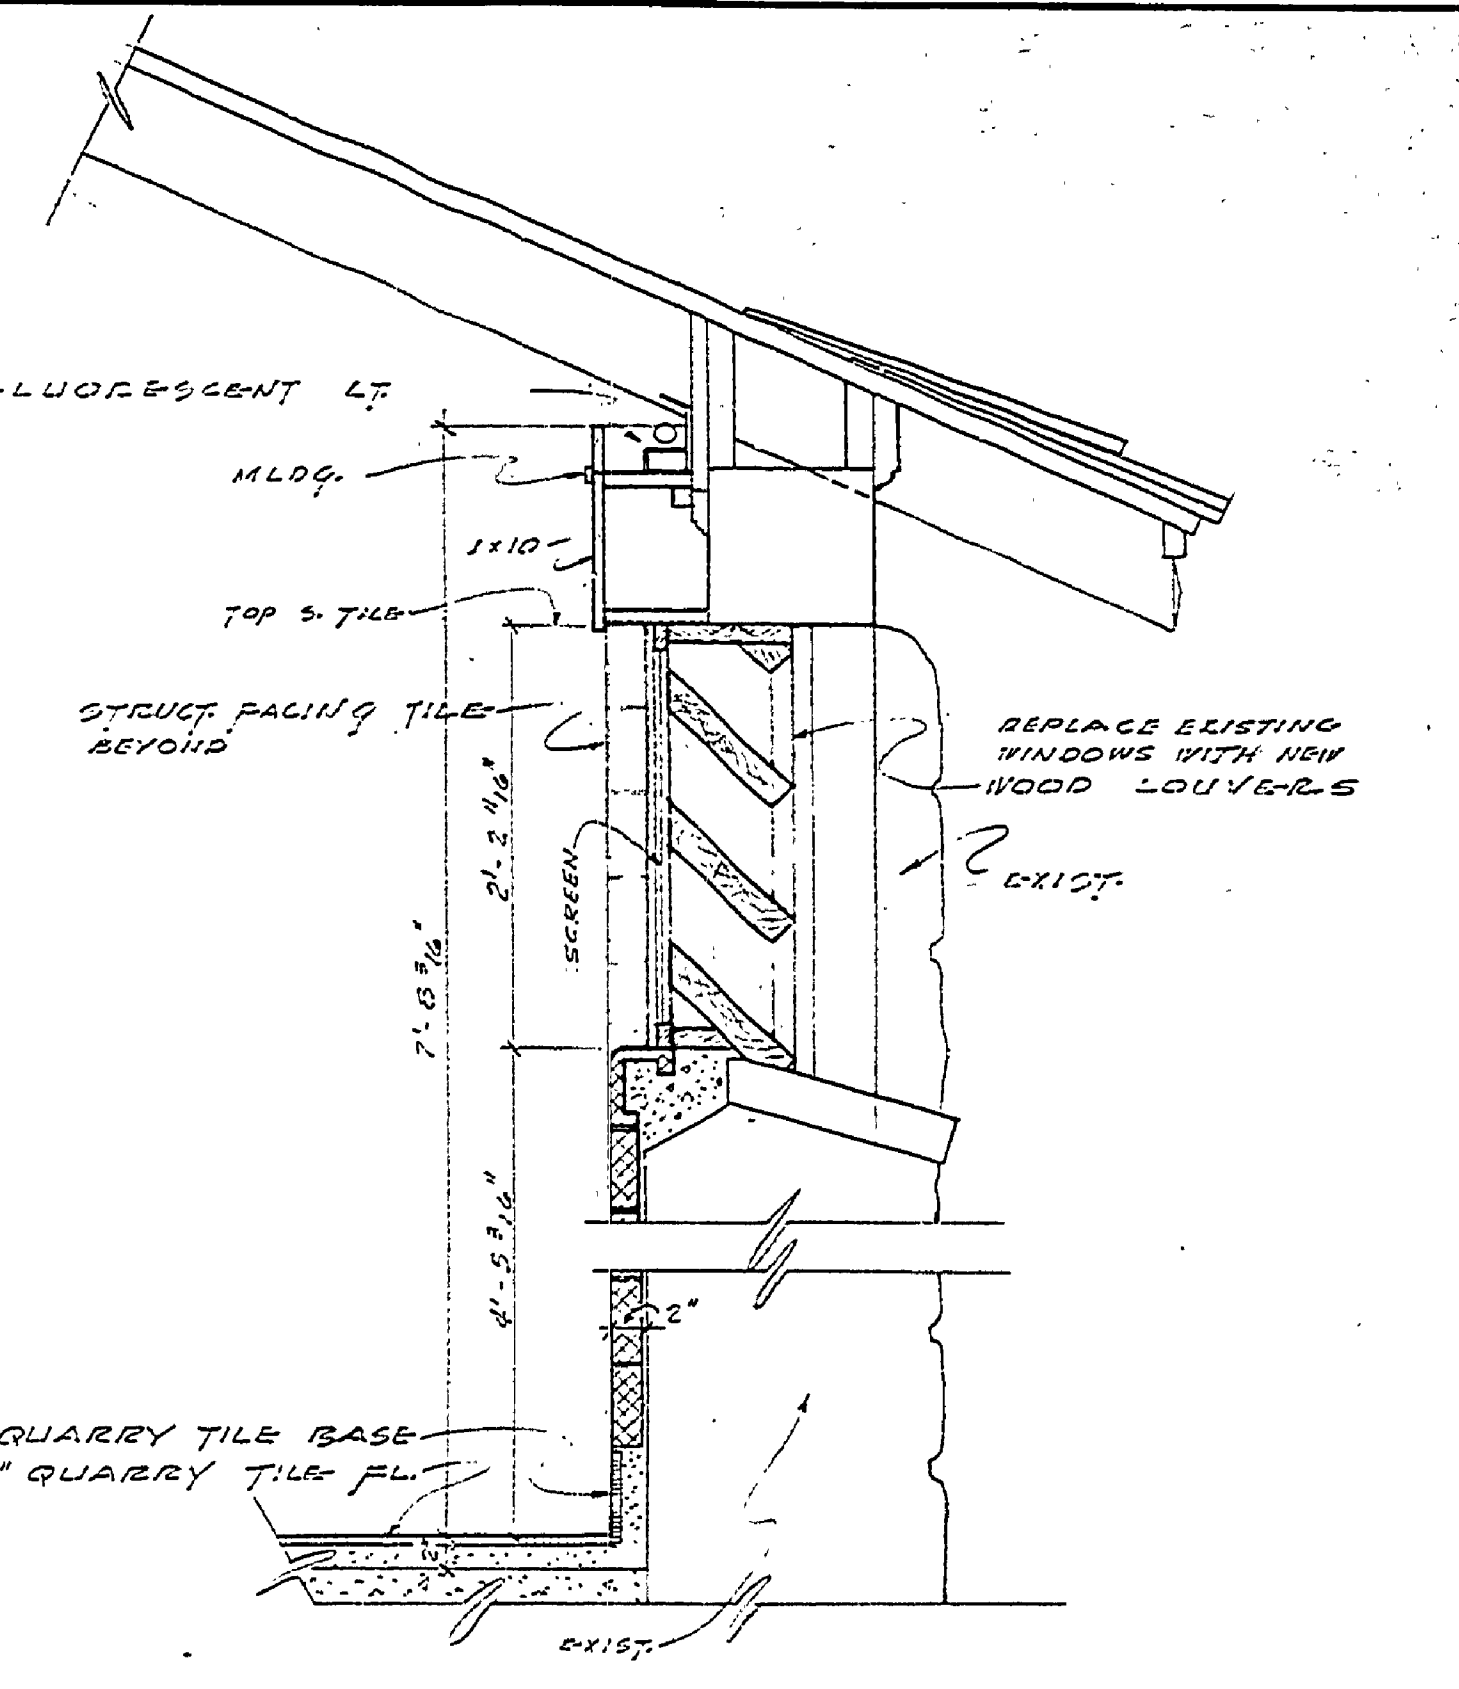

WALL SECTION - NORTH & SOUTH SIDES
SCALE - 1" = 1'-0"

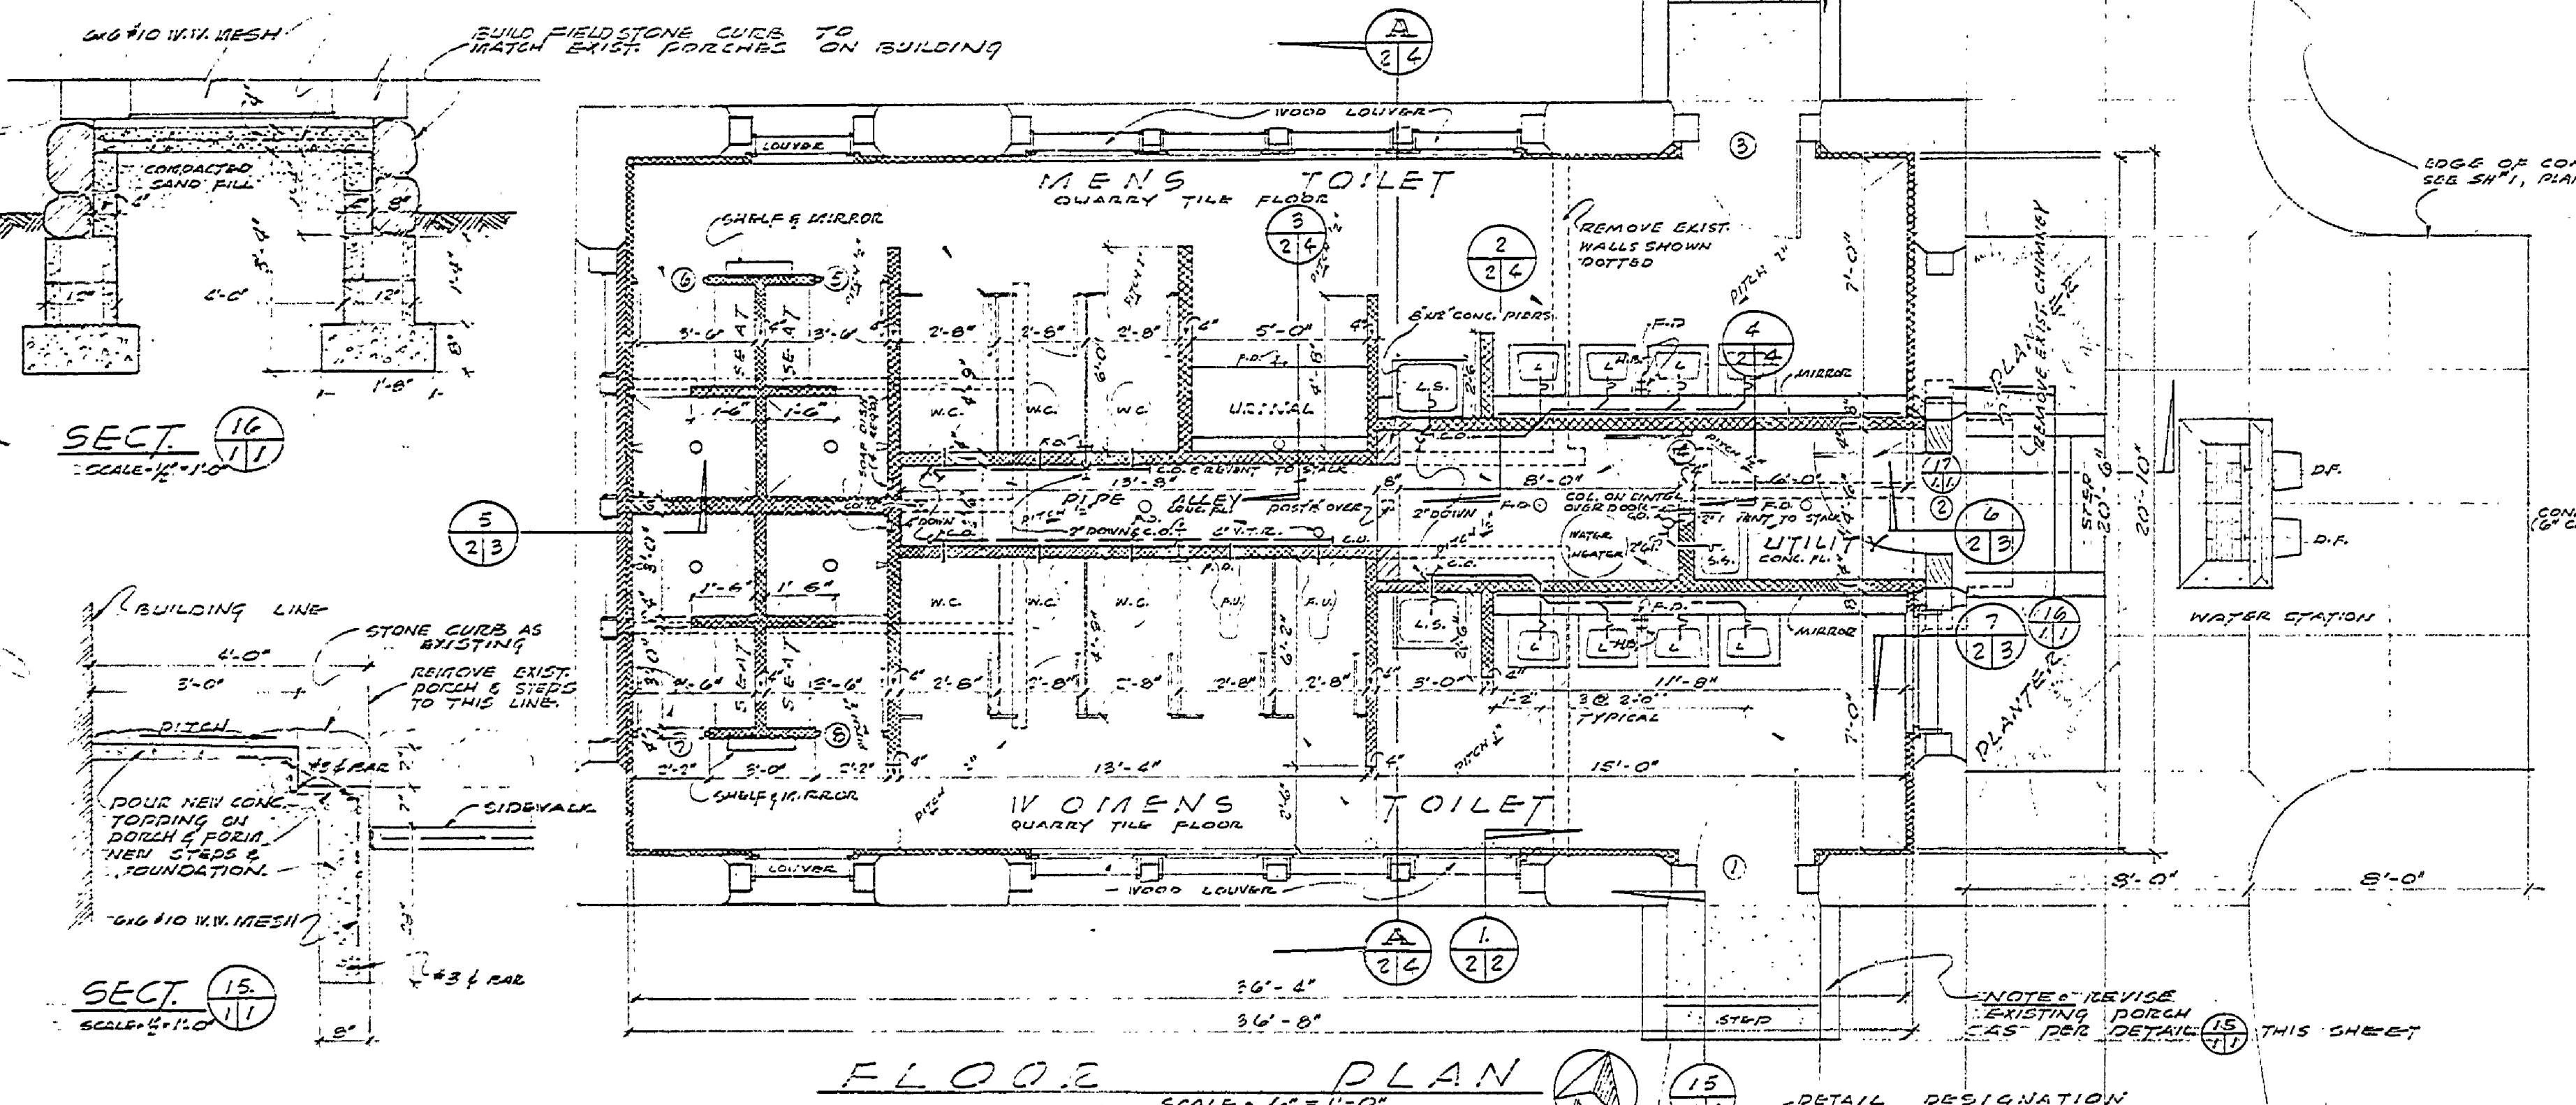

FLOOR PLAN
SCALE - 1/4" = 1'-0"

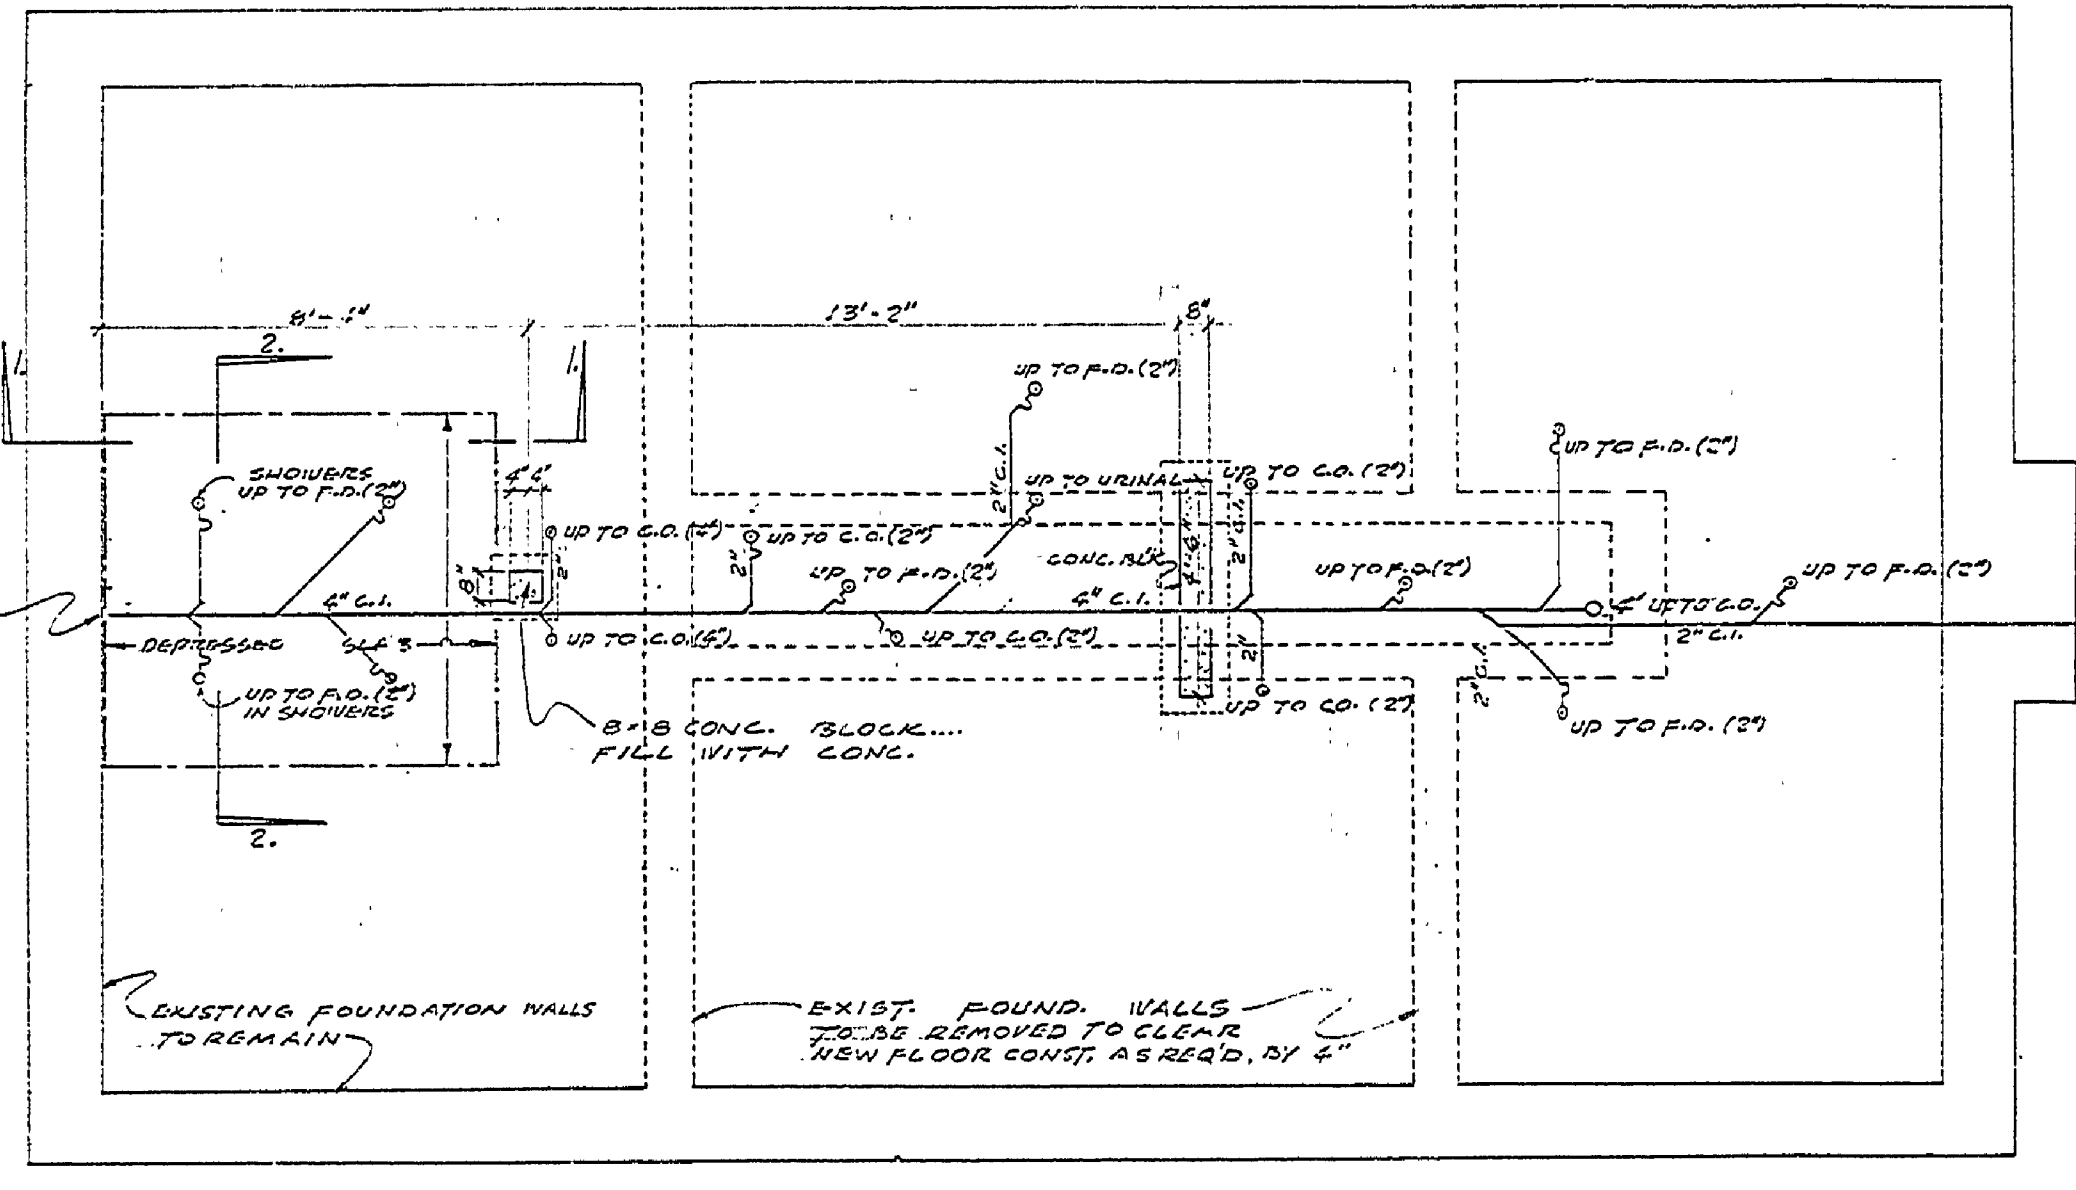


FOUNDATION & U.G. PLUMBING PLAN


ROOMS	FLOOR/FACE	WALLS	DOOR	WOOD	FINISH	OTHER	REMARKS
MENS TOILET Rm.	QUARRY TILE	QUARRY TILE	STAINLESS STEEL	WOOD	PAINTED	WOOD	
WOMENS TOILET Rm.	QUARRY TILE	QUARRY TILE	STAINLESS STEEL	WOOD	PAINTED	WOOD	
MENS SHOWER	QUARRY TILE	QUARRY TILE	STAINLESS STEEL	WOOD	PAINTED	WOOD	
WOMENS SHOWER	QUARRY TILE	QUARRY TILE	STAINLESS STEEL	WOOD	PAINTED	WOOD	
UTILITY ROOM	QUARRY TILE	QUARRY TILE	STAINLESS STEEL	WOOD	PAINTED	WOOD	FIELD PLYWOOD
STOR. & PIPE ALLEY	QUARRY TILE	QUARRY TILE	STAINLESS STEEL	WOOD	PAINTED	WOOD	

DOOR SCHEDULE		REMARKS	
NO.	TYPE	SIZE	REMARKS
1	A	1'0" x 6'8"	EXIST.
2	A	1'0" x 6'8"	REUSE SALVAGED DOOR
3	A	1'0" x 6'8"	EXIST.
4	B	1'0" x 6'8"	REUSE SALVAGED DOOR
5	B	1'0" x 6'8"	TO MATCH TOILET ROOM
6	B	1'0" x 6'8"	
7	B	1'0" x 6'8"	
8	B	1'0" x 6'8"	

SYMBOL
SHEET WHERE DETAIL IS TAKEN
SHEET WHERE DETAIL APPEARS

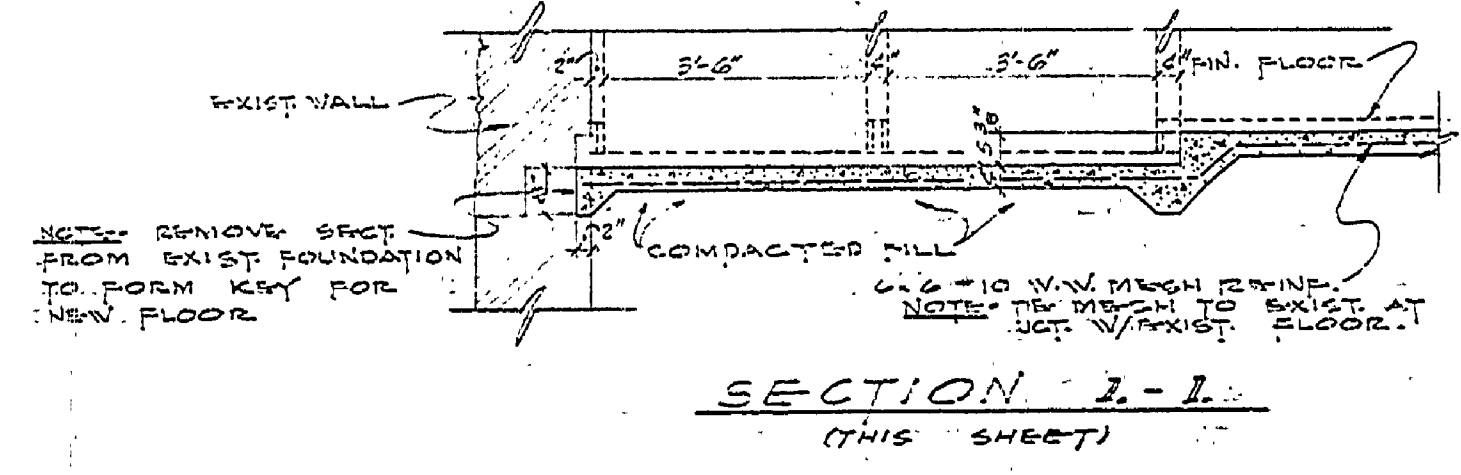

SECTION 1-1
(THIS SHEET)

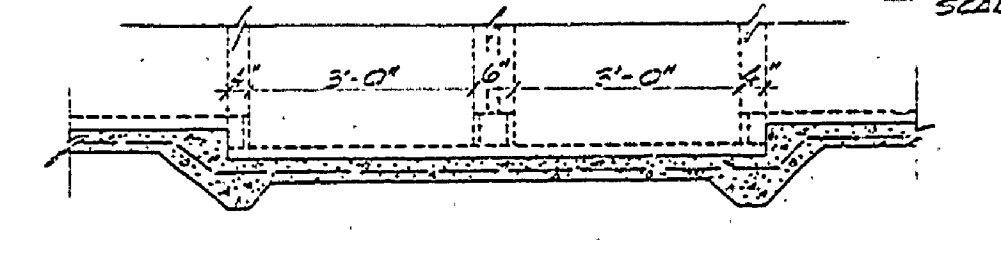

SECTION 2-2
(THIS SHEET)

NOTE: SEE SH. 1, PLAN #106 FOR SITE WORK RELATIVE TO THIS BUILDING

MICHIGAN DEPARTMENT OF CONSERVATION PARKS AND RECREATION DIVISION

FLOOR & FOUND. PLANS - SECTIONS - DETAILS
HARRISVILLE STATE PARK
REMODELING
TOILET & SHOWER BUILDING #1-A
SHEET NO. 1 OF 3
PLAN NO. A-1040