




DRAWN BY		REVIEWED BY SECTIONS		APPROVED BY		REVISIONS		DATE BY	
D.W.F.		ARCHITECTURAL	DATE	ASSISTANT CHIEF IN CHARGE		1		4	
CHECKED BY		ENGINEERING	DATE	OF DESIGN		2		5	
DATE		LANDSCAPE	DATE			3		6	

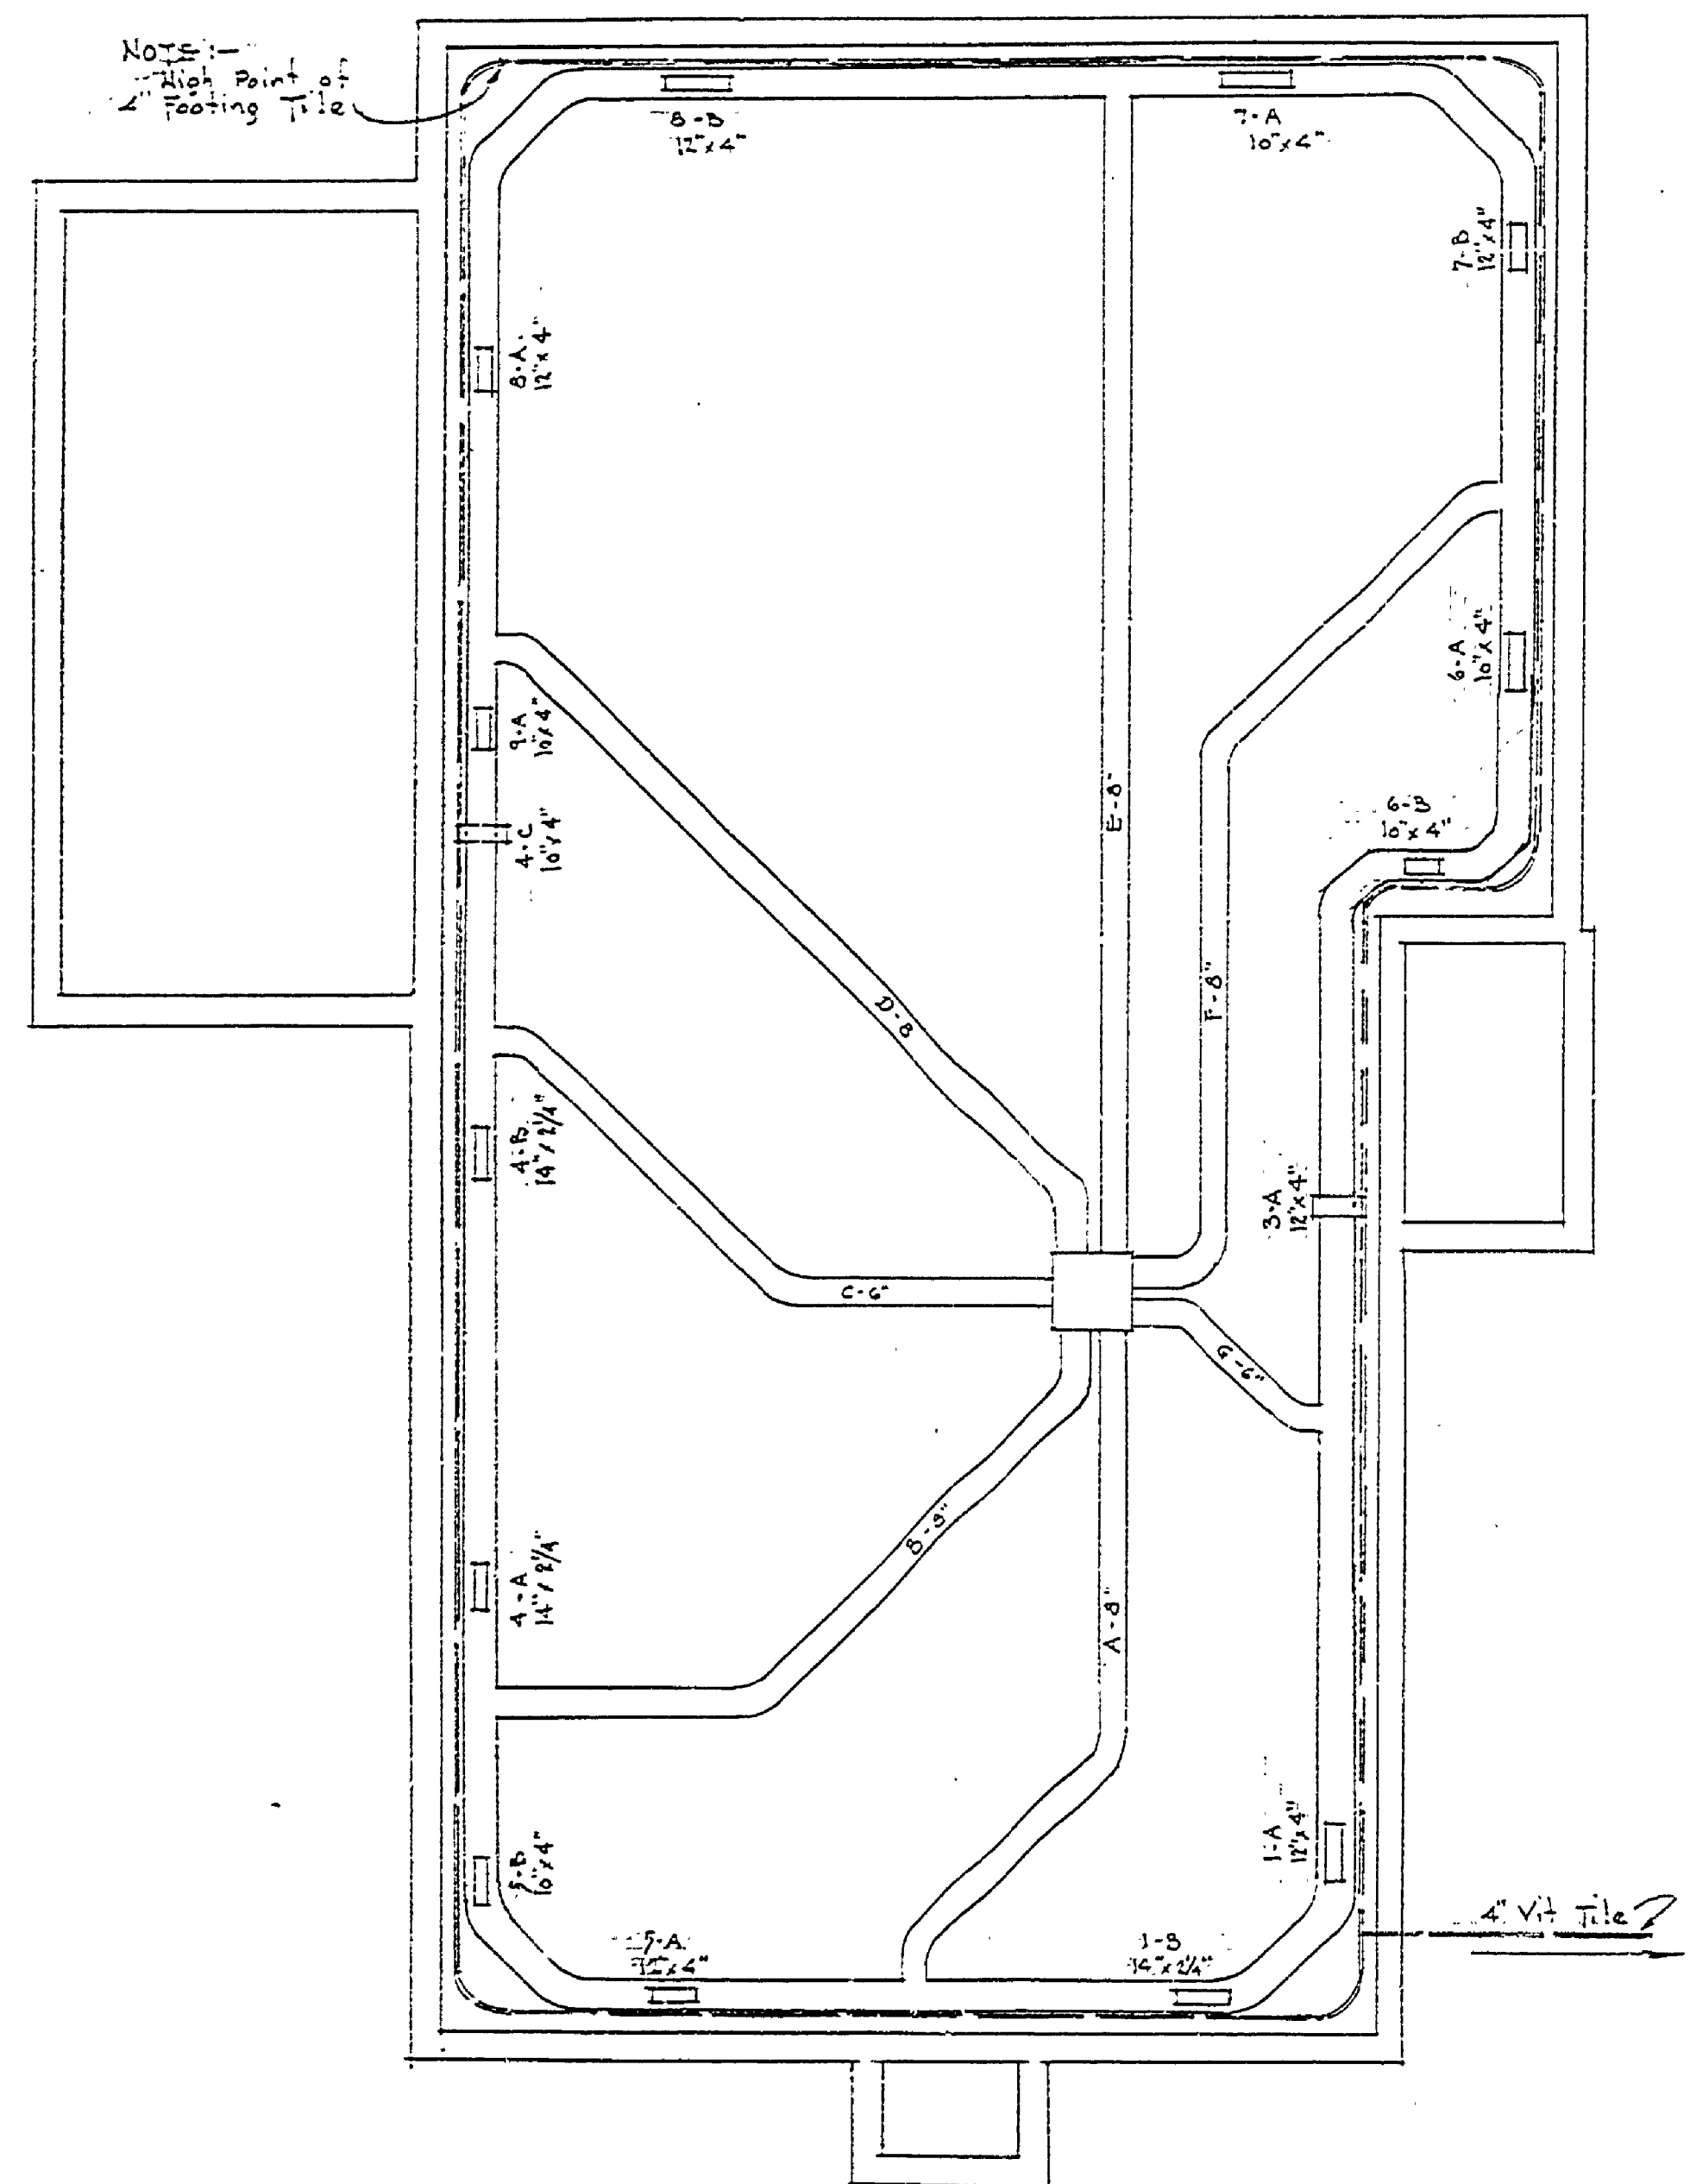


HEATING PLAN  
Scale 1/8" = 1'-0"

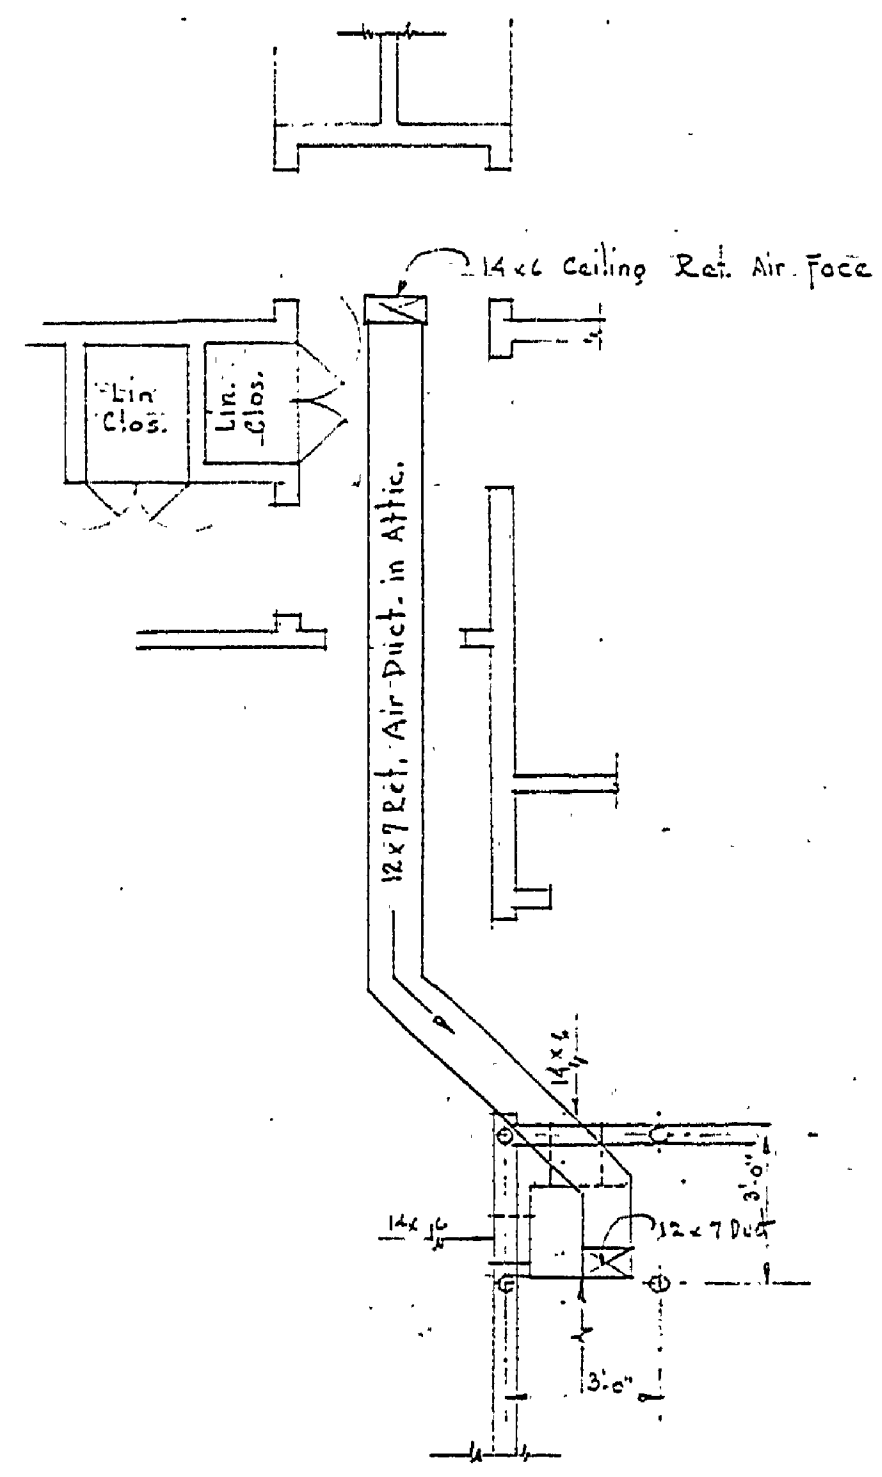


PLAN LAYOUT OF RETURN DUCT  
Scale 1/4" = 1'-0"

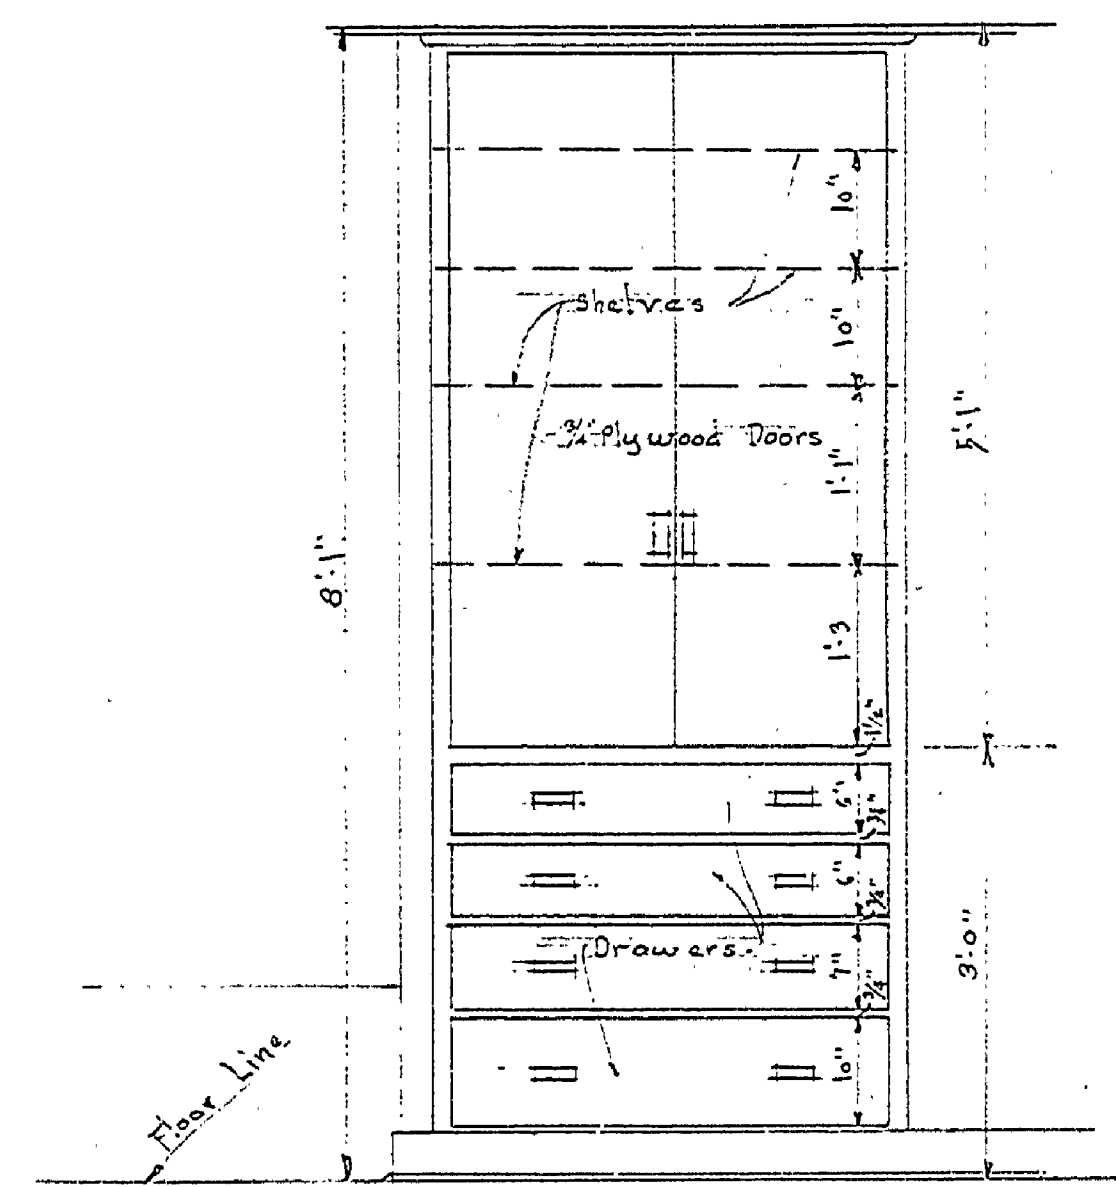

ELEVATION

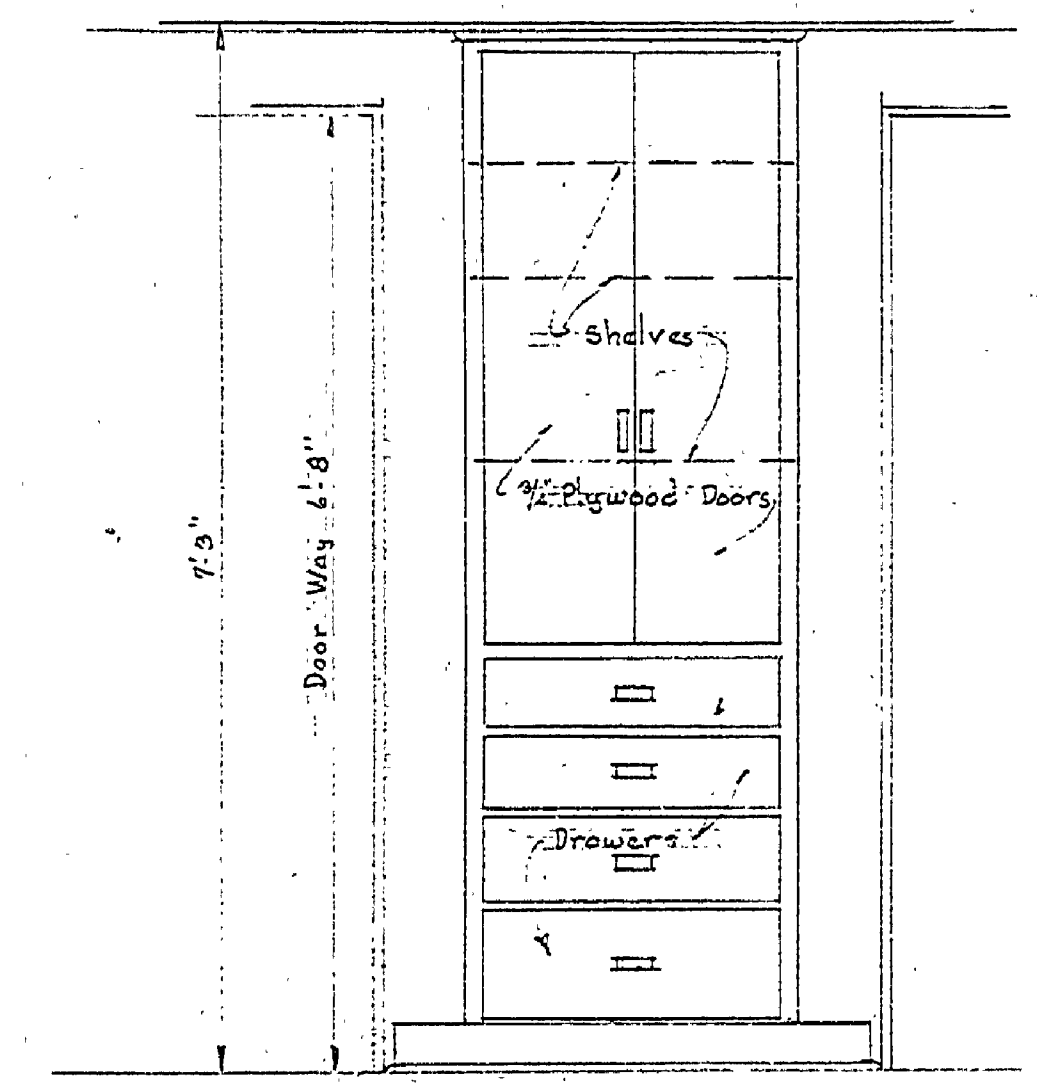

ELEVATION

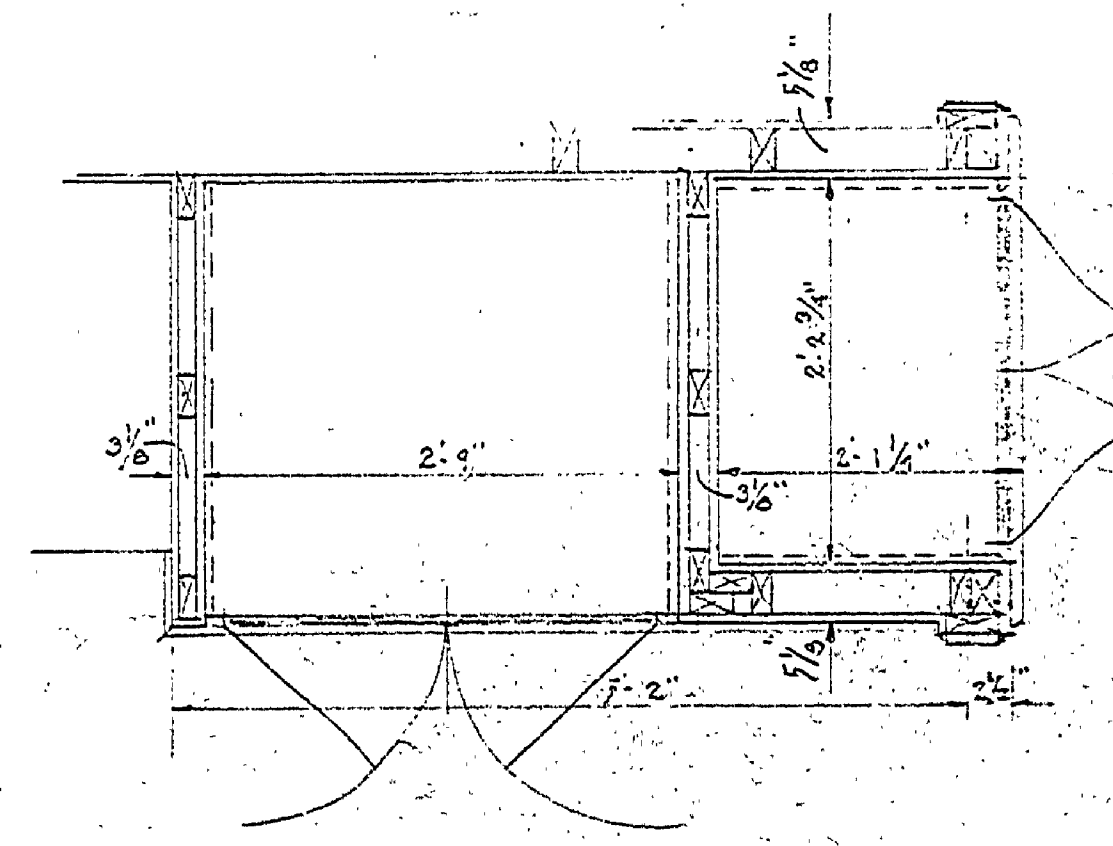

LINEN CLOSET DETAIL  
Scale 3/4" = 1'-0"

MICHIGAN  
DEPARTMENT OF CONSERVATION  
PARKS AND RECREATION DIVISION

HARRISVILLE STATE PARK  
MANAGER'S RESIDENCE

SHEET  
NO. 7  
OF

PLAN NO.  
A-105