
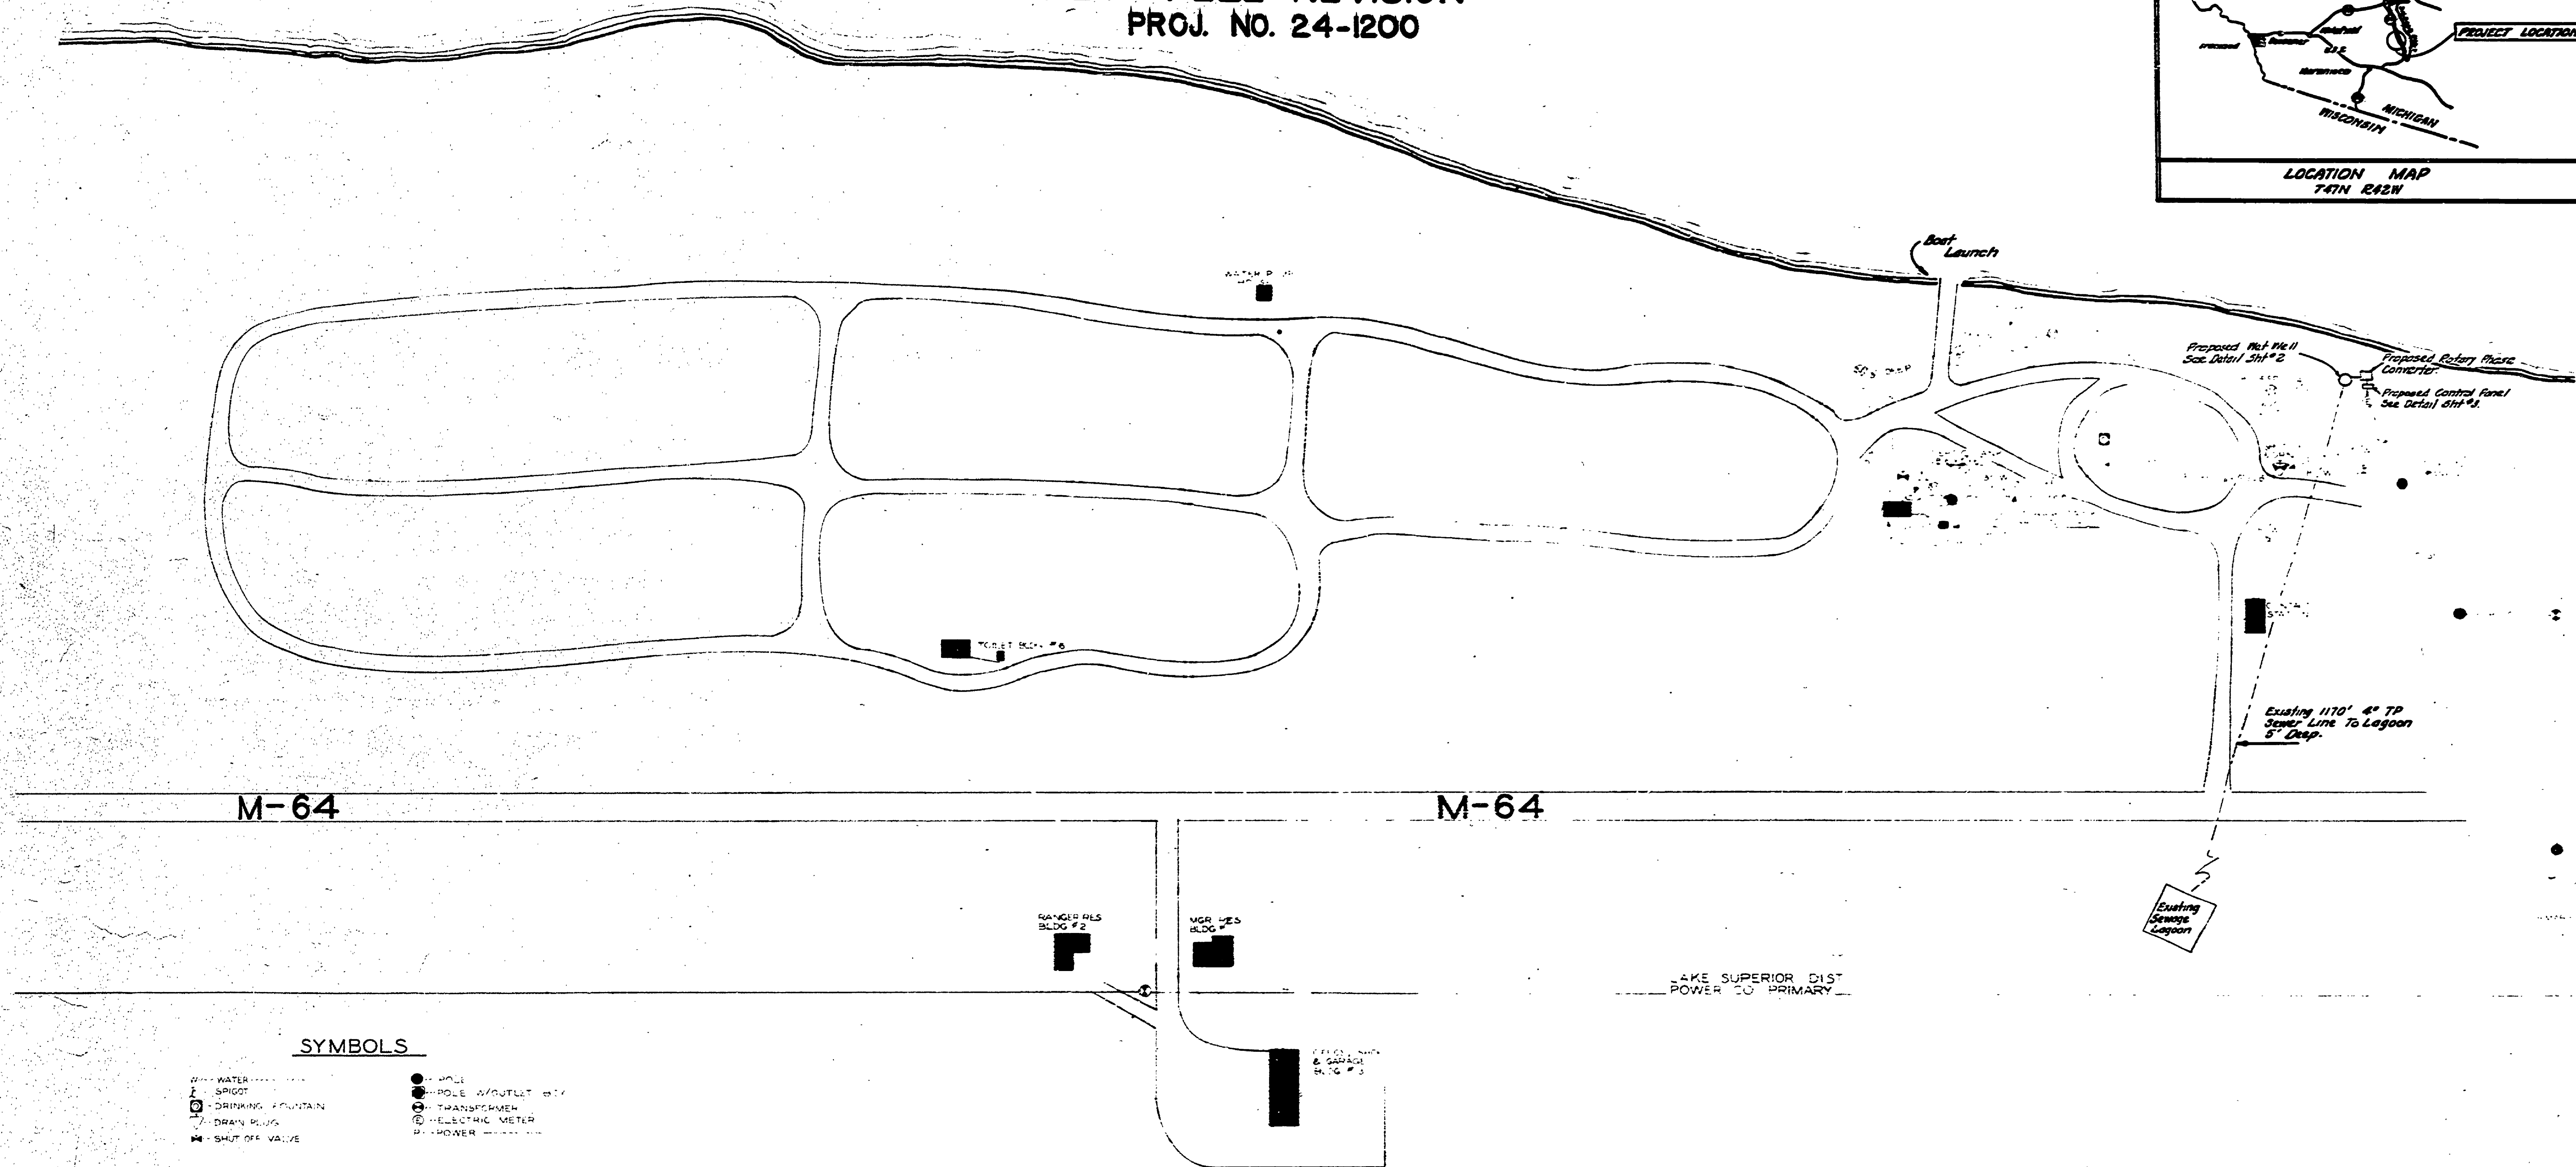


Lake Gogebic State Park

WET WELL REVISION
PROJ. NO. 24-1200

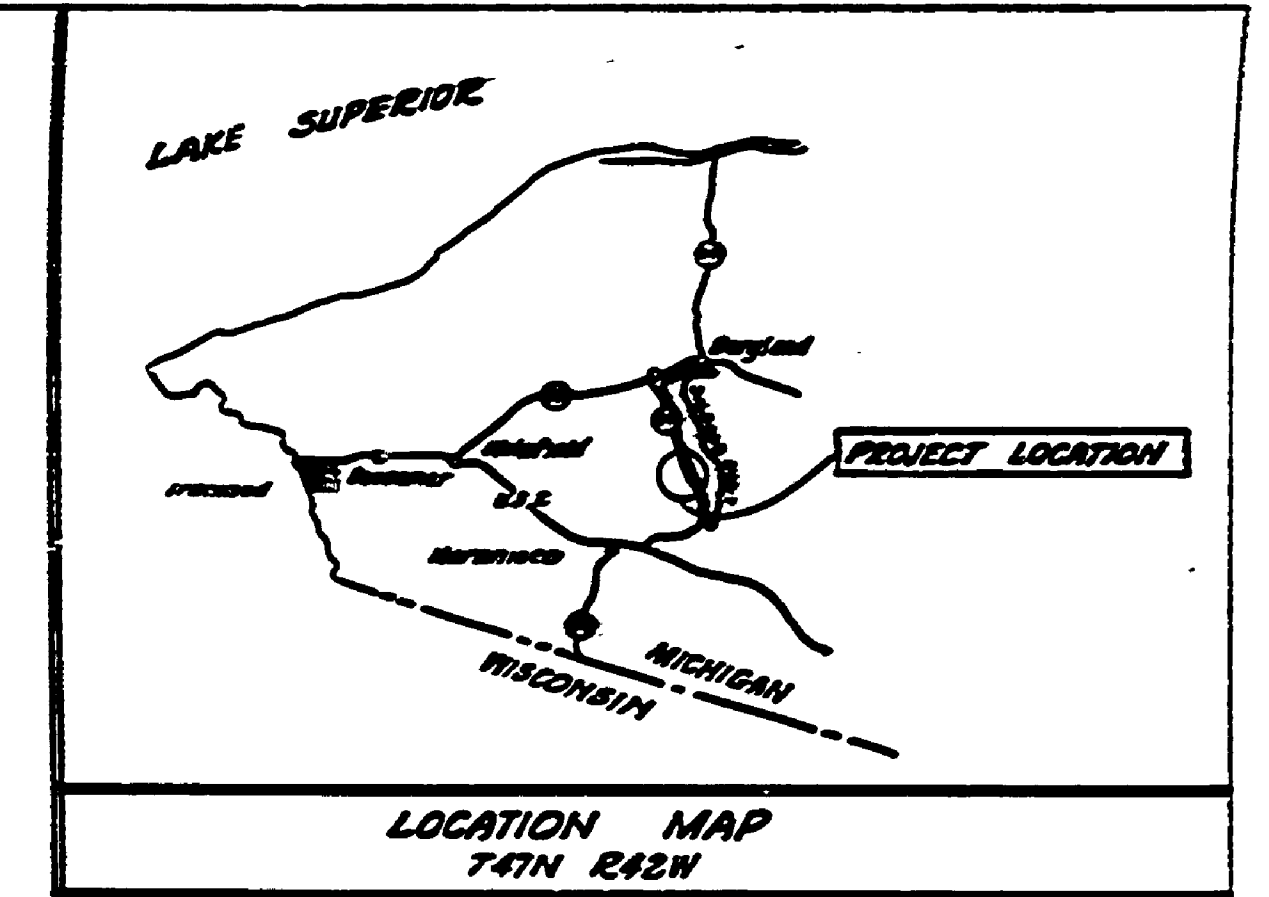

M-64

M-64

SYMBOLS

- WATER MAIN
- SPIGOT
- DRINKING FOUNTAIN
- DRAIN PLUG
- SHUT OFF VALVE
- SEWER
- MANHOLE
- HOLE
- HOLE OUTLET
- TRANSFORMER
- ELECTRIC METER
- POWER

DRAIN PLUG & V MUST BE OPENED WHEN WINTERIZING.

BUILDING COMMITTEE APPROVAL	
BY _____	DATE _____
RECOMMENDED FOR APPROVAL <i>Russell P. Peltola</i>	
RECOMMENDED FOR APPROVAL <i>S. J. Peltola</i>	
DIVISION - REGION APPROVAL	
BY <i>O. J. Schmitt</i>	DATE 6-10-73
ENGINEERING DIVISION	
APPROVED <i>H. M. ...</i>	DATE 6-15-73

SURVEYED BY _____	DRAWN BY <i>M. LeClaire</i>	4/73	NO DATE BY _____	REVISIONS _____	NO DATE BY _____	REVISIONS _____	MICHIGAN DEPARTMENT OF NATURAL RESOURCES	SITE PLAN SHEET TITLE	LAKE GOGEBIC STATE PARK AREA OR PARK	PROJECT NO. 24-1200	SHEET 1 OF 3	PLAN NO. E-111
DESIGNED BY <i>M. LeClaire</i>	CHECKED BY <i>R. H. Merrill</i>	4/73	DATE _____	DATE _____	DATE _____	DATE _____			NET WELL REVISION PROJECT			