


PLAN AT ELEV. 628.00  
SCALE: 1"=1'-0"

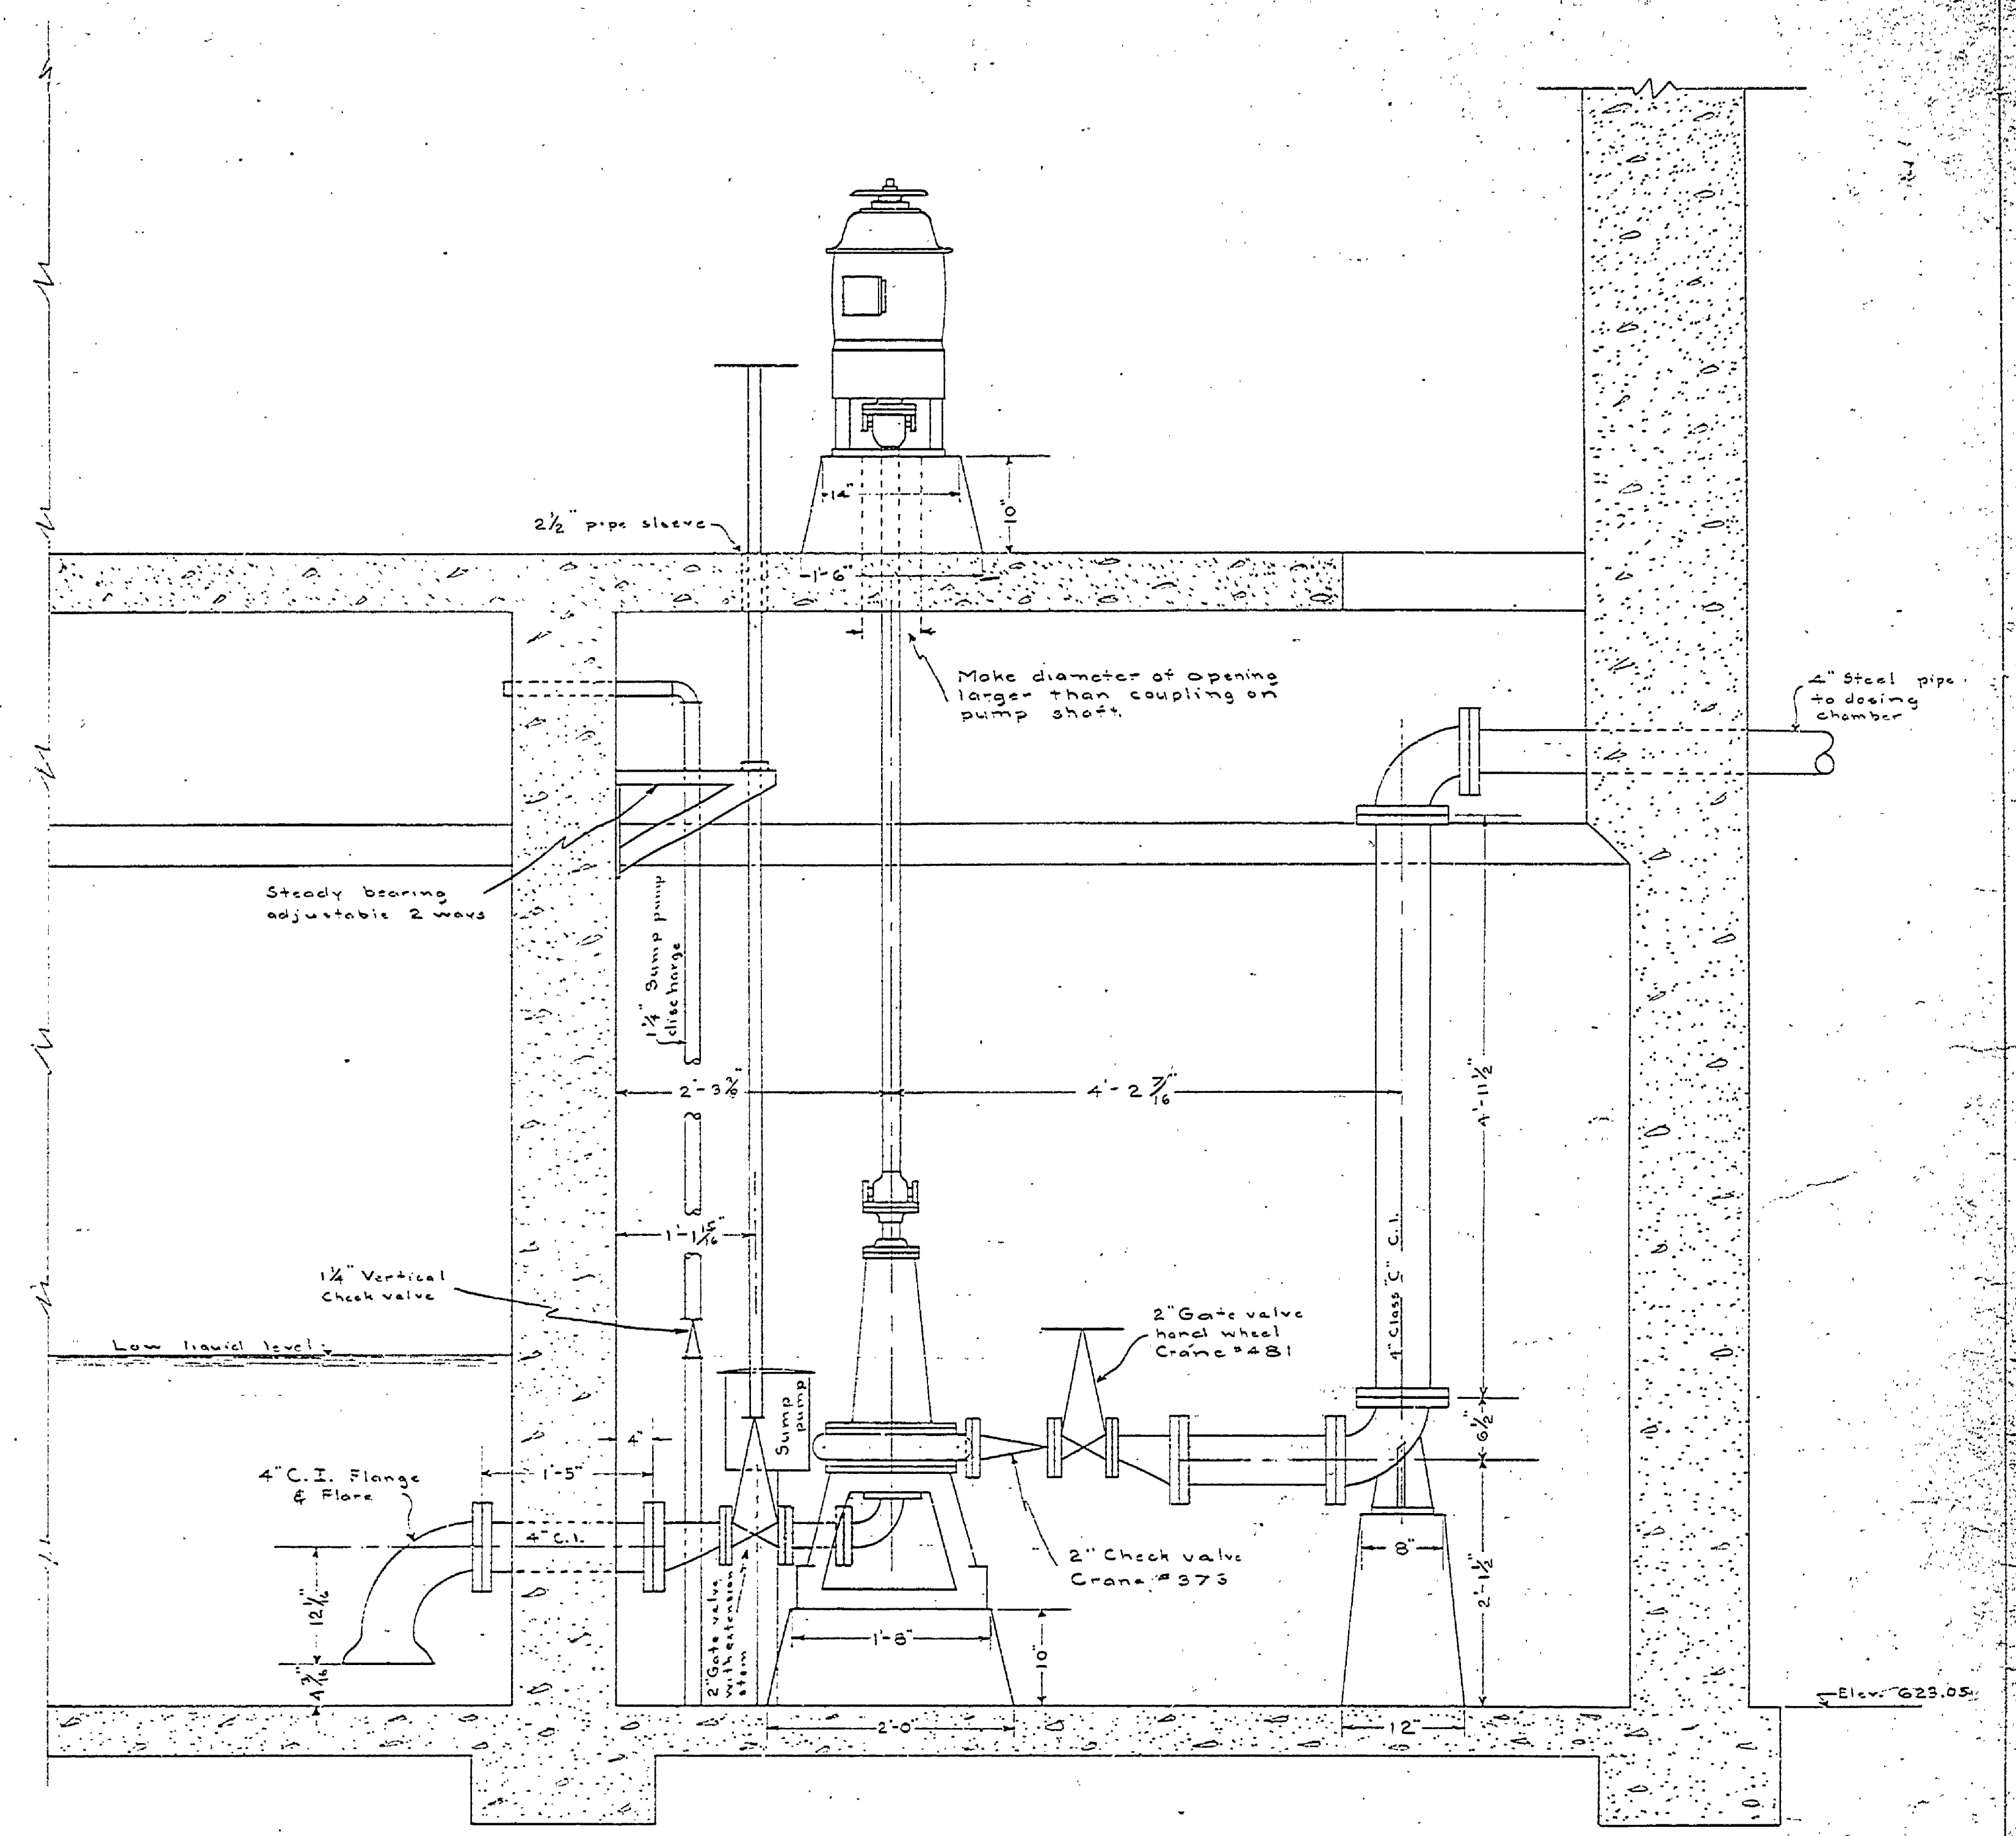

SECTION A-A  
SCALE: 1"=1'-0"

NOTE: Dimensions shown on fittings are face to face dimensions of some. Overall dimensions on pipe runs include a 1/8" gasket at each joint.

E-96

MICHIGAN DEPARTMENT OF CONSERVATION		
UNITED STATES DEPARTMENT OF THE INTERIOR NATIONAL PARK SERVICE COOPERATING		
DRAWN BY K.E.B.	ORCHARD BEACH STATE PARK	PLAN NO.
DESIGNED BY M.C.M.	SEWAGE PUMPS & PIPING LAYOUT FOR DISPOSAL SYSTEM	SCALE: AS SHOWN
CHECKED BY LUDINGTON-S.P.2-MICHIGAN		DATE
PREPARED AND APPROVED BY	CHEF OF STATE PARKS	DATE
APPROVED BY	INSPECTOR	DATE