



HALF PLAN-HALF SECTION

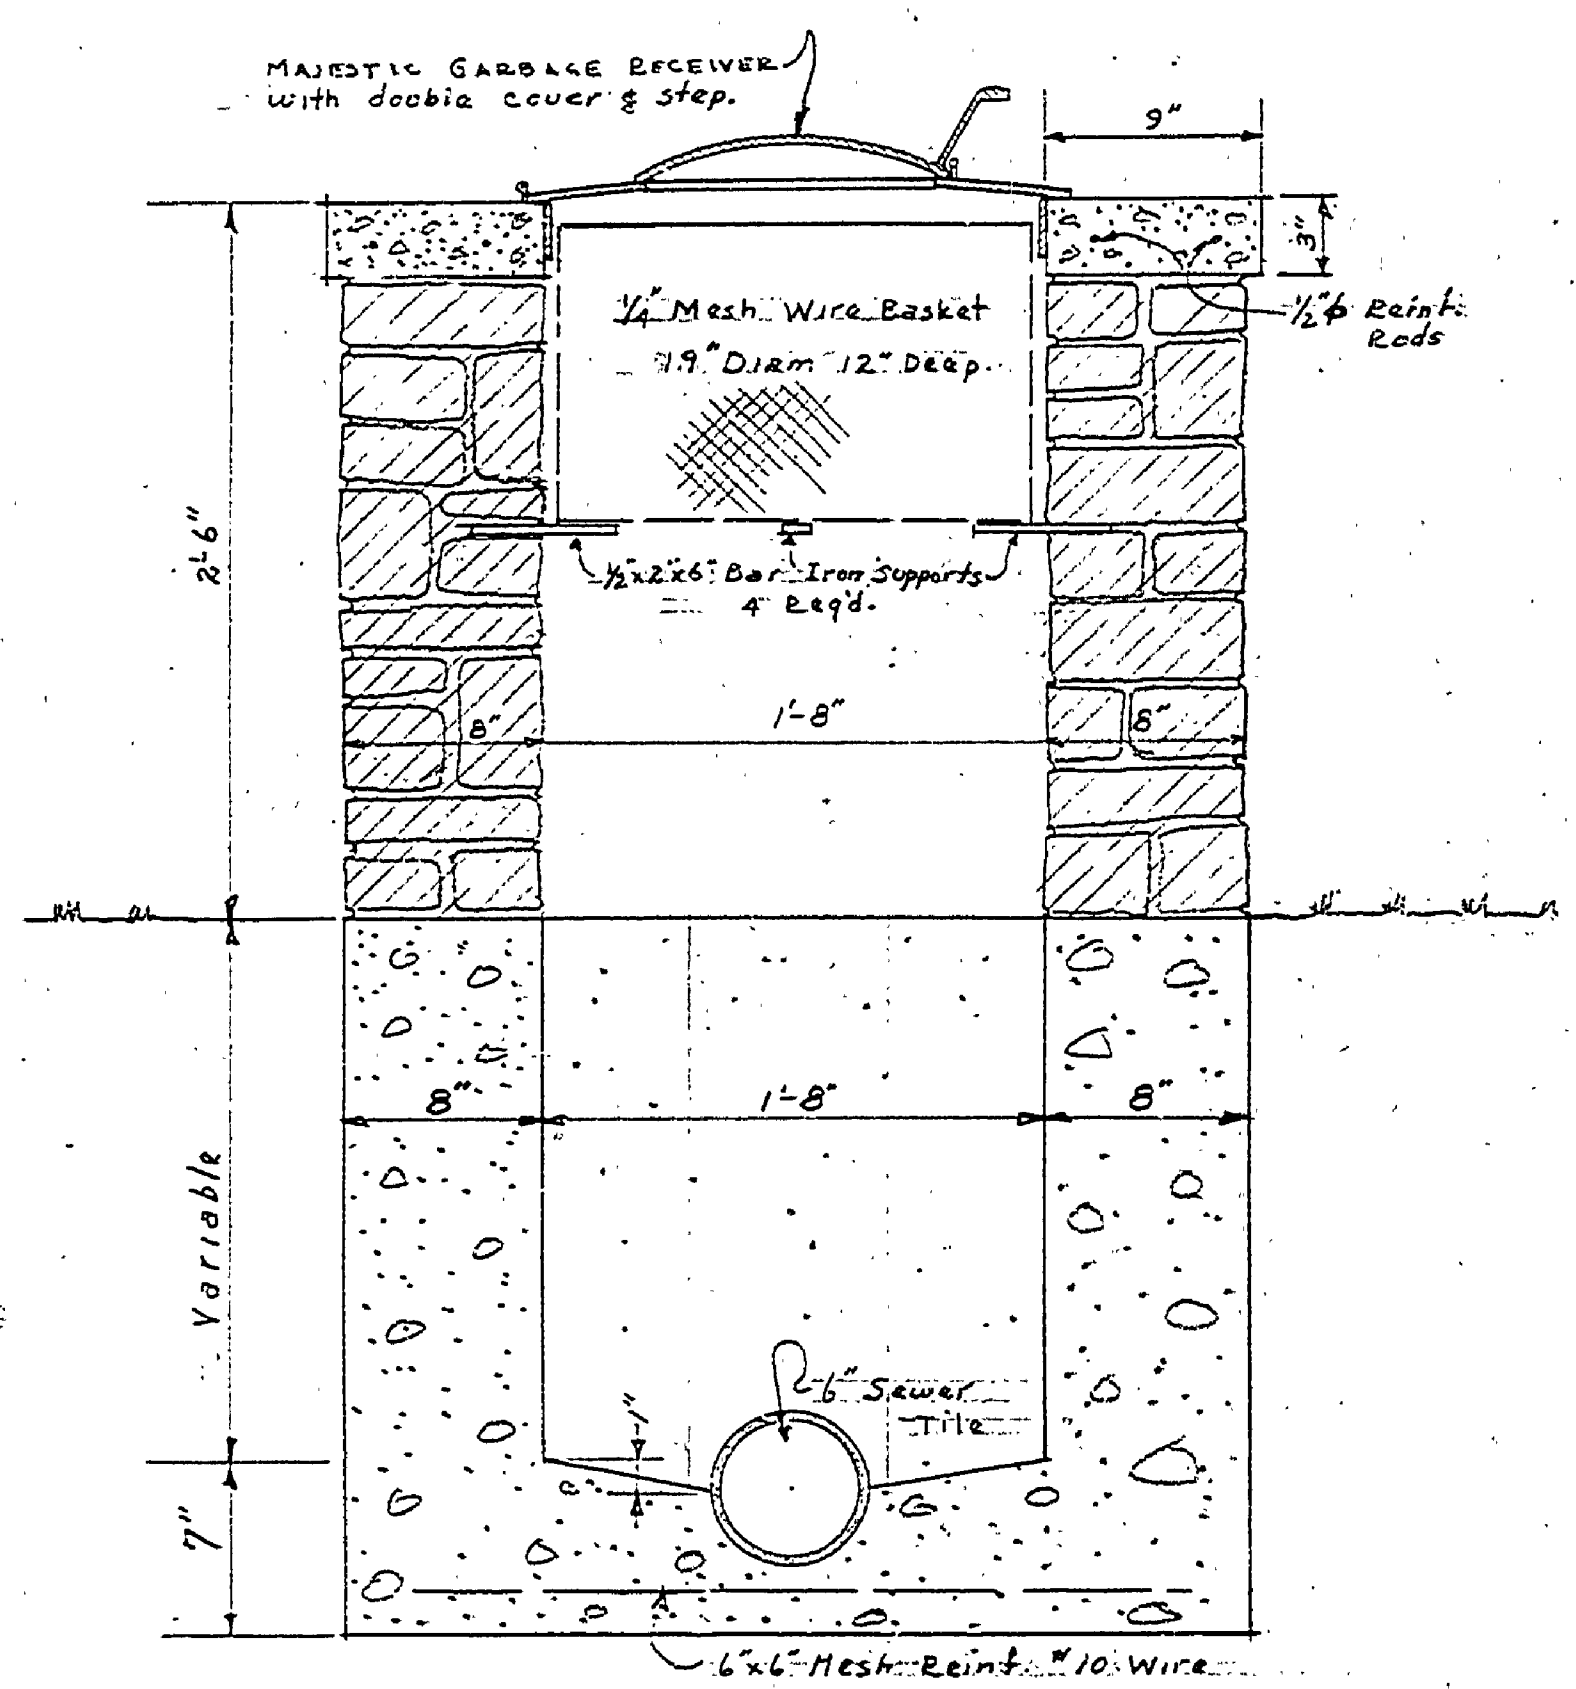


SECTION

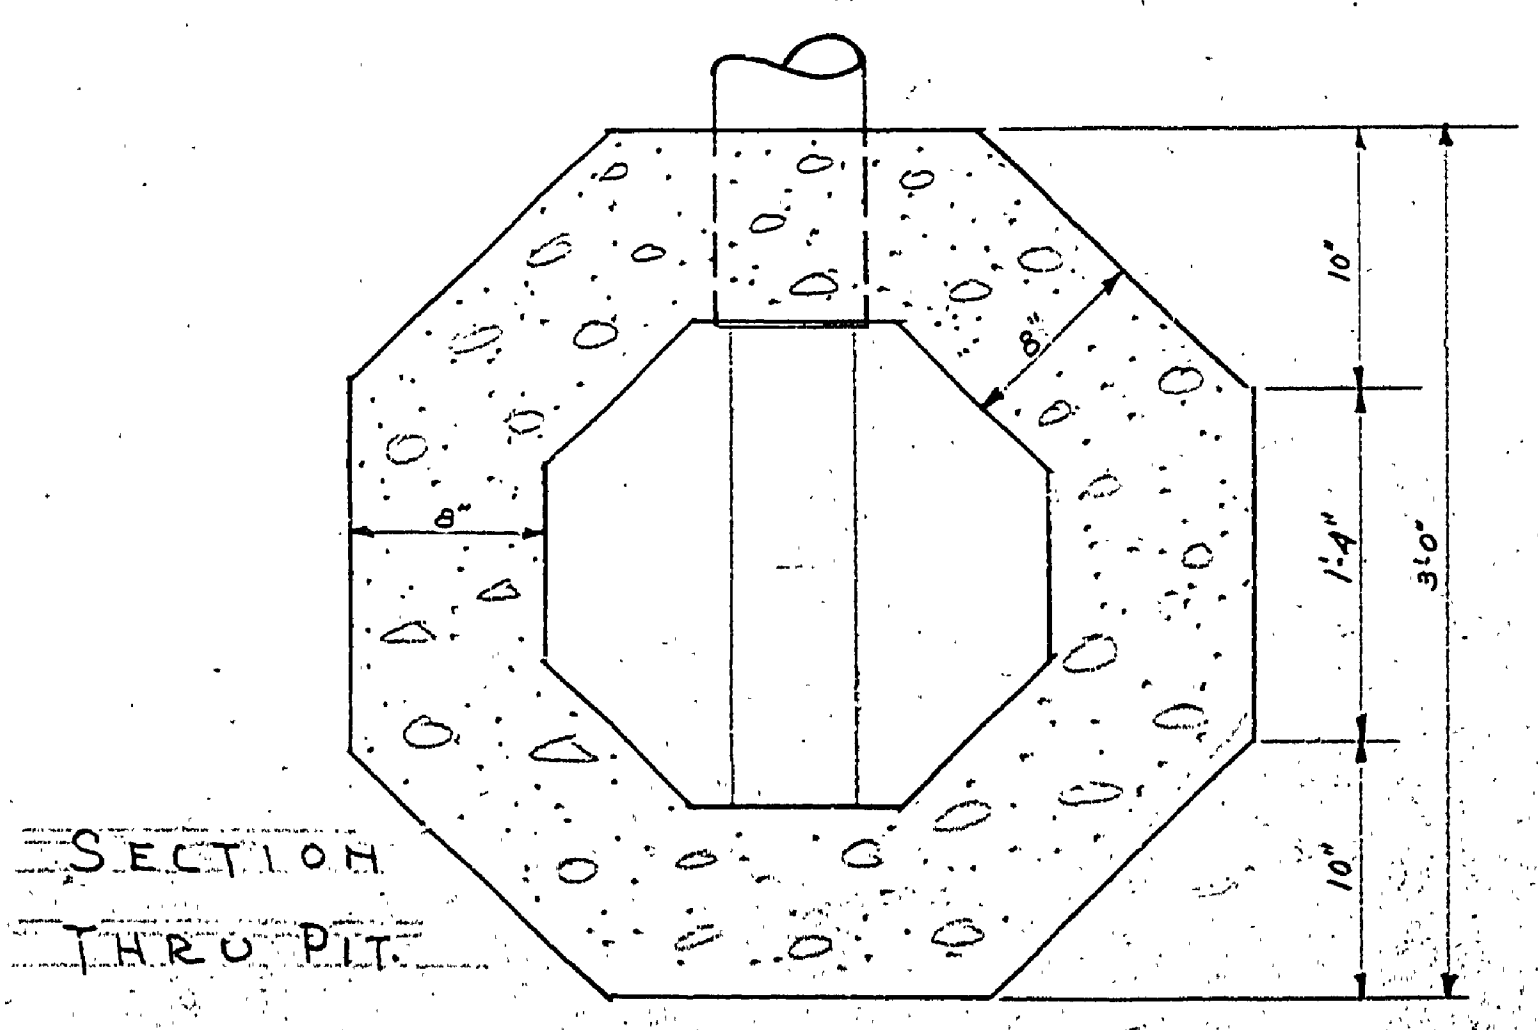


SECTION THRU PIT

DETAILS OF WASTE WATER SUMP
 SCALE: 1/2" = 1'-0"

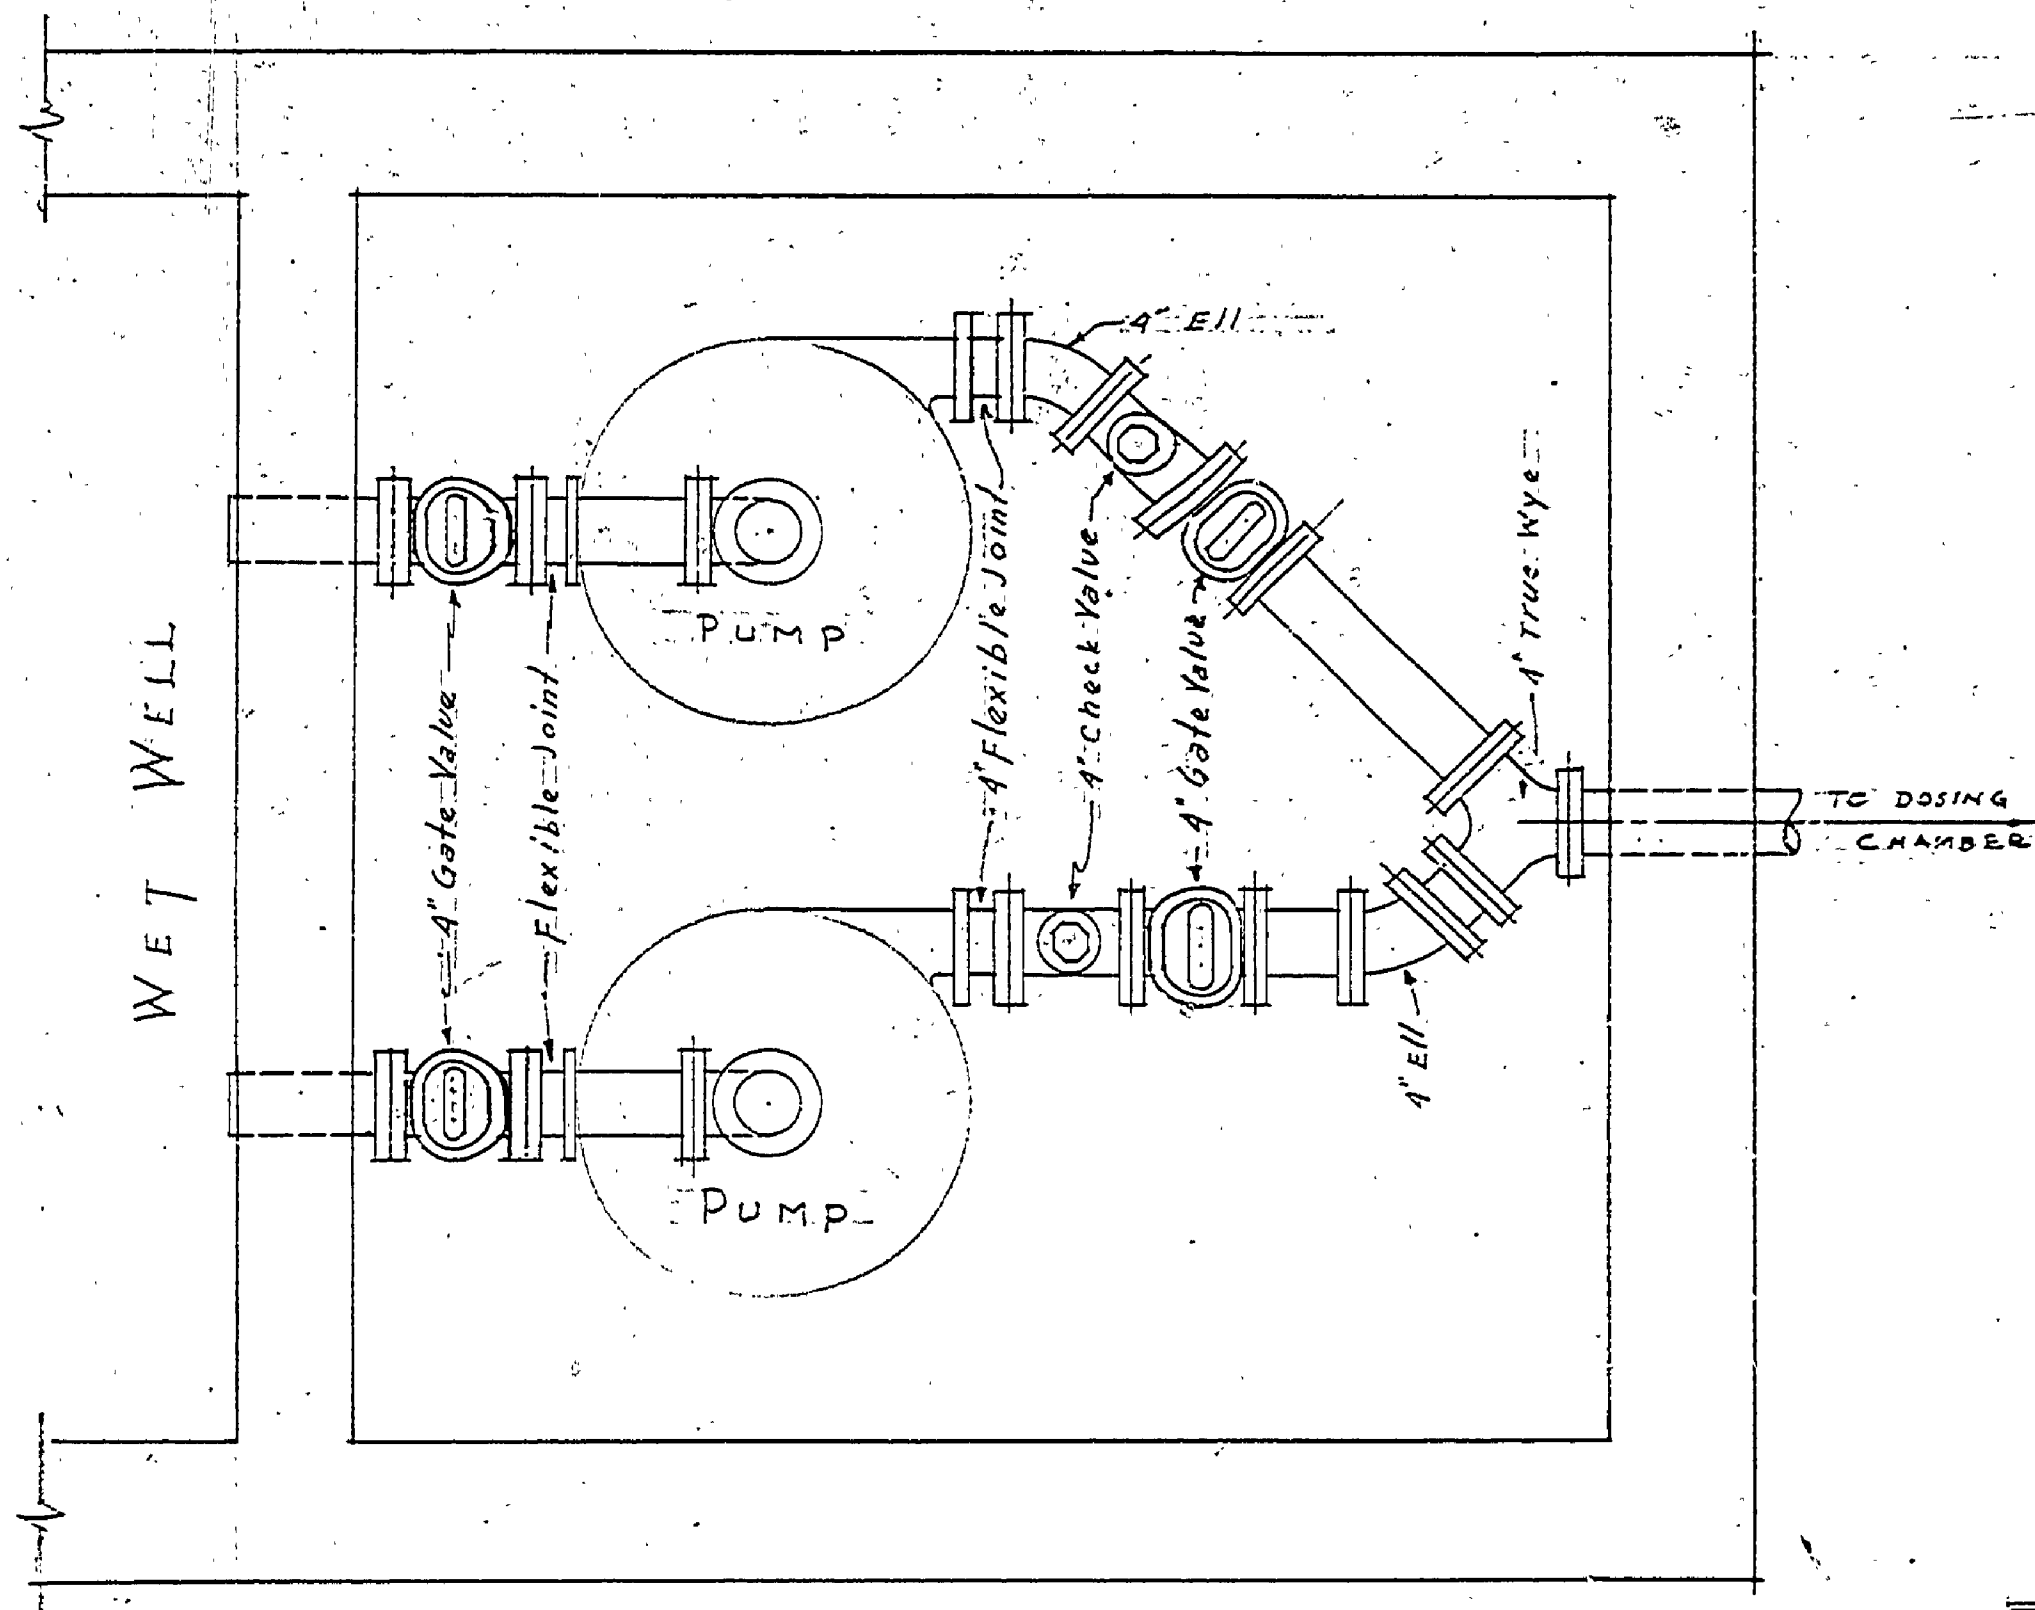


PUMPING STATION-PIPING LAYOUT


SCALE: 3/4" = 1'-0"
 NOTE: Do not set pipes in walls until piping layout has been checked by pump manufacturer furnishing the pumps for this job.

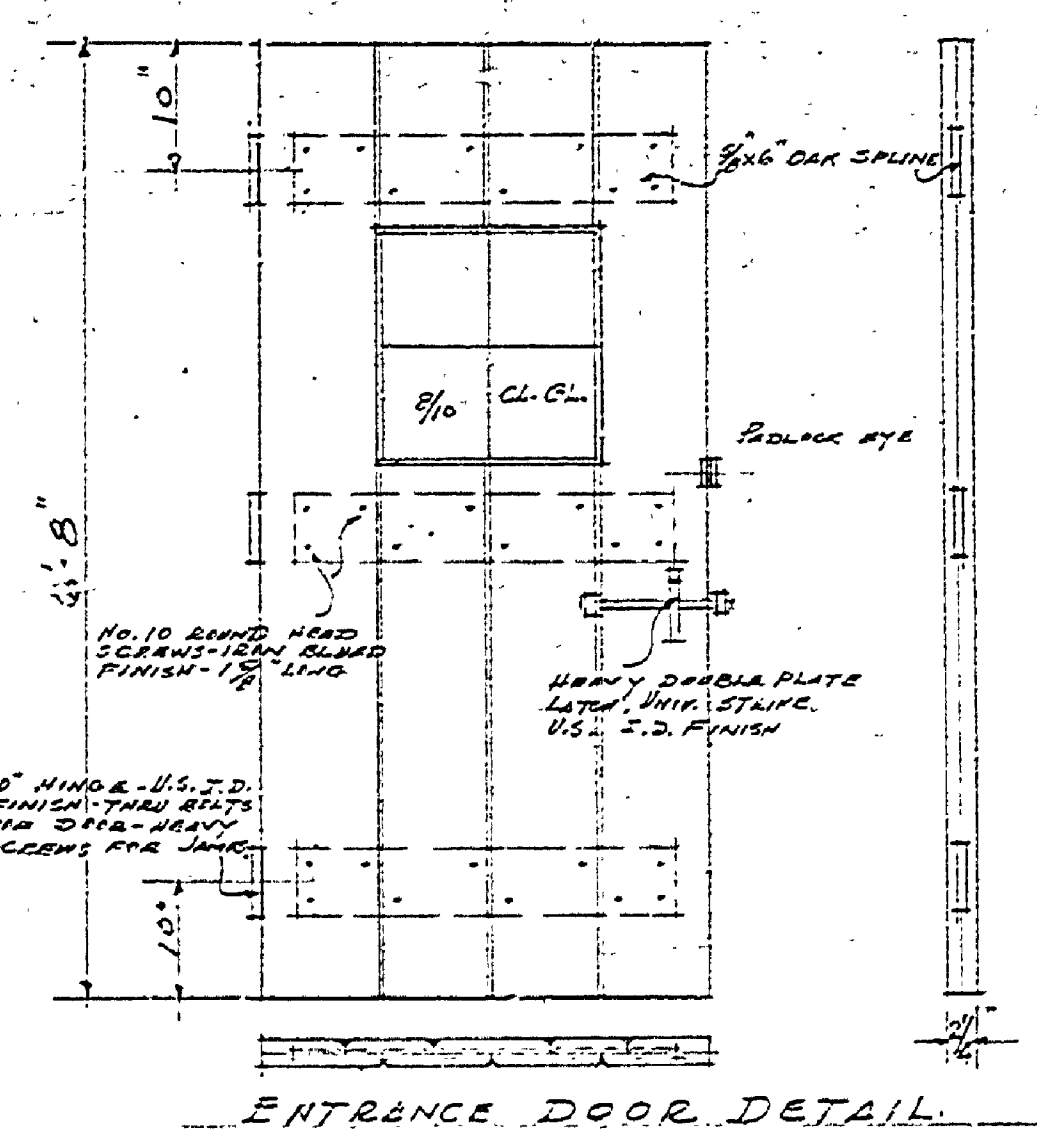


ENTRANCE DOOR DETAIL

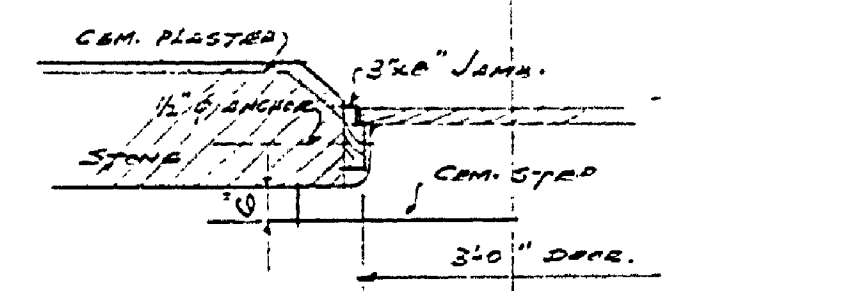


PLAN THRU DOOR WAY
 SCALE: 1/2" = 1'-0"

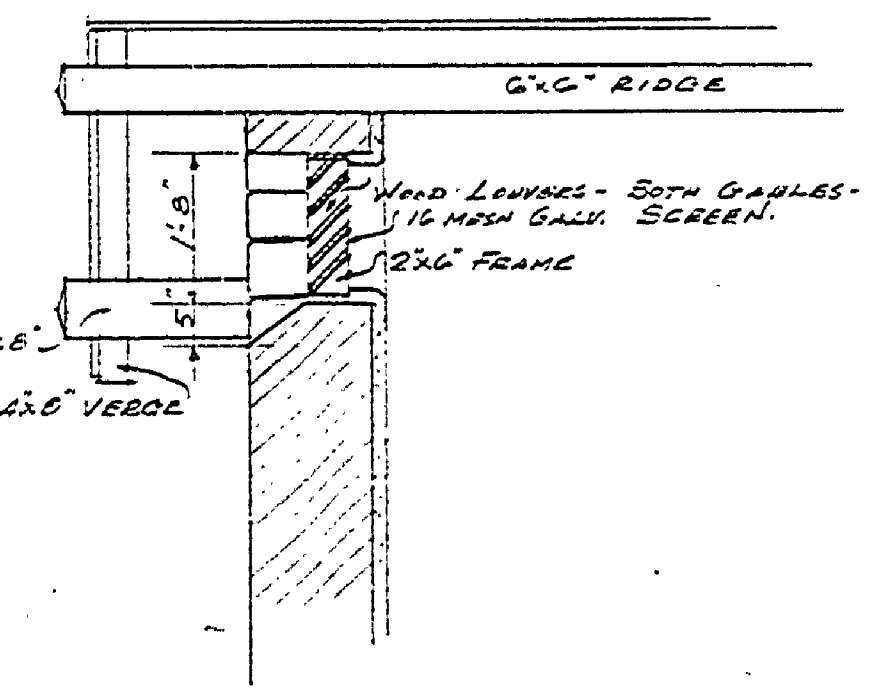


SEC. THRU LOUVERS
 1/2" SCALE

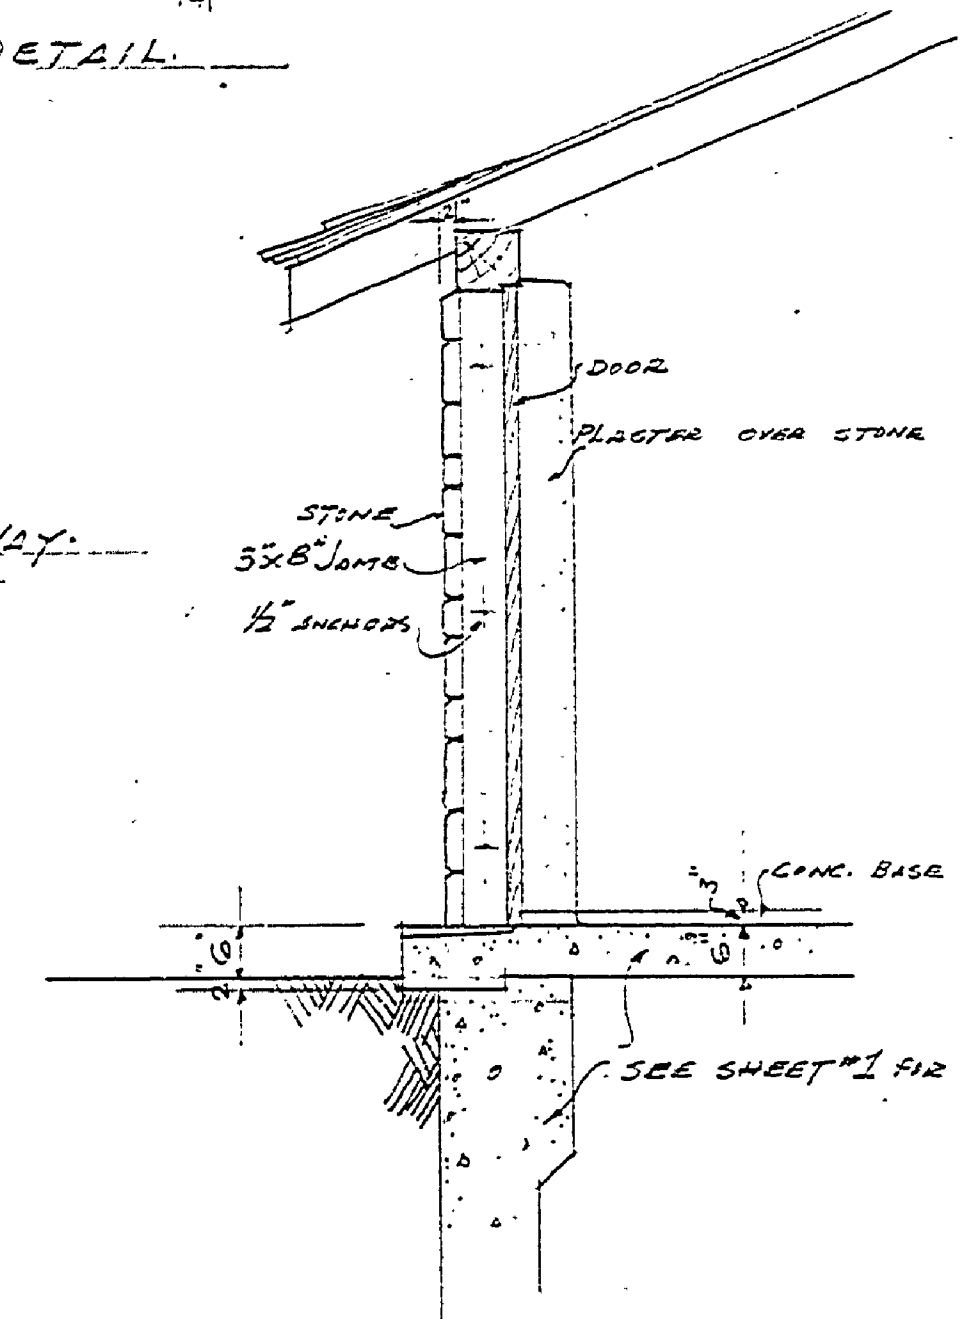


SEC. THRU ENTRANCE
 SCALE: 1/2" = 1'-0"

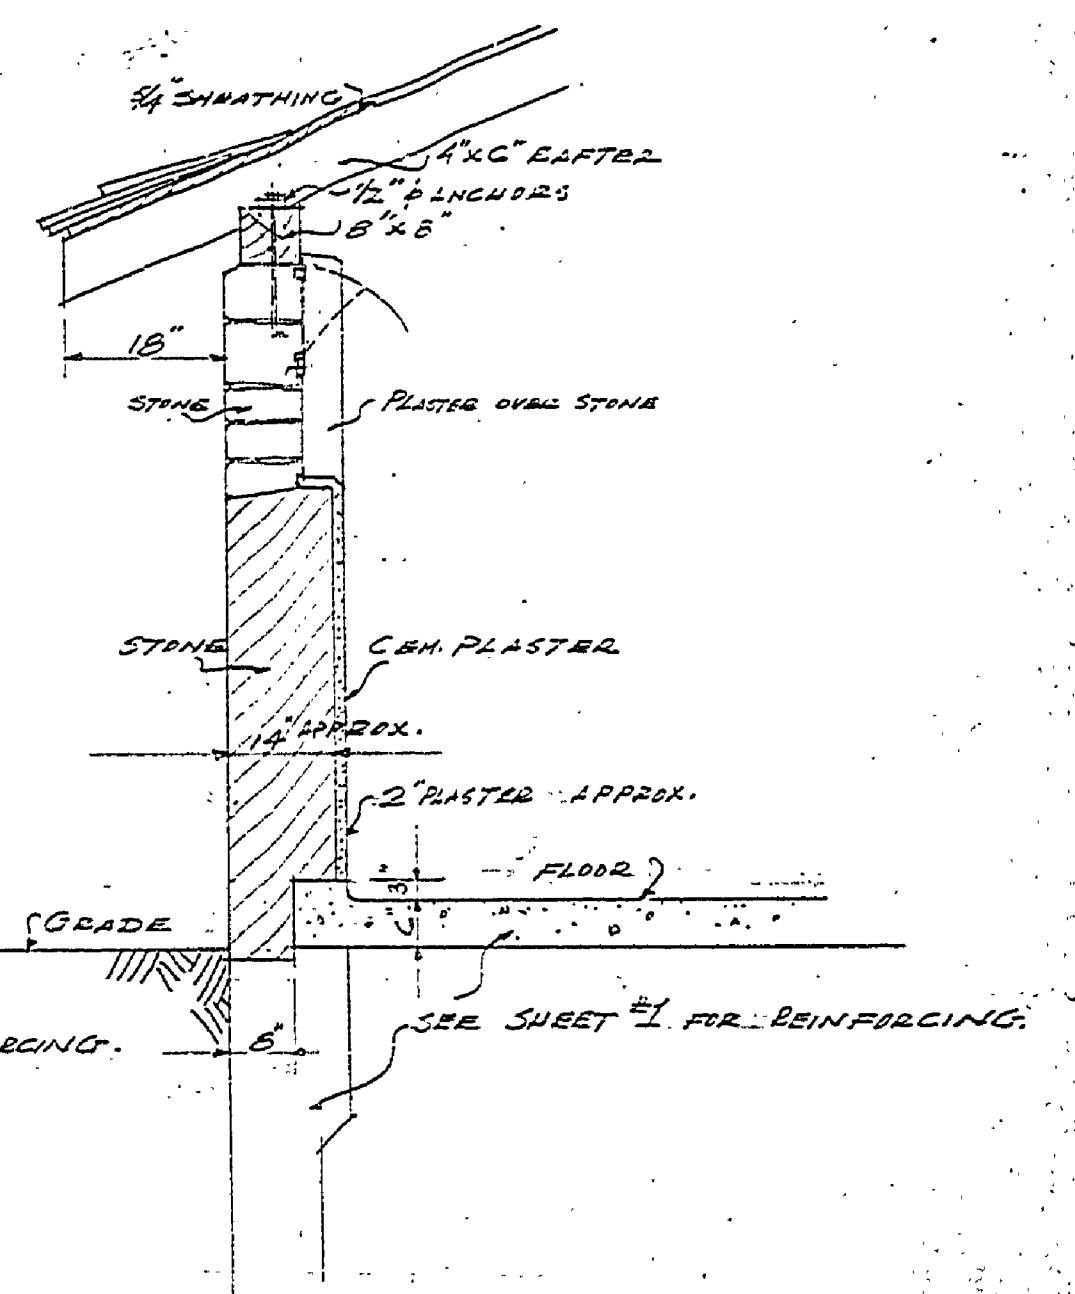

SEC. THRU WINDOW
 SCALE: 1/2" = 1'-0"

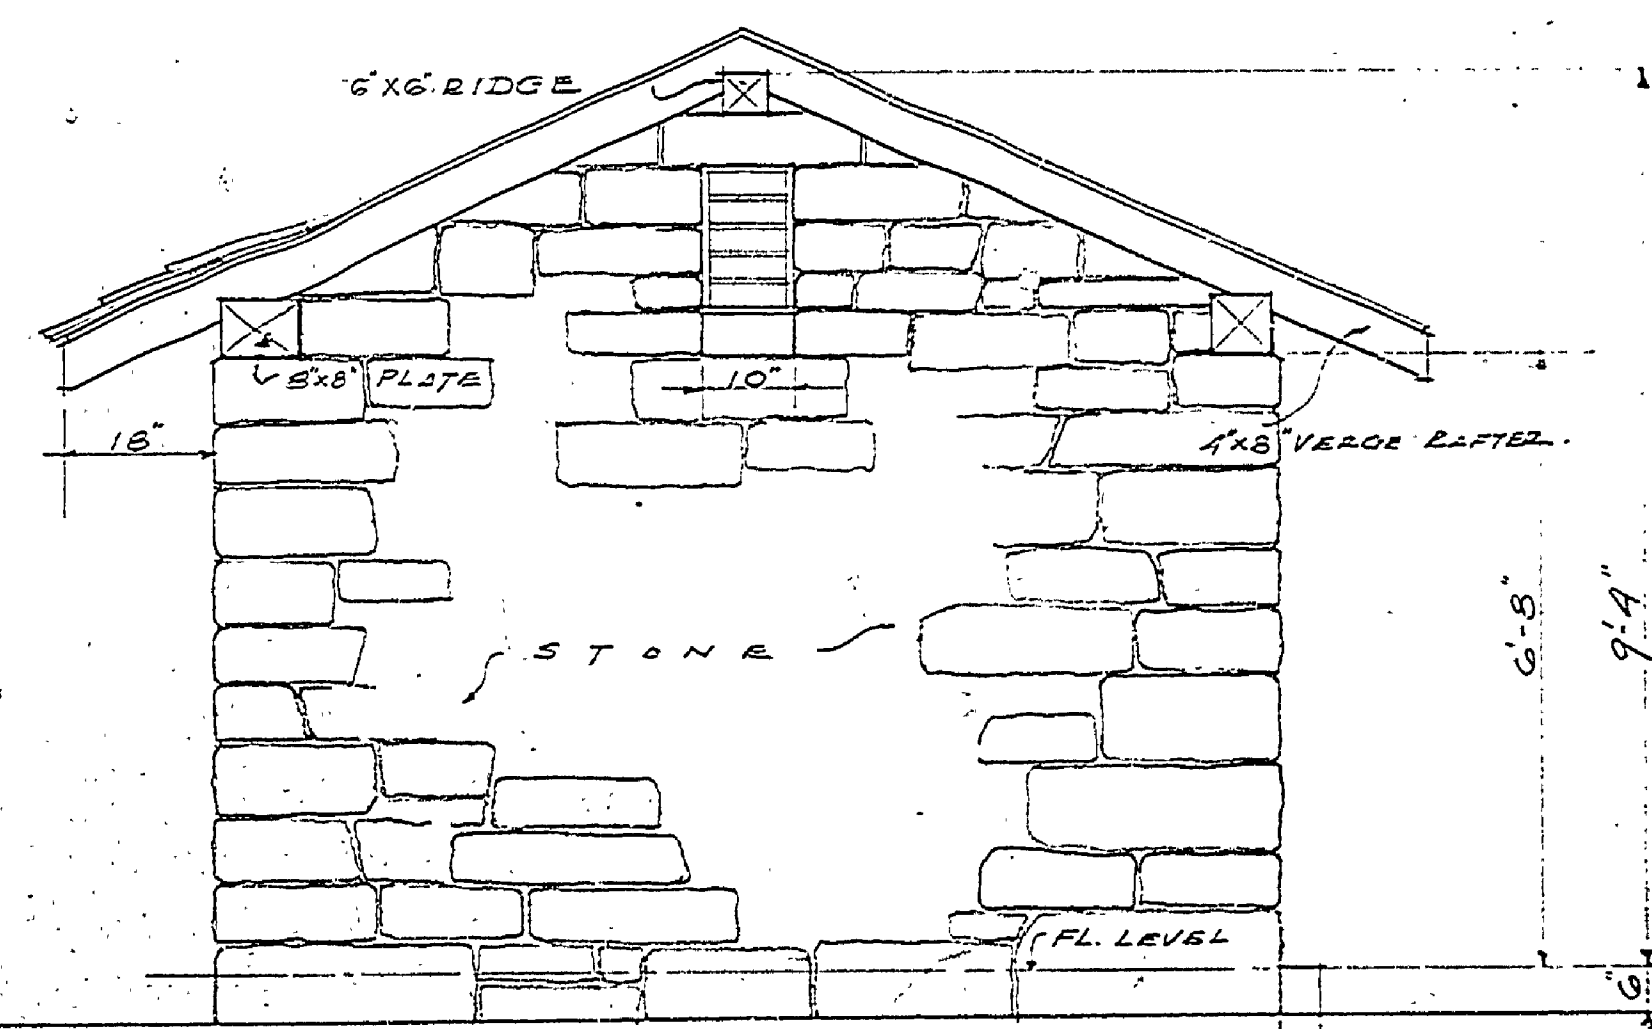

SOUTH ELEVATION
 SCALE: 1/2" = 1'-0"

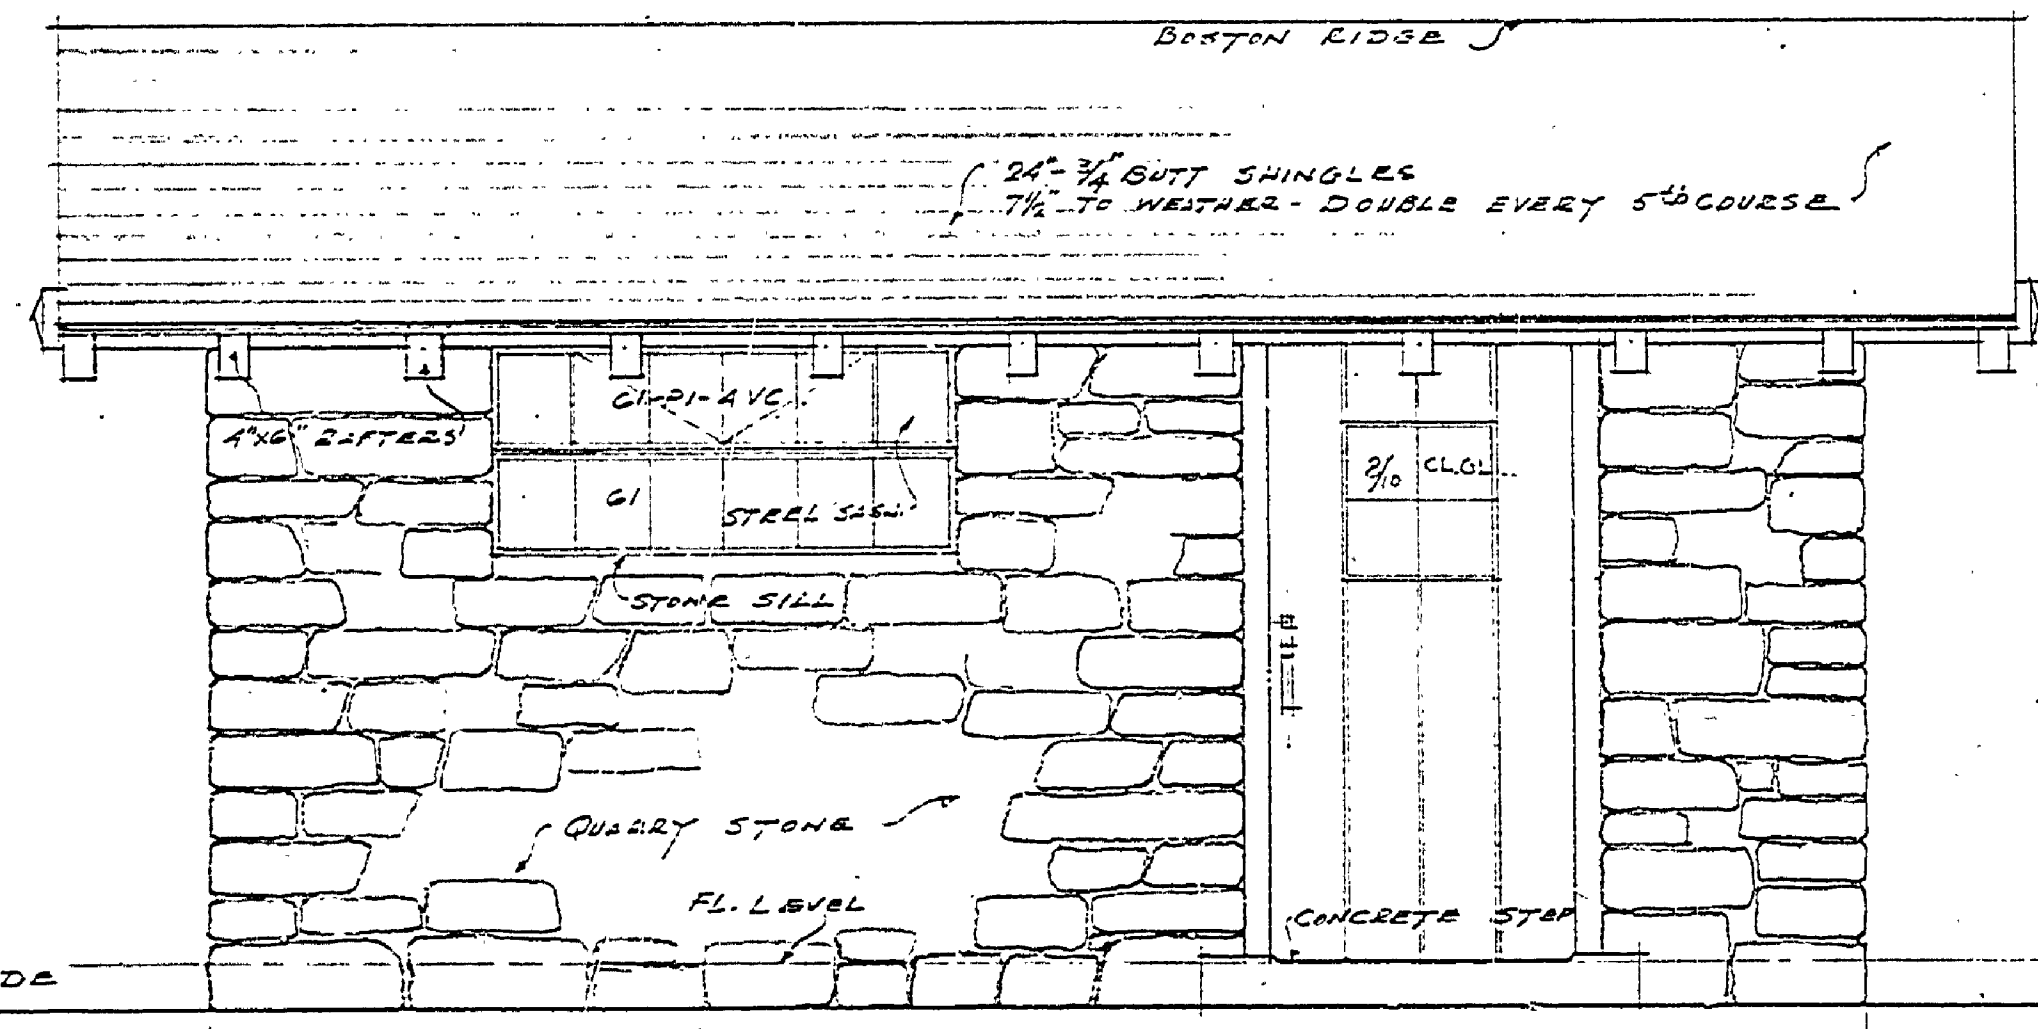

EAST ELEVATION
 SCALE: 1/2" = 1'-0"

E-98

Michigan Department of Health
 EDWIN GTON S. RICHMONTIAN
 ARCHITECT
 1939
 CONSTRUCTION PERMIT NO.