


REVISIONS	NO.	DATE	BY
4			
B			
0			


APPROVED BY	DATE
<i>[Signature]</i>	9-2-57
ASSISTANT CHIEF IN CHARGE	DATE
<i>[Signature]</i>	9-2-57

REVIEWED BY SECTIONS	DATE
ARCHITECTURAL	9-2-57
ENGINEERING	9-2-57
LANDSCAPE	9-2-57


DRAWN BY	DATE
<i>[Signature]</i>	9-2-57
CHECKED BY	DATE
<i>[Signature]</i>	9-2-57

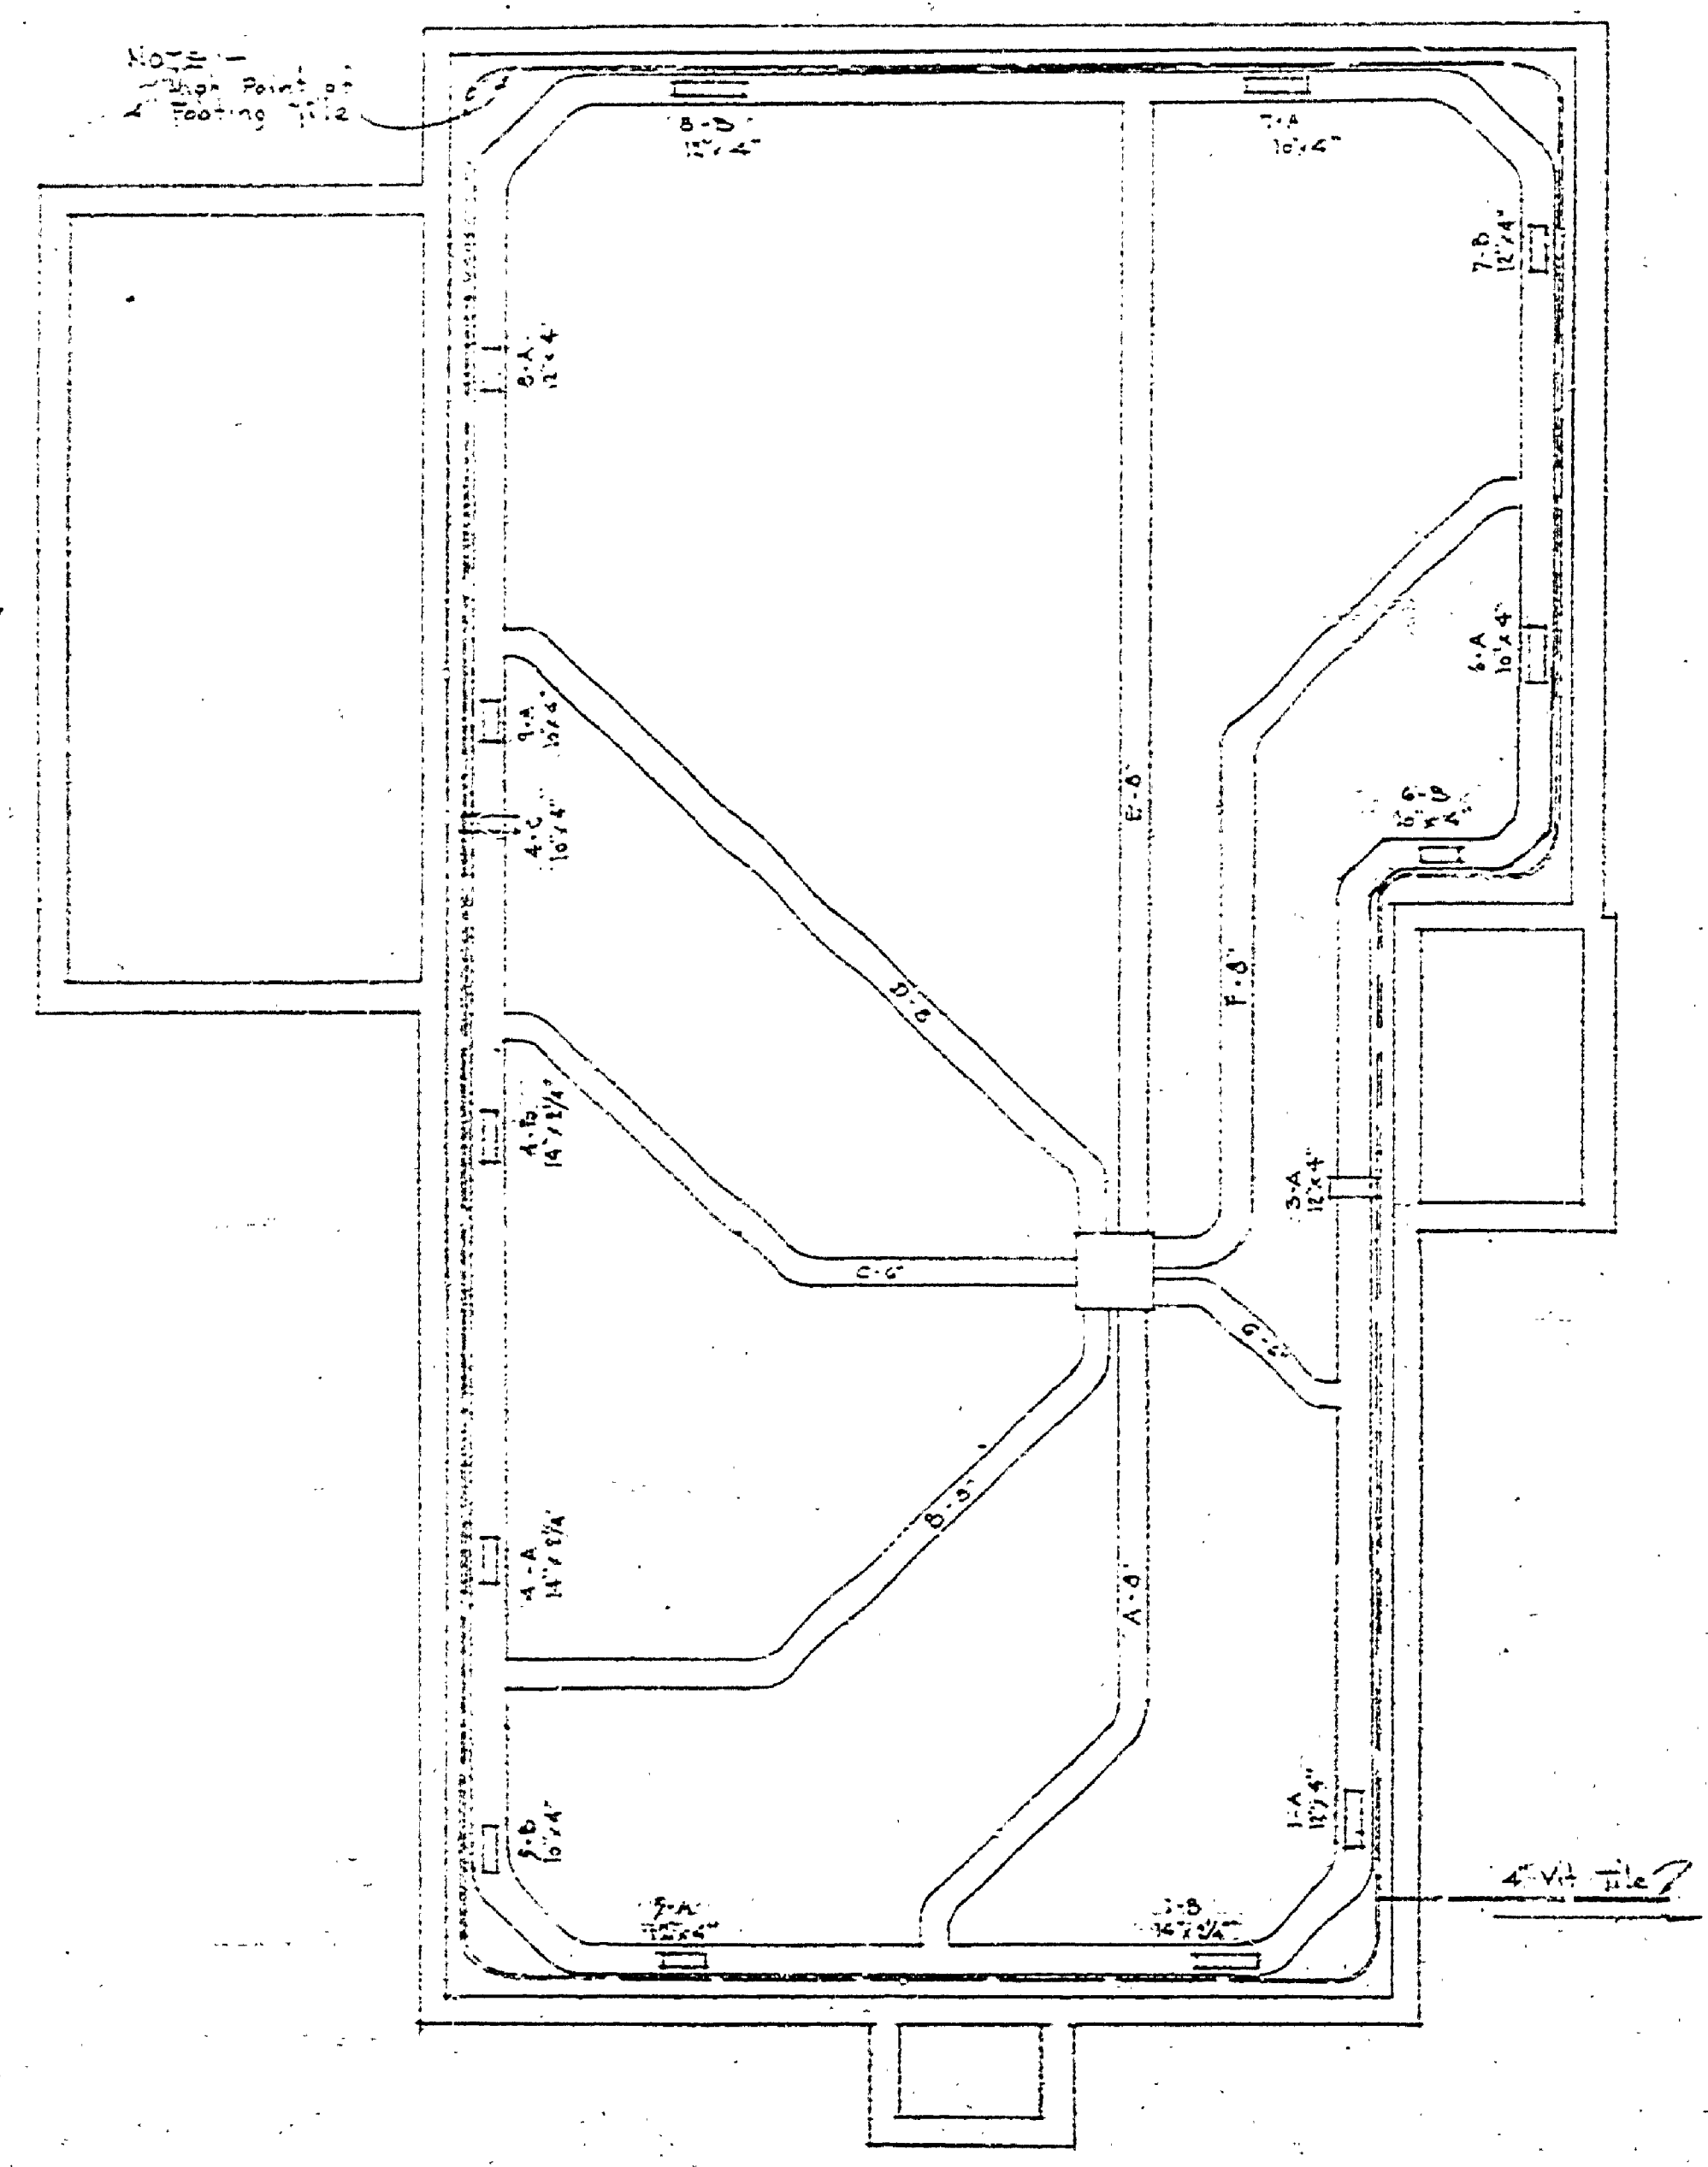


HEATING PLAN
Scale: 1/8" = 1'-0"

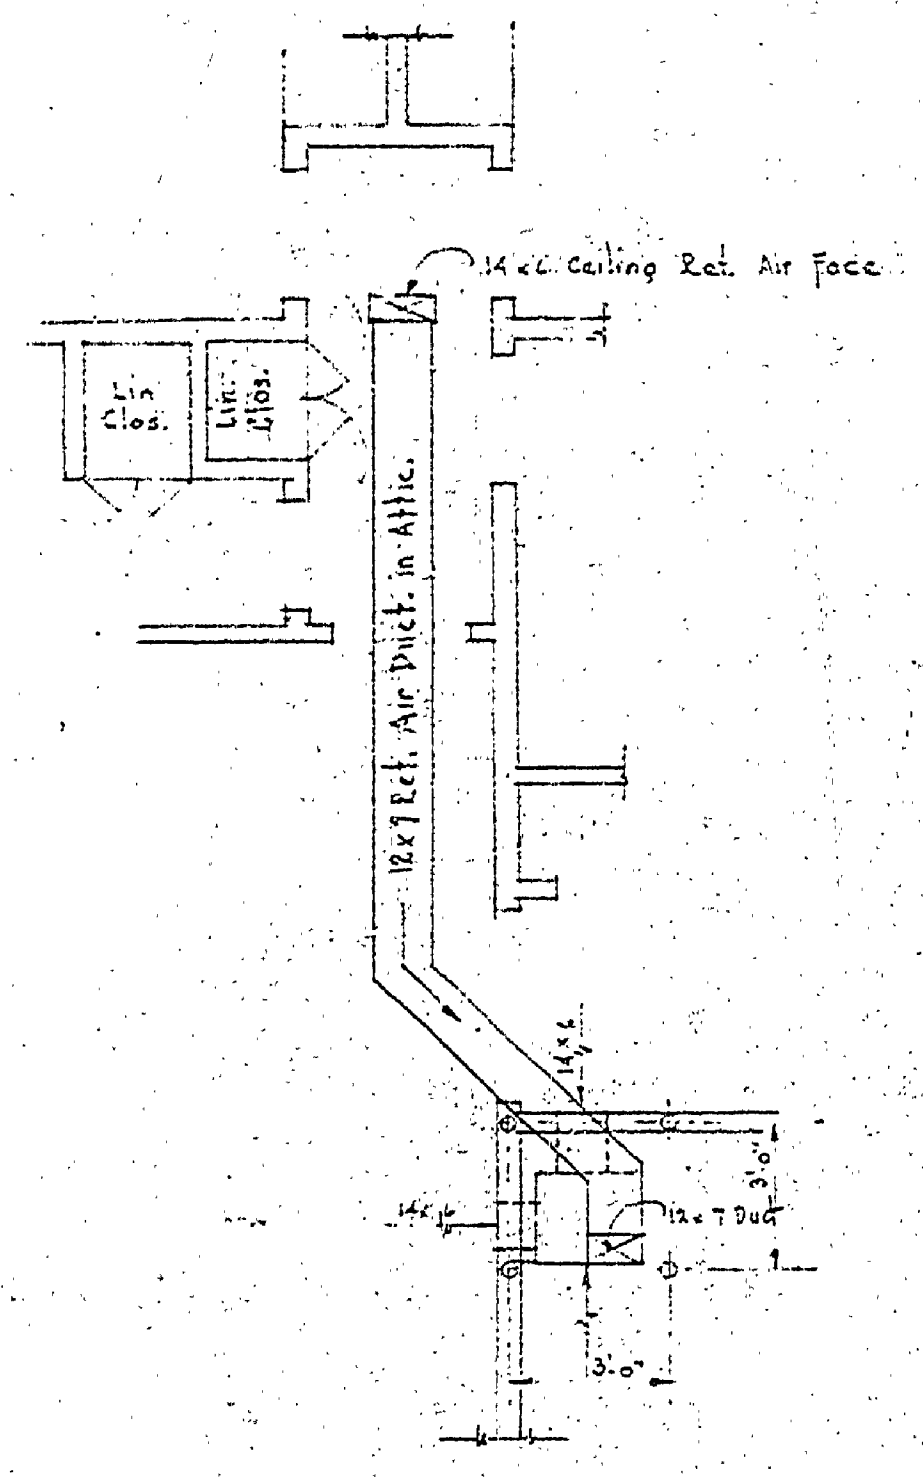


PLAN LAYOUT OF RETURN DUCT
Scale: 1/8" = 1'-0"

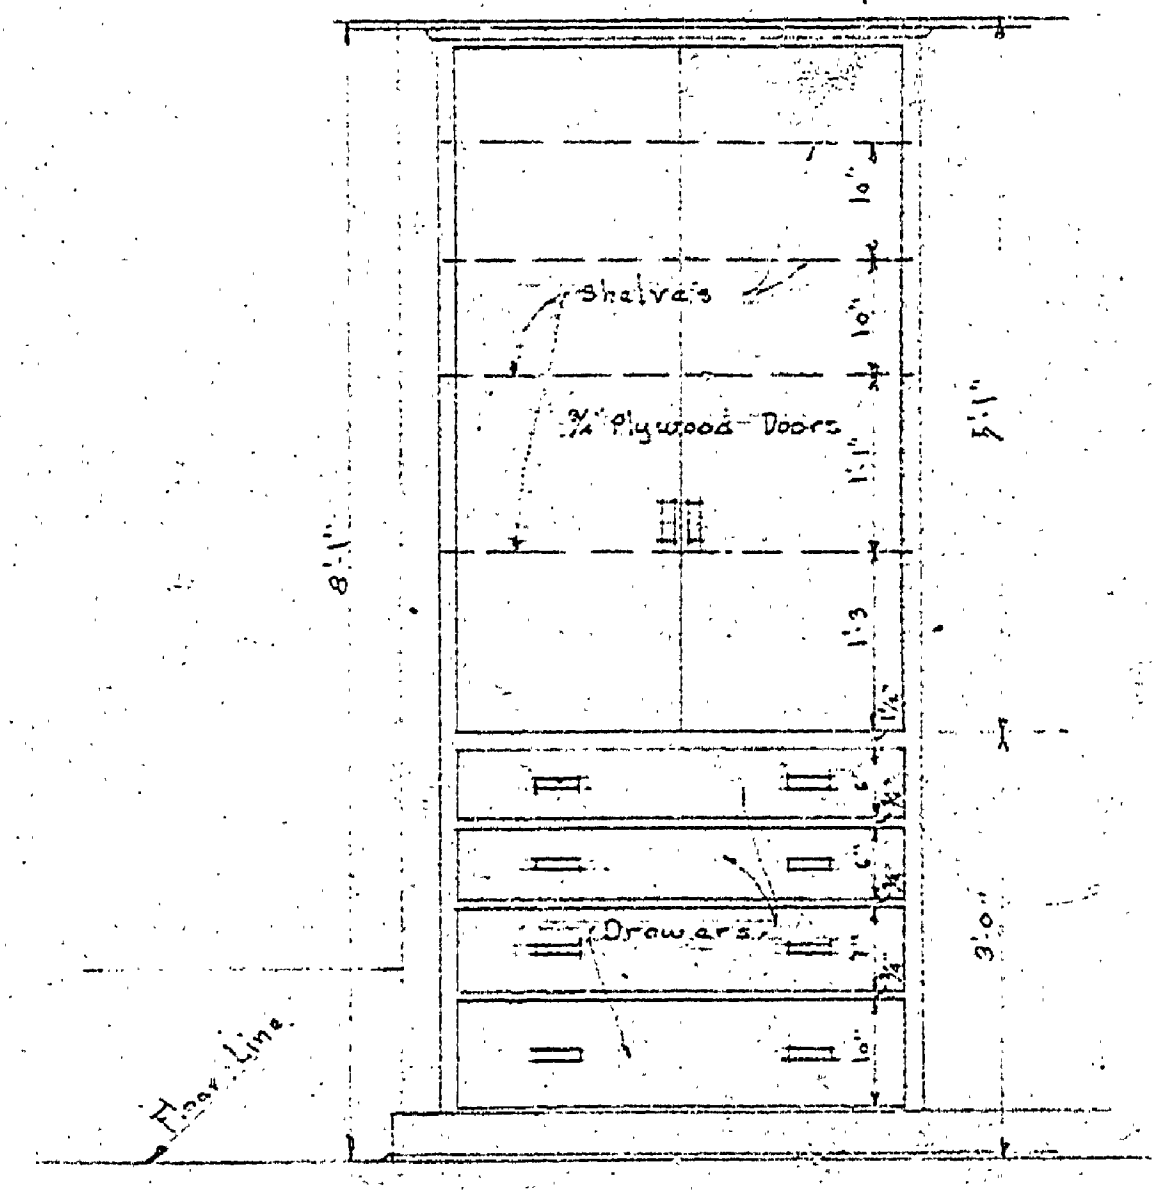

ELEVATION

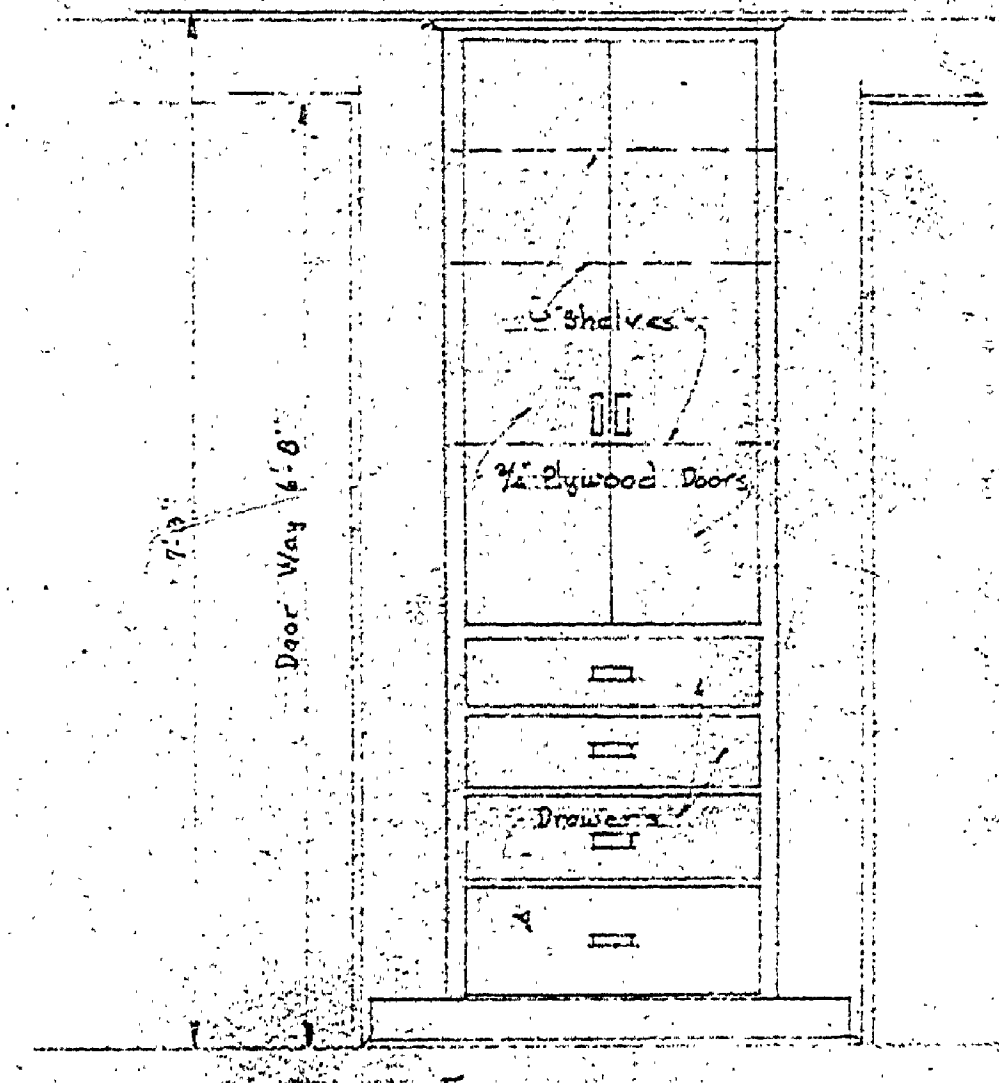

ELEVATION

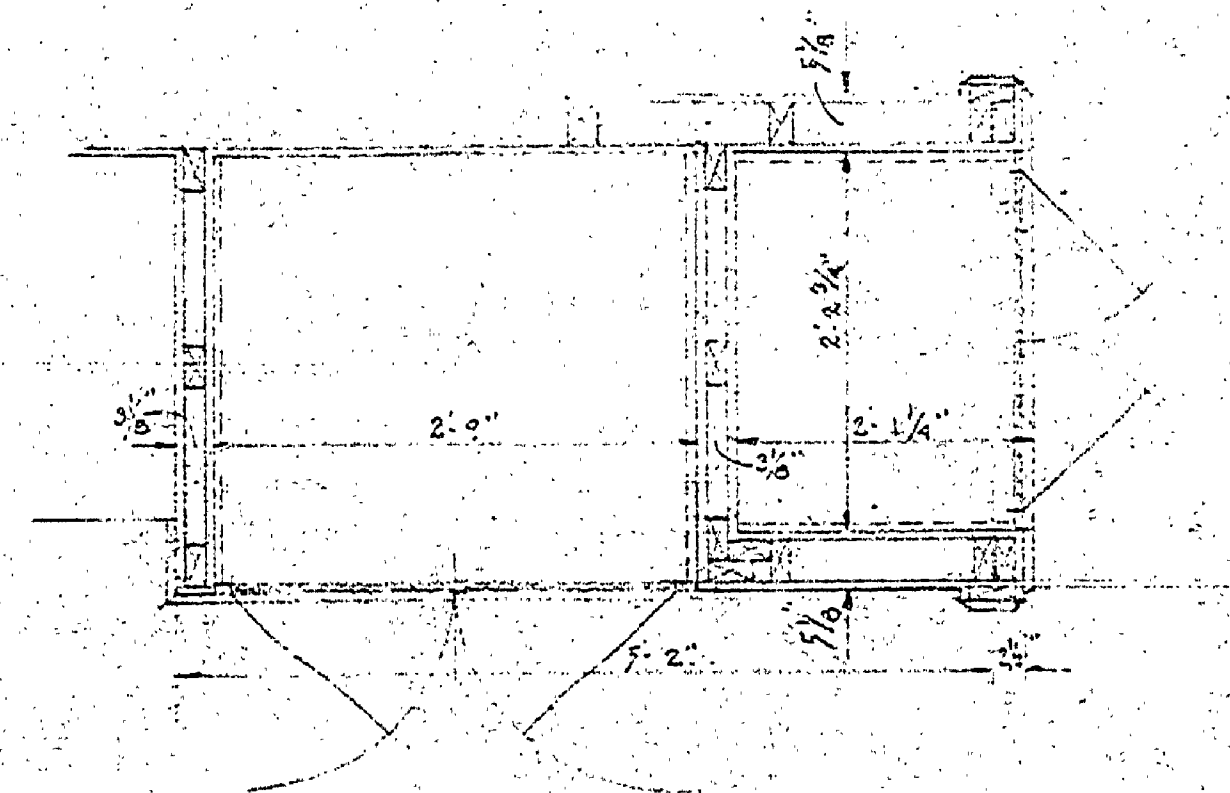

LINEN CLOSET DETAIL
Scale: 1/4" = 1'-0"

PLAN

MICHIGAN
DEPARTMENT OF CONSERVATION
PARKS AND RECREATION DIVISION

WM. MITCHELL STATE PARK
MANAGER'S RESIDENCE

SHEET
NO. 2
OF 7

PLAN NO.
A-104