


DESIGNED BY	DATE	REVIEWED	DATE	APPROVED	DATE	NO.	DATE	BY	REVISIONS	DATE	BY
JACK A. DREW ASSOC., INC.		ARCHITECTURAL				1			4		
LANDSCAPE		ENGINEERING				2			5		
LANSING, MICHIGAN		LANDSCAPE				3			6		

SHEET NO.	DESCRIPTION
1	COVER SHEET
2	PROJECT DESCRIPTION PLAN
3	DIMENSION PLAN MAIN PARK DRIVE
4	DIMENSION PLAN MAIN PARK DRIVE
5	DIMENSION PLAN NORTH CAMP CLUSTER
6	DIMENSION PLAN SOUTH CAMP CLUSTER
7	GRADING PLAN MAIN PARK DRIVE
8	GRADING PLAN MAIN PARK DRIVE
9	PROFILE PLAN MAIN PARK DRIVE
10	GRADING PLAN NORTH CAMP CLUSTER
11	GRADING PLAN SOUTH CAMP CLUSTER
12, 13, 14, 15, 16	SECTIONS
17	DETAIL SHEET
18	SEWER PROFILES
19	MECHANICAL UTILITIES
20	SANITATION STATION & DETAILS
21	WET WELL & DETAILS
22	SEWAGE LAGOON & MECHANICAL DETAILS
23	ELECTRICAL UTILITIES
24	ELECTRICAL DETAILS


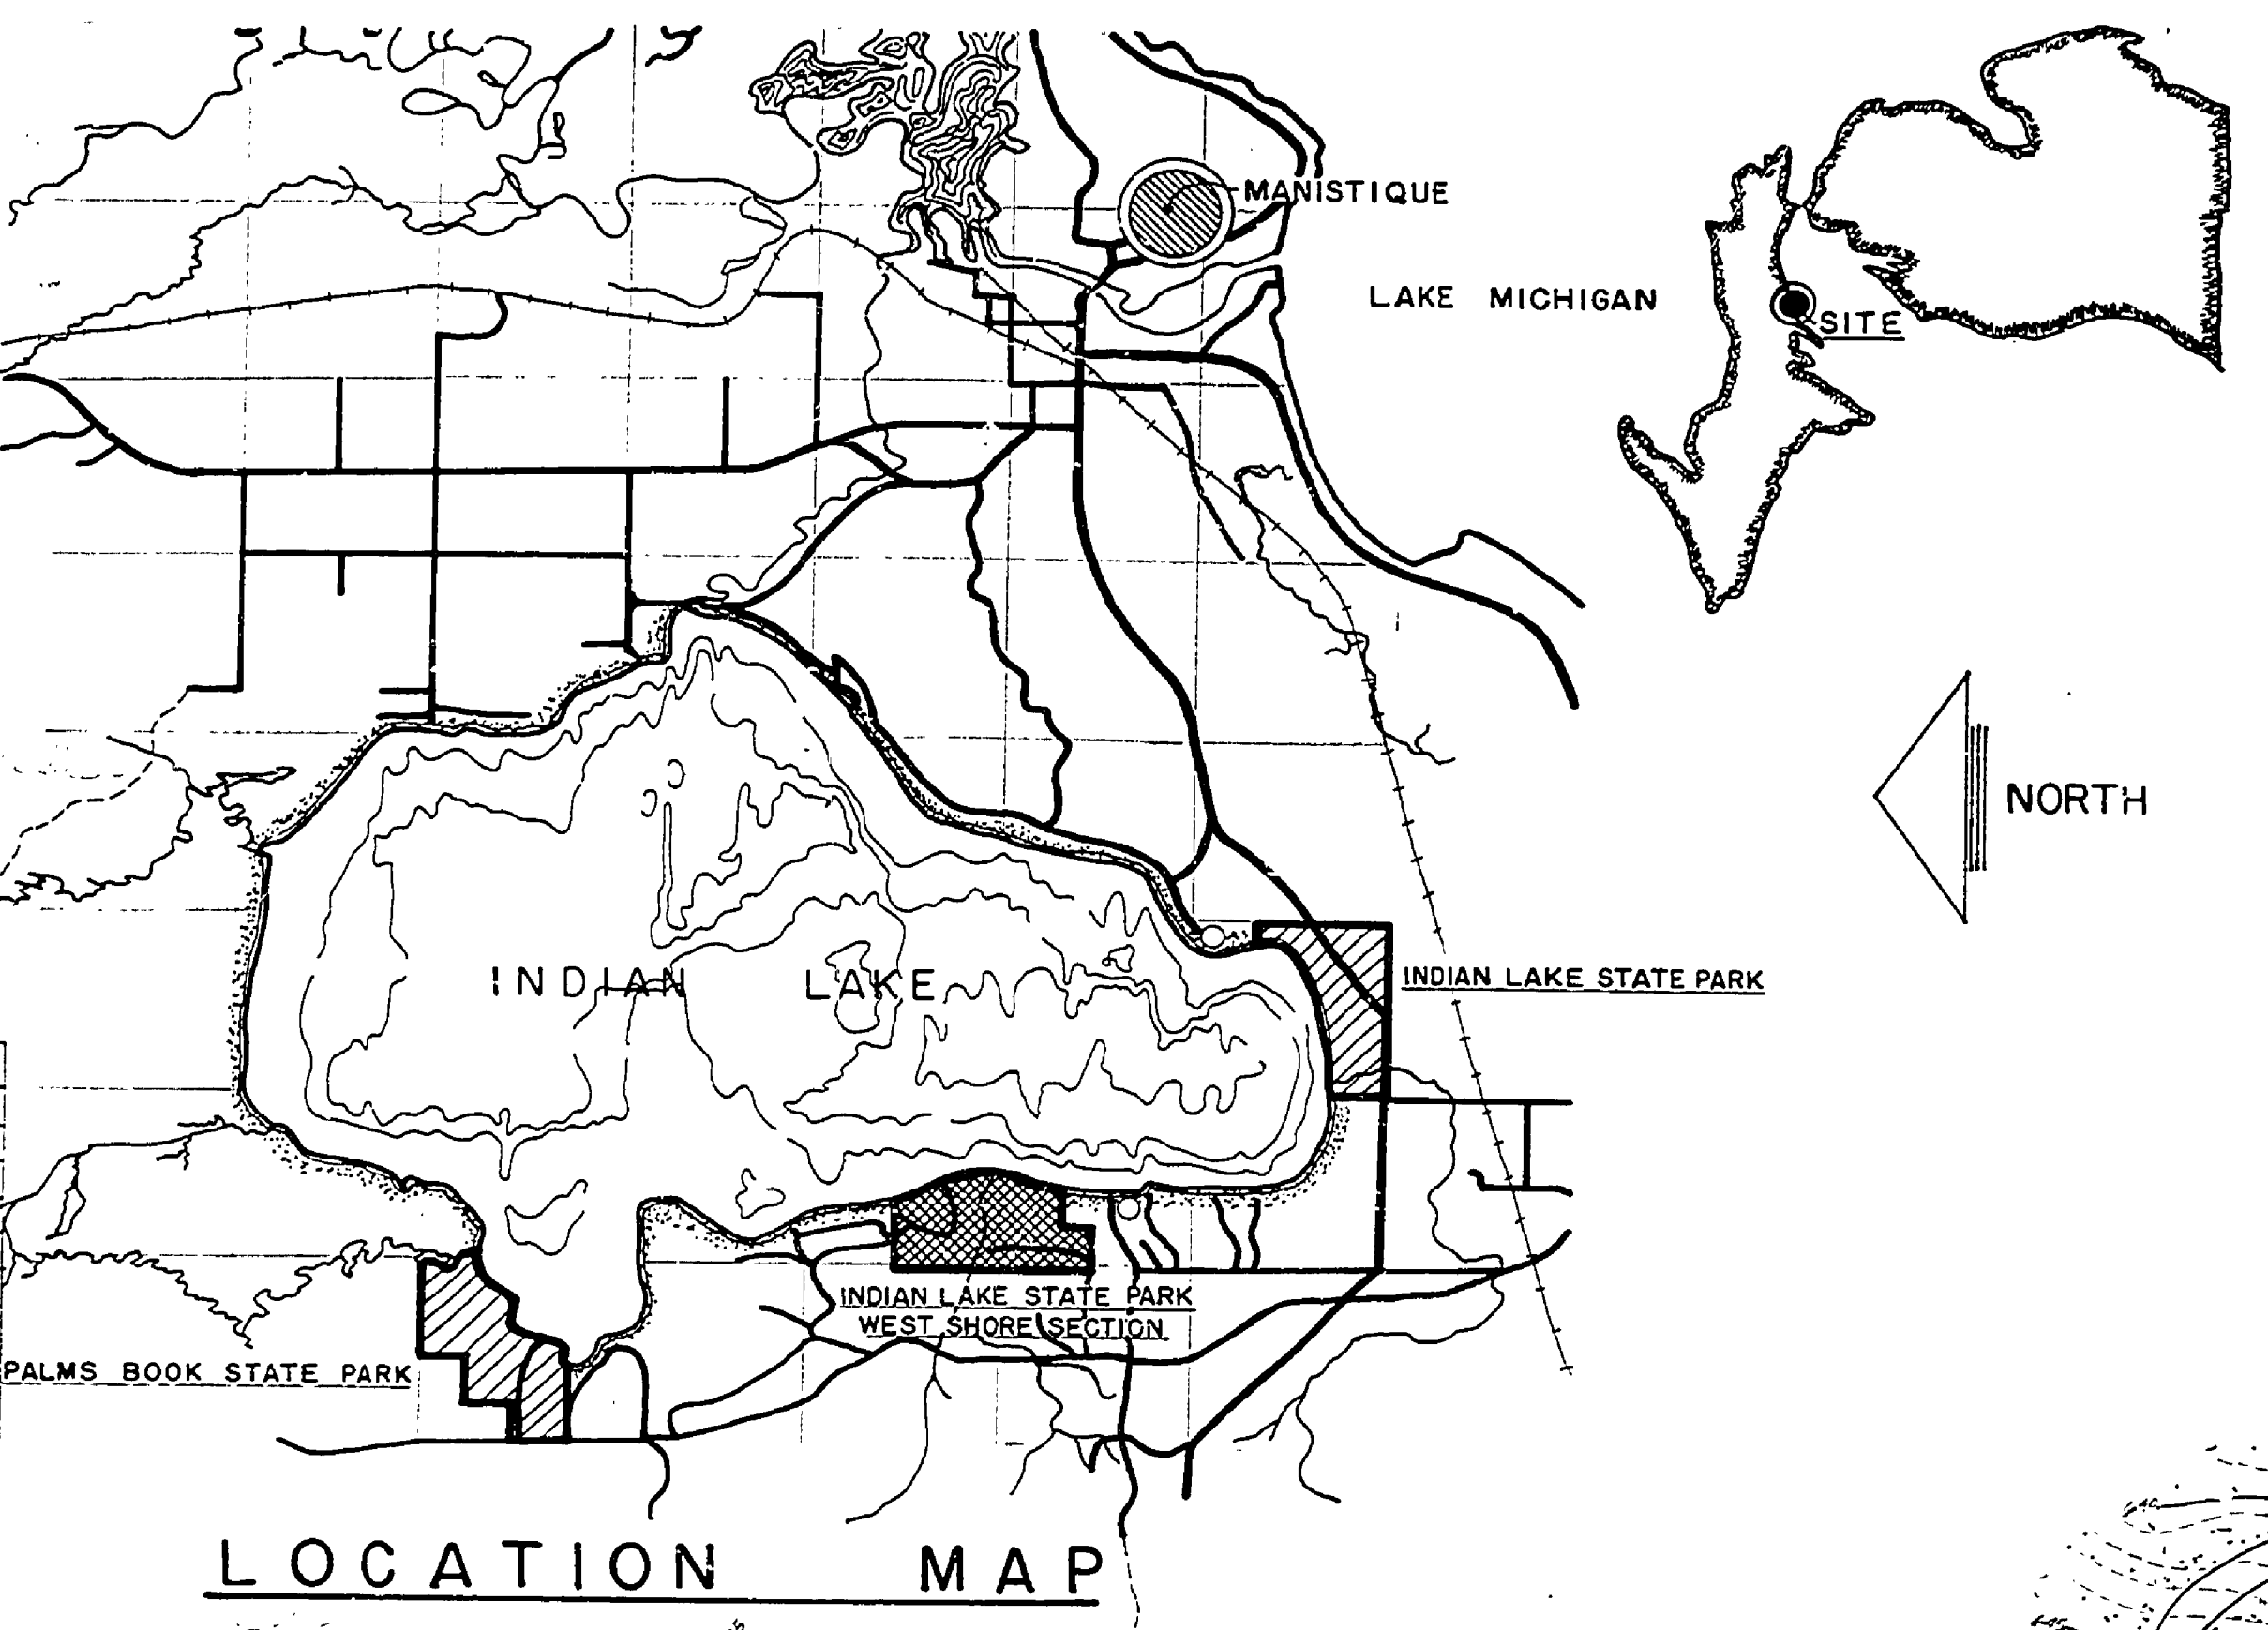


MICHIGAN DEPARTMENT OF CONSERVATION
SECTION OF PARKS AND RECREATION

INDIAN LAKE STATE PARK WEST SHORE SECTION

CONSTRUCTION PLANS FOR
CAMPGROUND DEVELOPMENT

PROJECT NO. PR67-258-300-003-C2

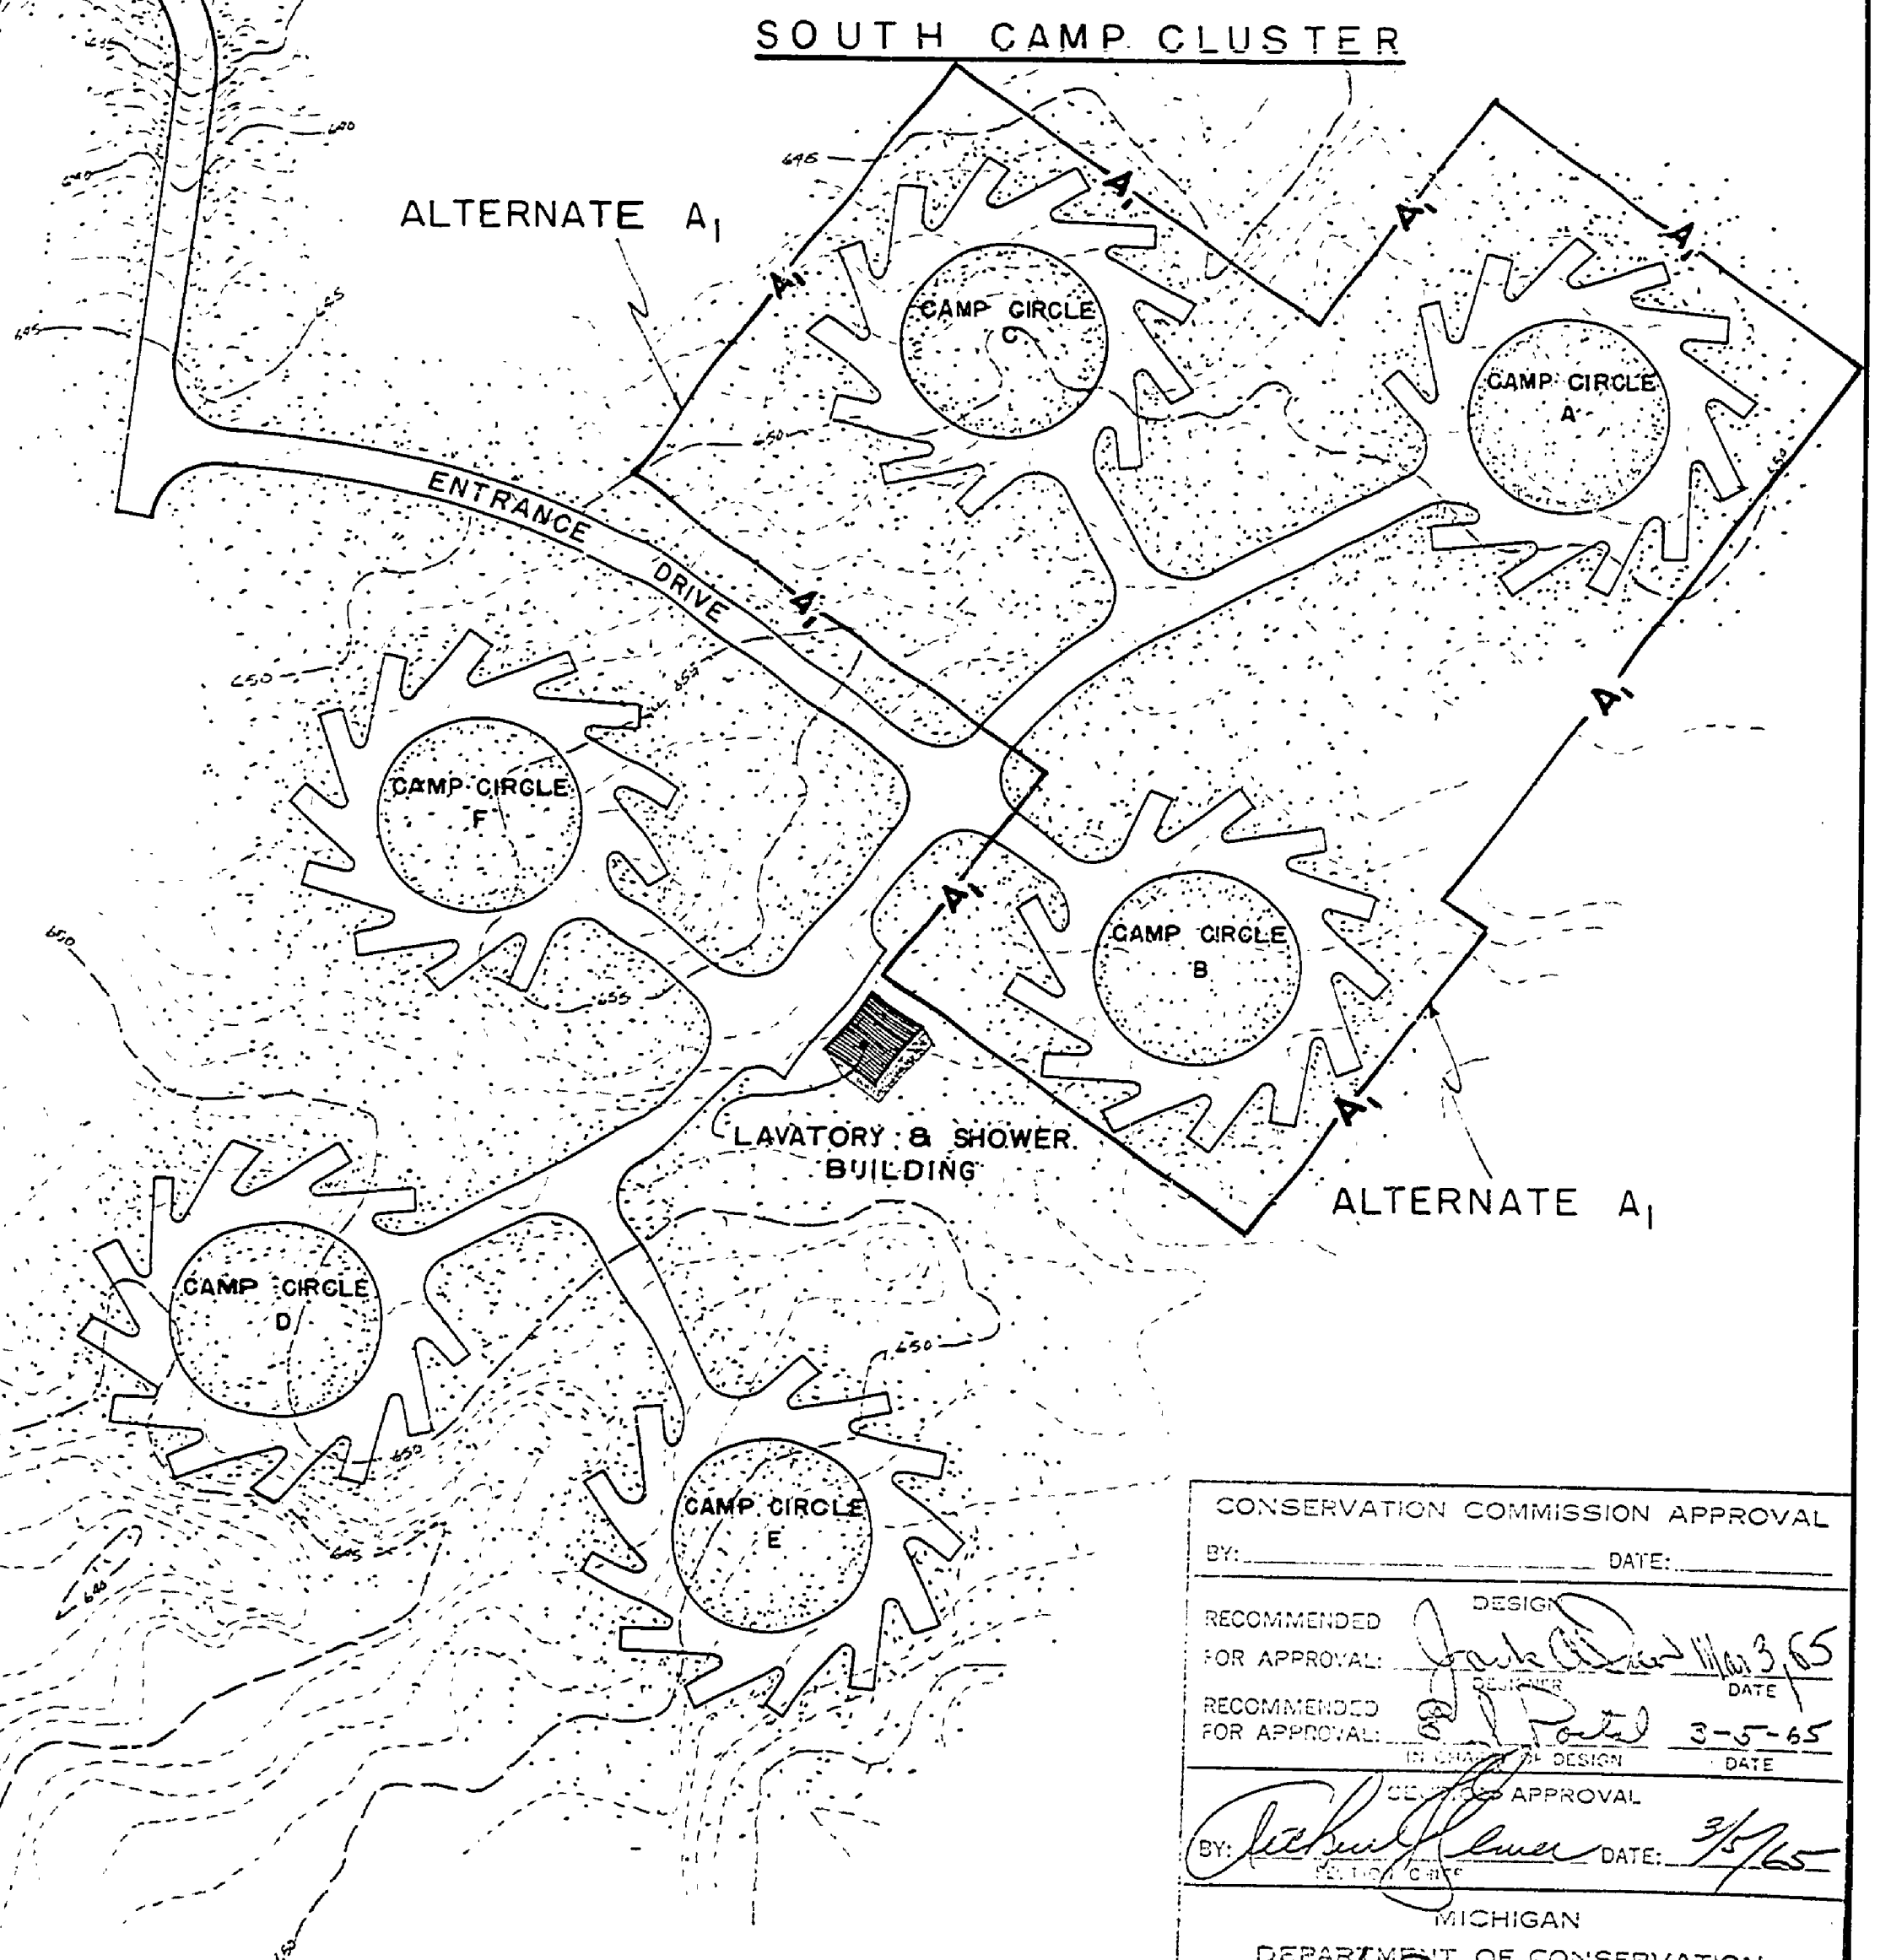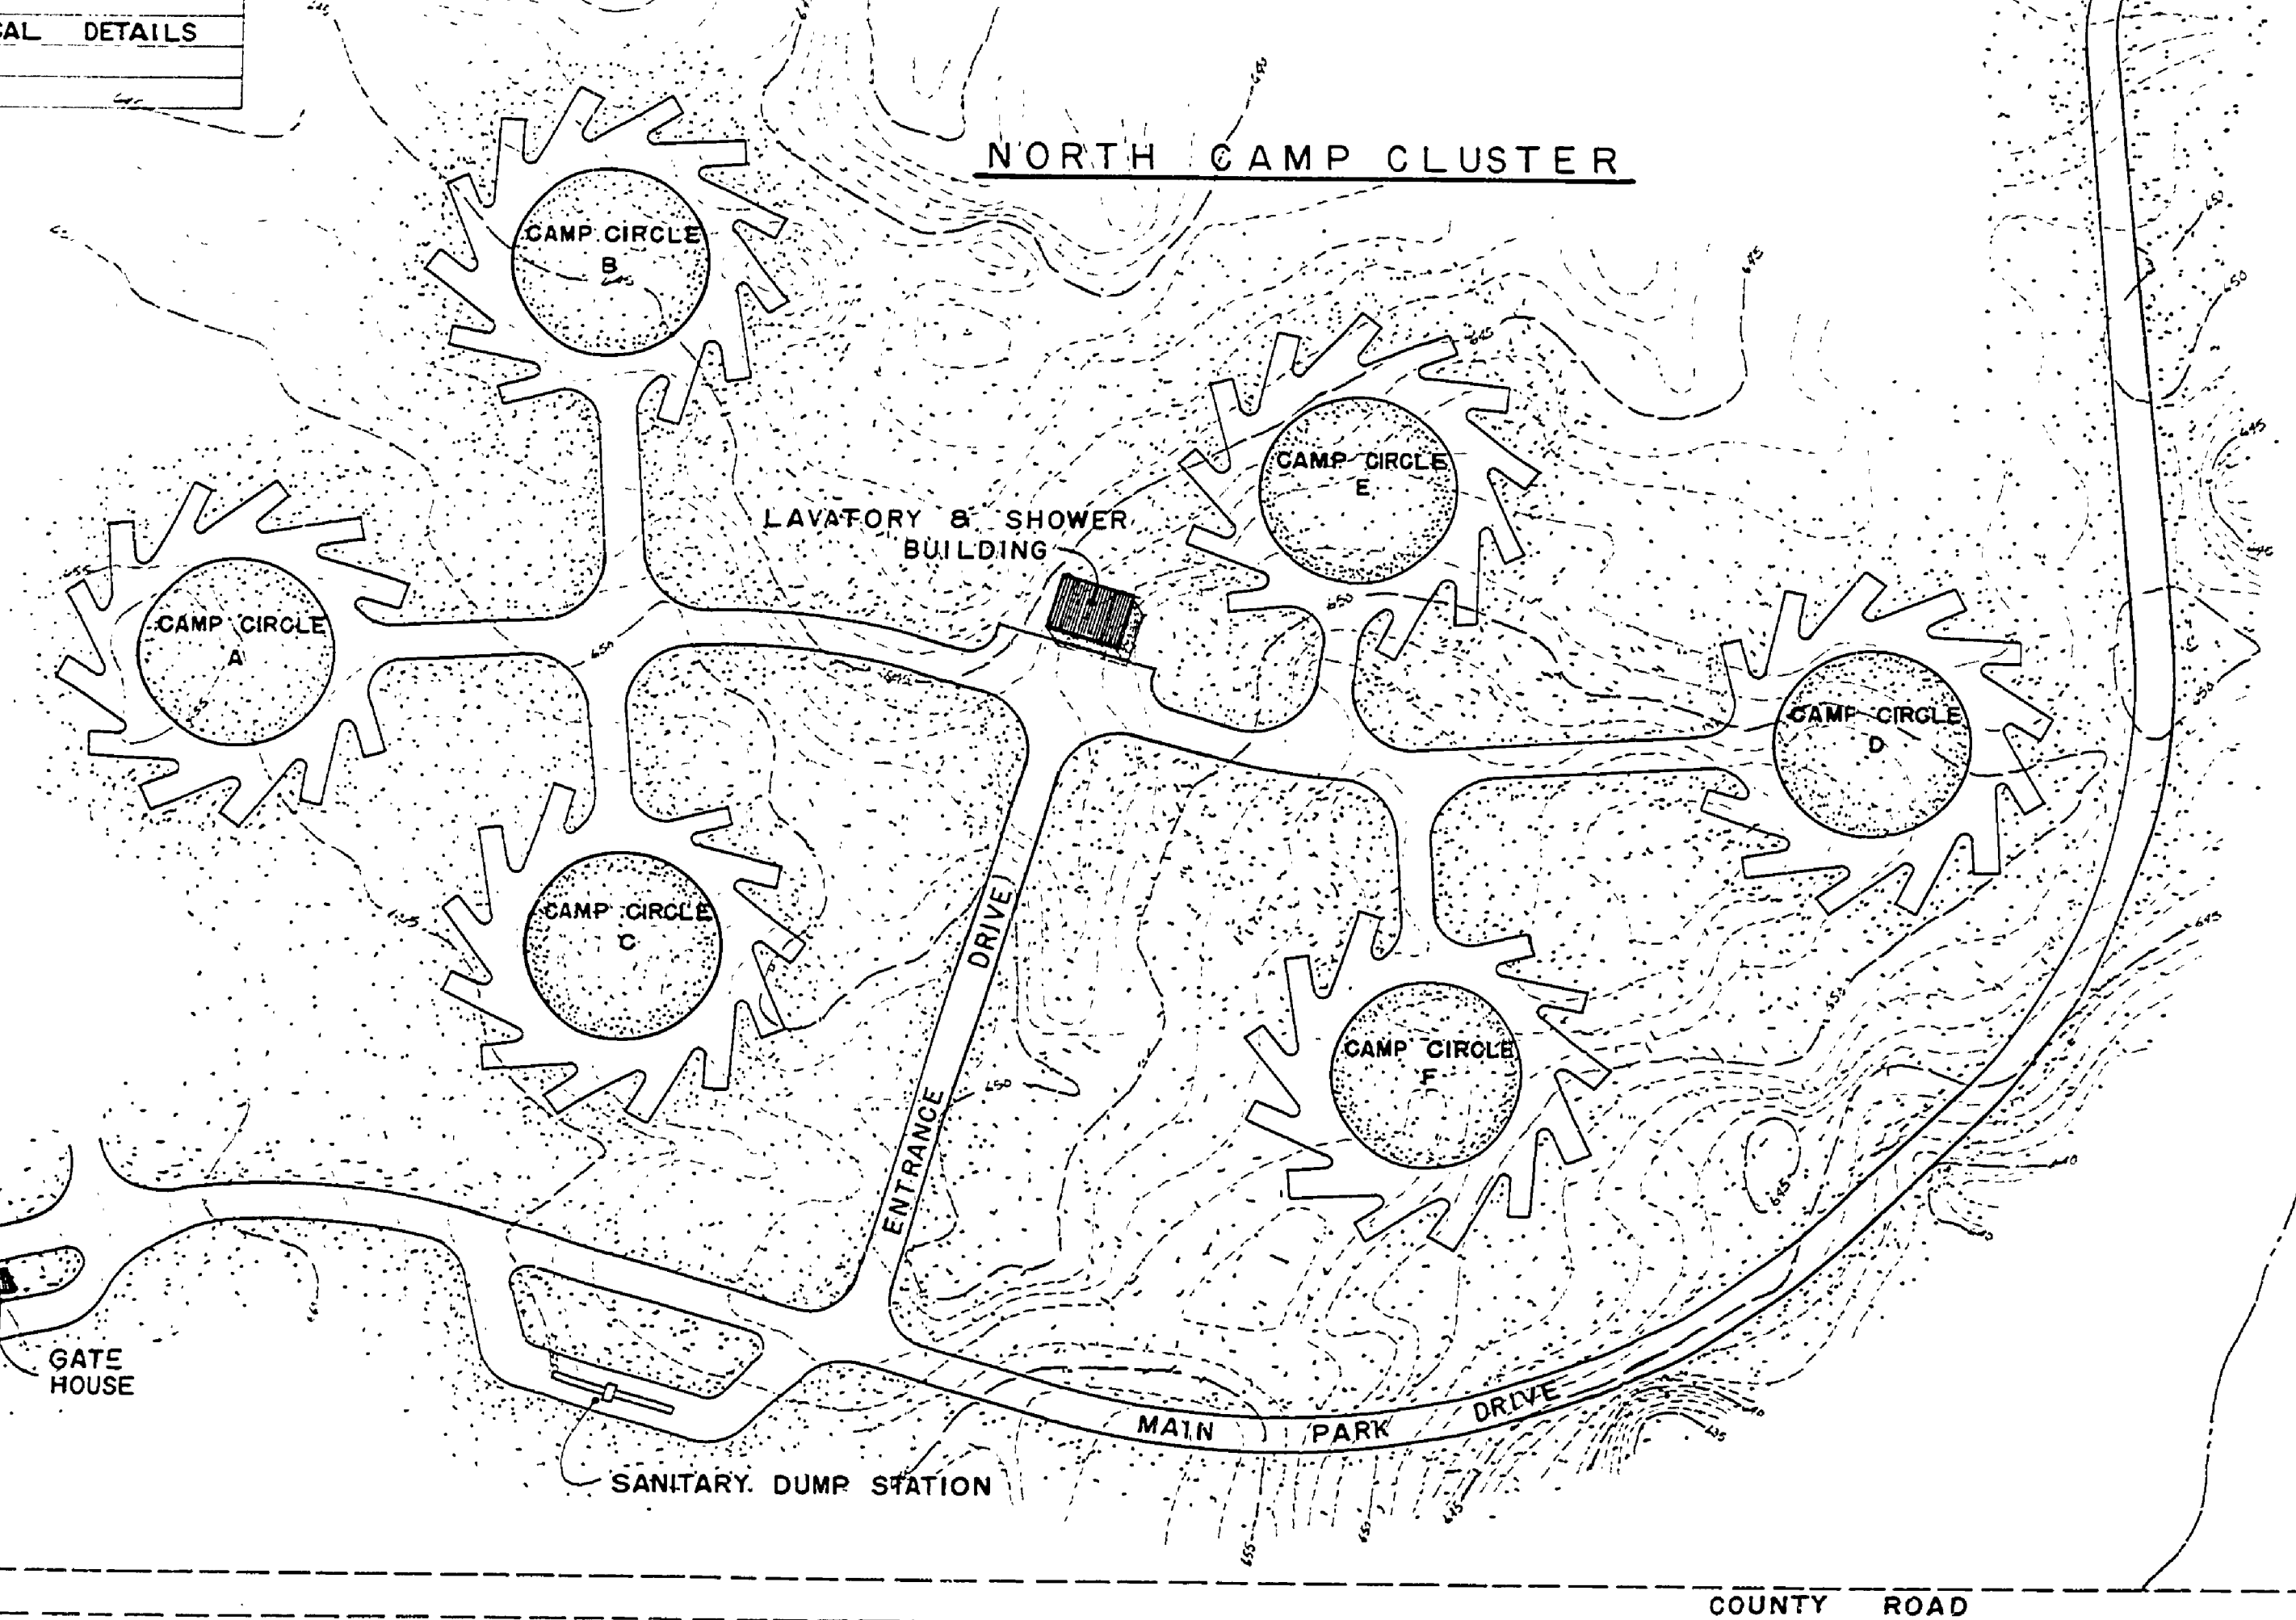

CONSERVATION COMMISSION APPROVAL	
BY: _____	DATE: _____
RECOMMENDED FOR APPROVAL: _____	DATE: 3-5-65
RECOMMENDED FOR APPROVAL: _____	DATE: 3-5-65
BY: _____	DATE: 3/5/65
MICHIGAN DEPARTMENT OF CONSERVATION	
APPROVED: _____	DATE: 3-5-65
PLAN NO. _____	PROJECT NUMBER _____
SHEET _____	OF _____

BENCH MARK TO HEMLOCK ELEV 660.79 - 30' W. & OF CO. RD. APP. 200' S. OF TRAIL E. OF CO. RD. APP. 1000' N. OF CULVERT