




DESIGNED BY	DATE	REVIEWED	DATE	APPROVED	DATE	NO.	DATE	BY	REVISIONS	DATE	BY
DRAWN BY	1/1/47	ARCHITECTURAL				1			4		
CHECKED BY		ENGINEERING				2			5		
		LANDSCAPE				3			6		

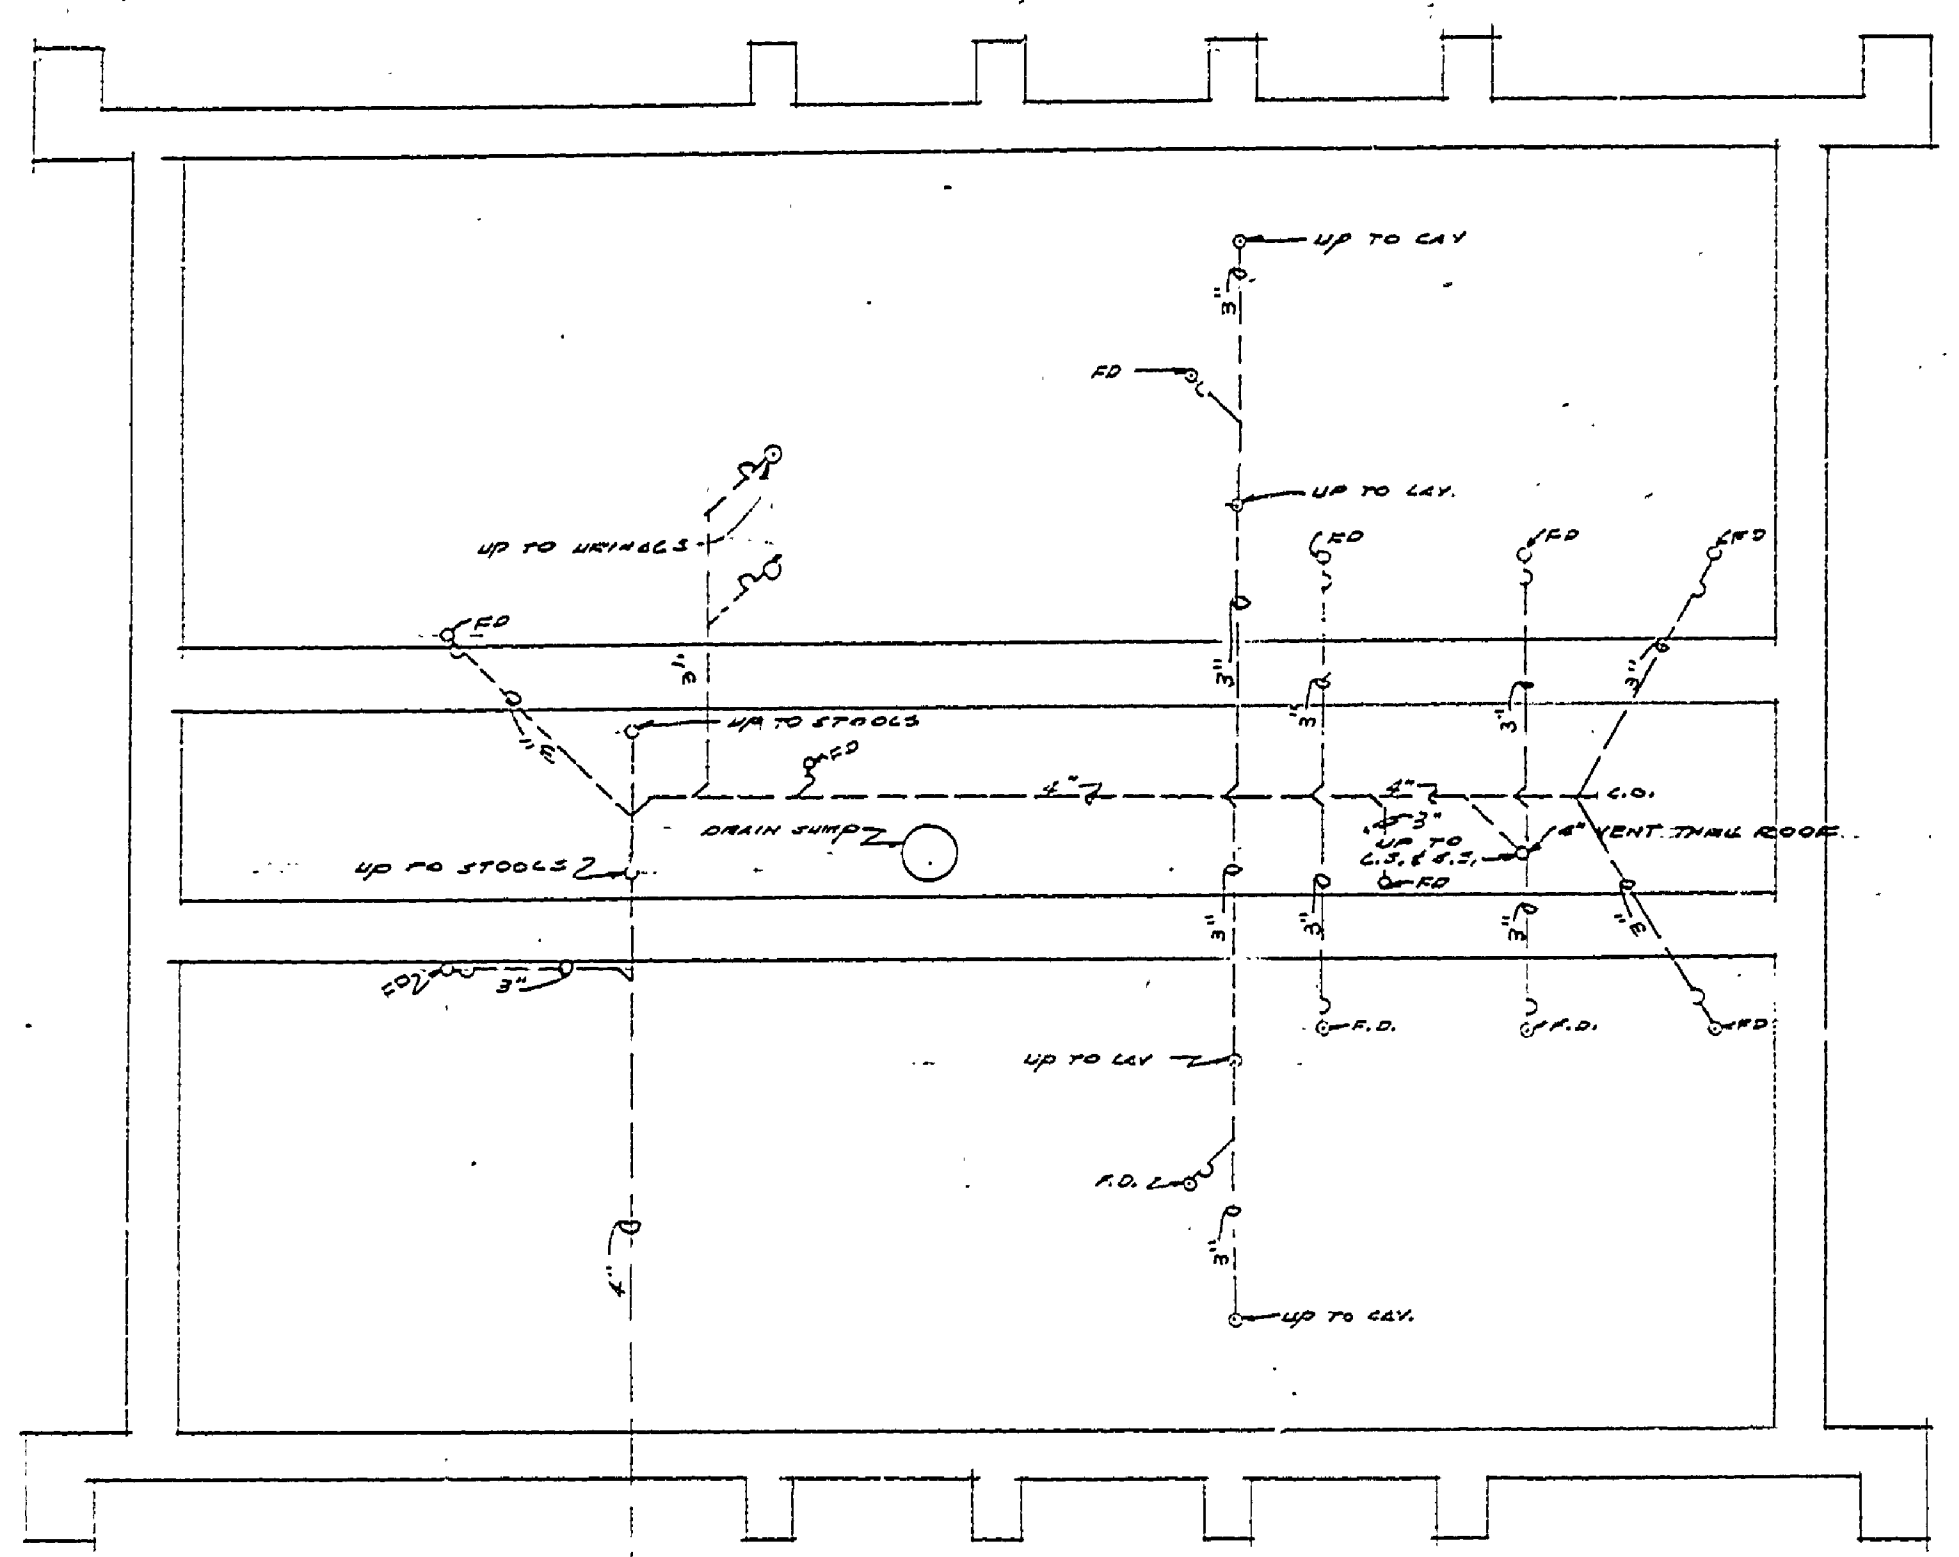


PLUMBING PLAN - UNDERGROUND WASTE

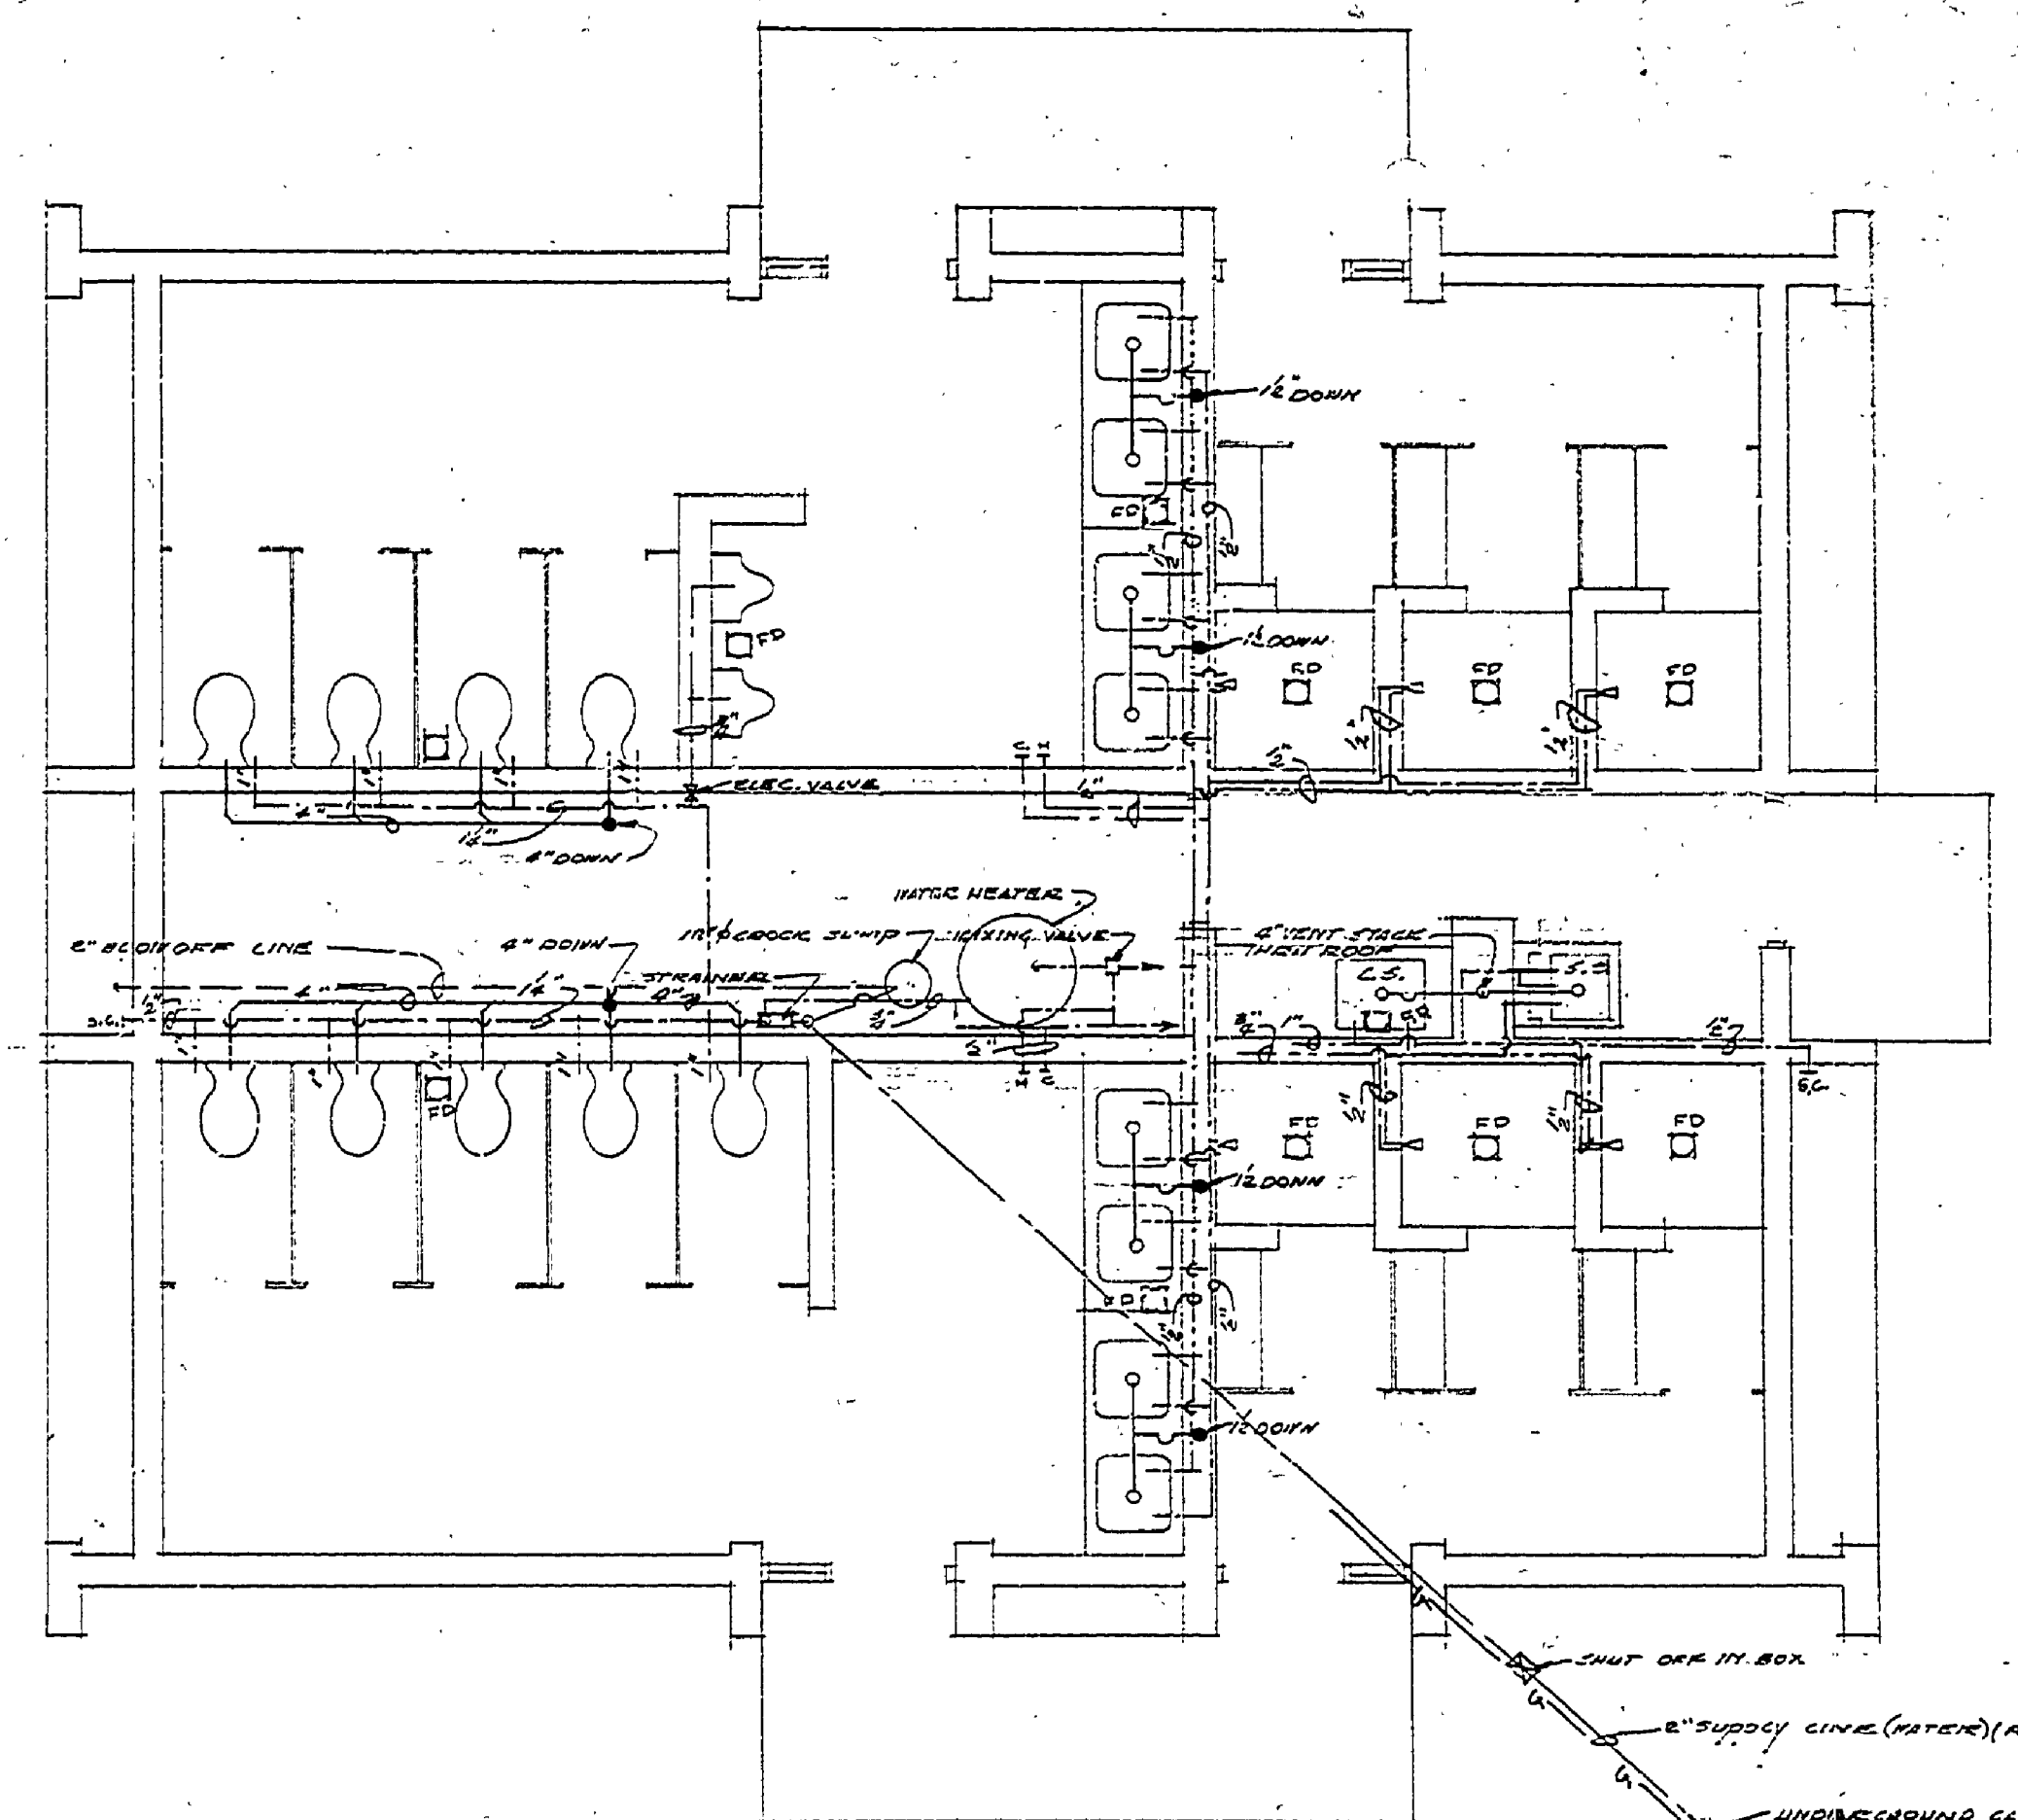


PLUMBING PLAN - ABOVE GROUND - WASTE & WATER

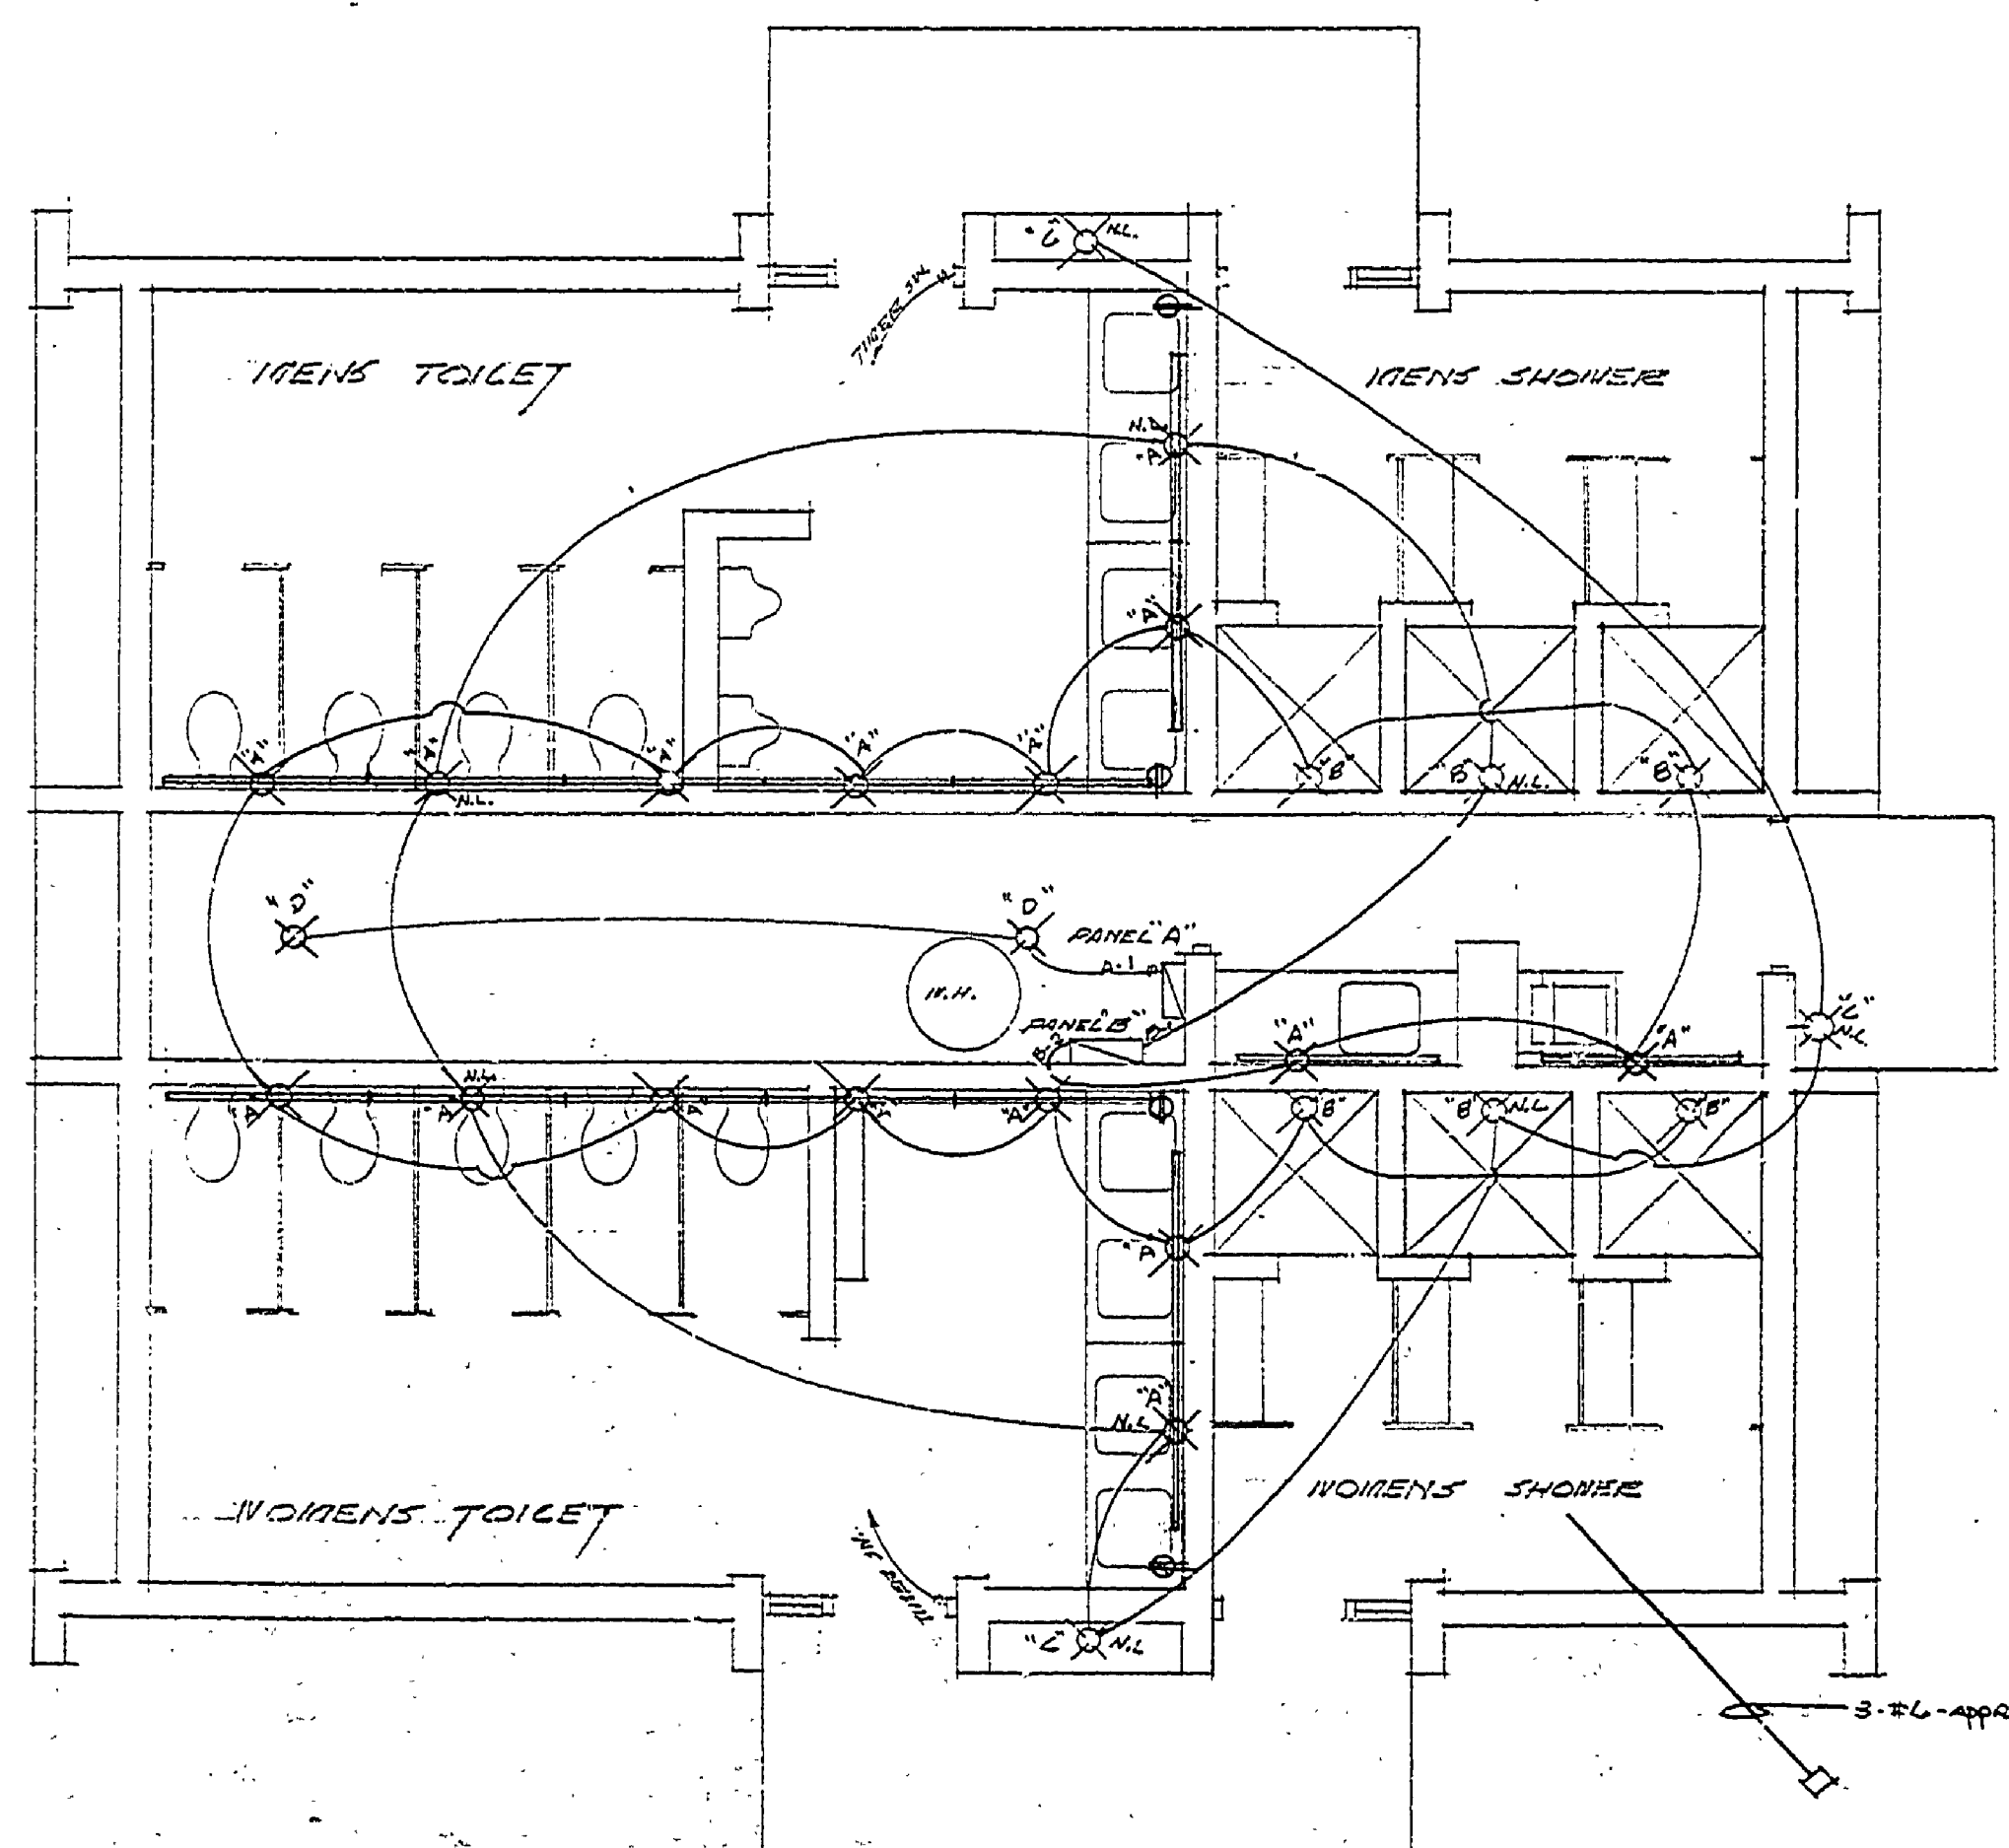

FLOOR PLAN - ELECTRICAL

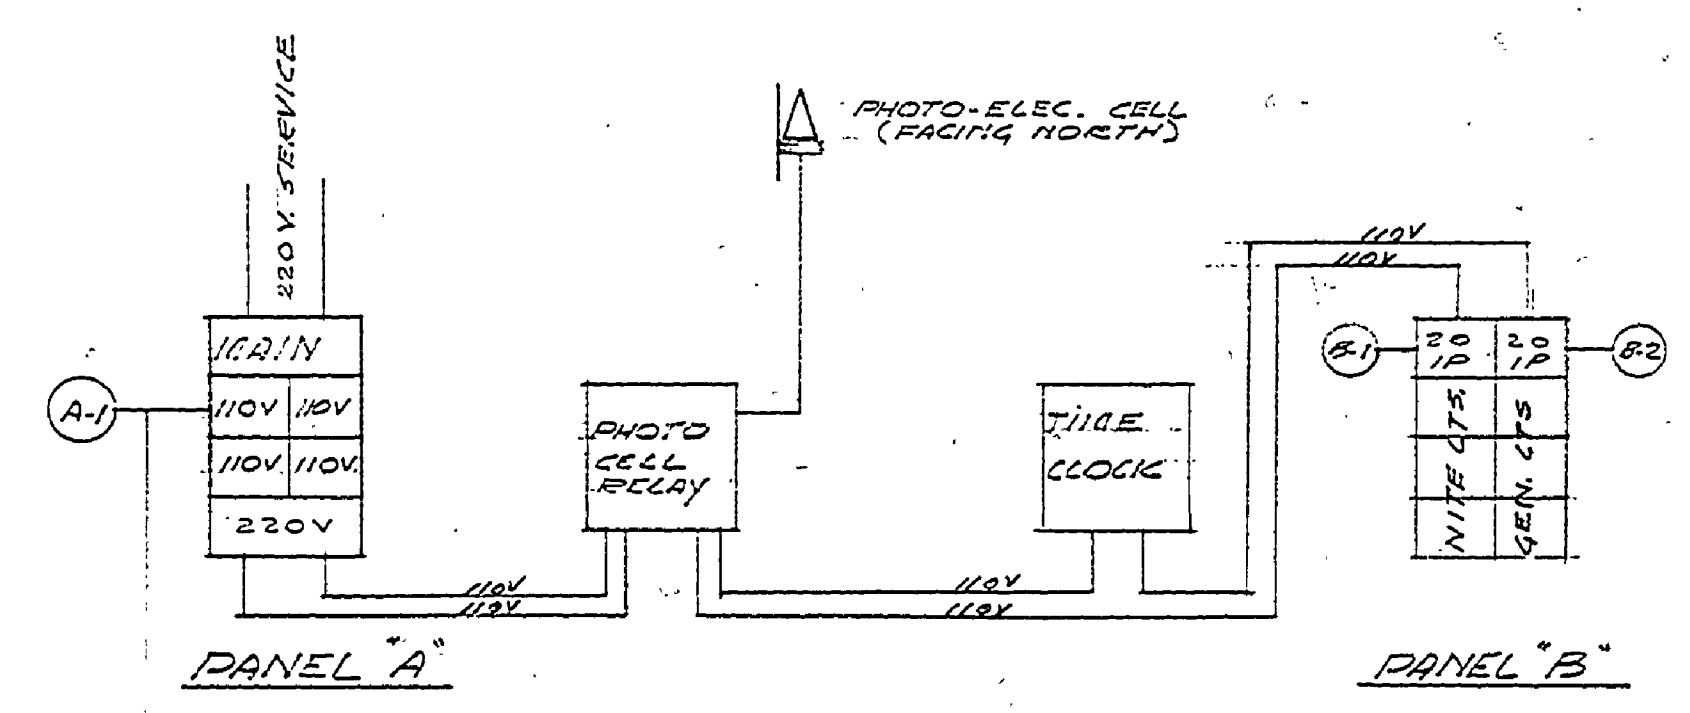

SCHEMATIC WIRING DIAGRAM

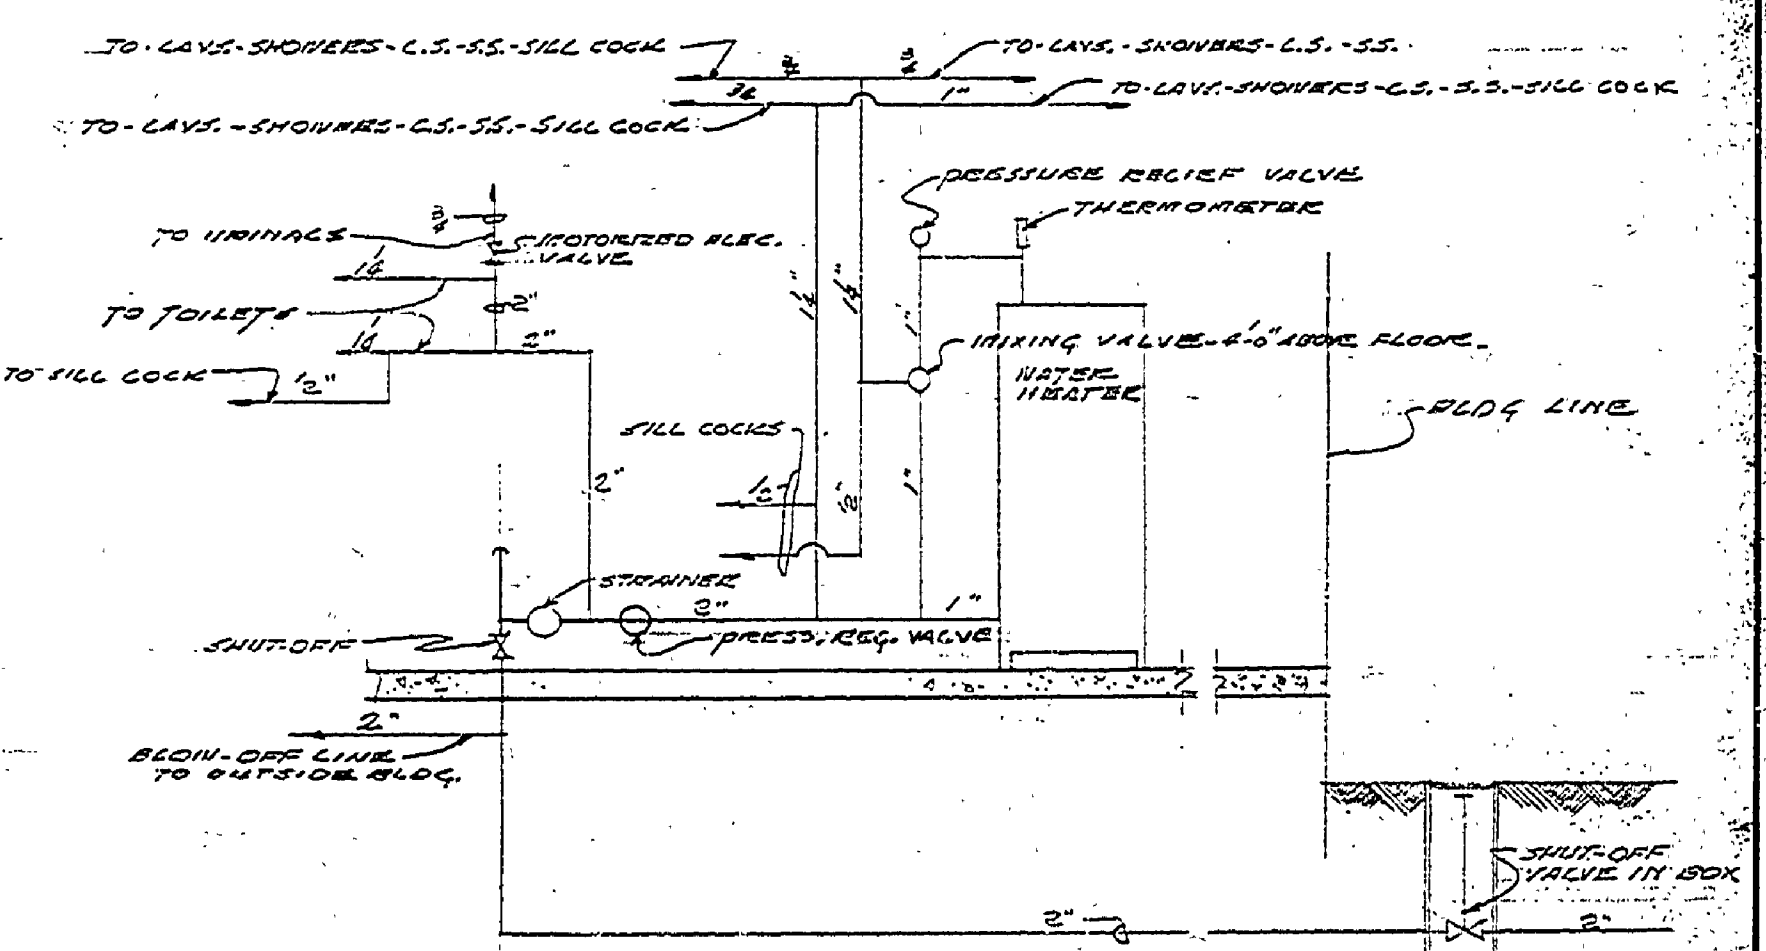

PLUMBING DIAGRAM - WATER

MICHIGAN
DEPARTMENT OF CONSERVATION
PARKS AND RECREATION DIVISION

TOILET - SHOWER BLDG
MEARS STATE PARK

SHEET NO. 4 OF 4
PLAN NO. A-102