


MEARS STATE PARK BEACHHOUSE

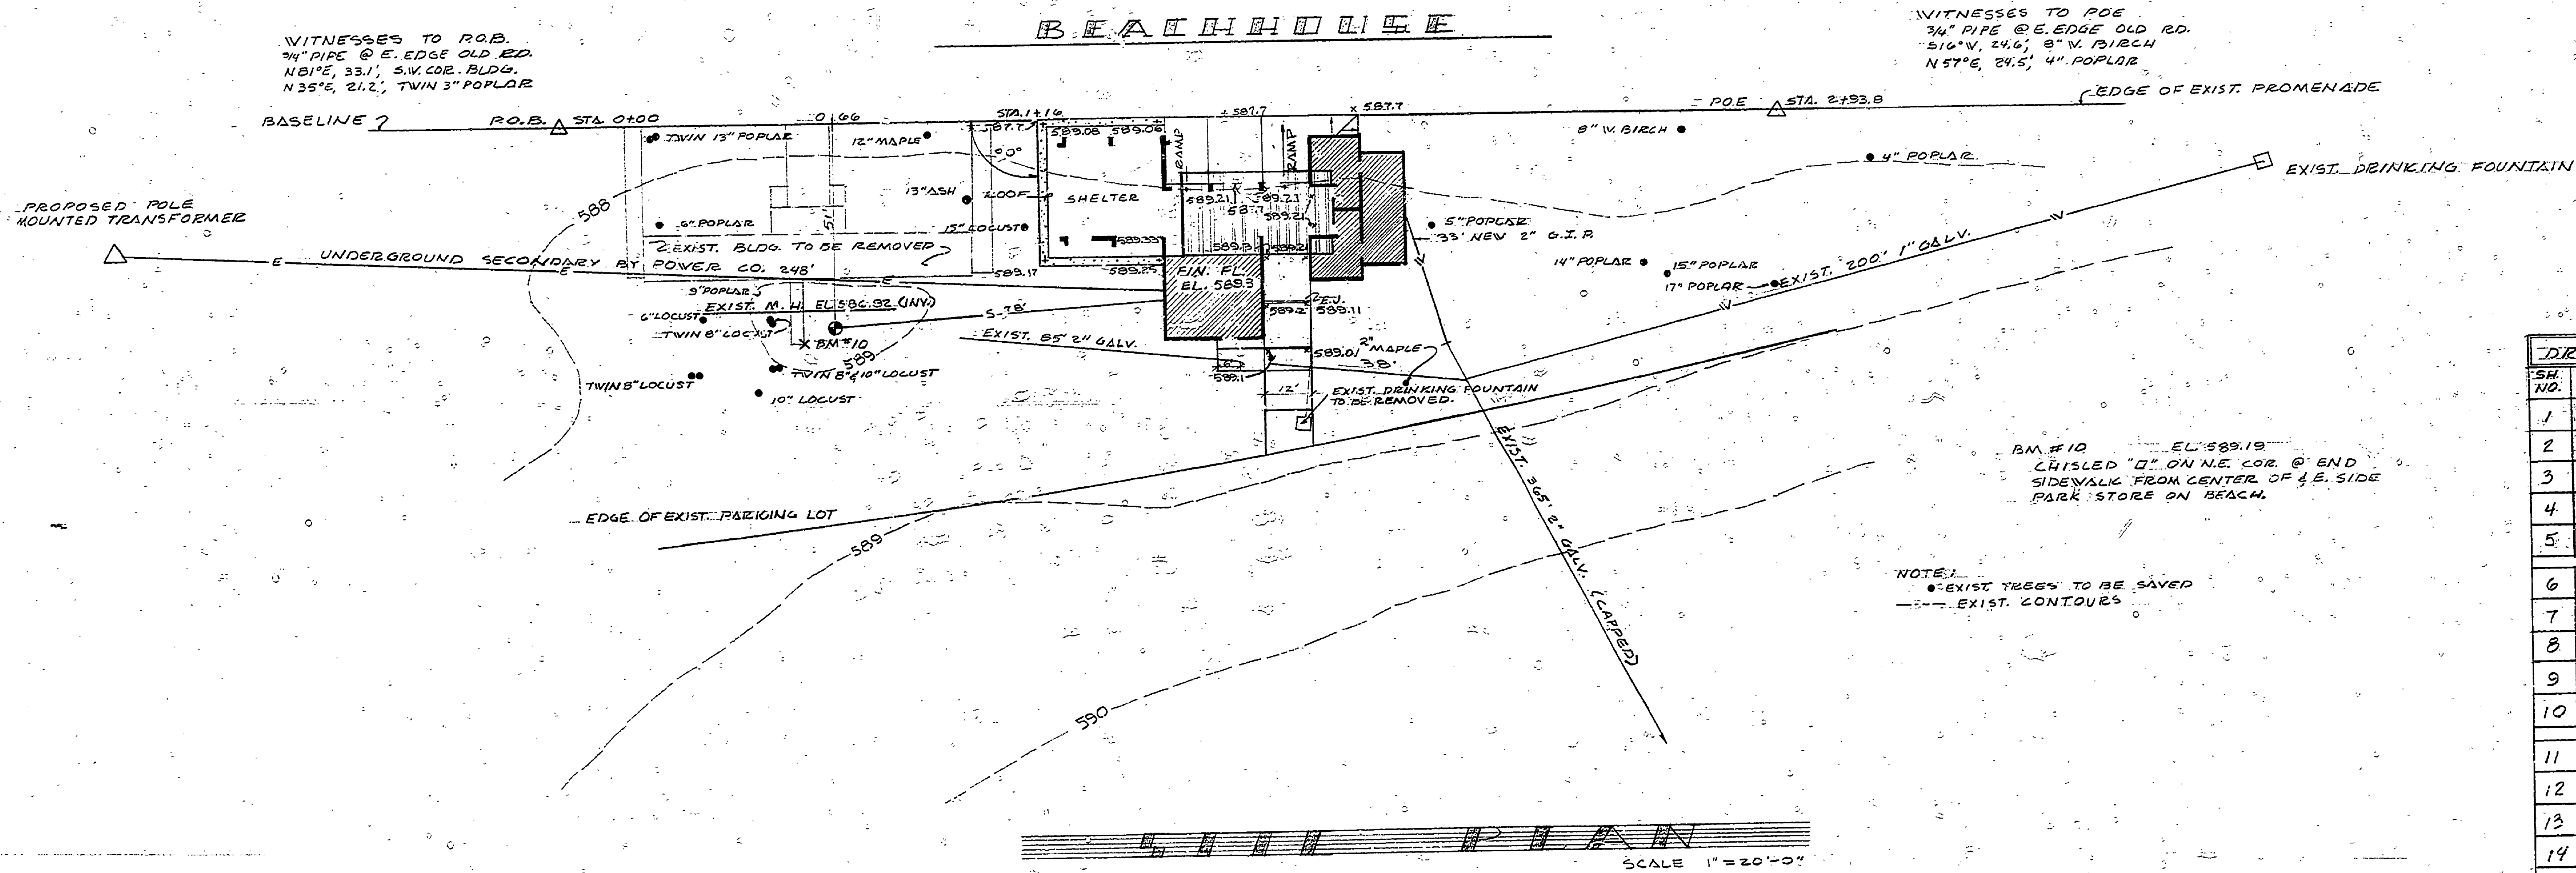

DRAWING SCHEDULE	
SH. NO.	DESCRIPTION
1	TITLE SHEET & SITE PLAN
2	FOUNDATION & UNDERGROUND PLUMBING PLAN & DETAILS
3	FLOOR PLAN, SCHEDULES & DETAILS
4	ROOF & LATTICE FRAMING PLAN & DETAILS
5	ELEVATIONS
6	SECTIONS & DETAILS
7	DETAILS
8	MECHANICAL - DUCTS, EXHAUST
9	SUPPLY PLUMBING
10	ELECTRICAL & ABOVEGROUND SANITARY PLUMBING
11	
12	
13	
14	
15	

BUILDING COMMITTEE APPROVAL
 BY: *[Signature]* CHAIRMAN DATE: 2-8-72
 RECOMMENDED FOR APPROVAL: V.N.C. 1-20-72
 ENGINEERING OR ARCHITECTURAL SUPERVISOR DATE
 RECOMMENDED FOR APPROVAL: R.P.P. 1-21-72
 PROGRAM AND PLAN COORDINATOR DATE
 DIVISION/REGION APPROVAL
 BY: *[Signature]* 2-4-72
 DIVISION CHIEF/REGIONAL MANAGER DATE
 ENGINEERING DIVISION
 APPROVED: *[Signature]* 2-5-72
 CHIEF ENGINEER DATE

SURVEYED BY		DRAWN BY G. TOMPKINS		NO. DATE BY REVISIONS		NO. DATE BY REVISIONS		MICHIGAN DEPARTMENT OF NATURAL RESOURCES		TITLE SHEET & SITE PLAN SHEET TITLE		MEARS STATE PARK AREA OR PARK PROJECT BEACHHOUSE		PROJECT NO. 24-1230	
DESIGNED BY		CHECKED BY		DATE		DATE		SHEET 1 OF 10		PLAN NO. A-103					