


DESIGNED BY	WUC	DATE	10-15-62	APPROVED		DATE	10-15-62	REVIEWED	W.M.G.	DATE	10-15-62
DRAWN BY	WUC	ARCHITECTURAL	10-15-62								
CHECKED BY	WUC	ENGINEERING	10-15-62								
		LANDSCAPE	10-15-62								

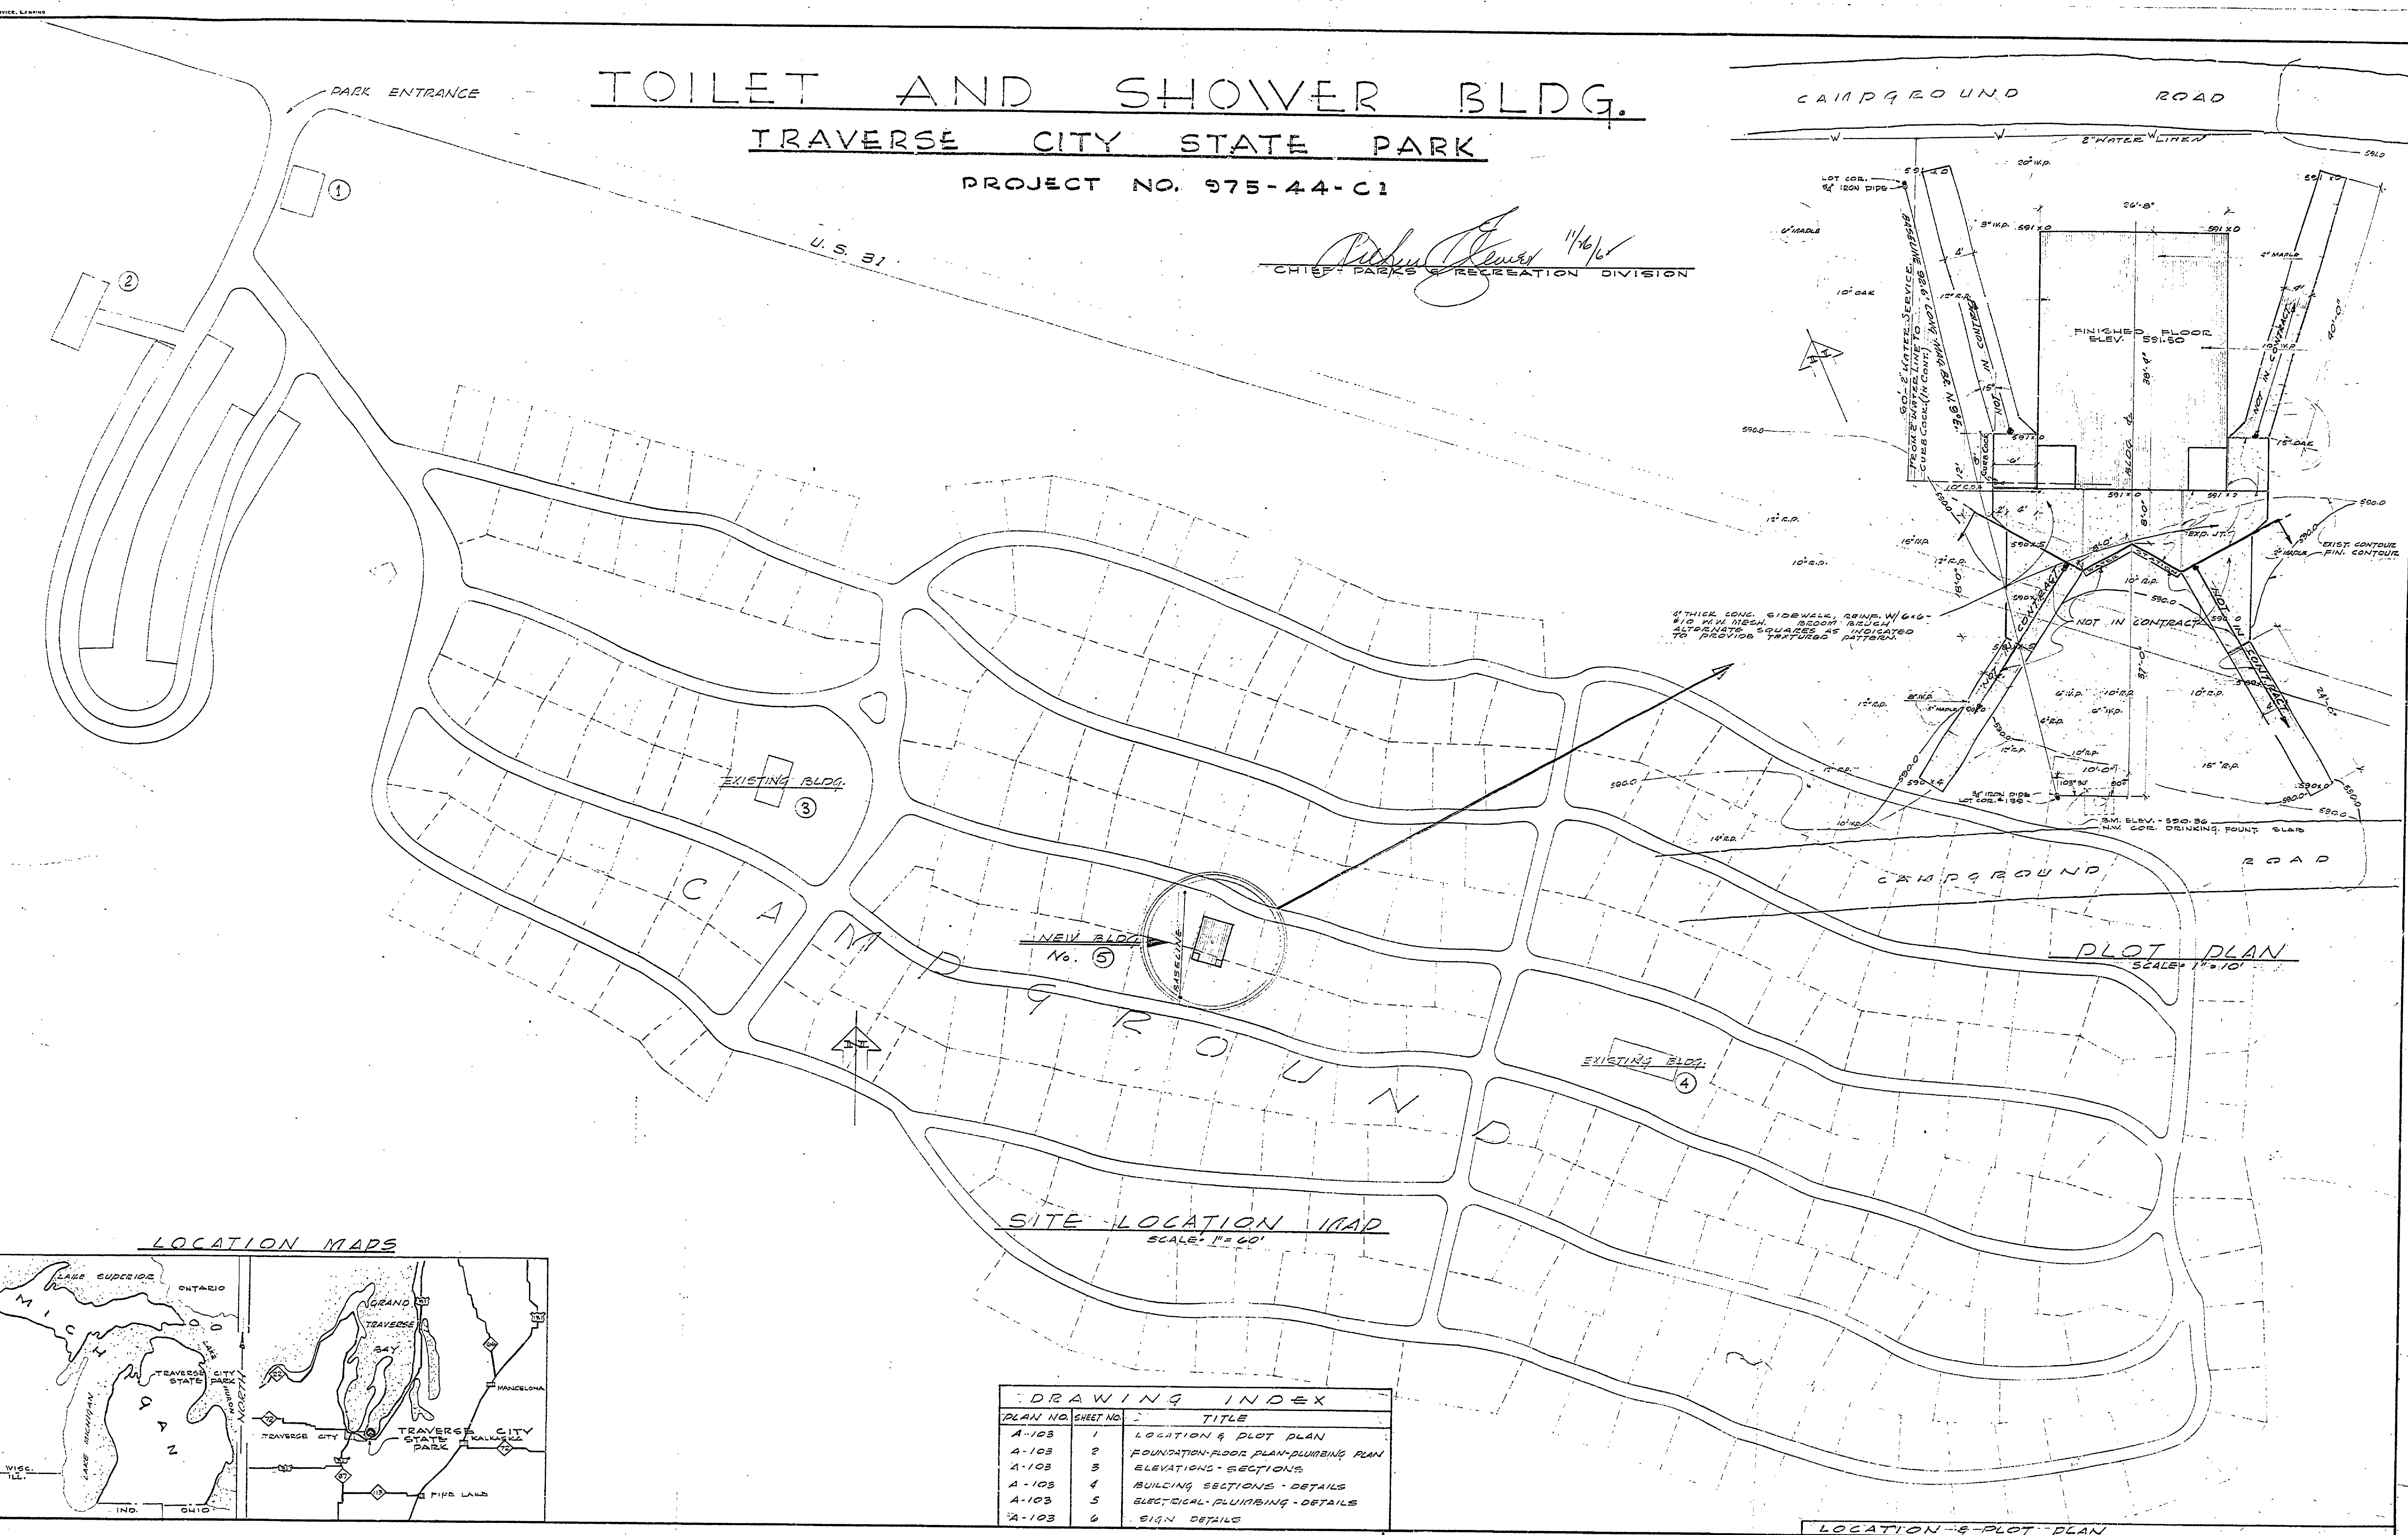

**TOILET AND SHOWER BLDG.**  
**TRAVERSE CITY STATE PARK**  
 PROJECT NO. 975-44-C1

*Richard Jones* 11/6/62  
 CHIEF, PARKS & RECREATION DIVISION

DRAWING INDEX		
PLAN NO.	SHEET NO.	TITLE
A-103	1	LOCATION & PLOT PLAN
A-103	2	FOUNDATION-FLOOR PLAN-PLUMBING PLAN
A-103	3	ELEVATIONS-SECTIONS
A-103	4	BUILDING SECTIONS-DETAILS
A-103	5	ELECTRICAL-PLUMBING-DETAILS
A-103	6	SIGN DETAILS