




PLUMBING PLAN  
Scale 1/8" = 1'-0"

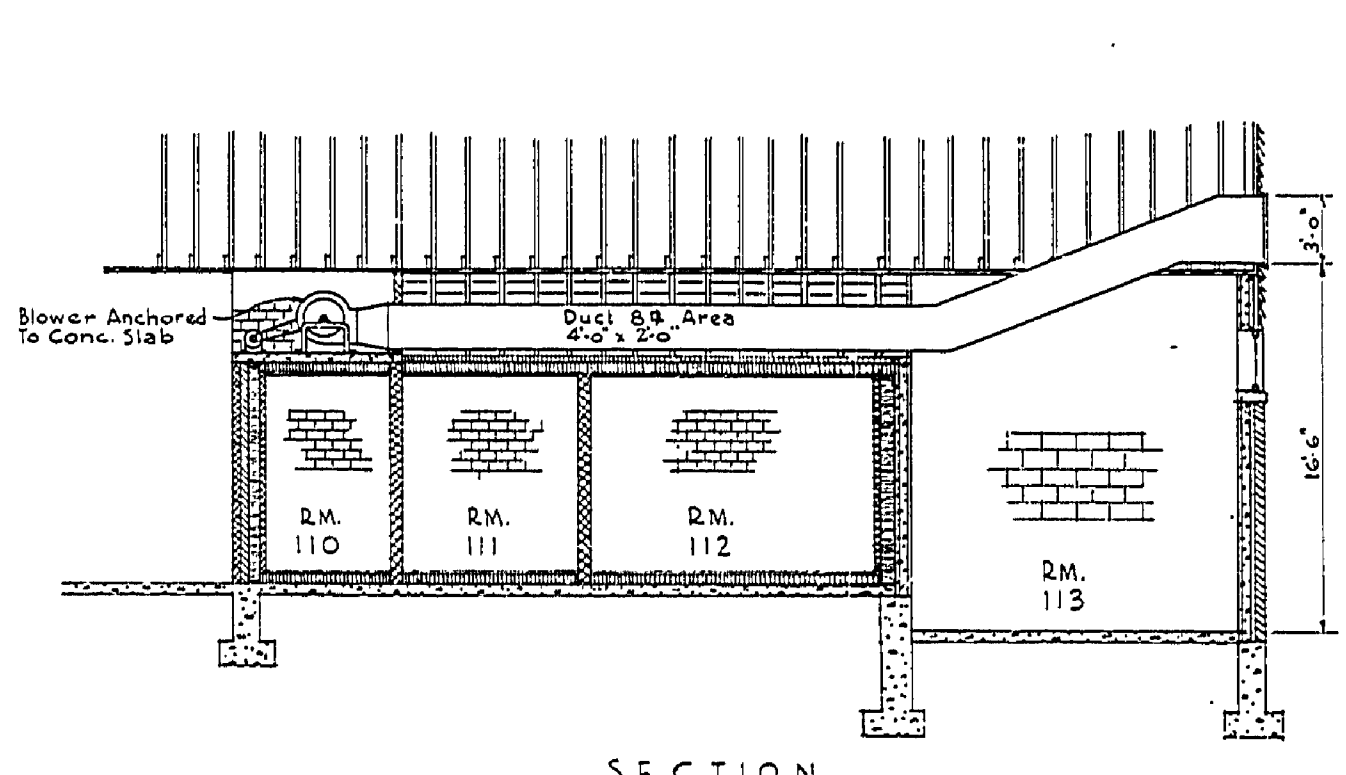

SECTION  
DETAIL OF KITCHEN FAN INSTALLATION  
Scale 1/8" = 1'-0"

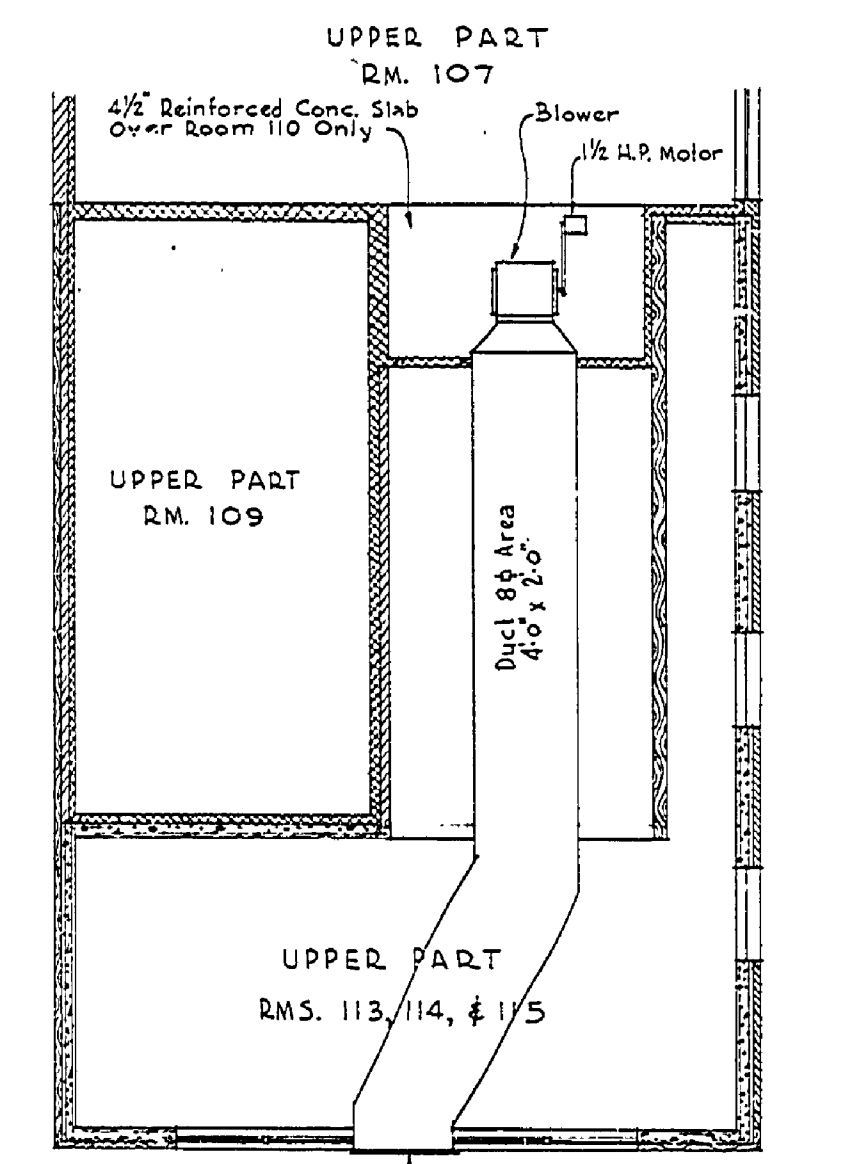

PLAN

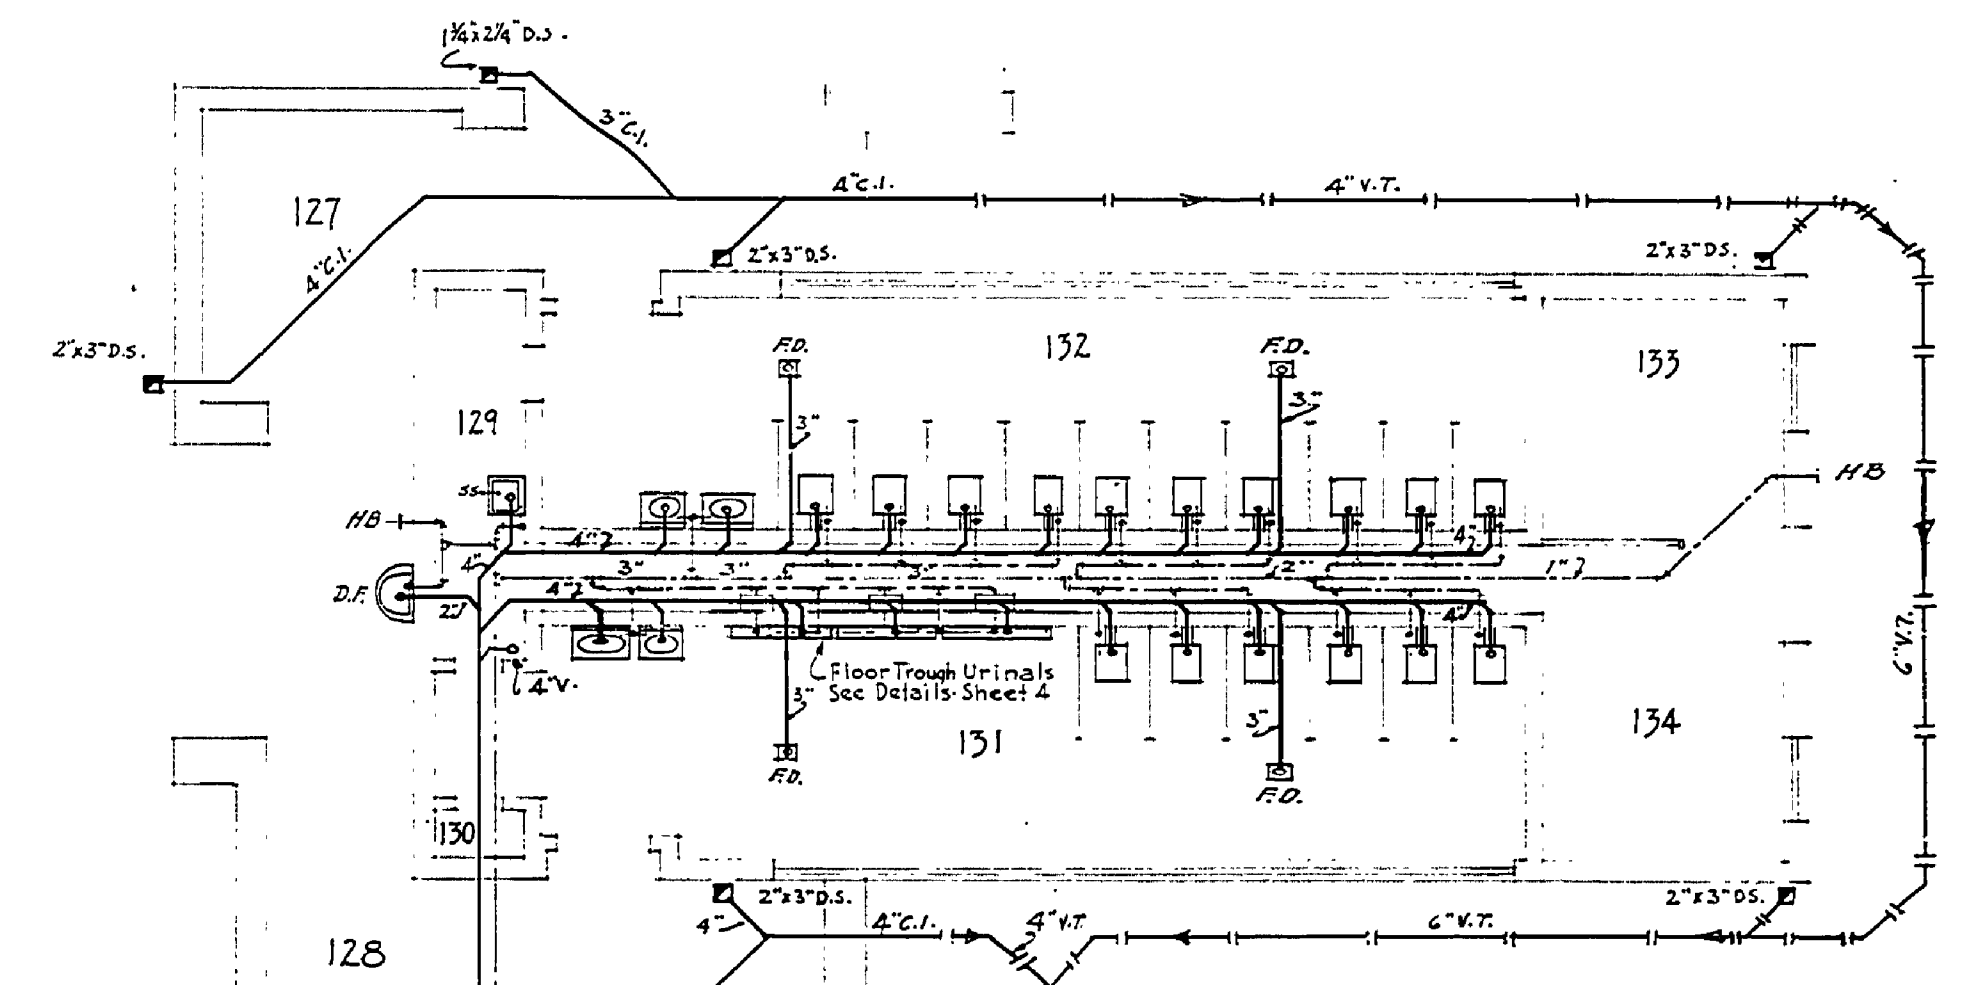

TYPICAL BRANCH MAIN TO W.C. FLUSH VALVES.

SYMBOLS

- CAST IRON SEWER
- VITRIFIED TILE SEWER
- COLD WATER PIPING
- REFRIGERANT PIPING
- HOSE BIBB
- FLOOR DRAIN

8" W.C. APPROX. 180' TO EXISTING 8" STORM SEWER

5" C.I. WATER SERVICE FROM BUILDING 5' MIN. APPROX. 400' FROM BLDG.

MICHIGAN CONSERVATION DEPARTMENT		PLUMBING PLAN	
PARKS DIVISION		BATH HOUSE, BAY CITY STATE PARK	
Architectural Section	REVIEW	Date	Lee Black & Kenneth C. Black, Architects, Lansing, Mich.
Engineering Section			Wm. W. Bradford, Mechanical Engineer - Grand Rapids, Mich...
Landscaping Arch. Sec.		Drawn K.C.B., Checked K.C.B.	Scale 1/8" = 1'-0"
Approved		Revisions	Job No. 4438
Asst. Chief in Charge of Design		Date	Sheet No. P-1
Division Chief		10-26-45	Section No. A1017