
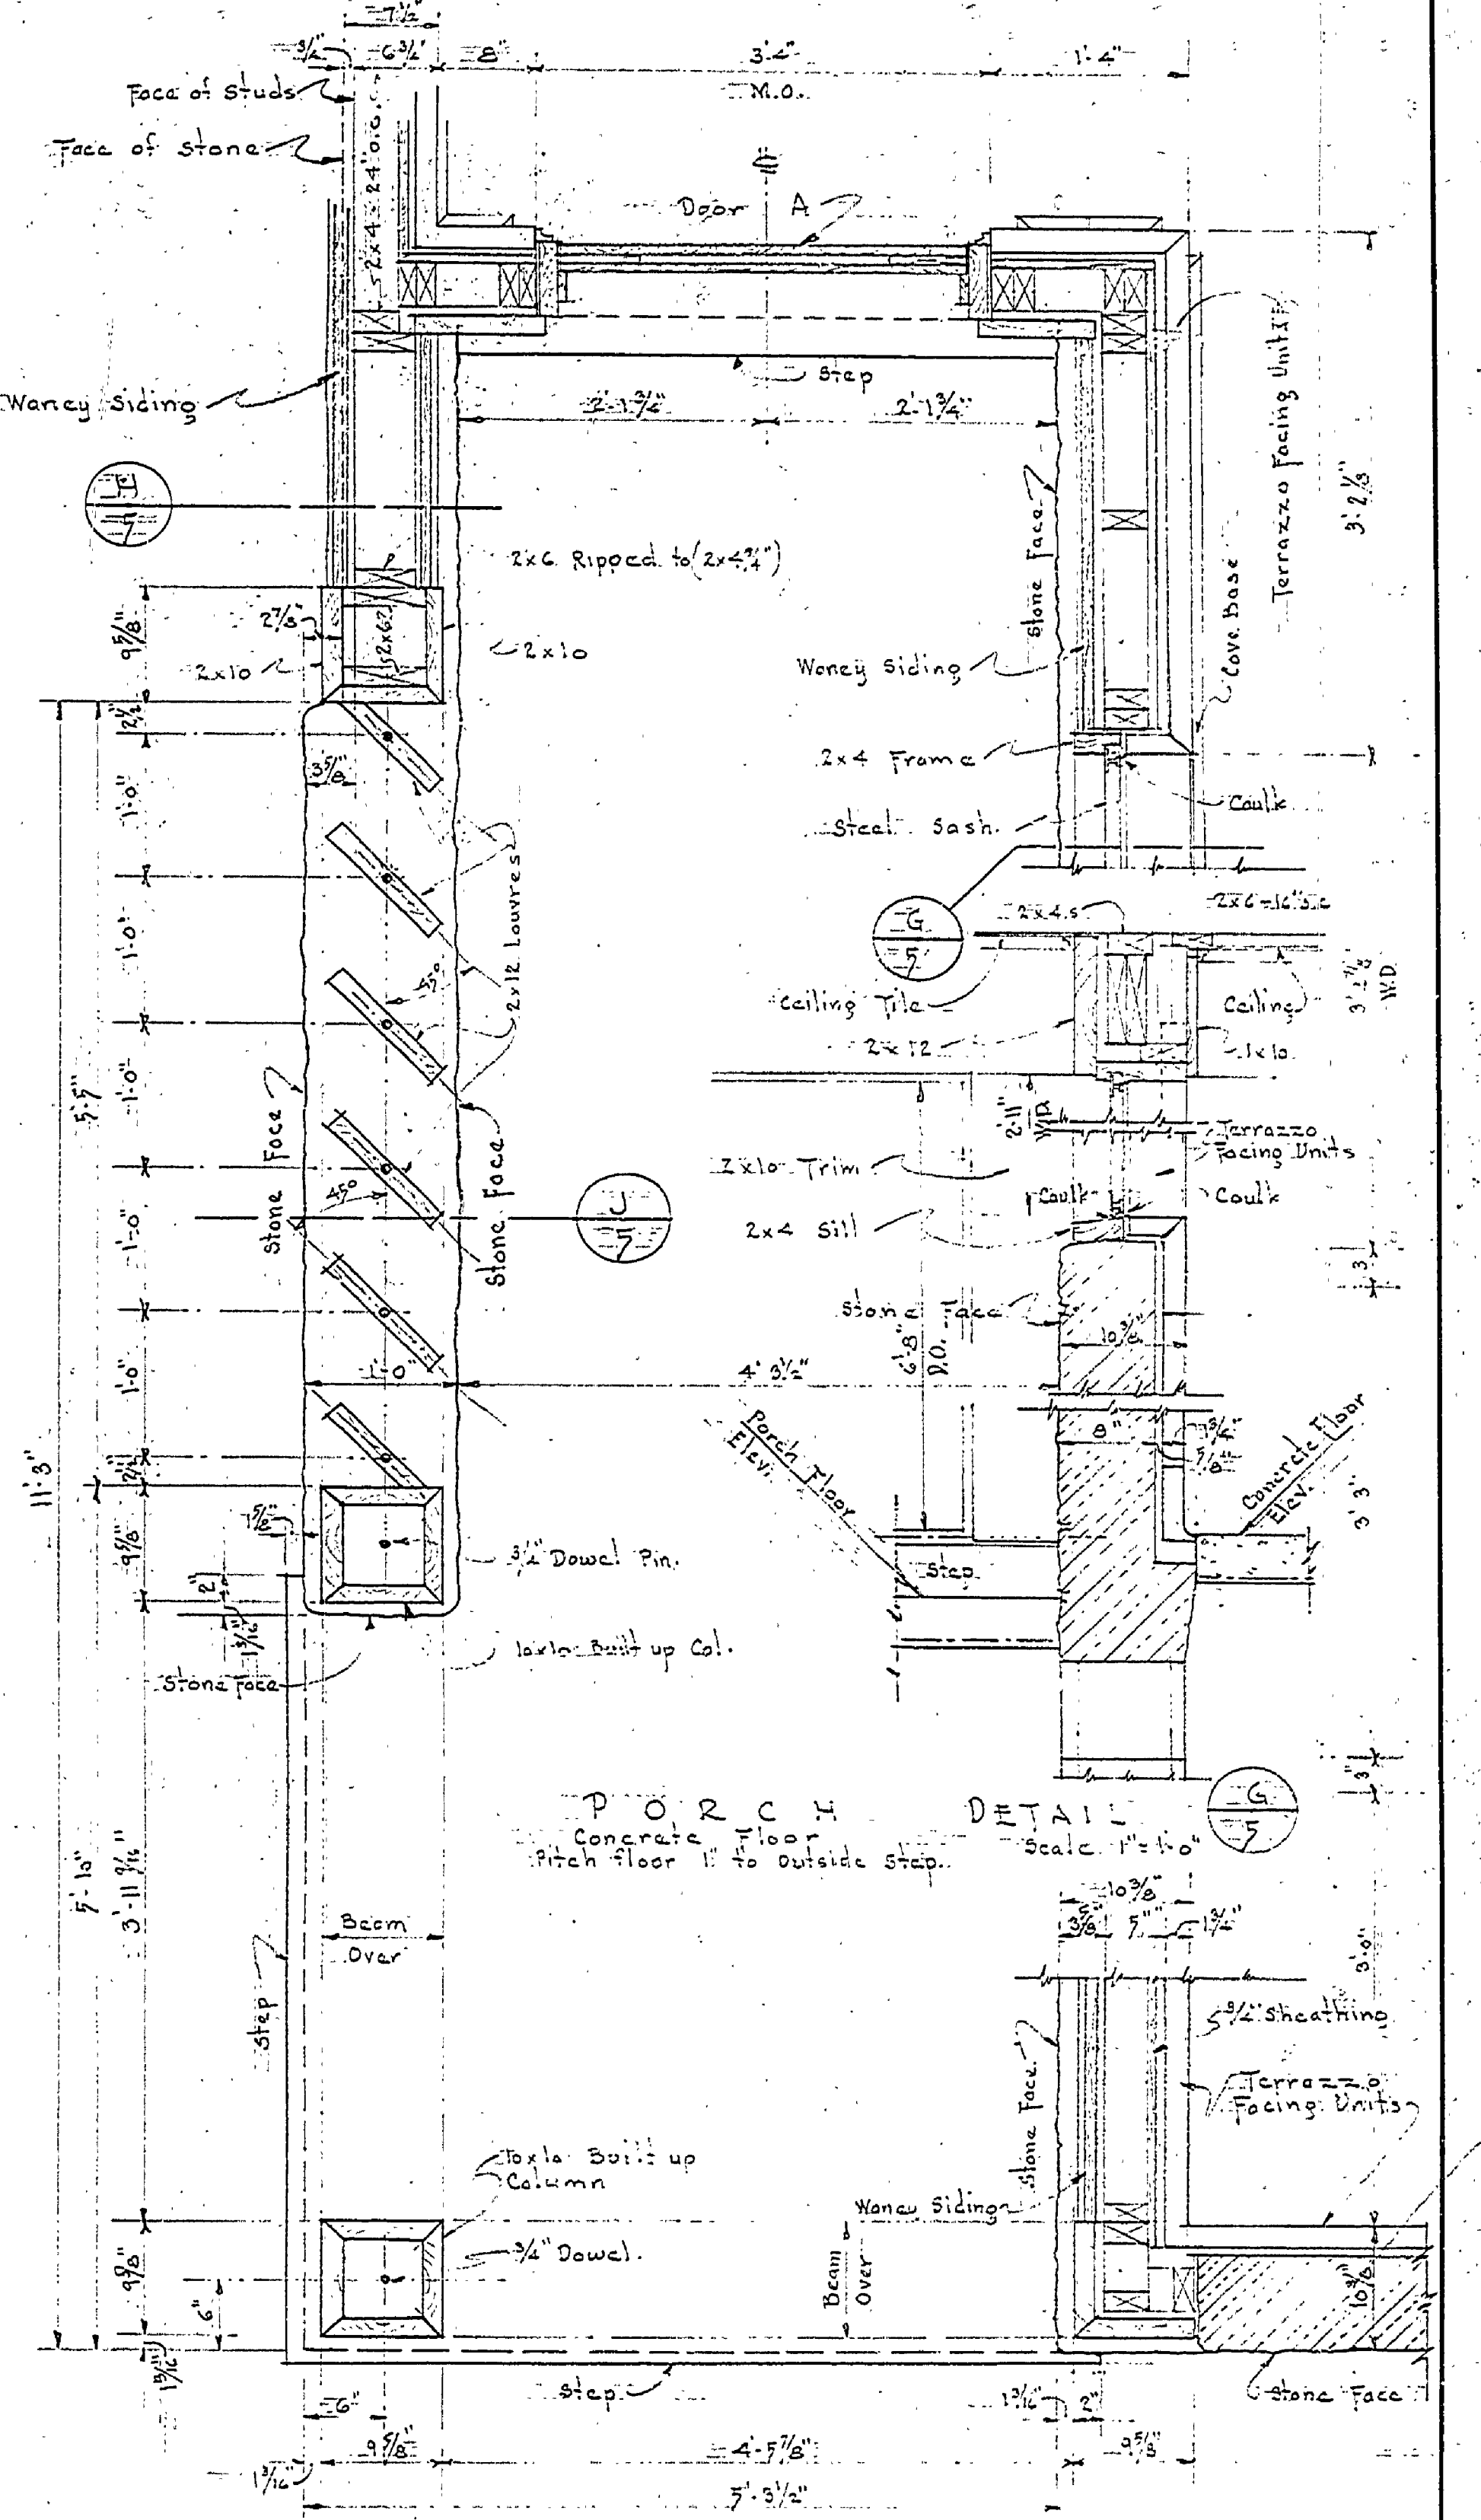
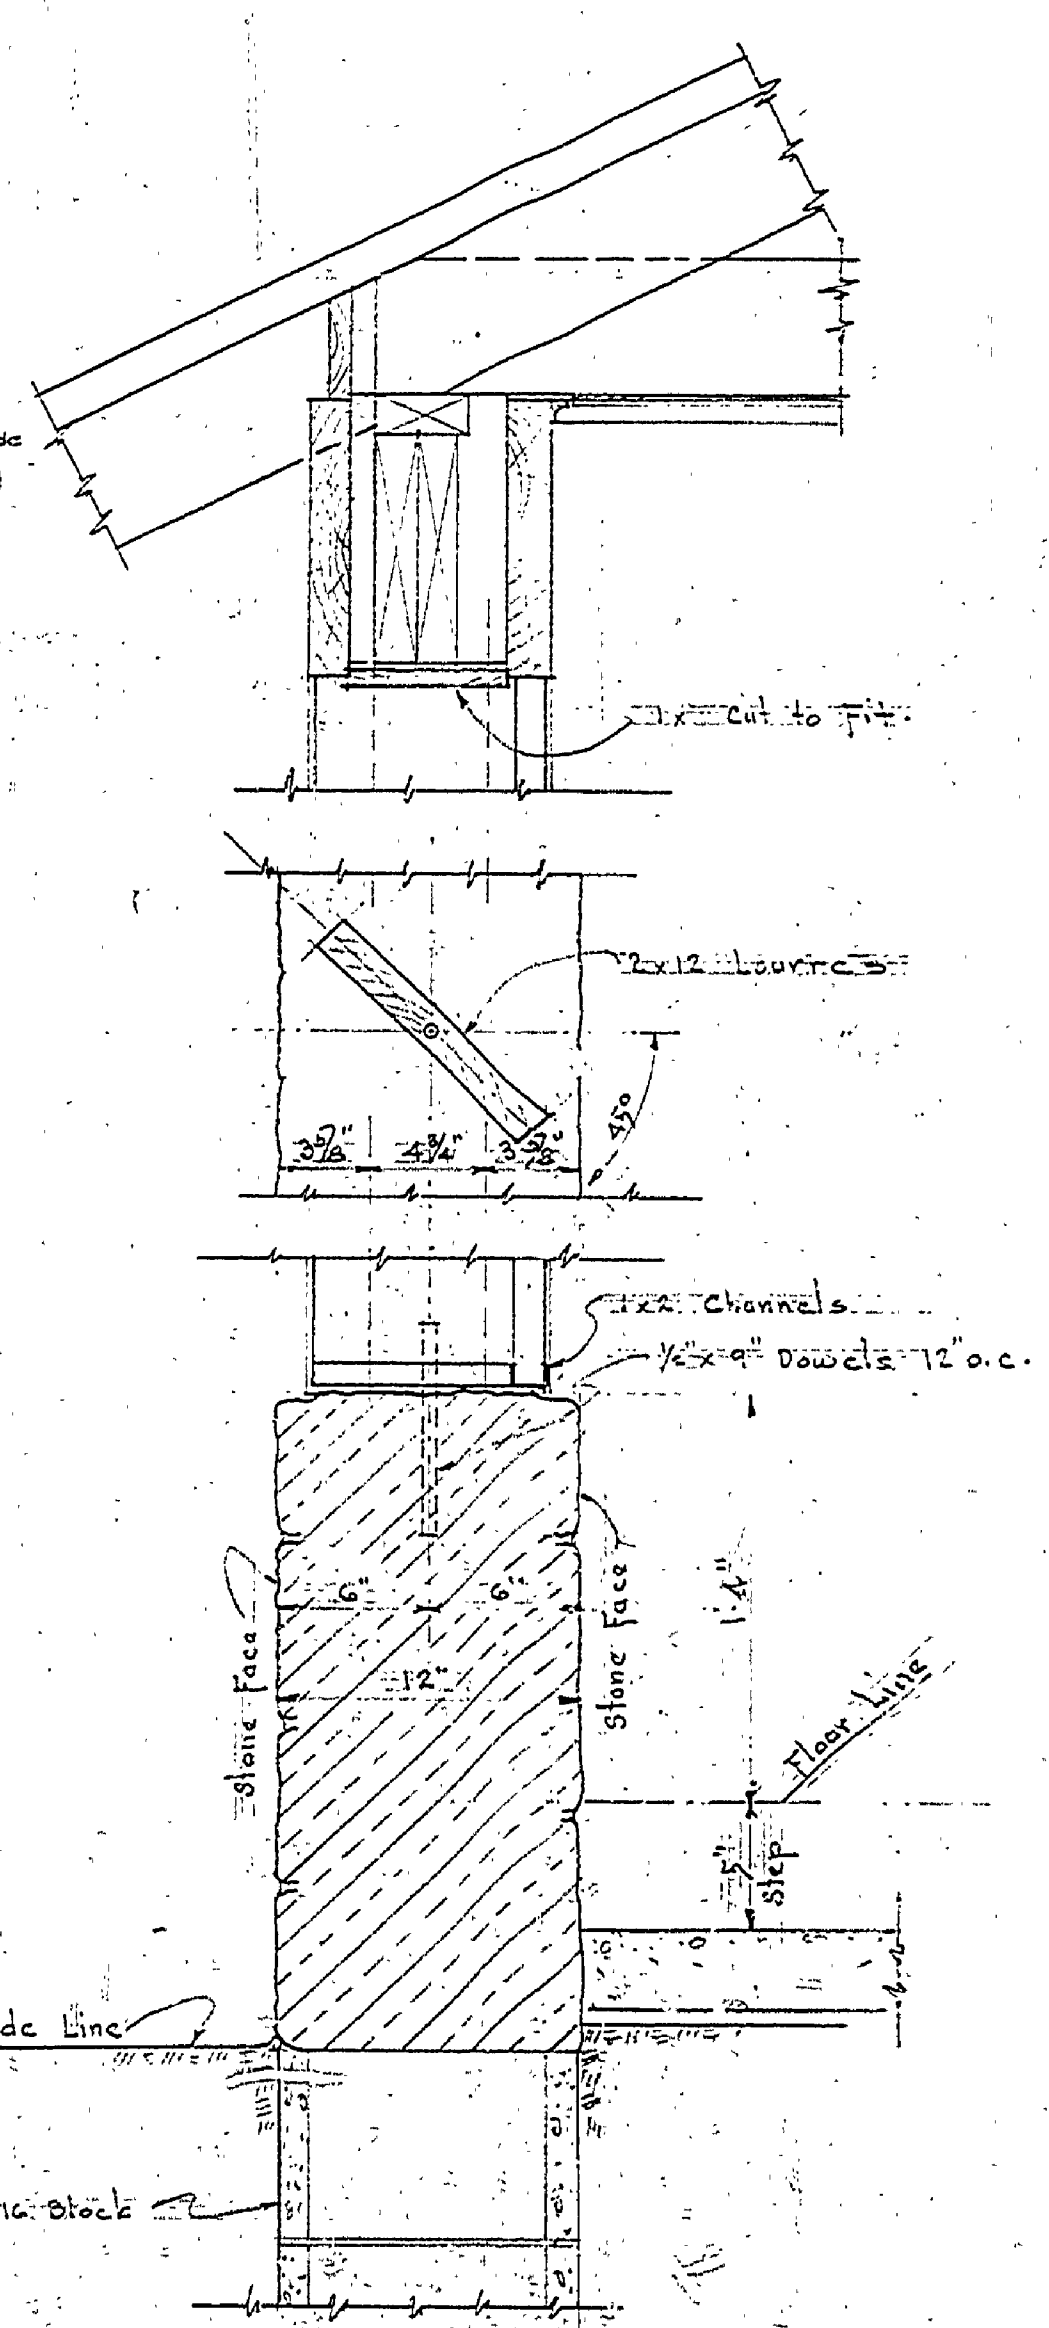
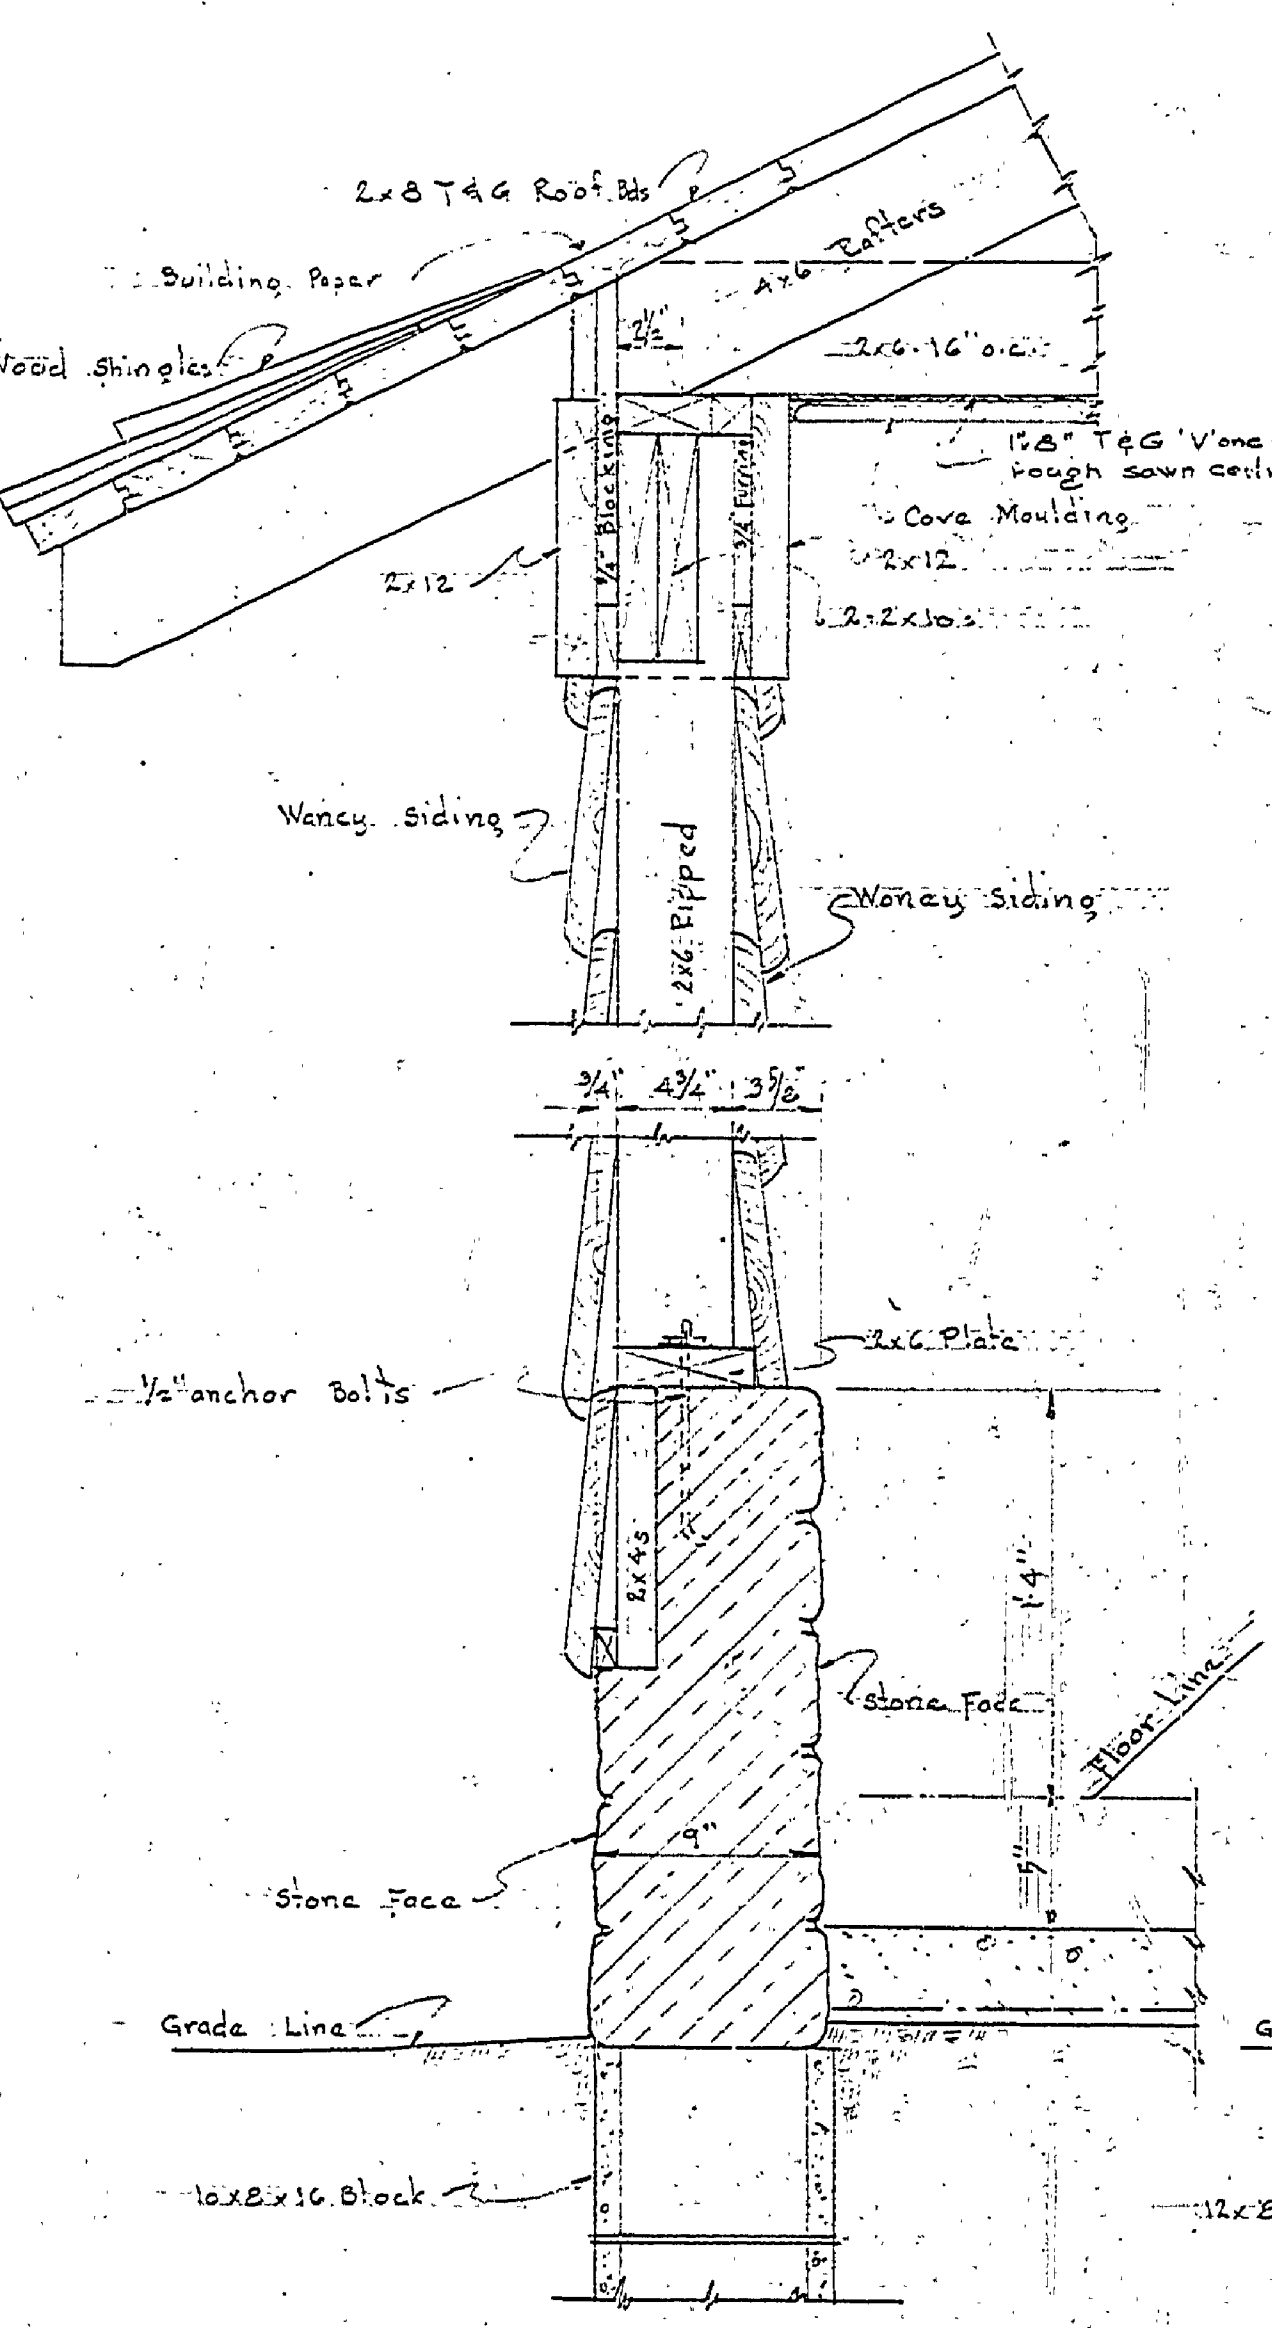
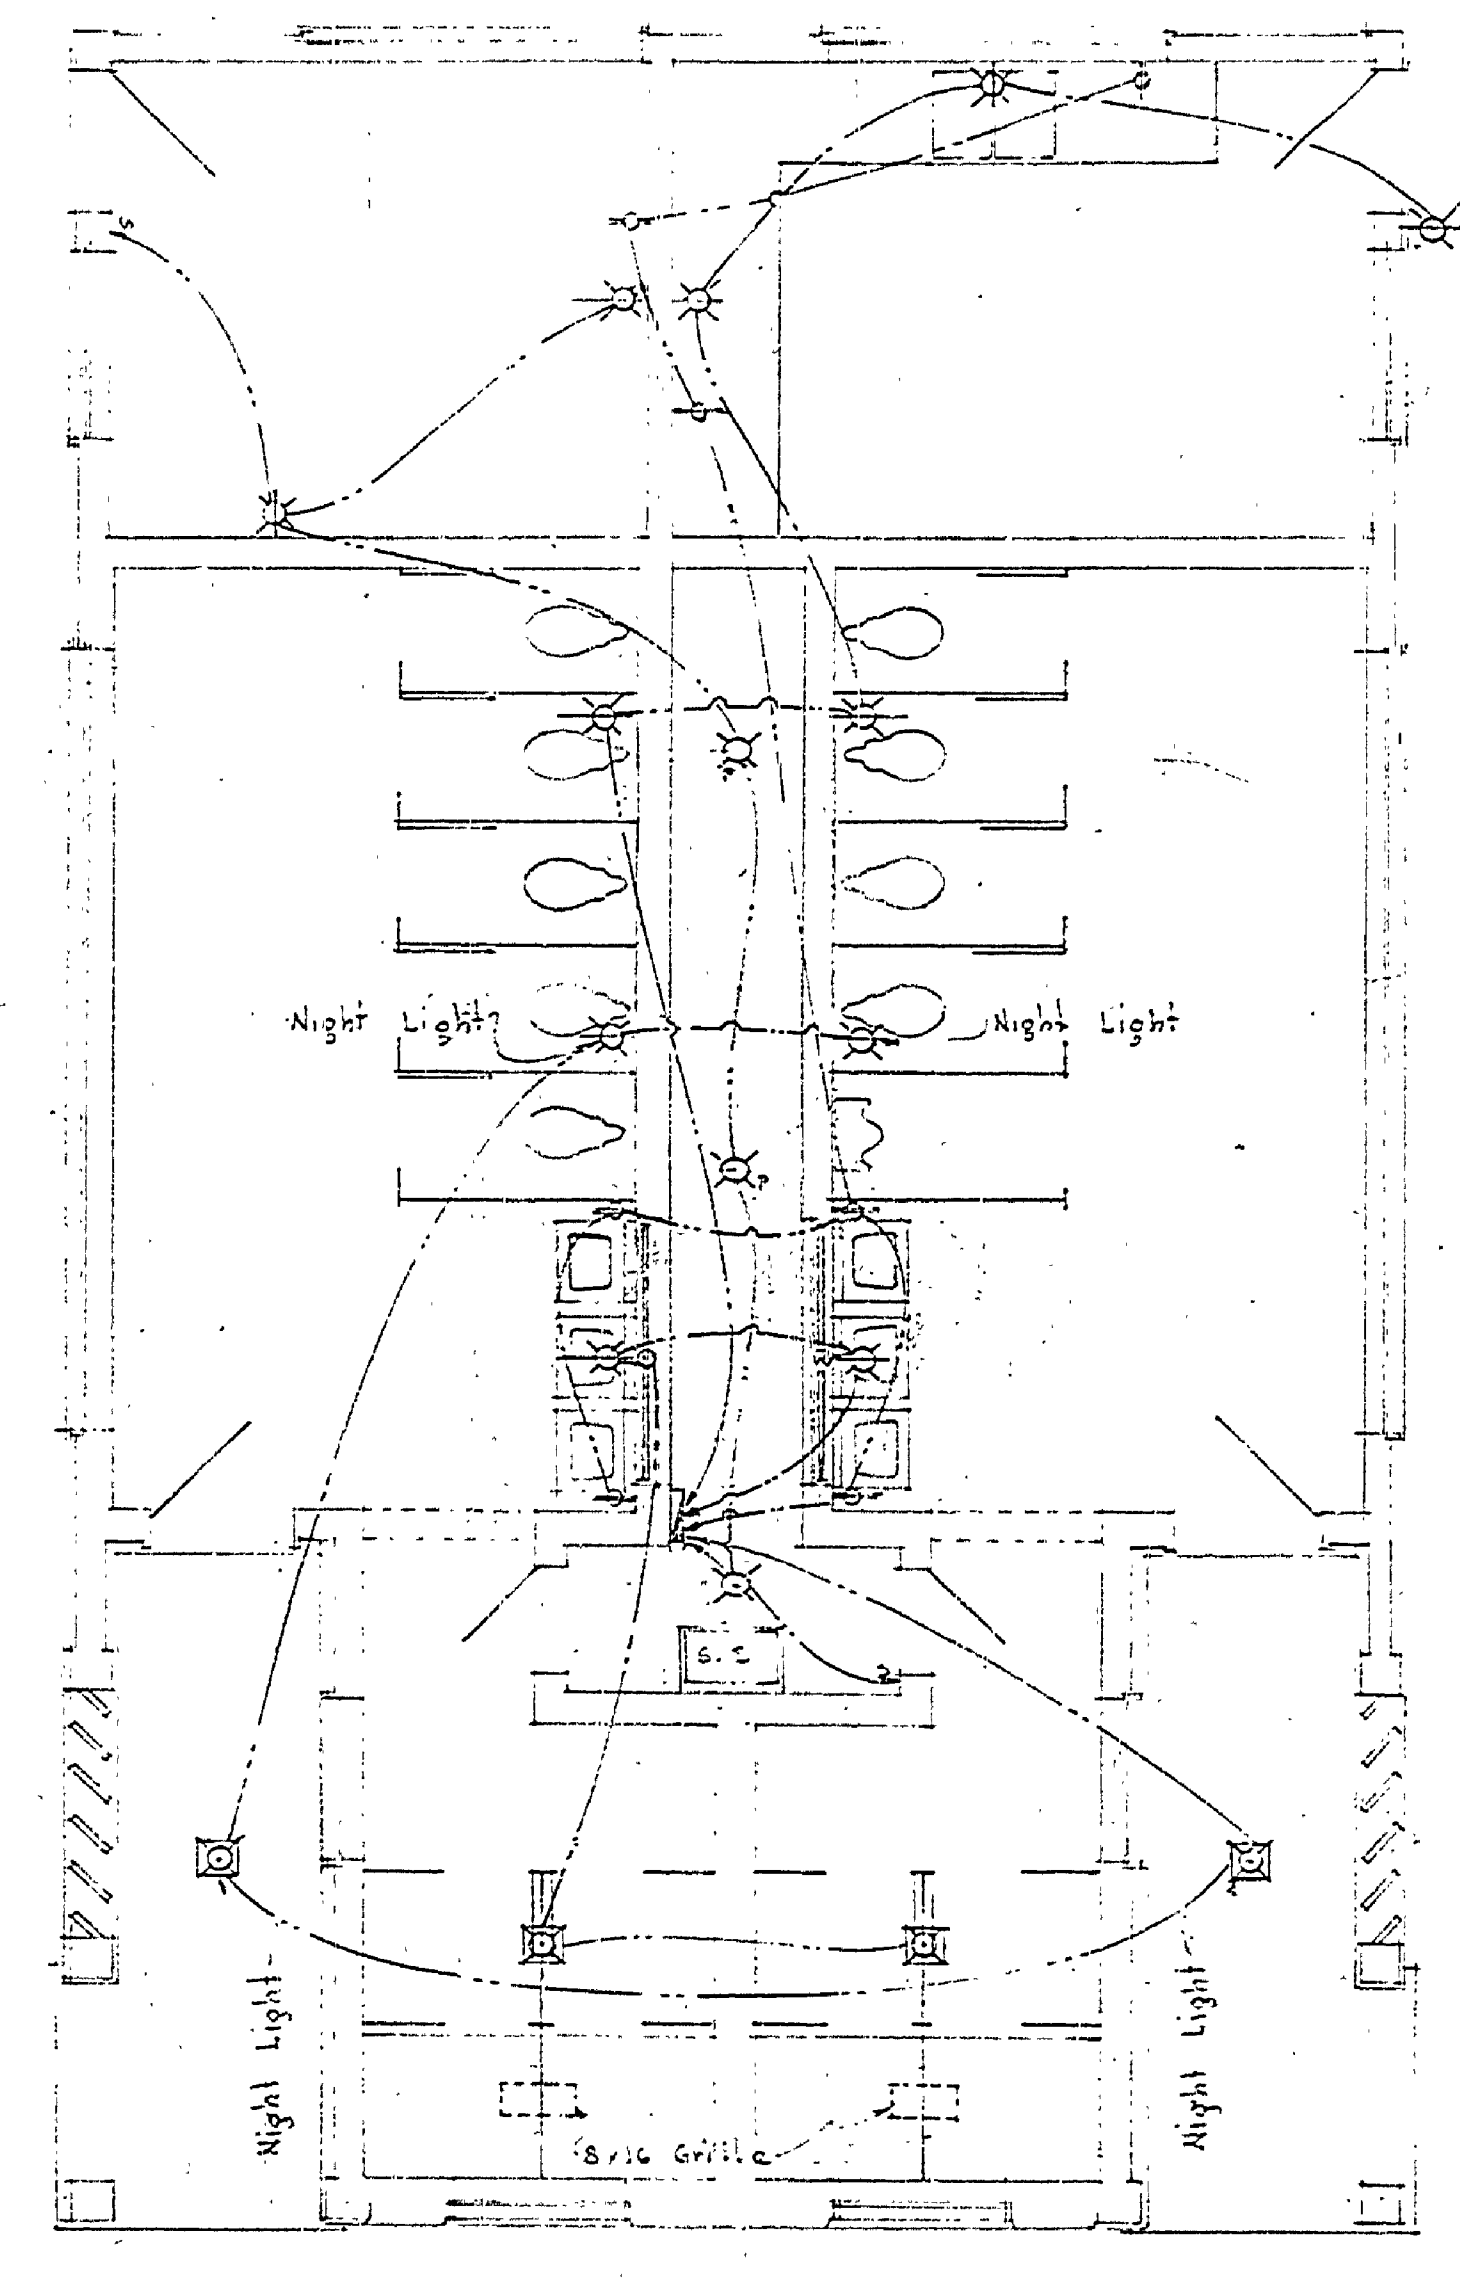
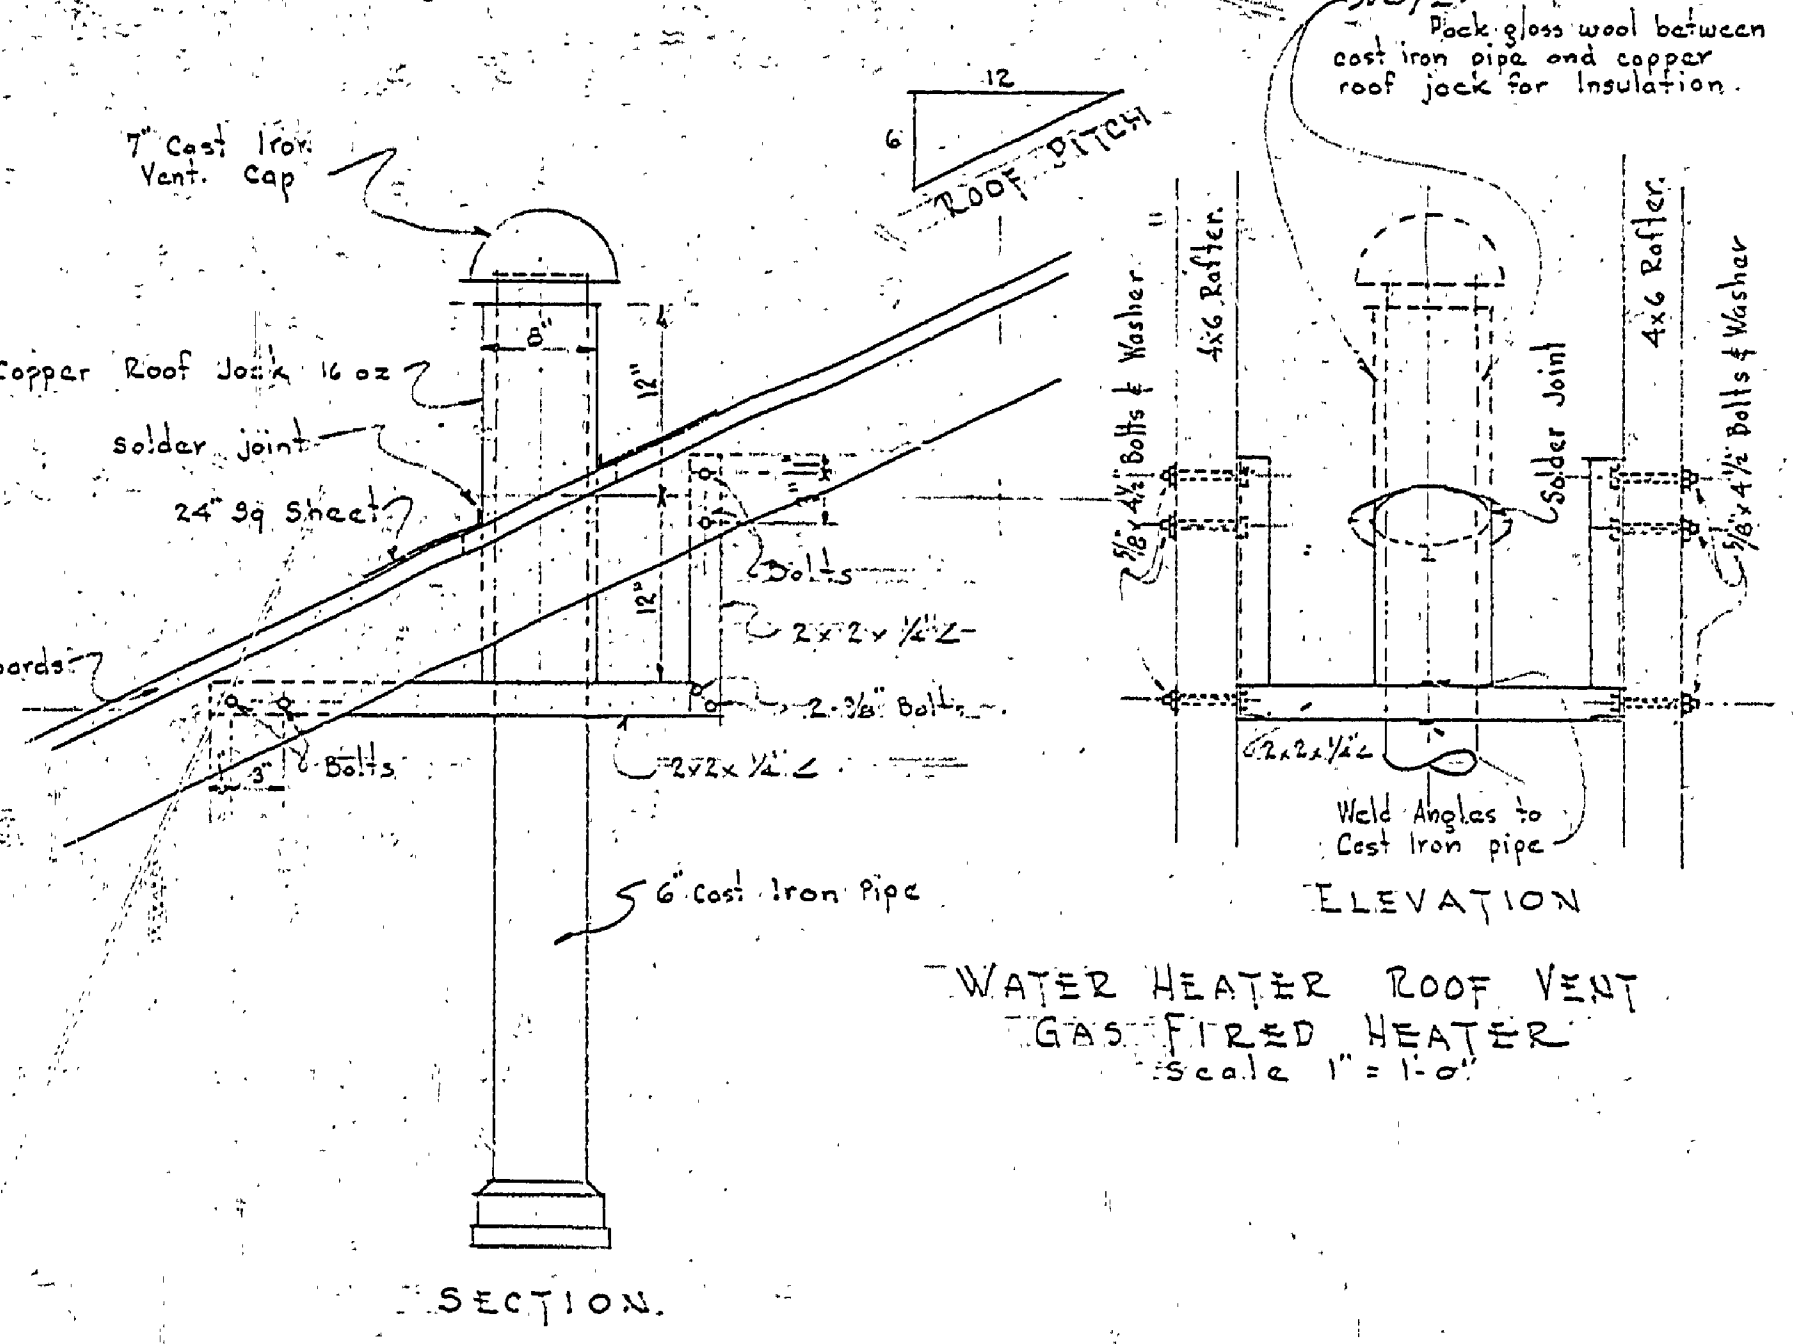


REVISIONS	NO.	DATE	BY
4			
5			
6			

APPROVED BY	DATE	REVIEWED BY SECTIONS	DATE
<i>H.C. MacIntyre</i>	2-8-57	ARCHITECTURAL	J.R.R.
ASSISTANT CHIEF IN CHARGE	2-8-57	ENGINEERING	J.R.R.
OF DESIGN	2-8-57	LANDSCAPE	J.L.E.

DRAWN BY	CHECKED BY
J.M.P.	J.M.P.

ELECTRICAL CIRCUITS
 1. All convenience outlets
 2. Rice Alley and Master Room
 3. Bath lights and two Toilet Room Lights
 4. Shower Room and Mirror Lights with two Toilet Room Lights
 5. Laundry Room lights with two Toilet Room Lights.
 6. Two Toilet Room Lights.
 7. Two Toilet Room Lights.
 8. Two Toilet Room Lights.
 100. Two Toilet Room Lights.

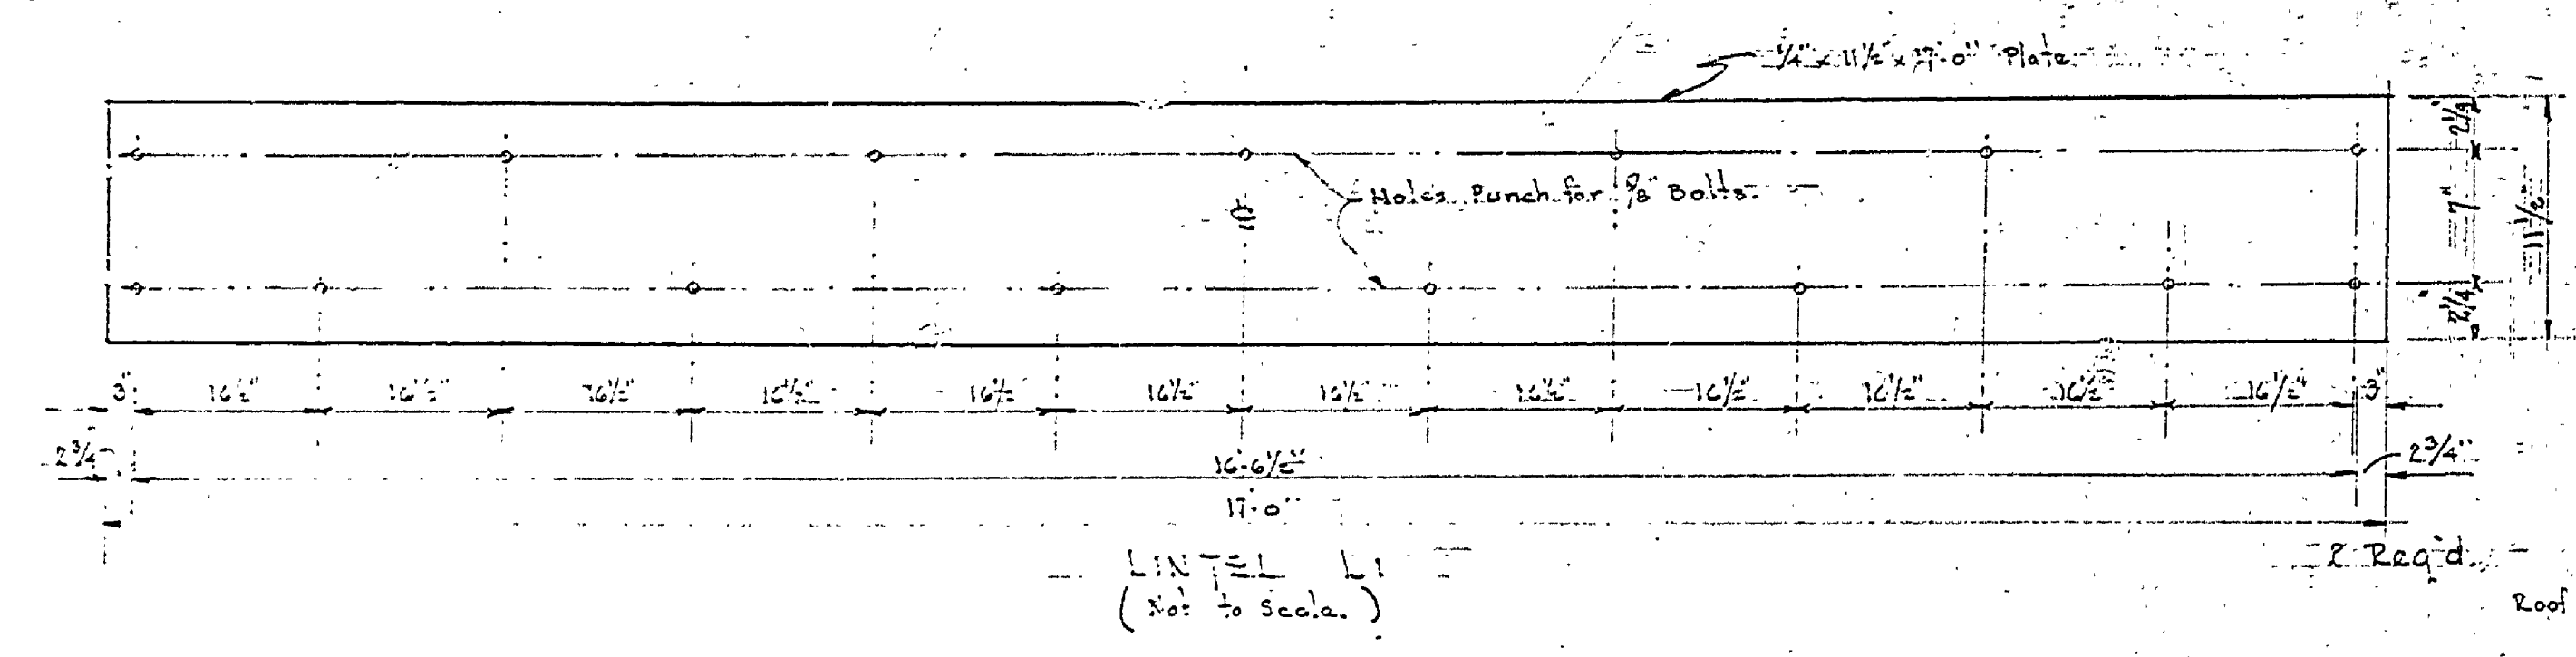

PORCH DETAIL
 Scale 1" = 1'-0"
 DETAIL DESIGNATION: (A-7)
 SHEET NO. WHERE DETAIL APPEARS OR WHERE DETAIL IS TAKEN
 SYMBOL

ELECTRICAL LAYOUT
 Scale 1/2" = 1'-0"

DETAIL
 Scale 1/2" = 1'-0"

DETAIL
 Scale 1/2" = 1'-0"

MICHIGAN
 DEPARTMENT OF CONSERVATION
 PARKS AND RECREATION DIVISION

BURT LAKE STATE PARK
 TOILET, LAUNDRY AND SHOWER BUILDING
 SOUTH EAST BUILDING

PROJECT NO.	64-227-T
SHEET NO.	5
OF	6
PLAN NO.	A-105