




NORTH ELEVATION
1/2" = 1'-0"

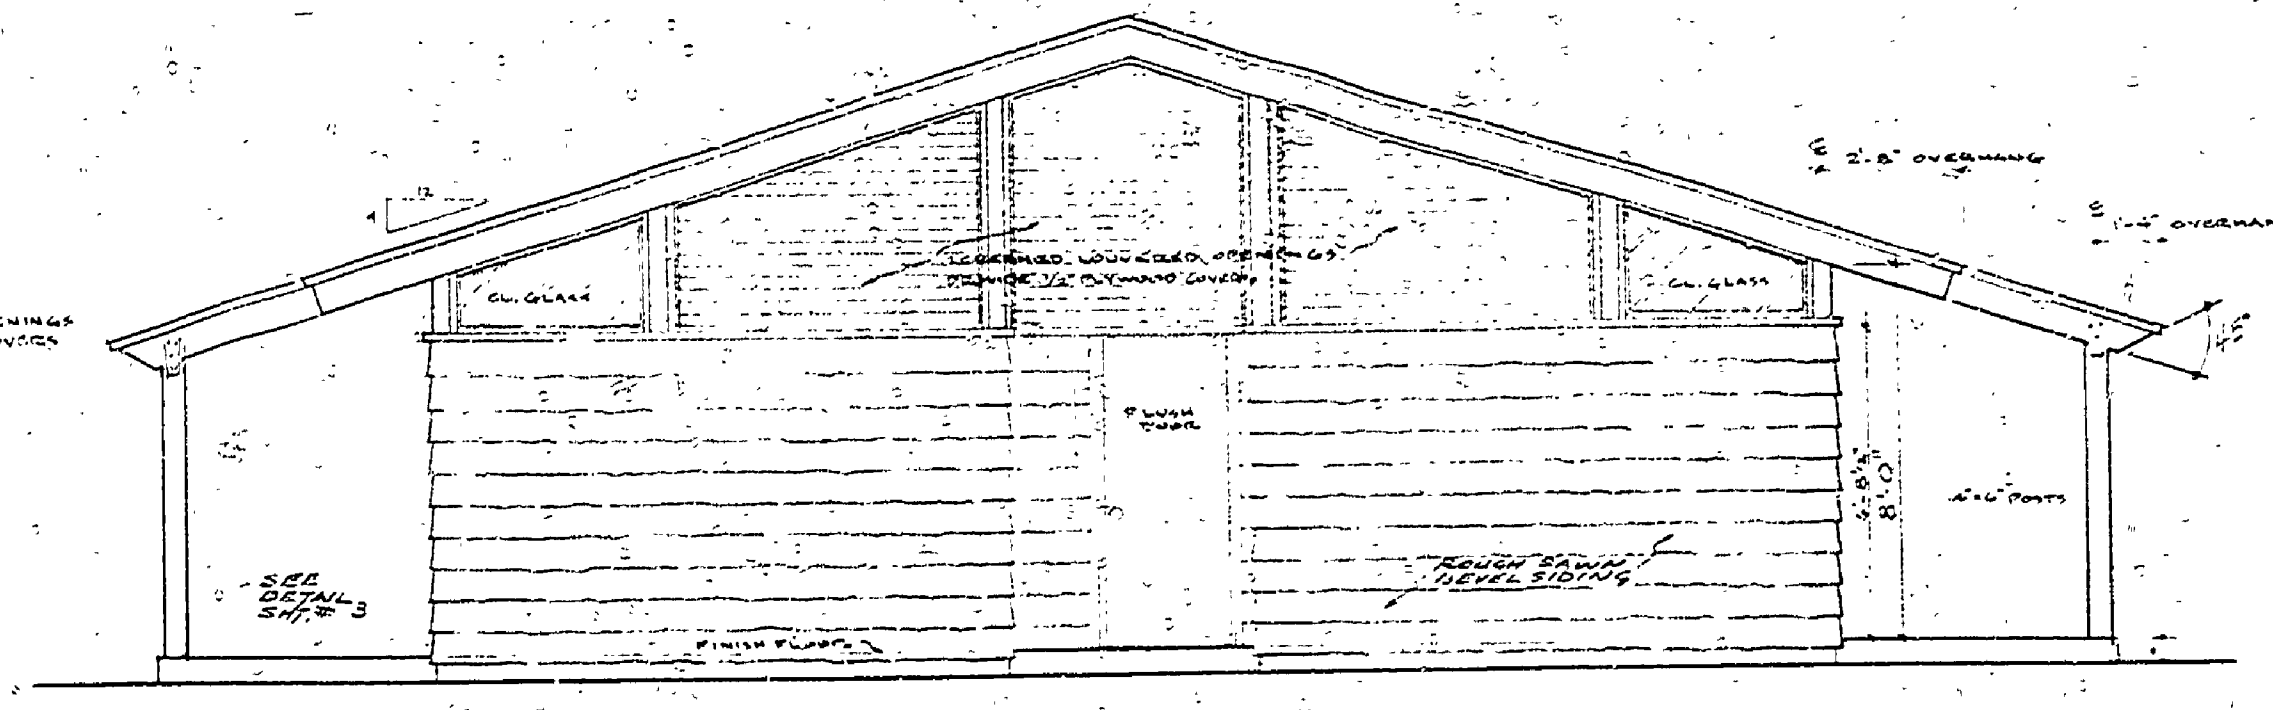


WEST ELEVATION
1/2" = 1'-0"

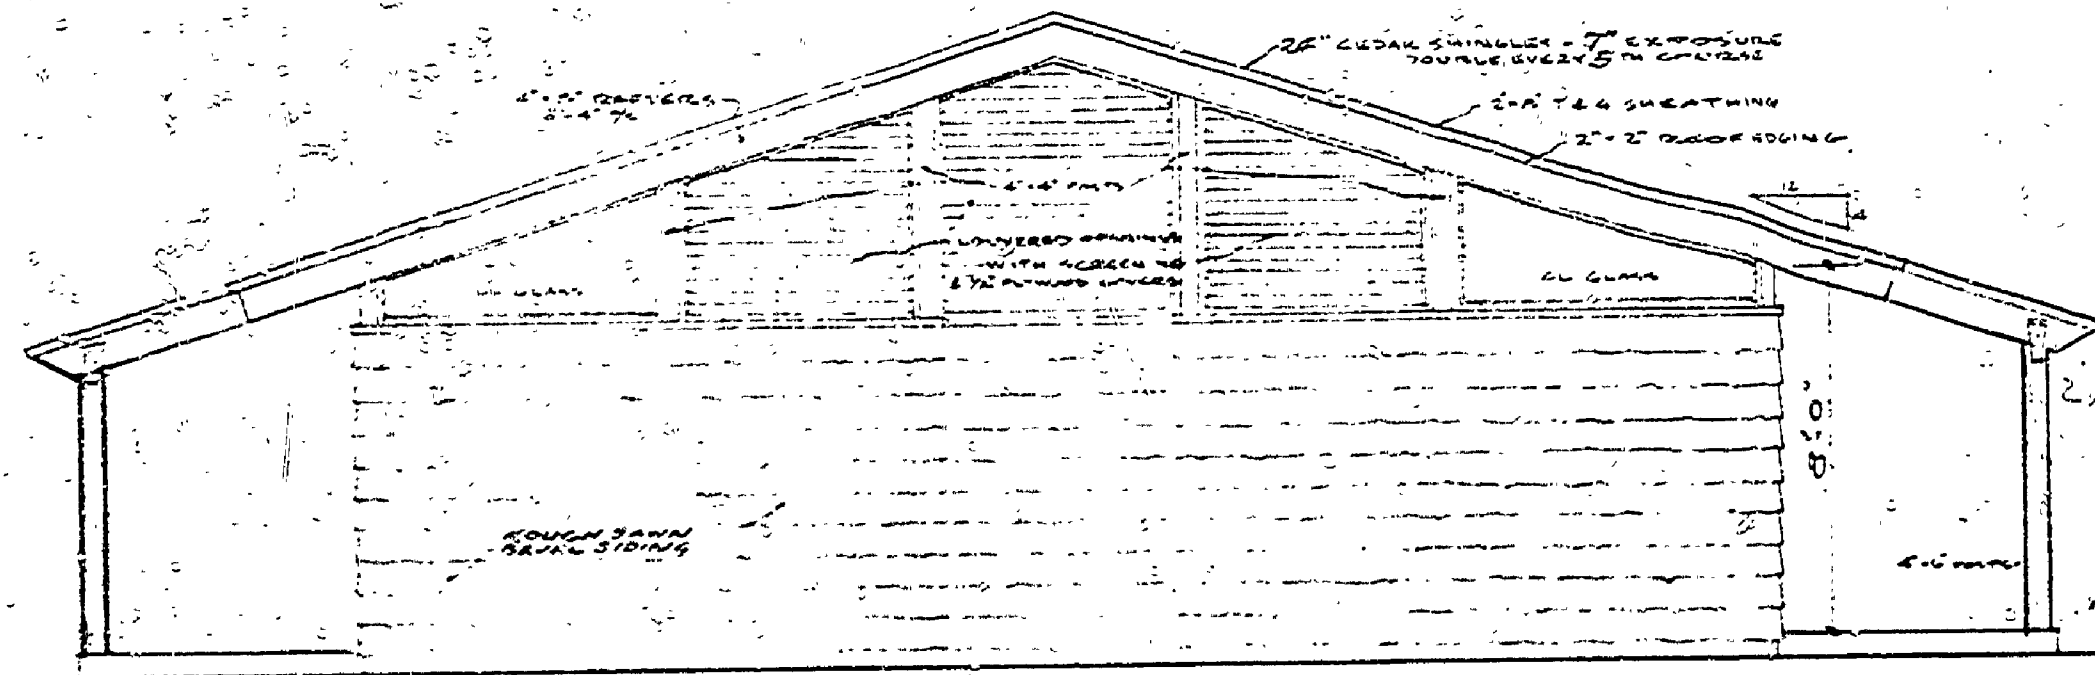


EAST ELEVATION
1/2" = 1'-0"

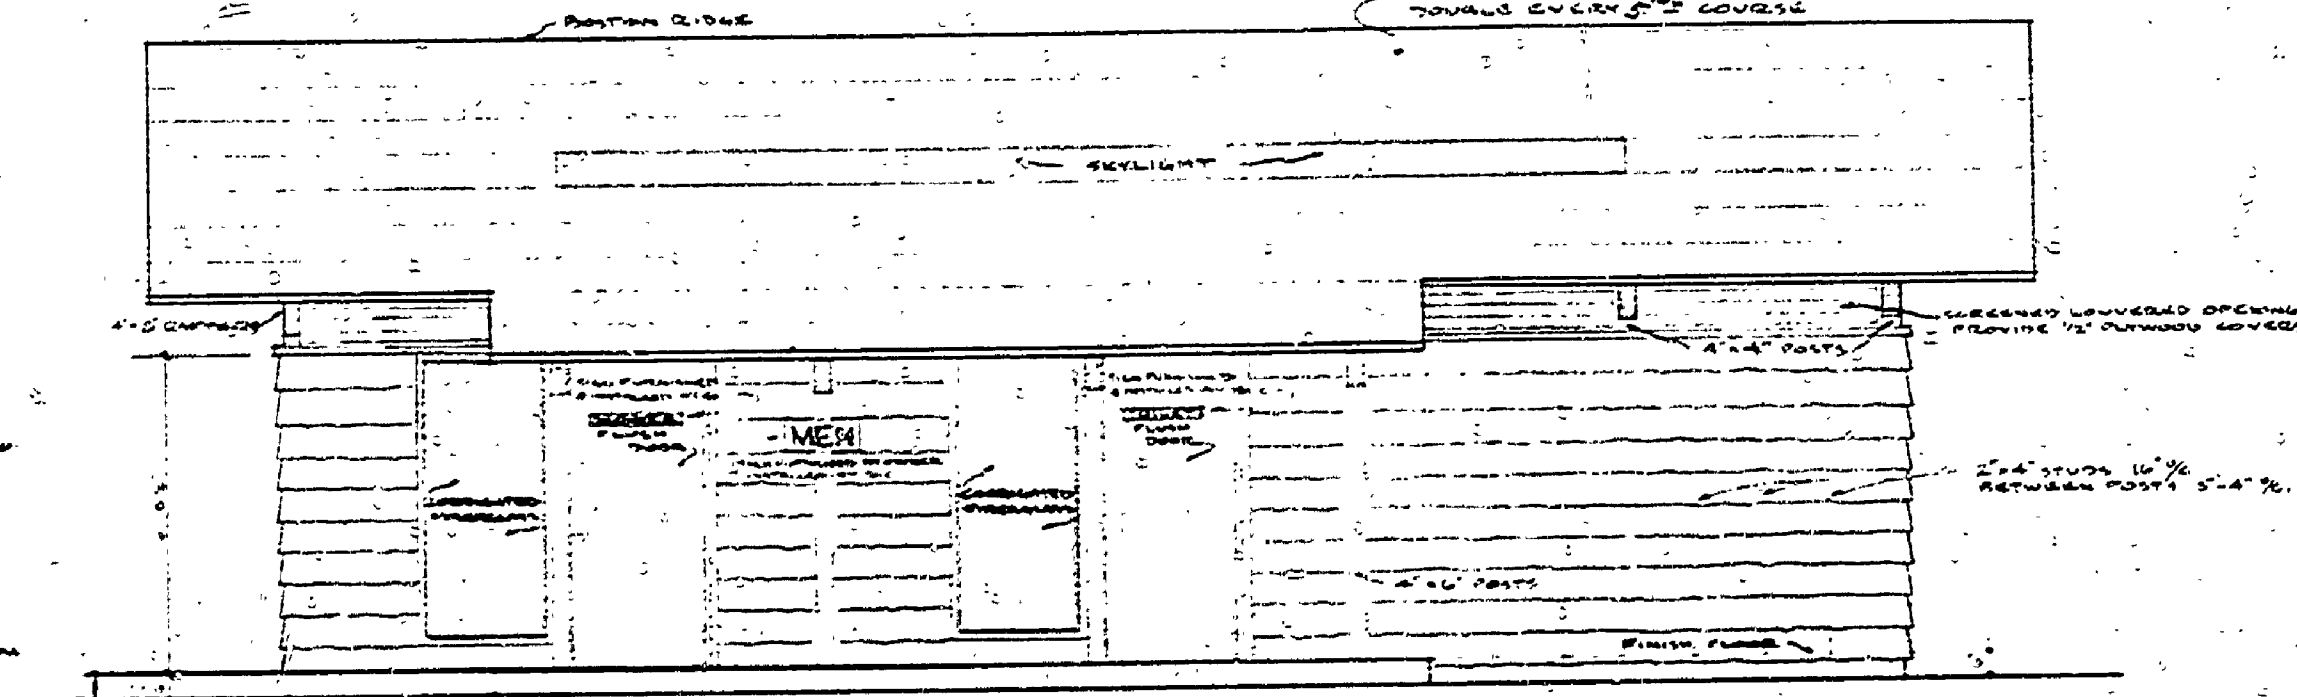


SOUTH ELEVATION
1/2" = 1'-0"

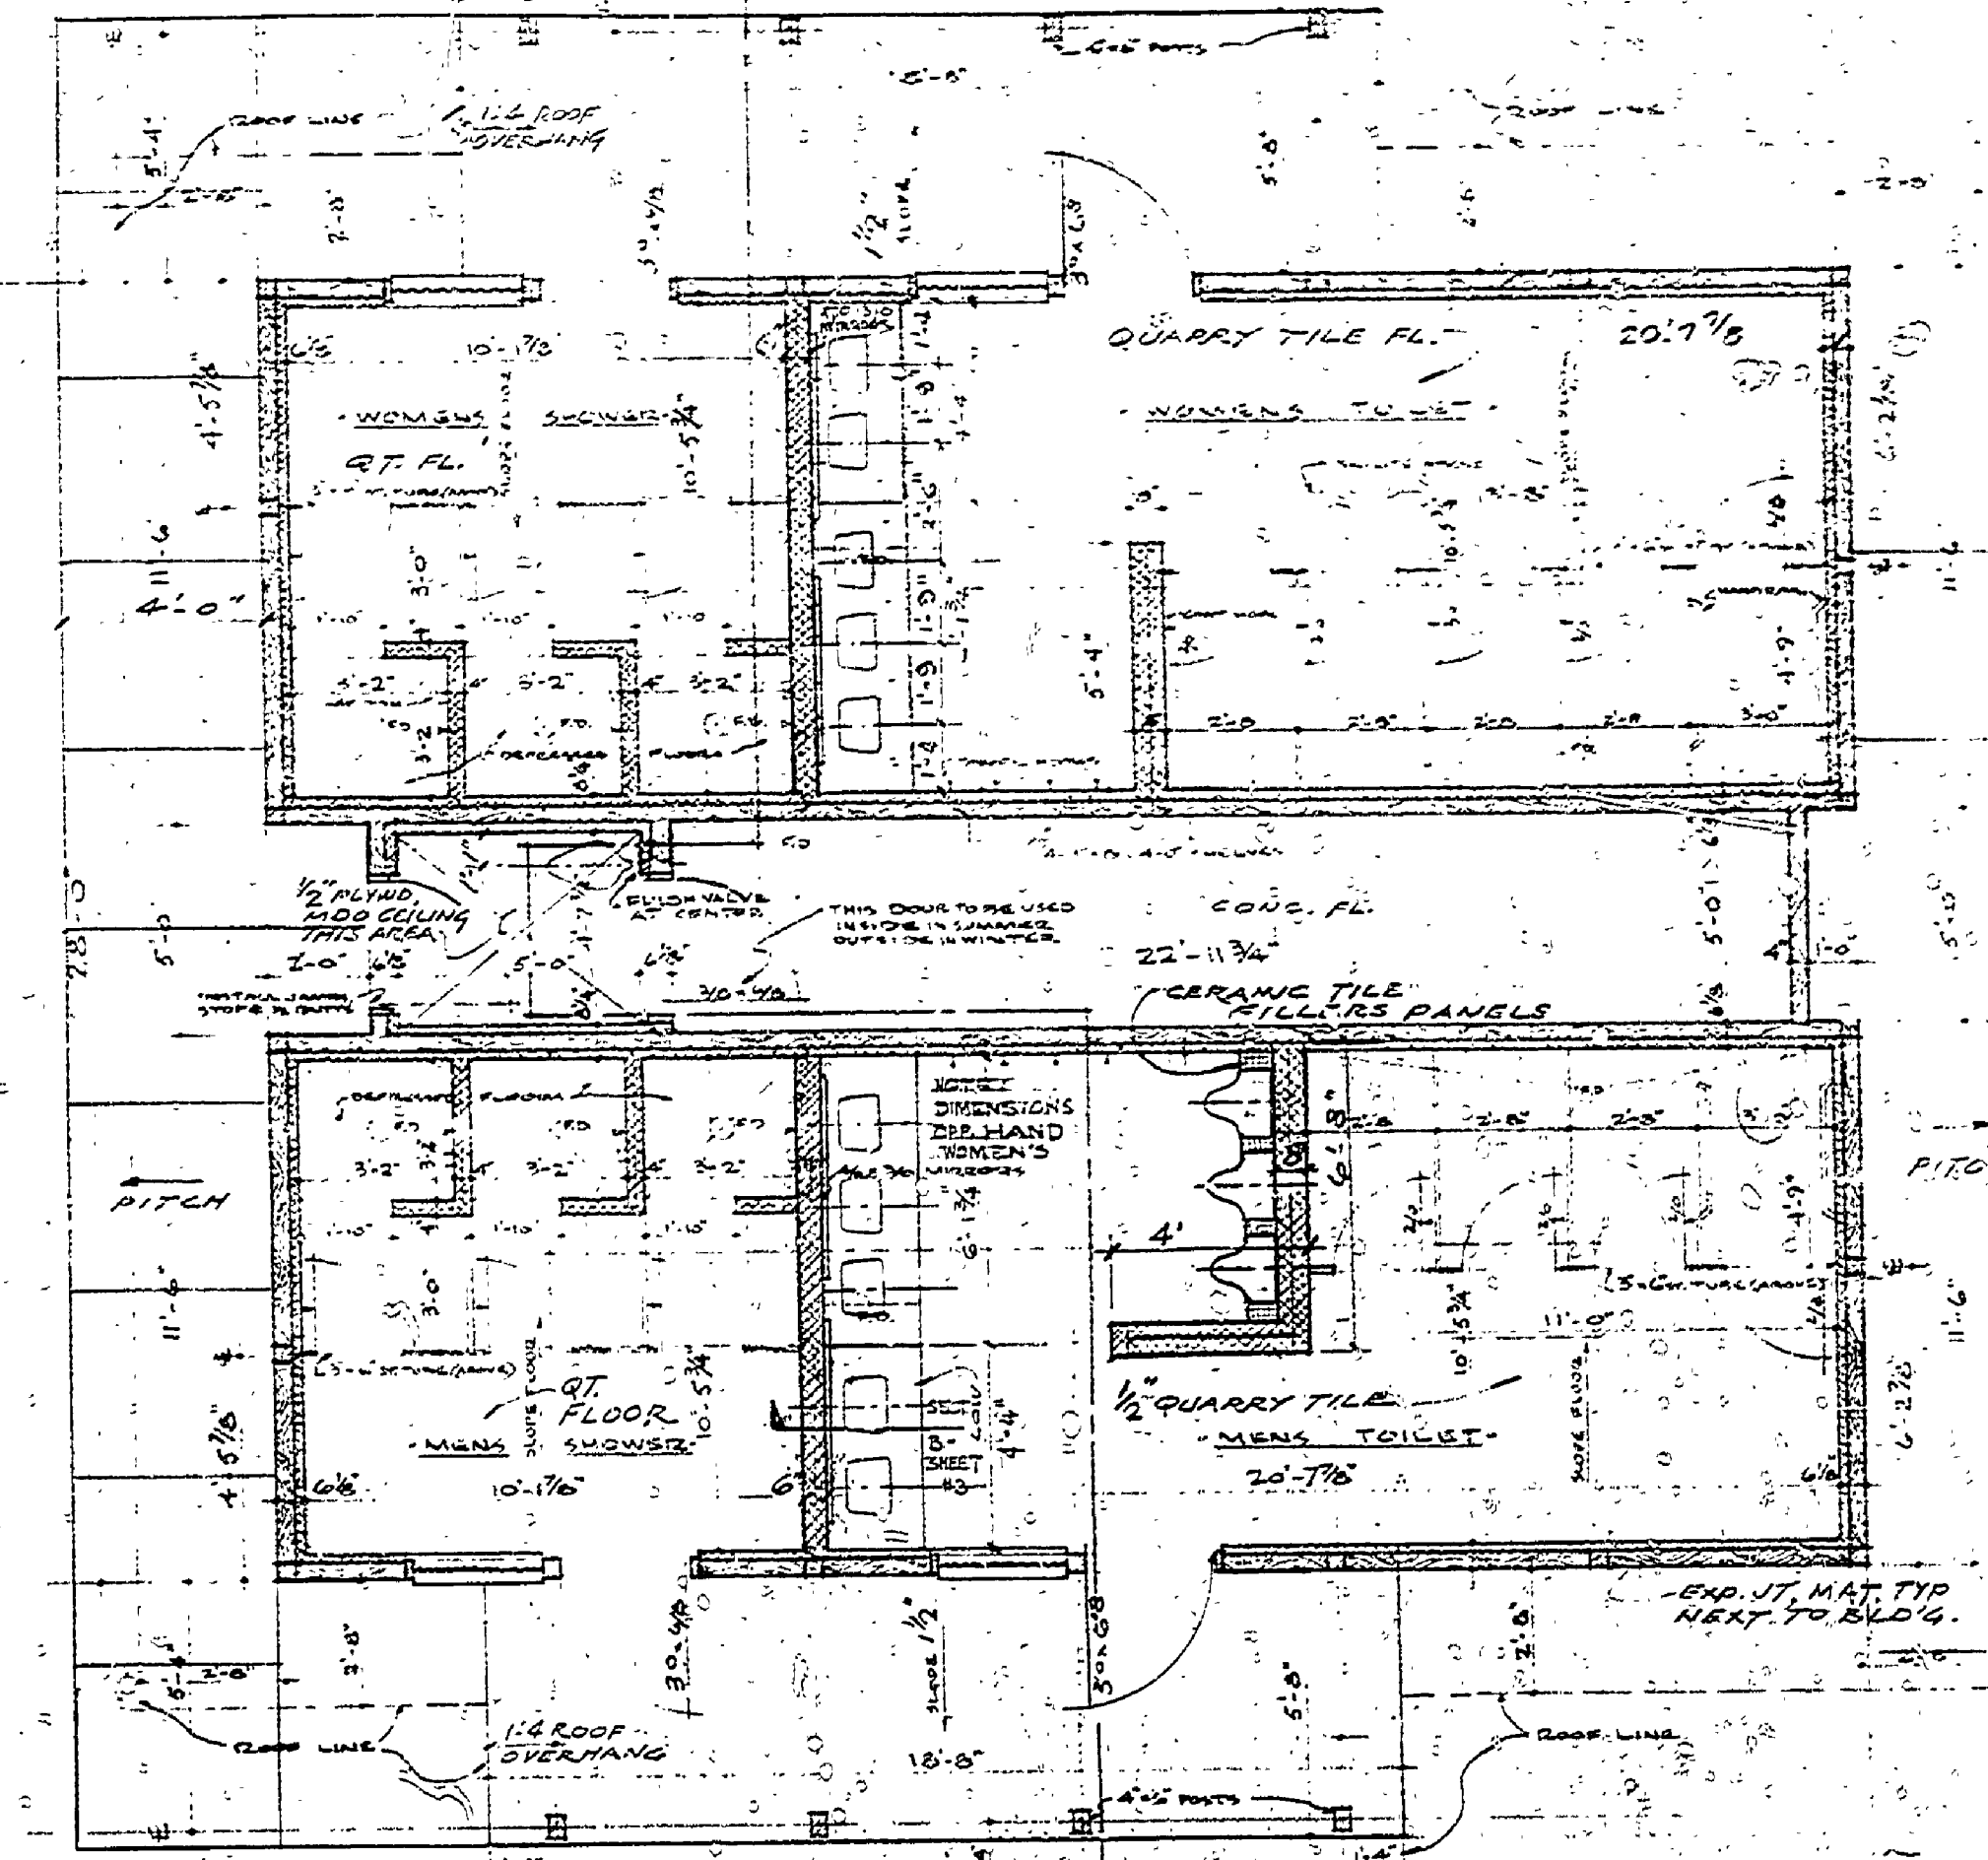


FLOOR PLAN
1/2" = 1'-0"

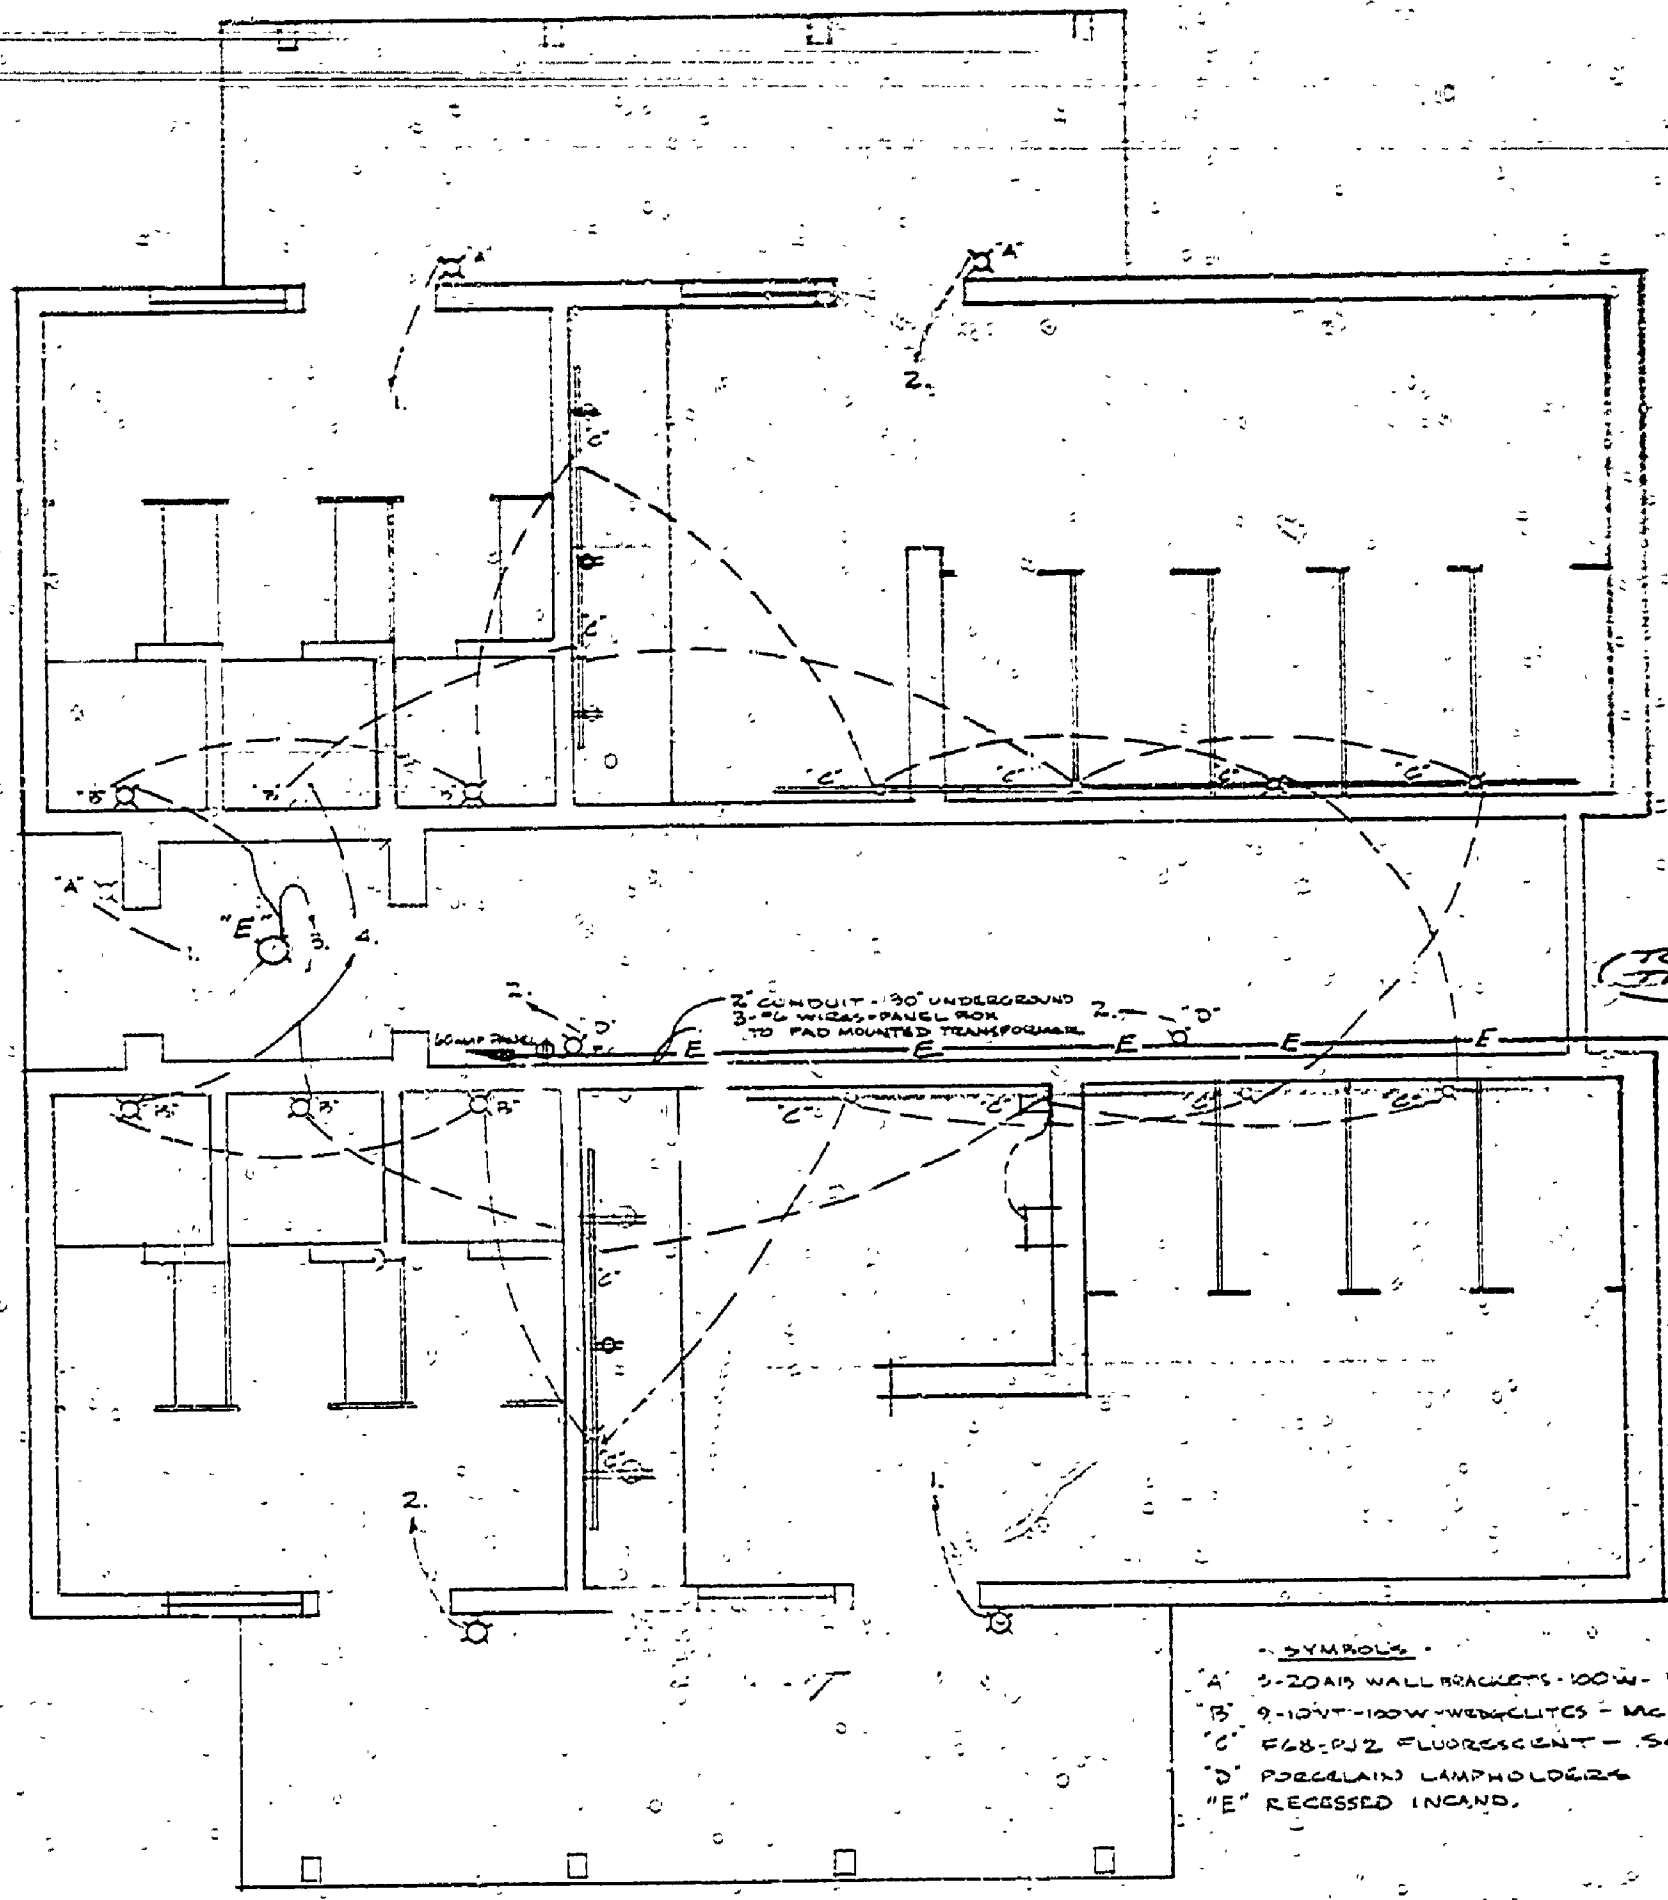


ELECTRICAL PLAN
1/2" = 1'-0"

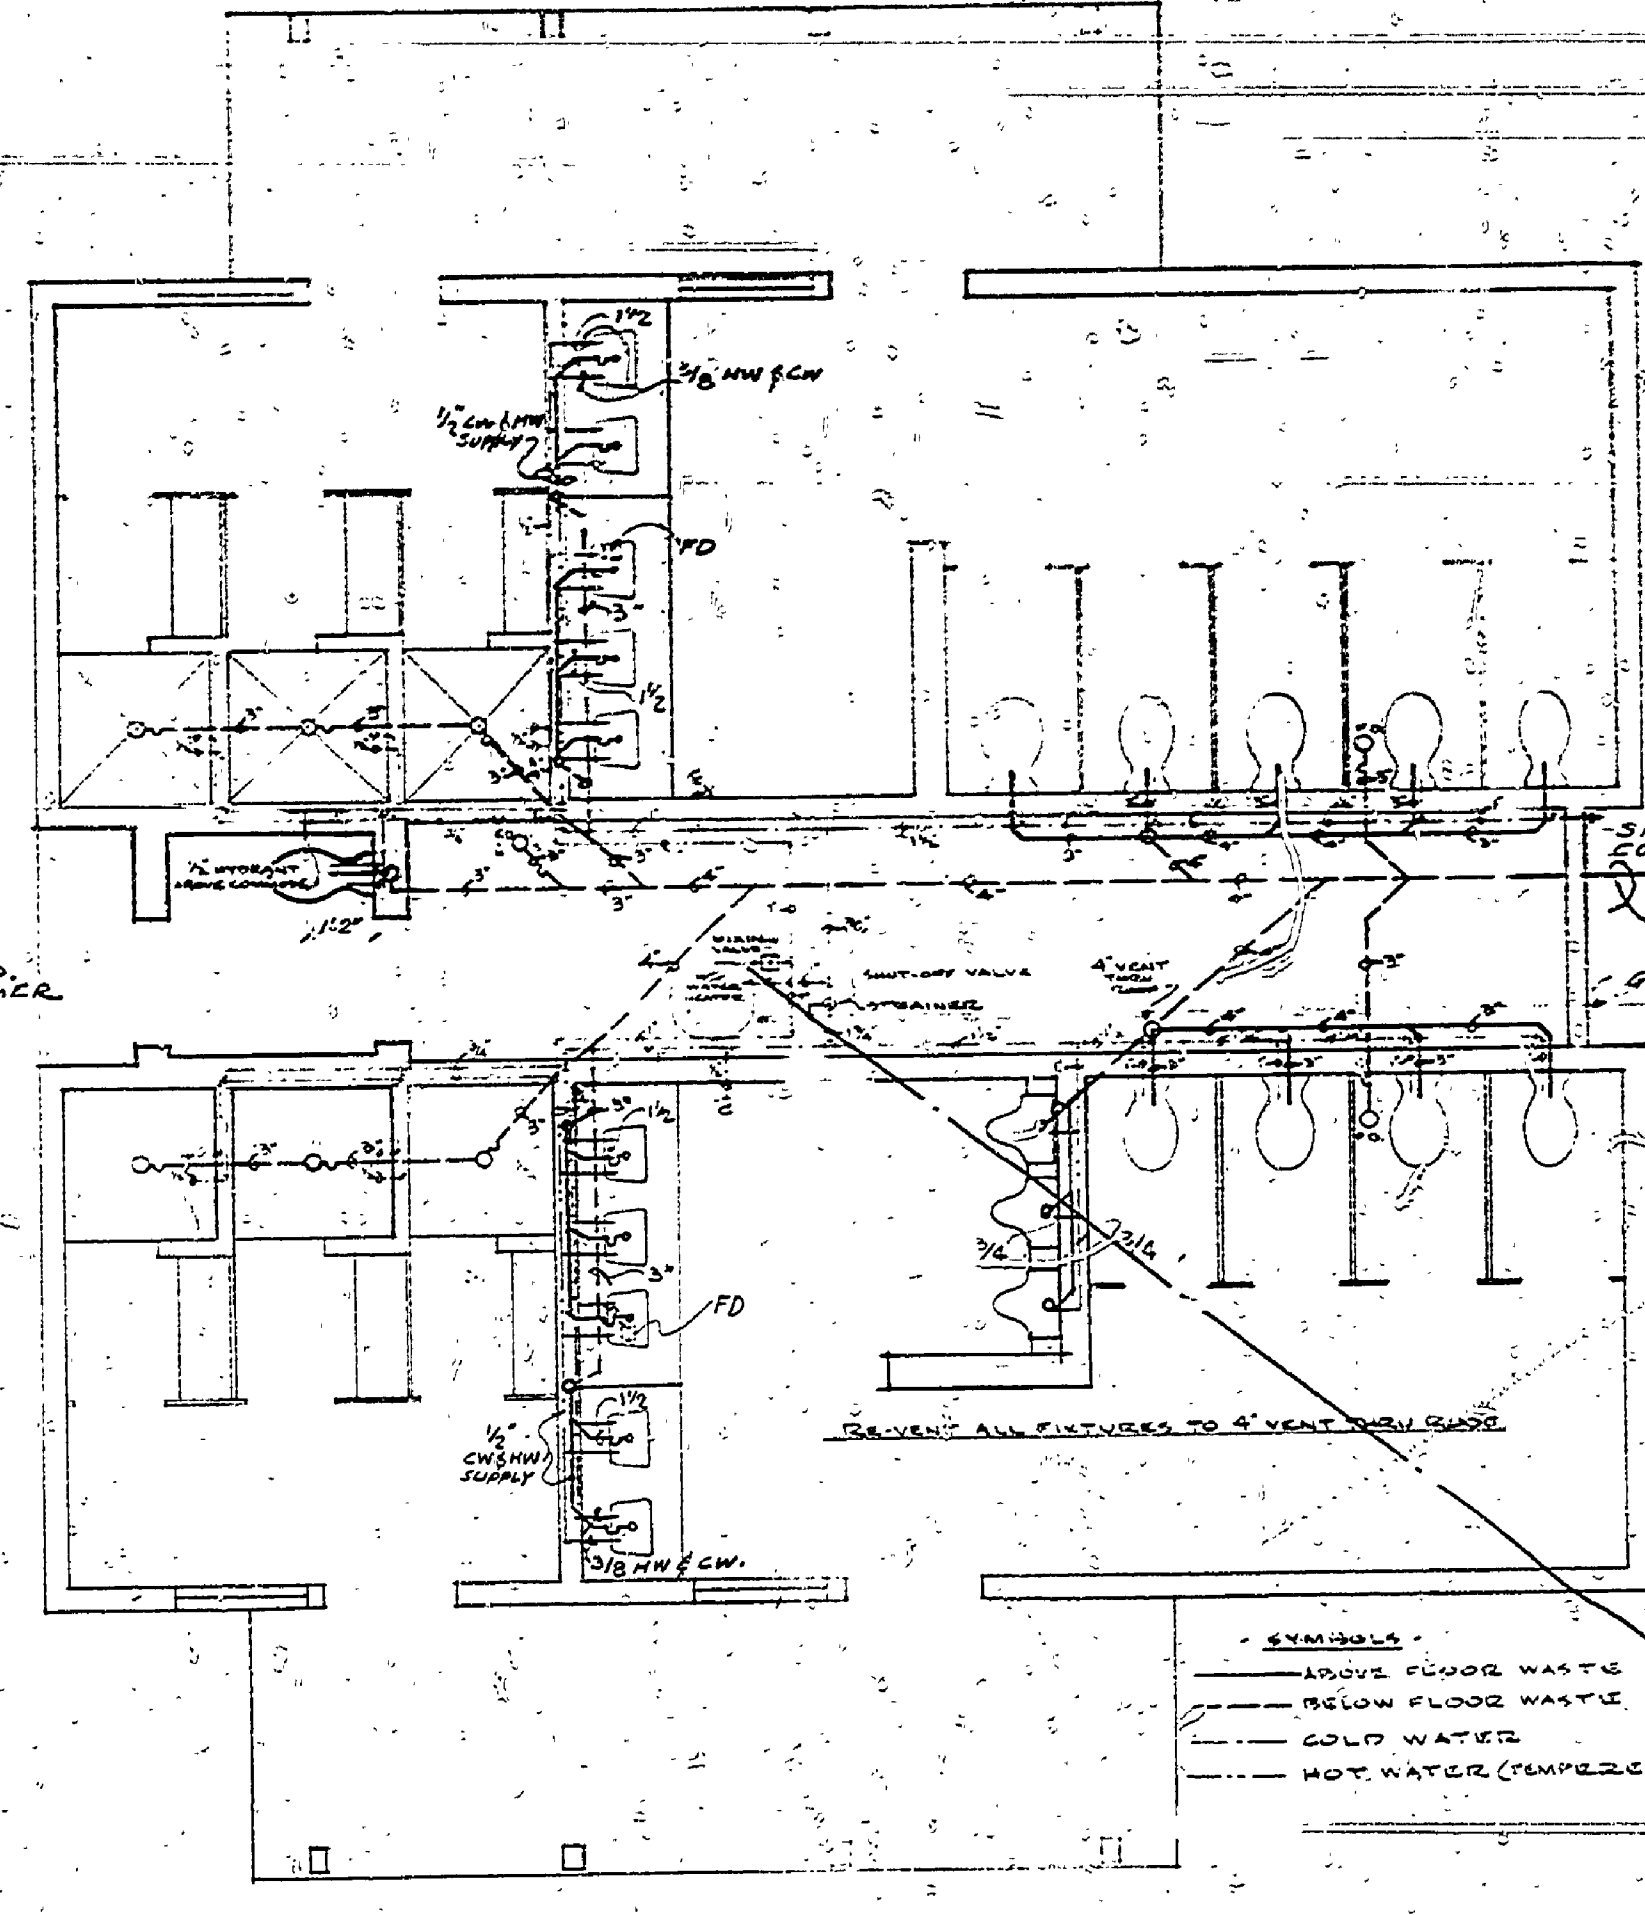


PLUMBING PLAN
1/2" = 1'-0"

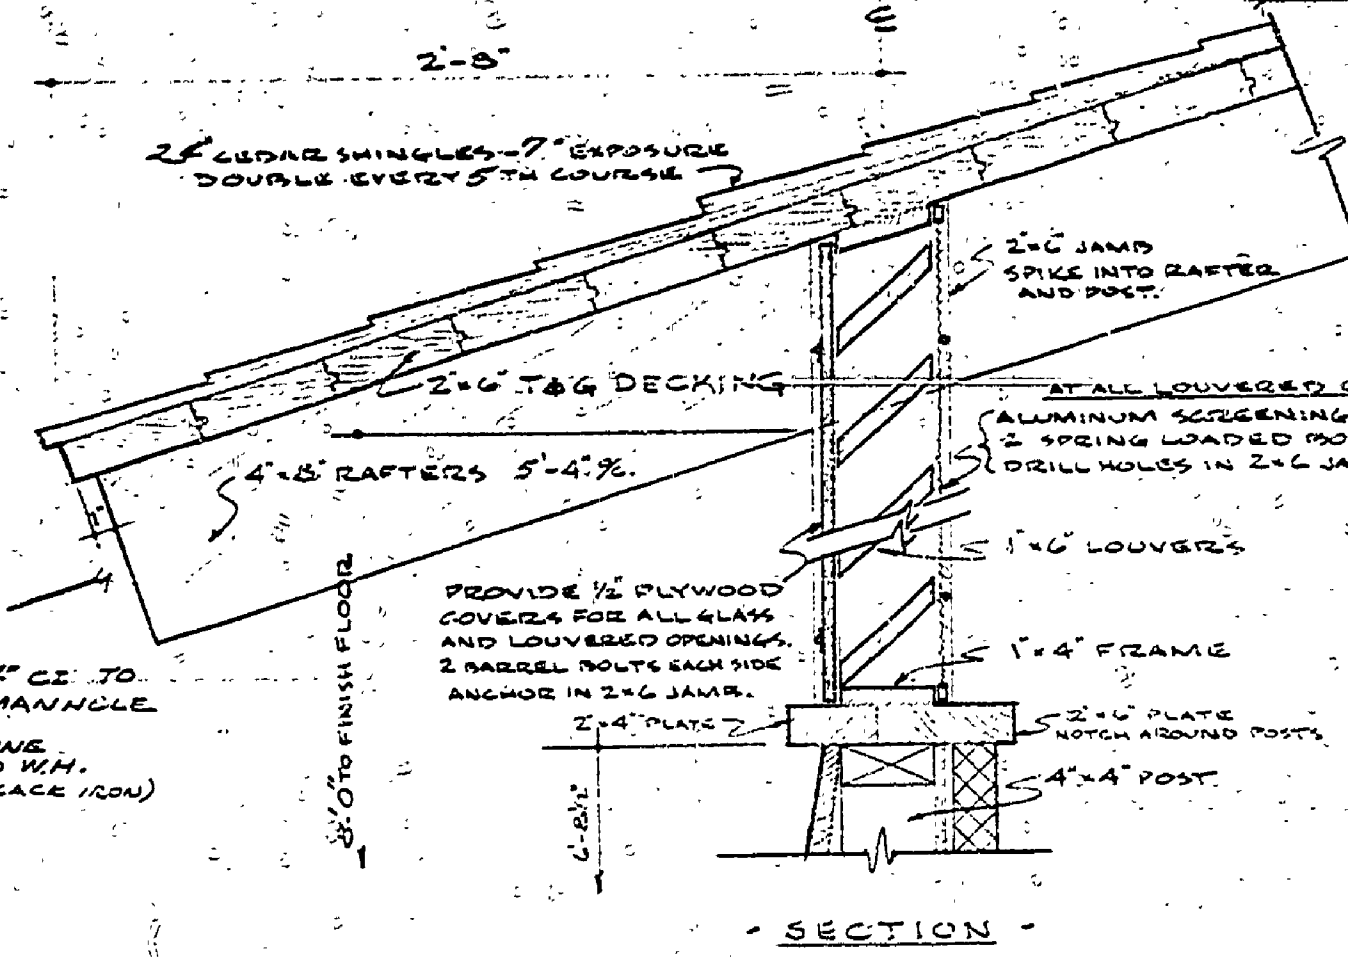

SECTION
1/2" = 1'-0"

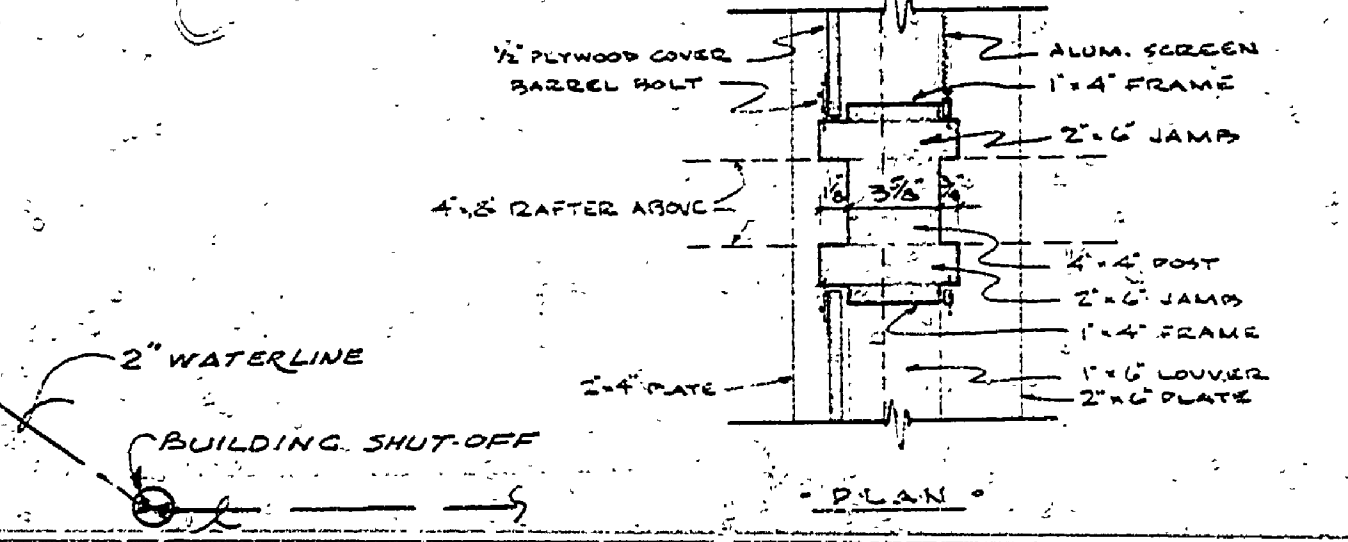

FOUNDATION SECTION
1/2" = 1'-0"

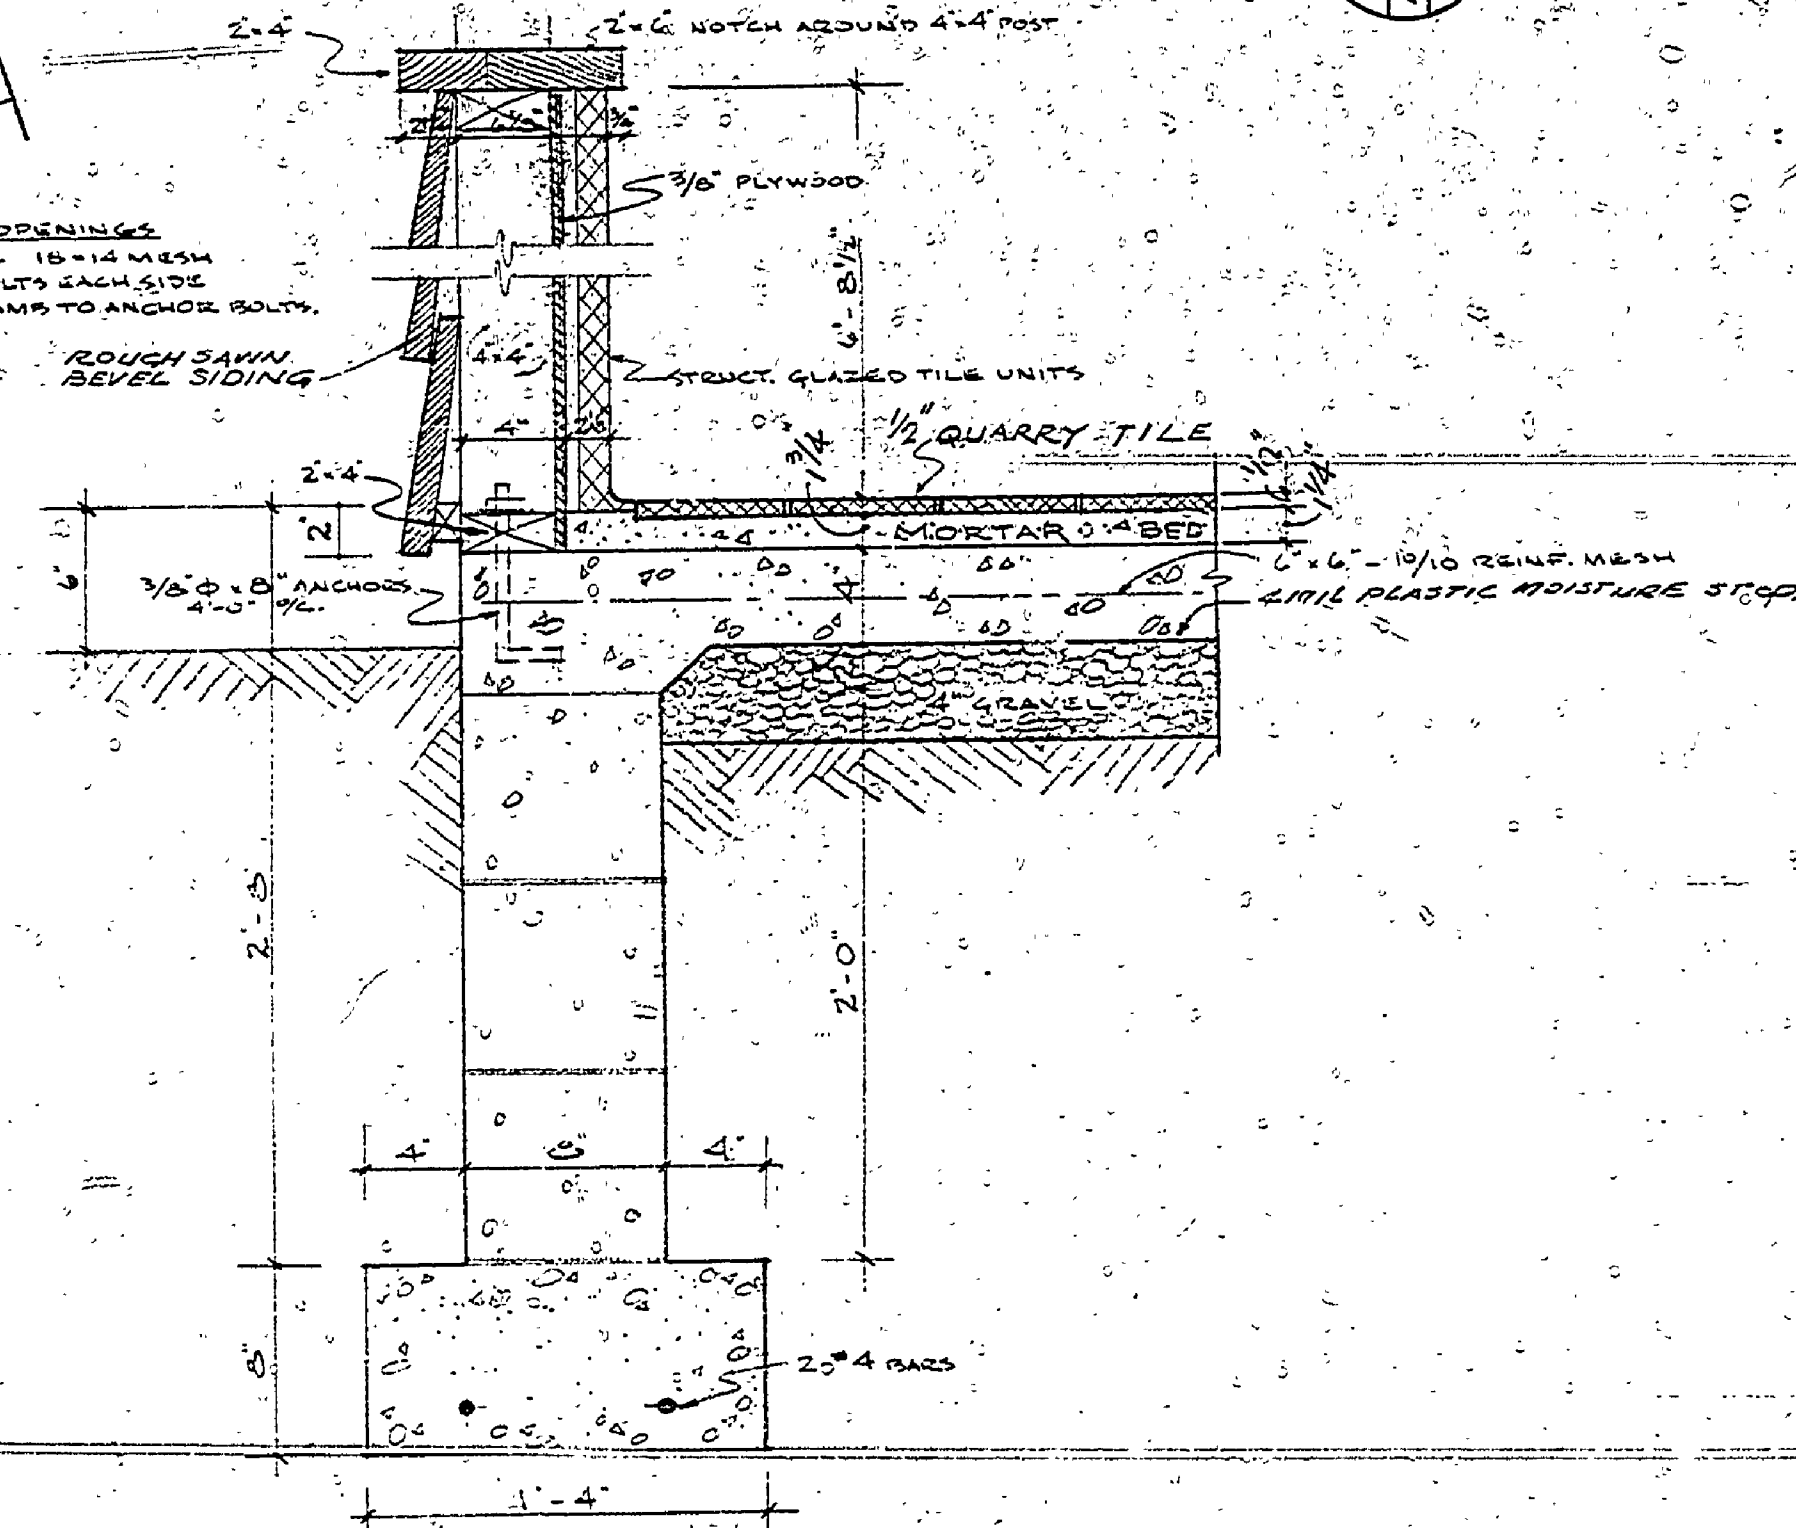

FOUNDATION SECTION
1/2" = 1'-0"

SURVEYED BY		DRAWN BY R.R.		4/11/72	NO.	DATE	BY	REVISIONS	NO.	DATE	BY	REVISIONS	MICHIGAN DEPARTMENT OF CONSERVATION		BURT LAKE TOILET BUILDING		SHEET NO. 2 OF 3 FOR PROJECT NO. 24-1315		PLANS & CONSTRUCTION DETAILS SHEET 2 OF 3 PLAN NO. A-110	
DESIGNED BY		CHECKED BY			1.				4.											
DATE		DATE			2.															