




SIDE ELEVATION

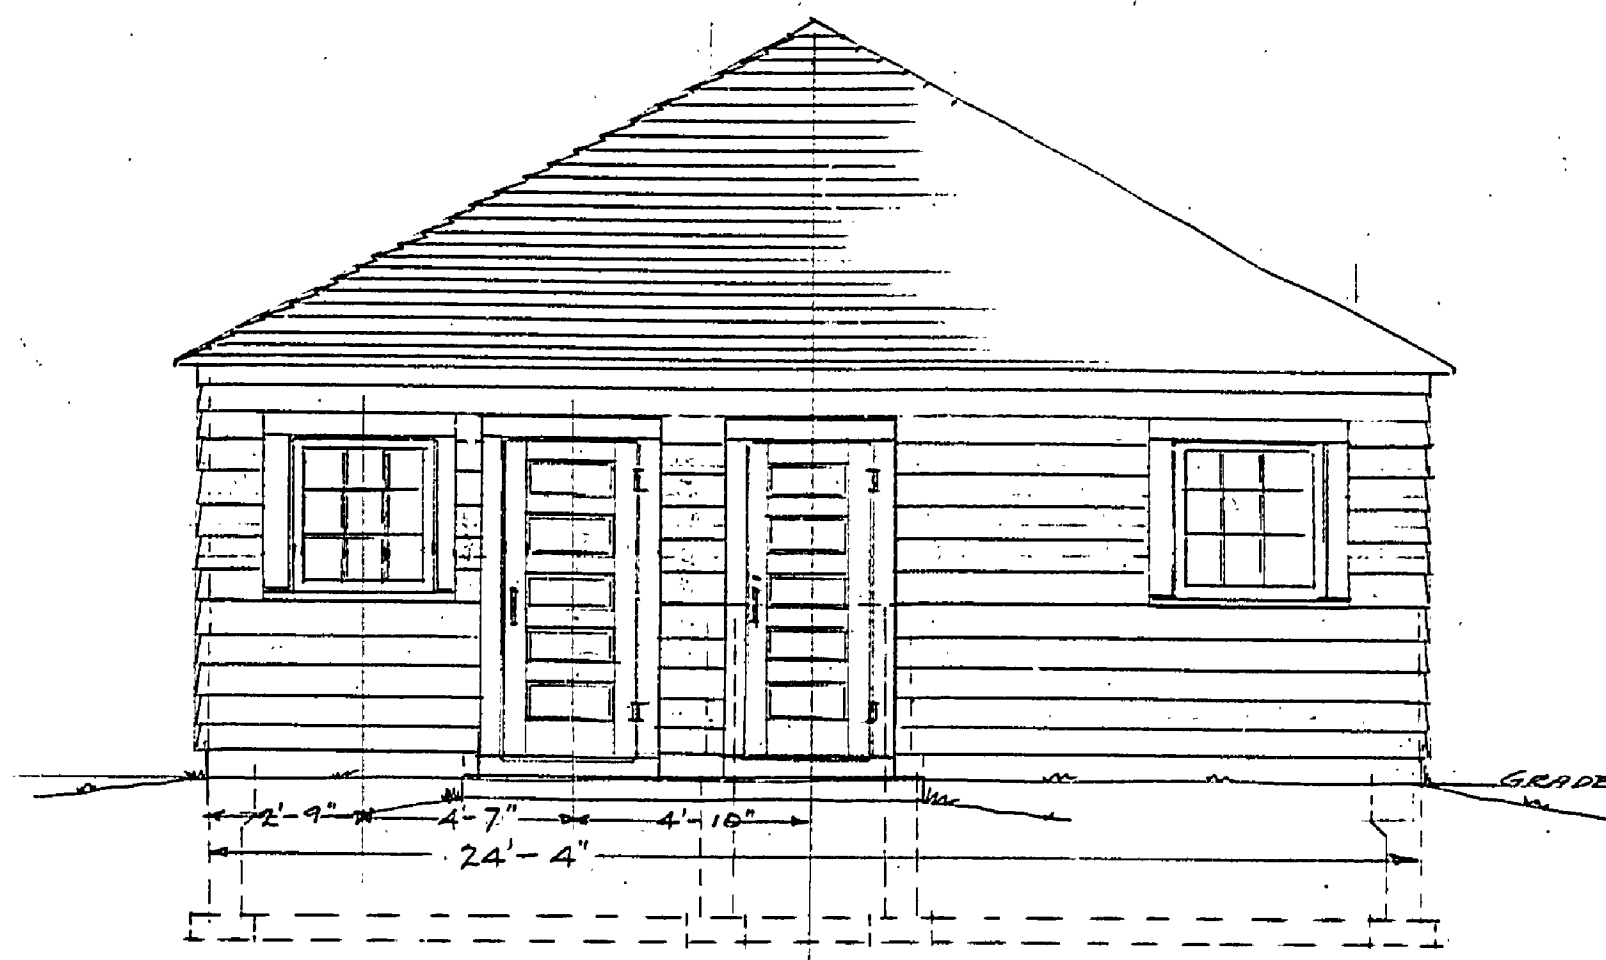


END ELEVATION
SHOWING ENTRANCE TO PIPE PASSAGE

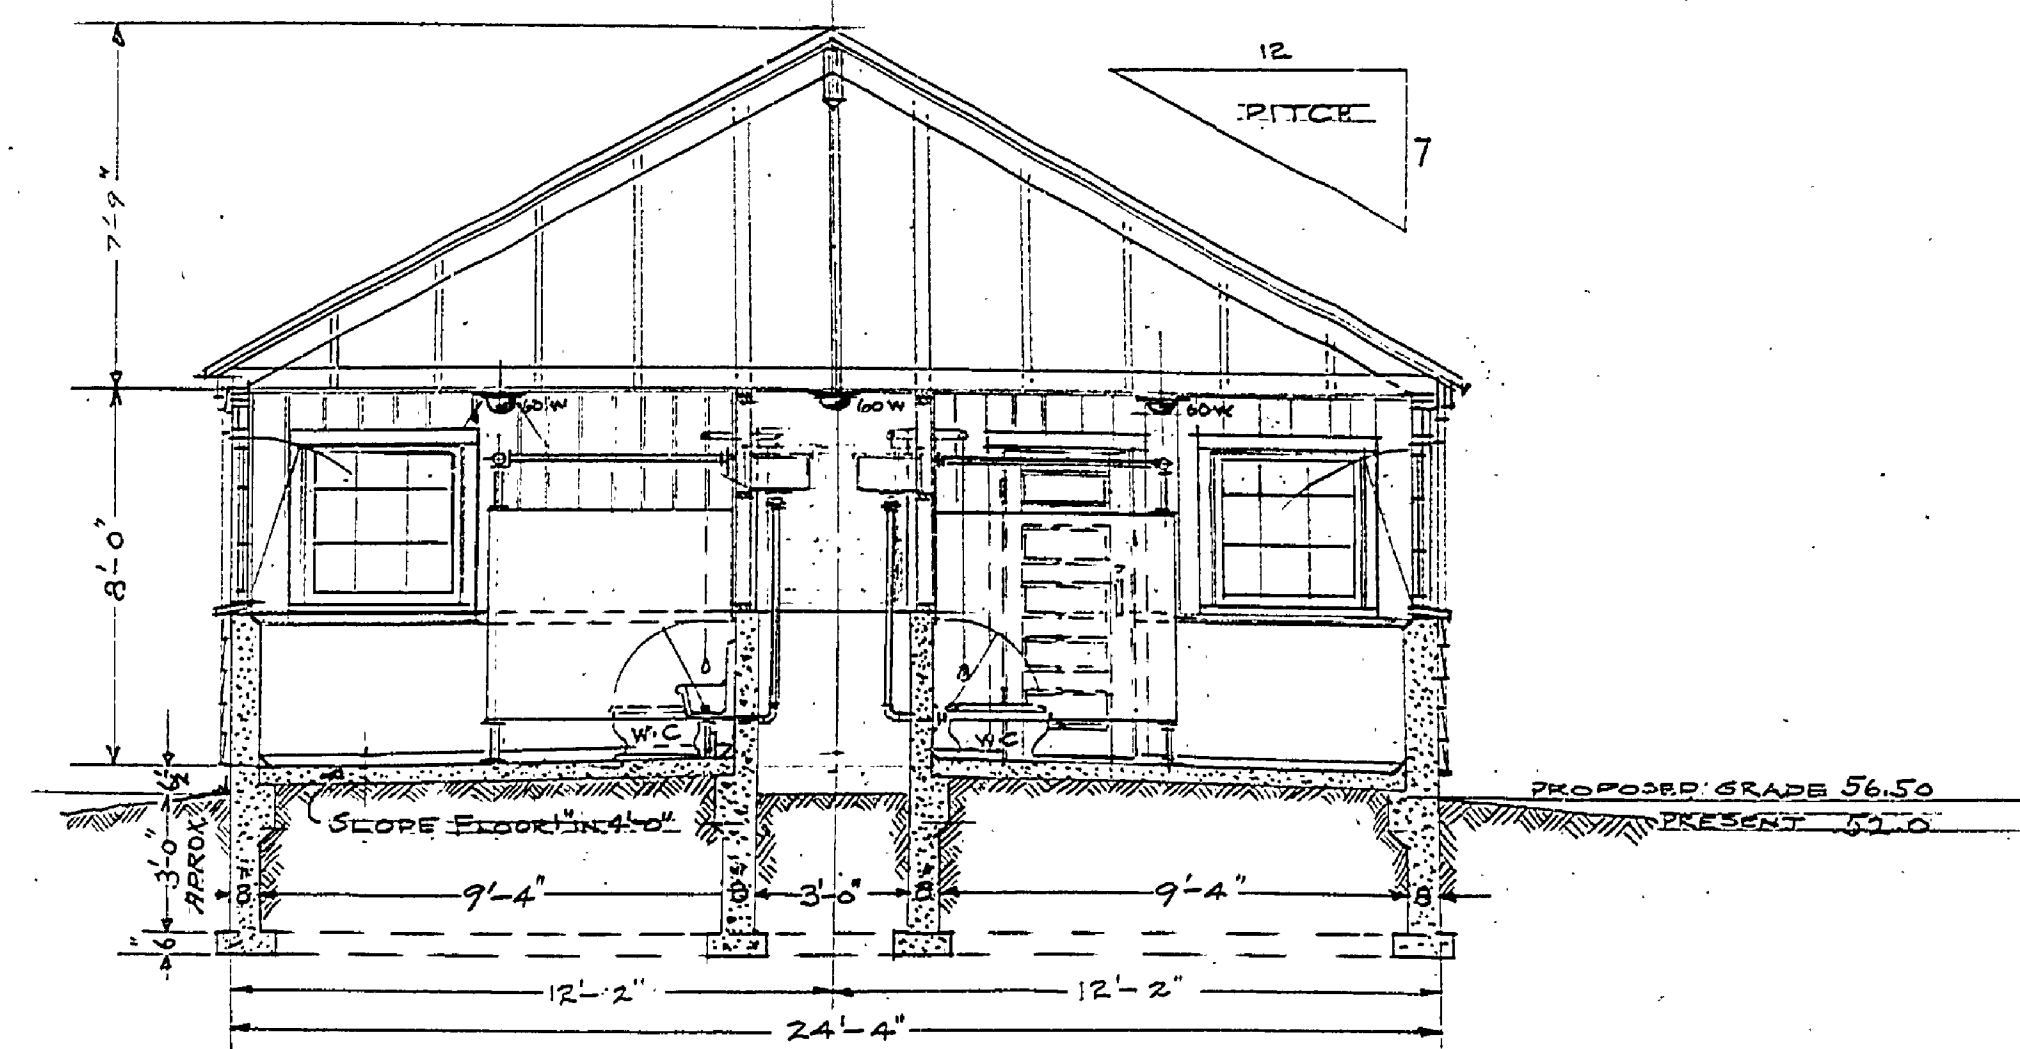


CROSS SECTION A-A

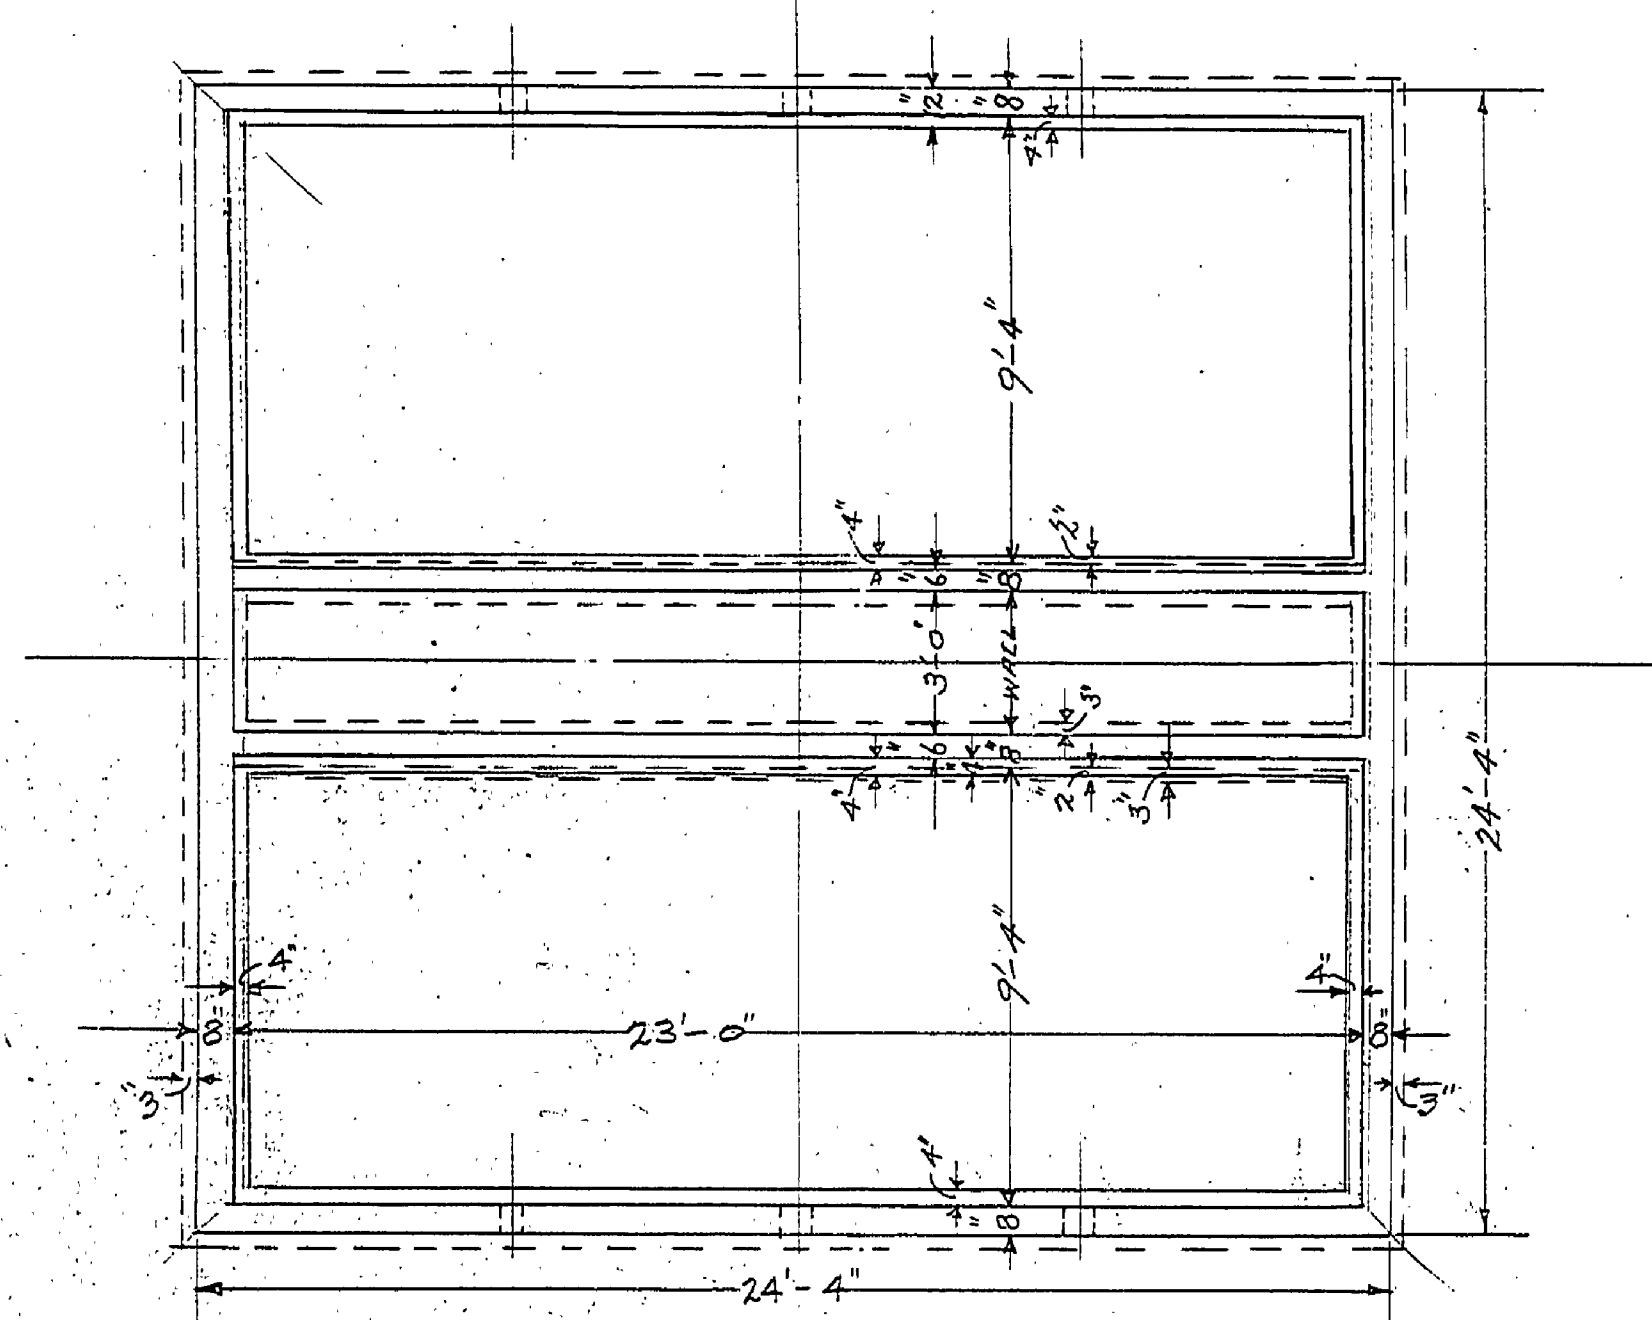


FOUNDATION PLAN

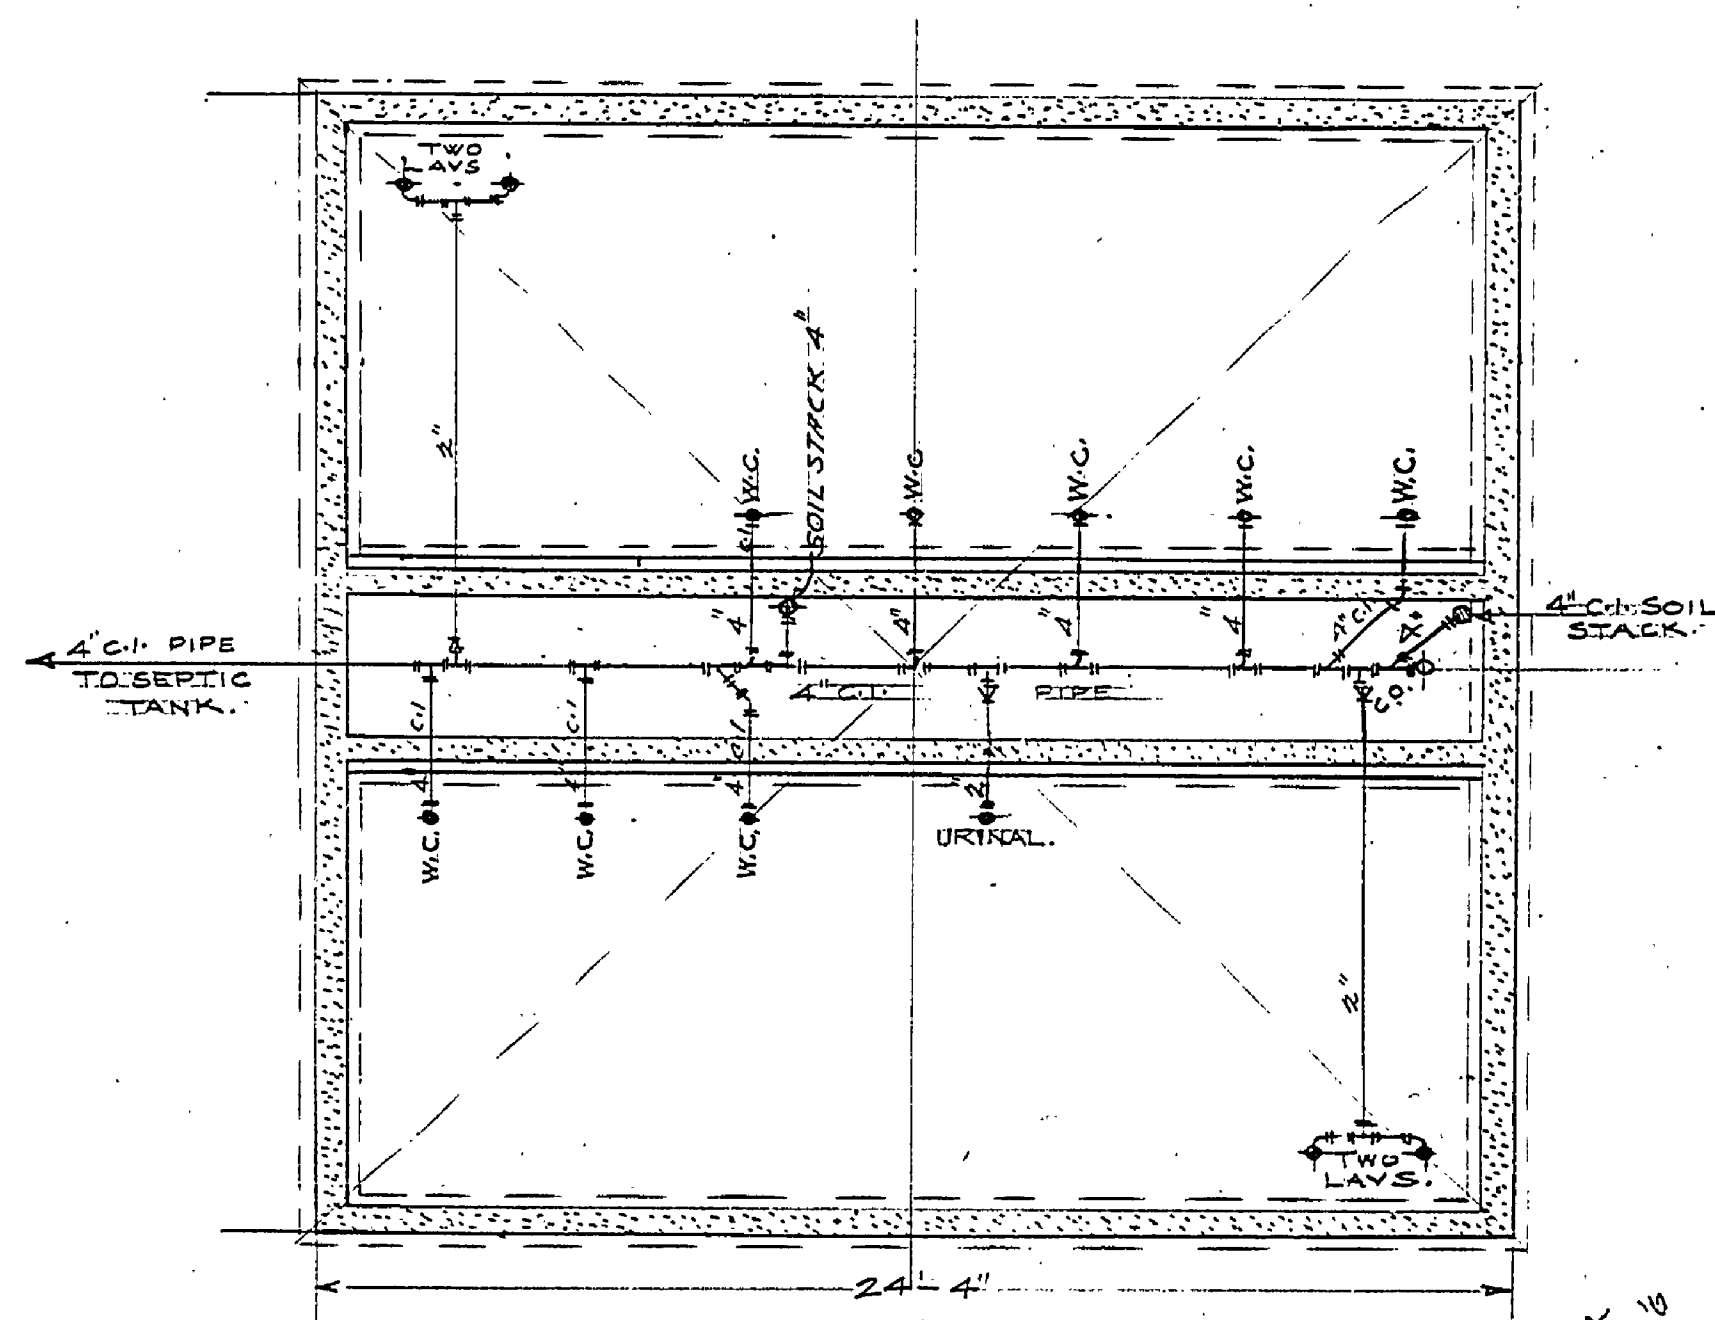


PIPING PLAN

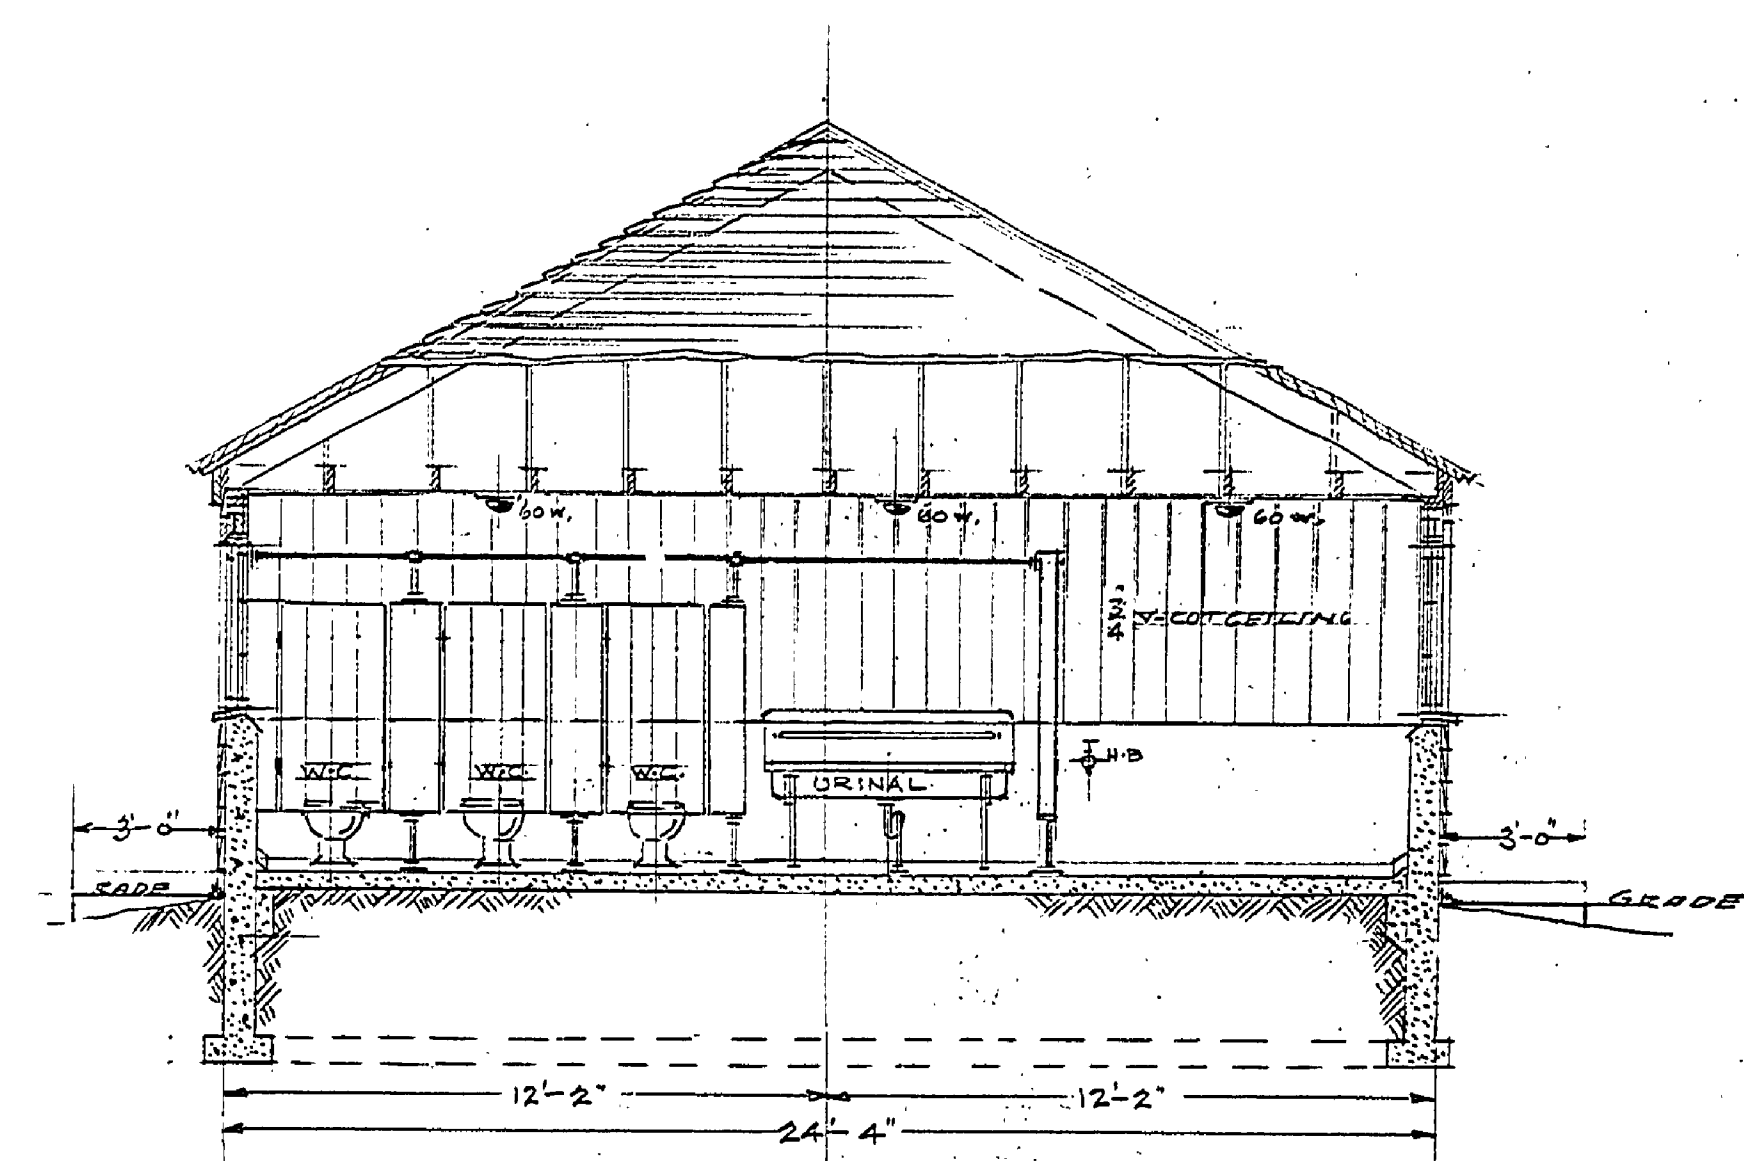


CROSS SECTION C-C

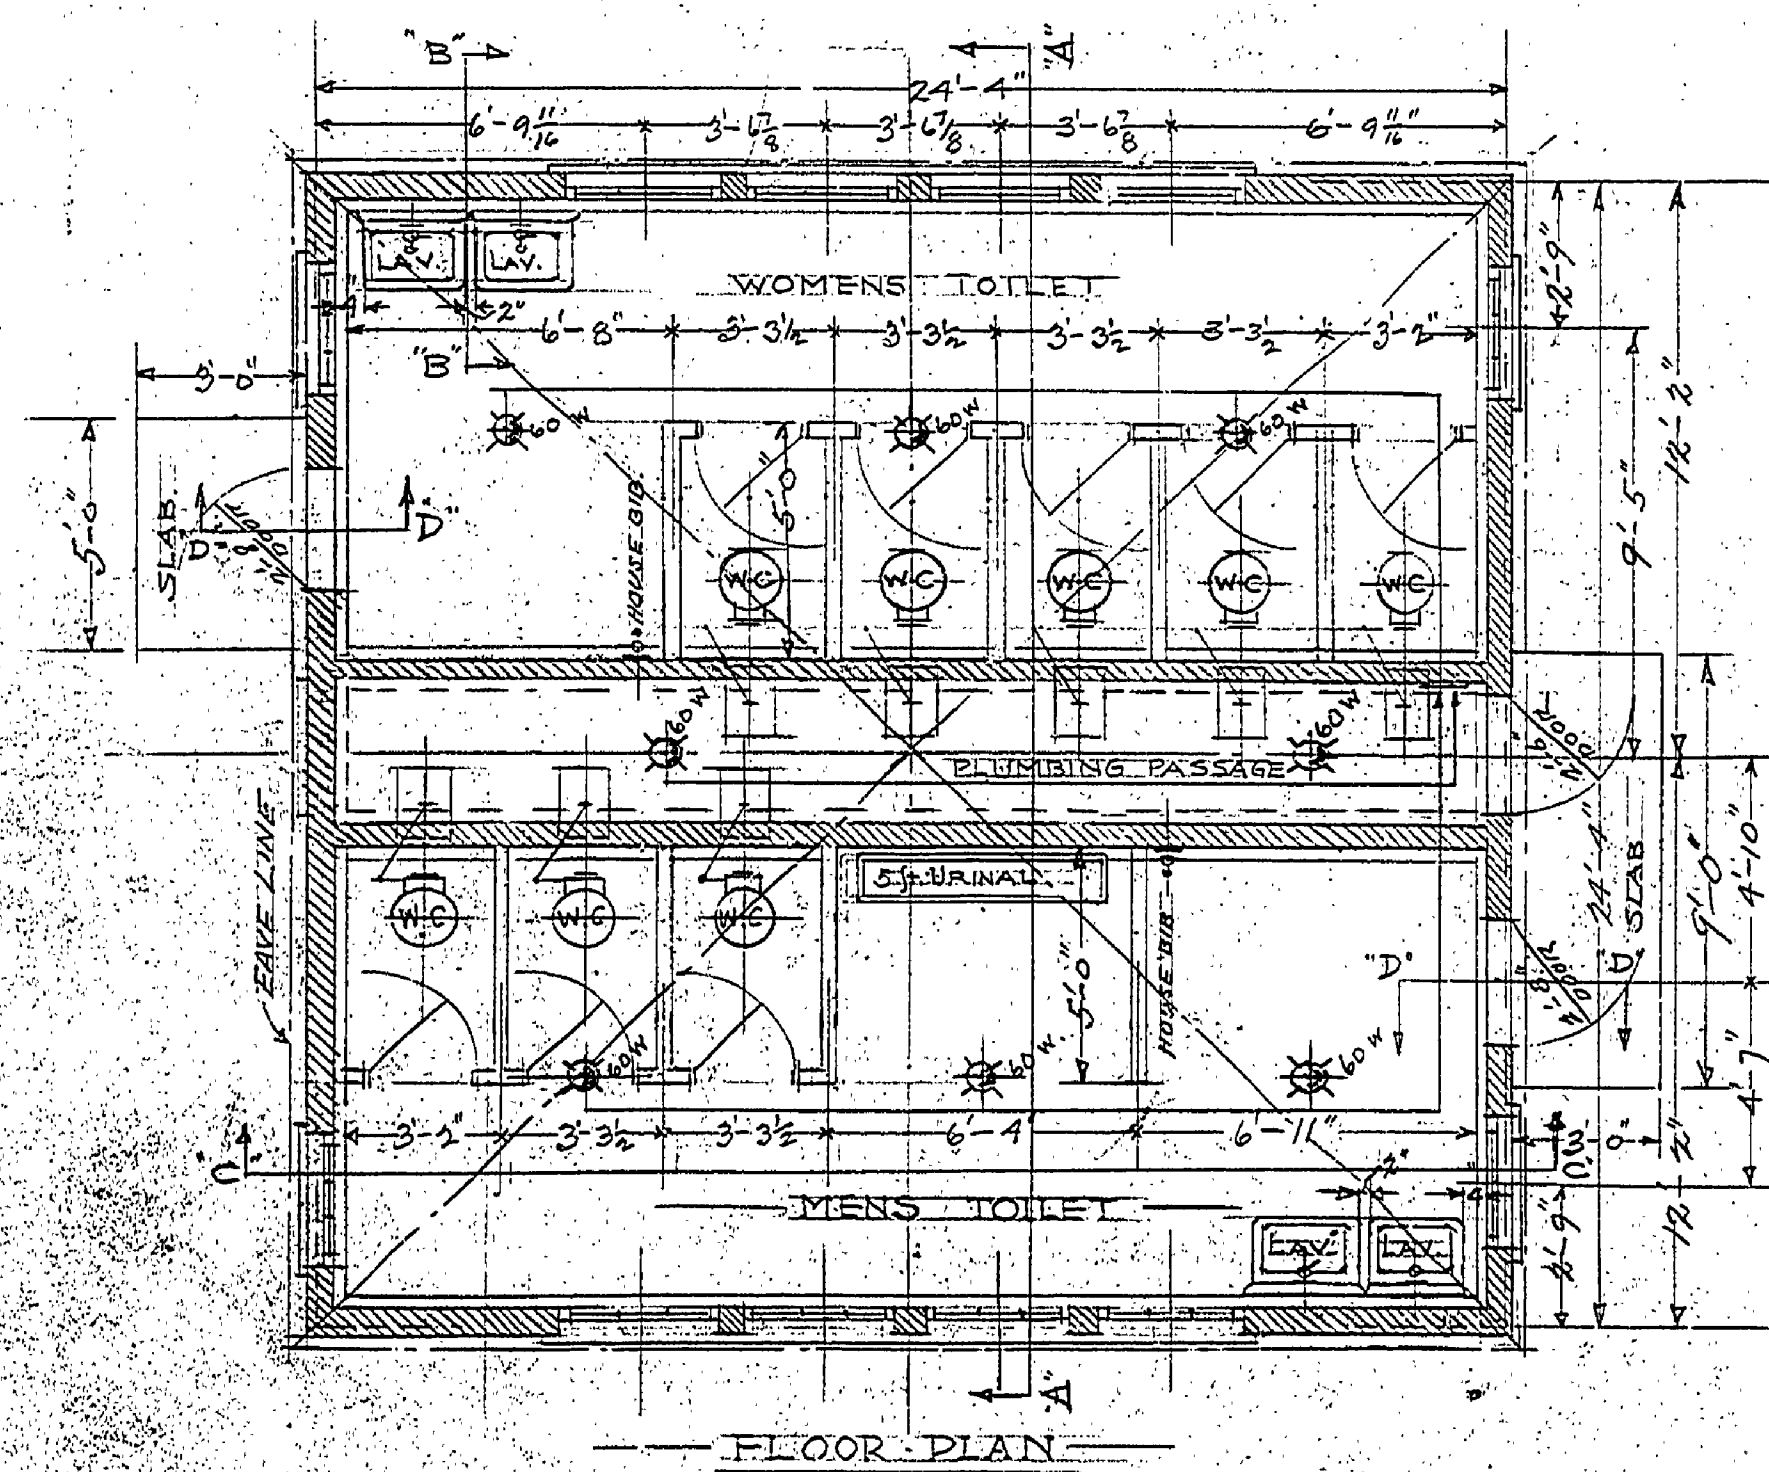

FLOOR PLAN

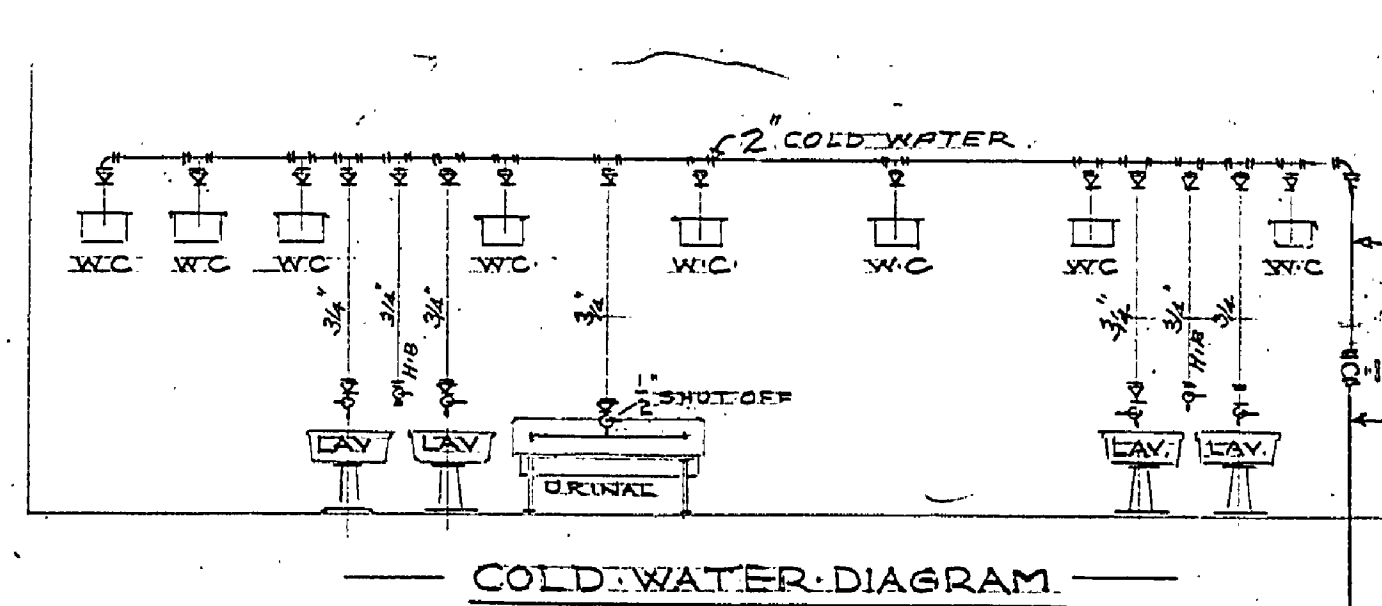


COLD WATER DIAGRAM

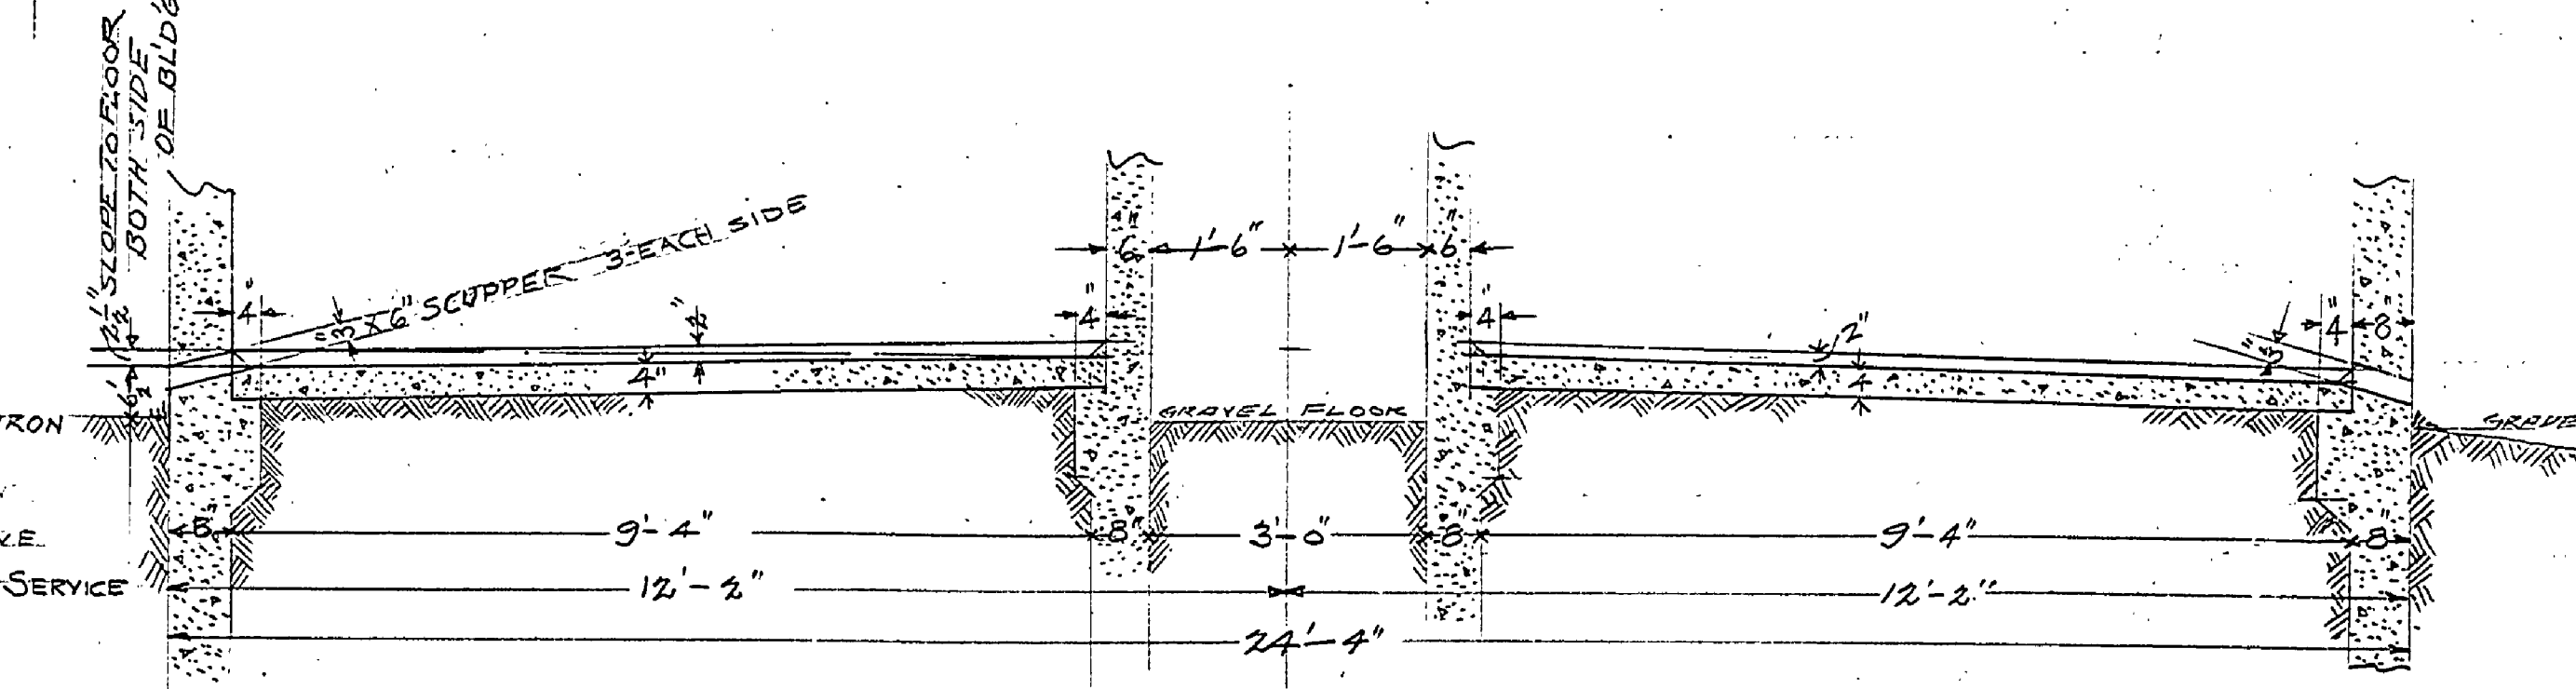

SECTION A-A

SHOWING SLOPE OF FLOOR.
Scale: 1/2" = 1'-0"

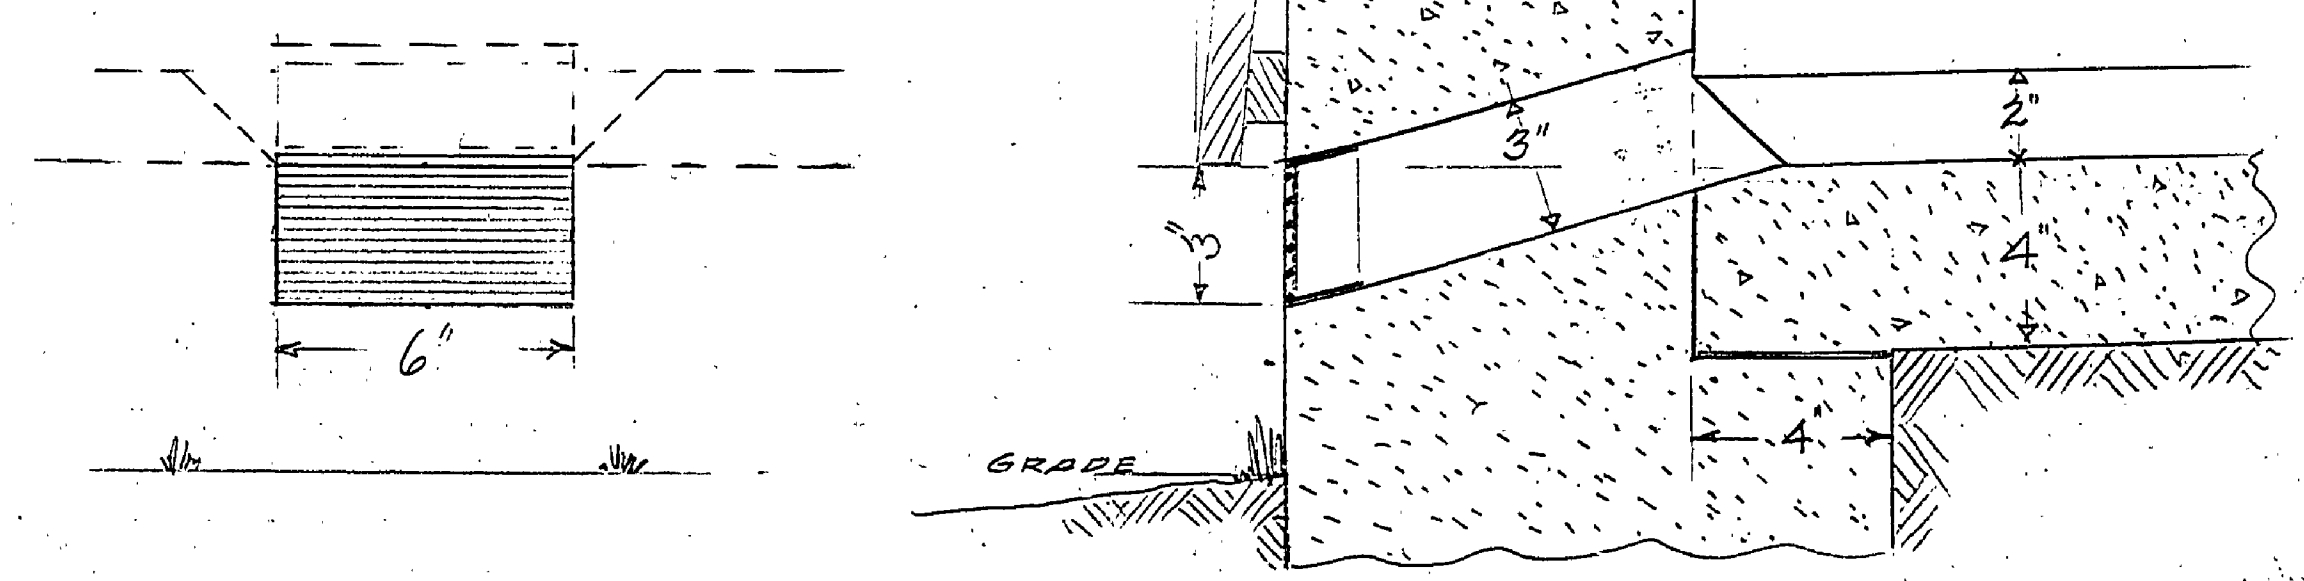

DETAIL OF SCUPPERS

Scale: 3" = 1'-0"

UNITED STATES DEPARTMENT OF THE INTERIOR NATIONAL PARK SERVICE MICH. DEPT. OF CONSERVATION COOPERATING			
DRAWN BY E.W.G.	YANKEE SPRINGS AREA	PLANS 90-89	NO. 1 of 2
DESIGNED BY E.W.G.	BI-SEXUAL LATRINE	SCALE AS SHN.	LD-MI-6
CHECKED BY E.P.C.	JOB. NO. 291	DATE	
RECOMMENDED BY <i>Shaul R. ...</i>	DATE	2-15-40	
RECOMMENDED BY	INSPECTOR	DATE	
APPROVED BY	PARK AUTHORITY OR SPONSOR	DATE	
APPROVED BY	REGIONAL DIRECTOR	DATE	

INSURANCE No. 15 #15

Job #241 Camp Ground

AUG 1940
11-112