




FIRST FLOOR PLUMBING PLAN

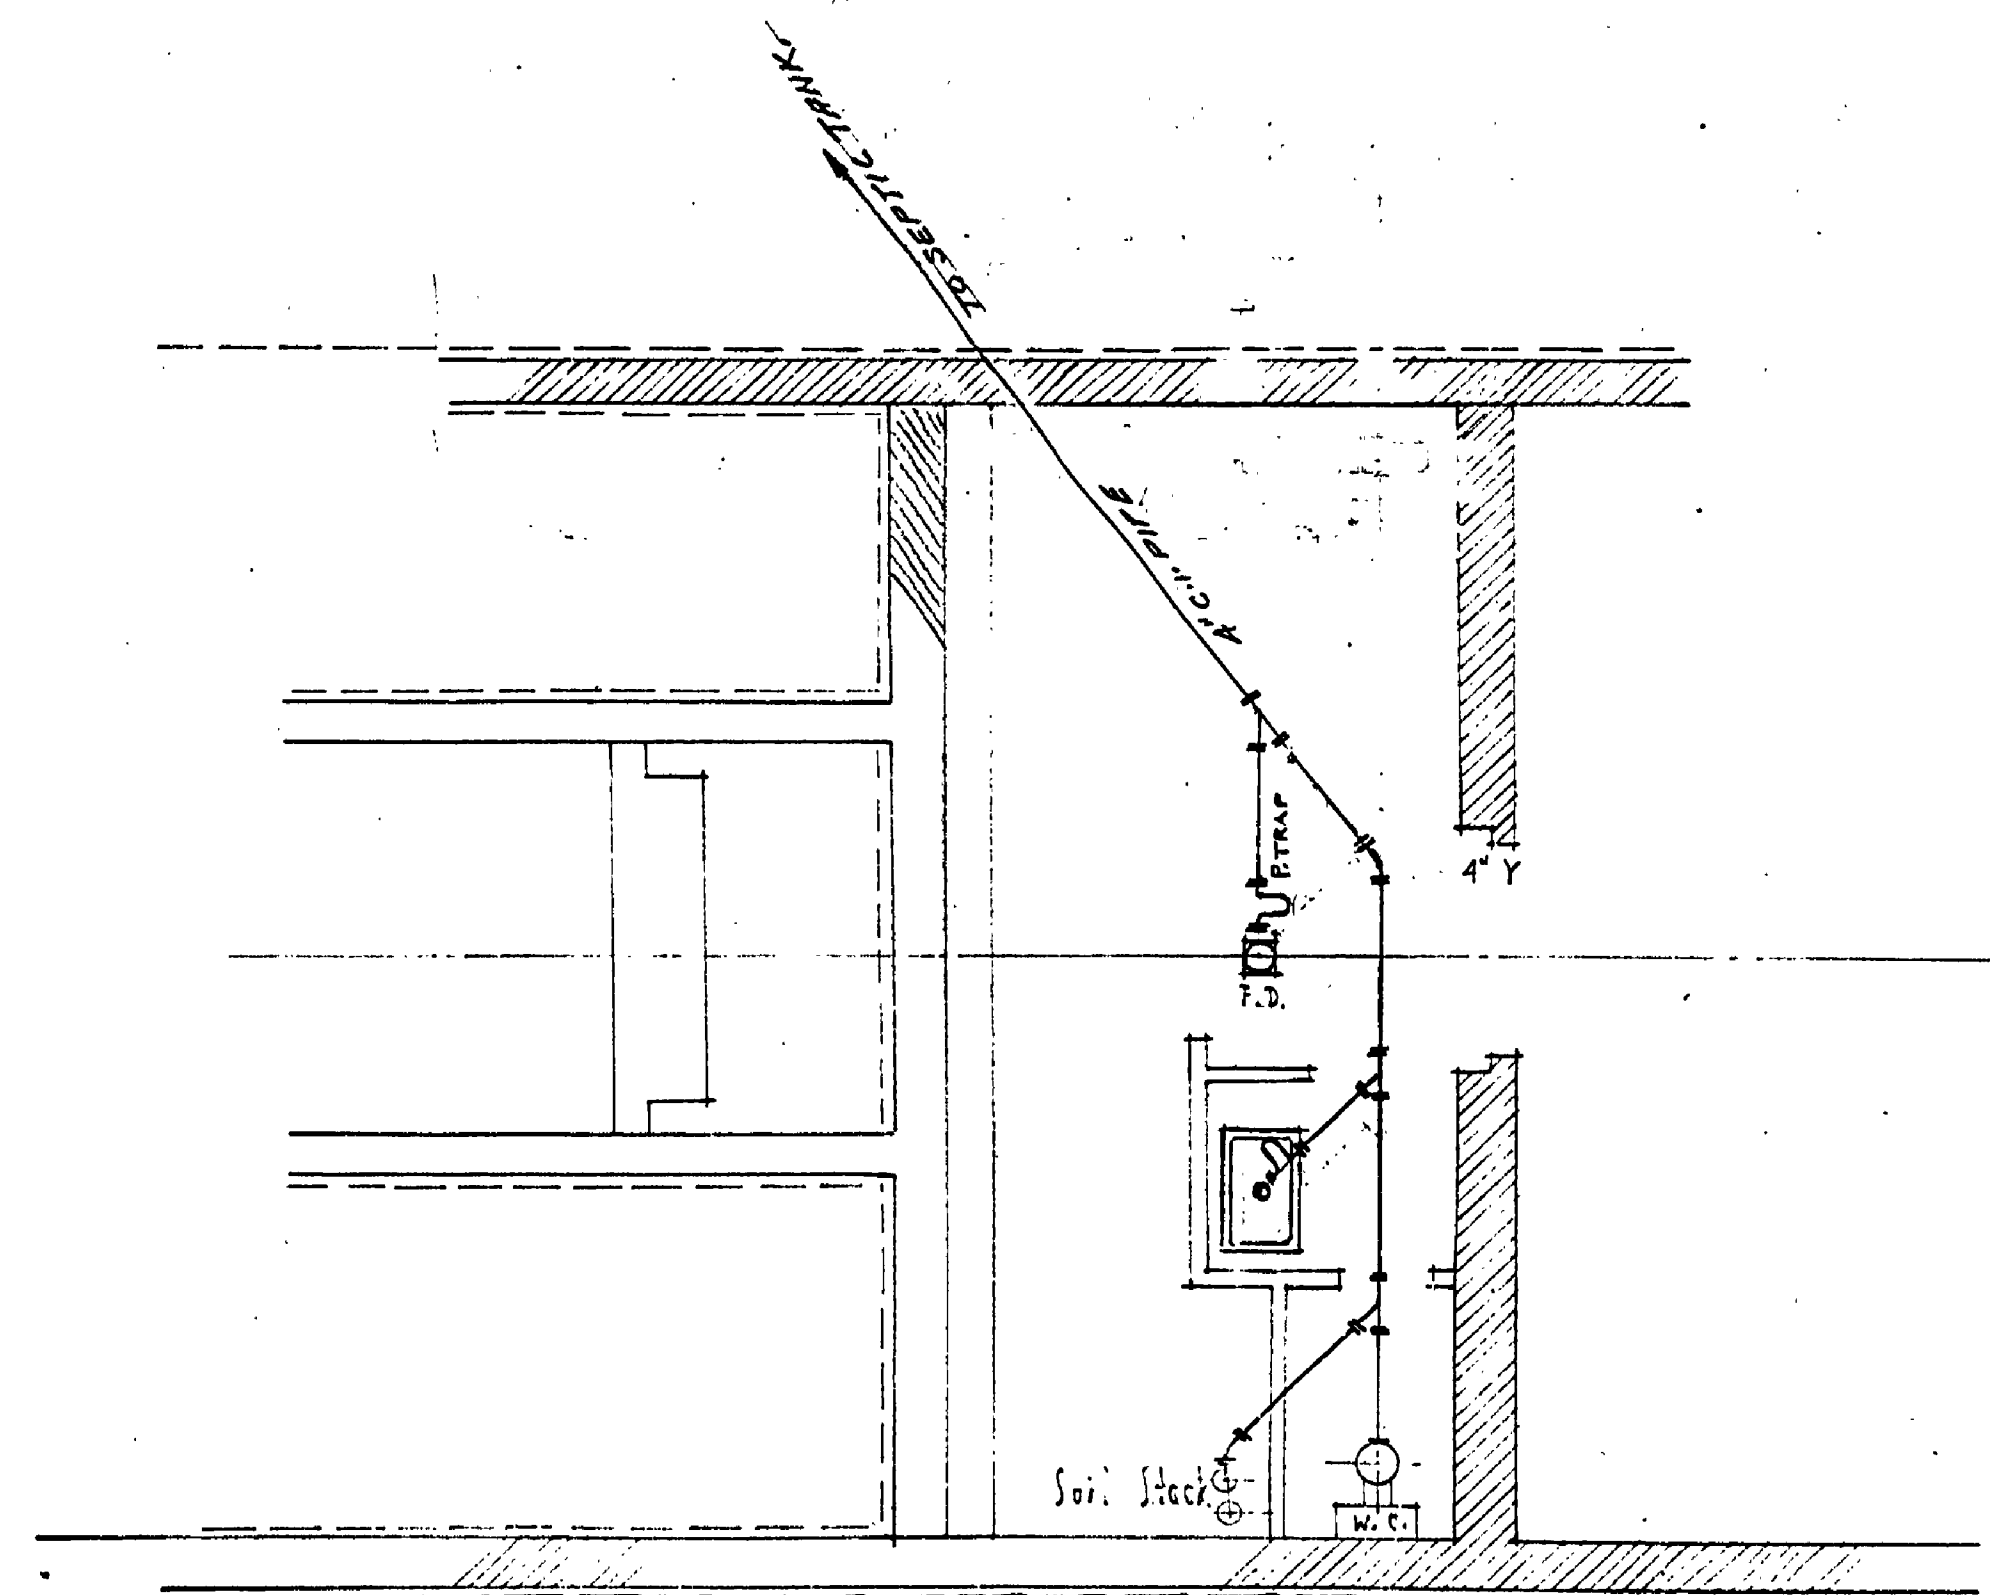

BASEMENT PLUMBING PLAN

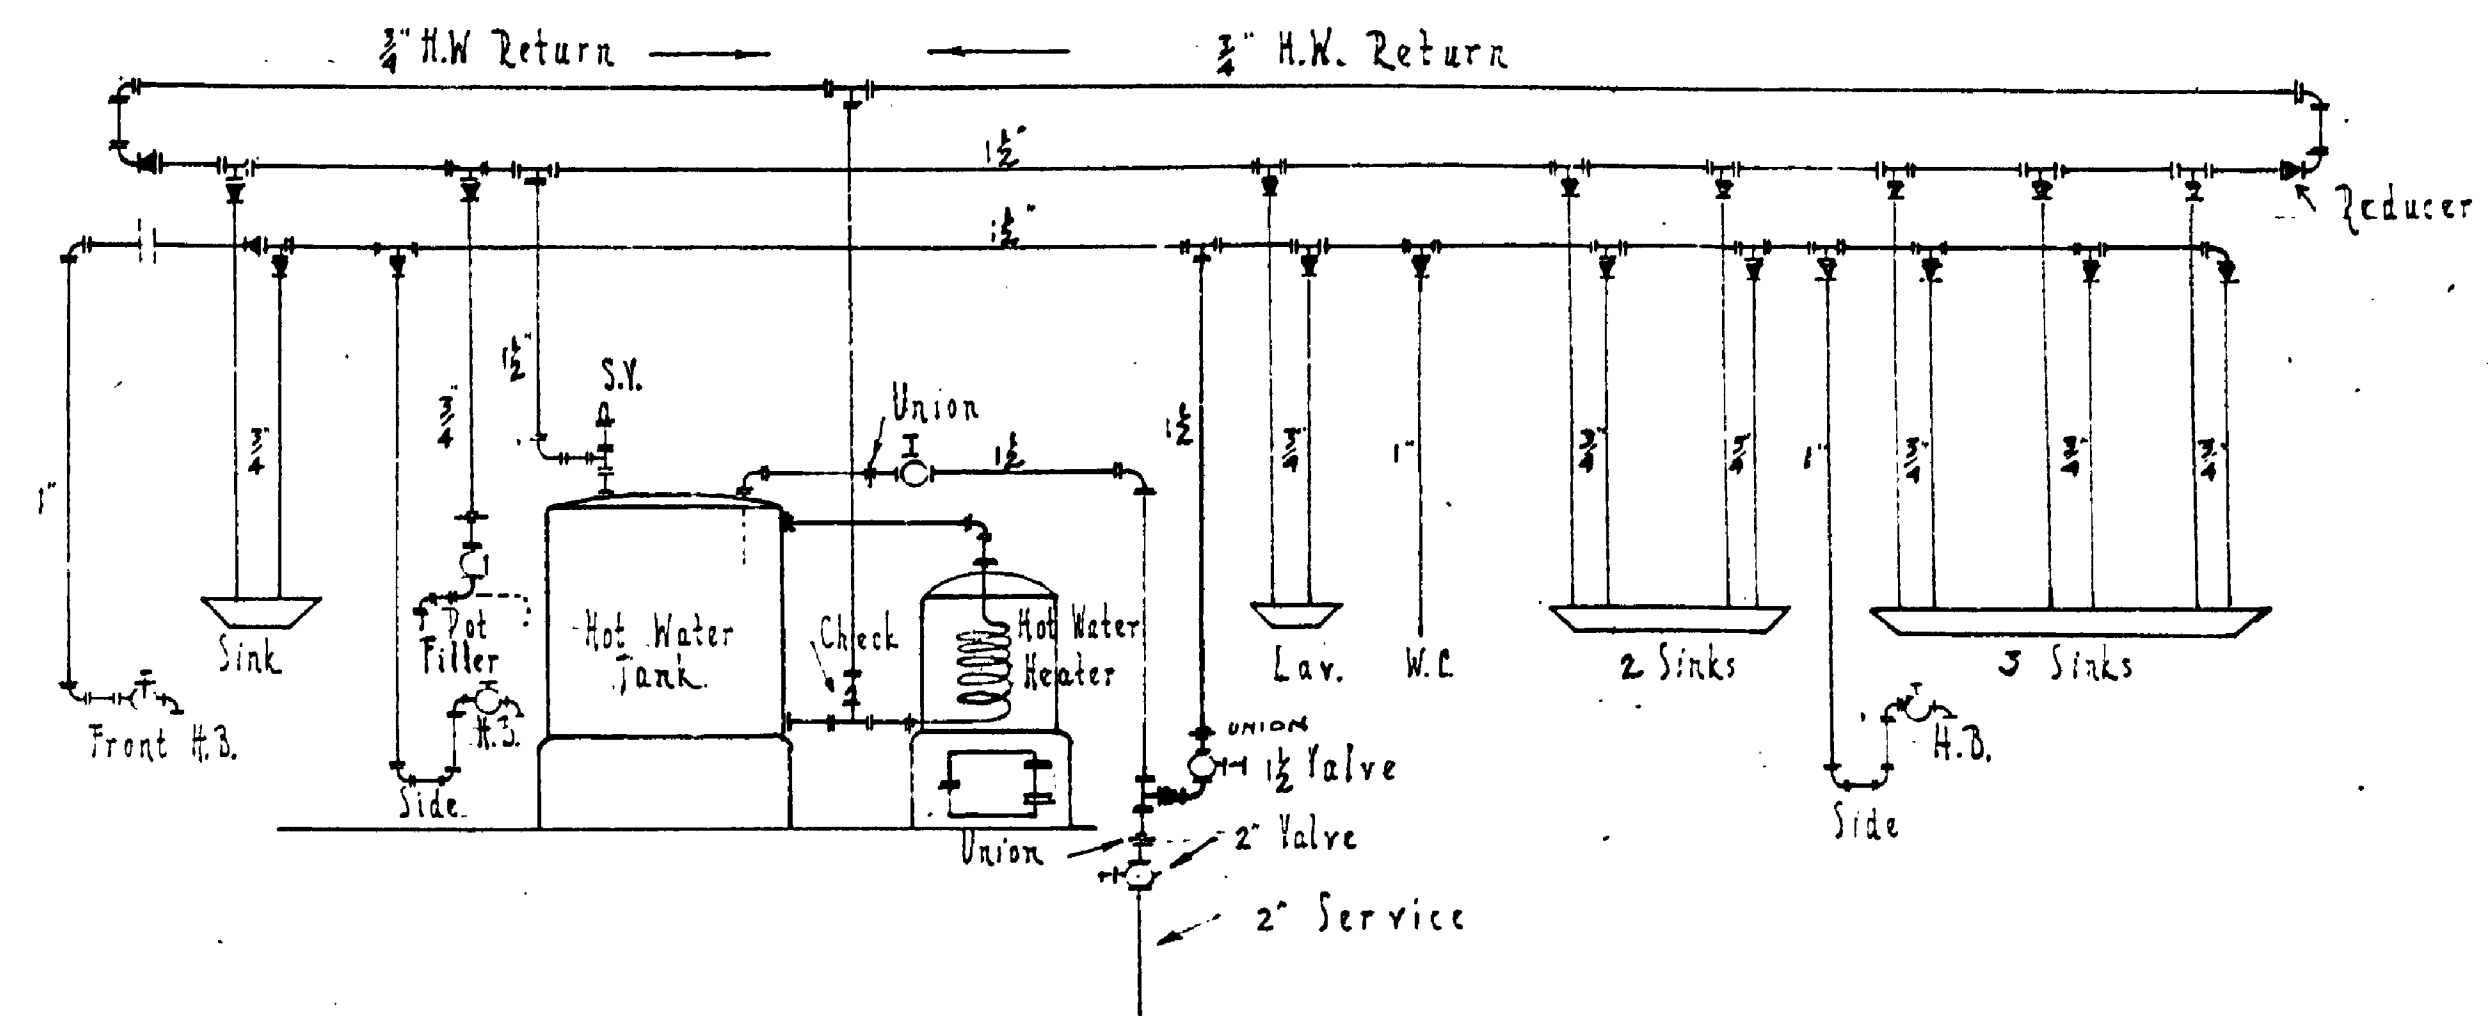

HOT AND COLD WATER DIAGRAM

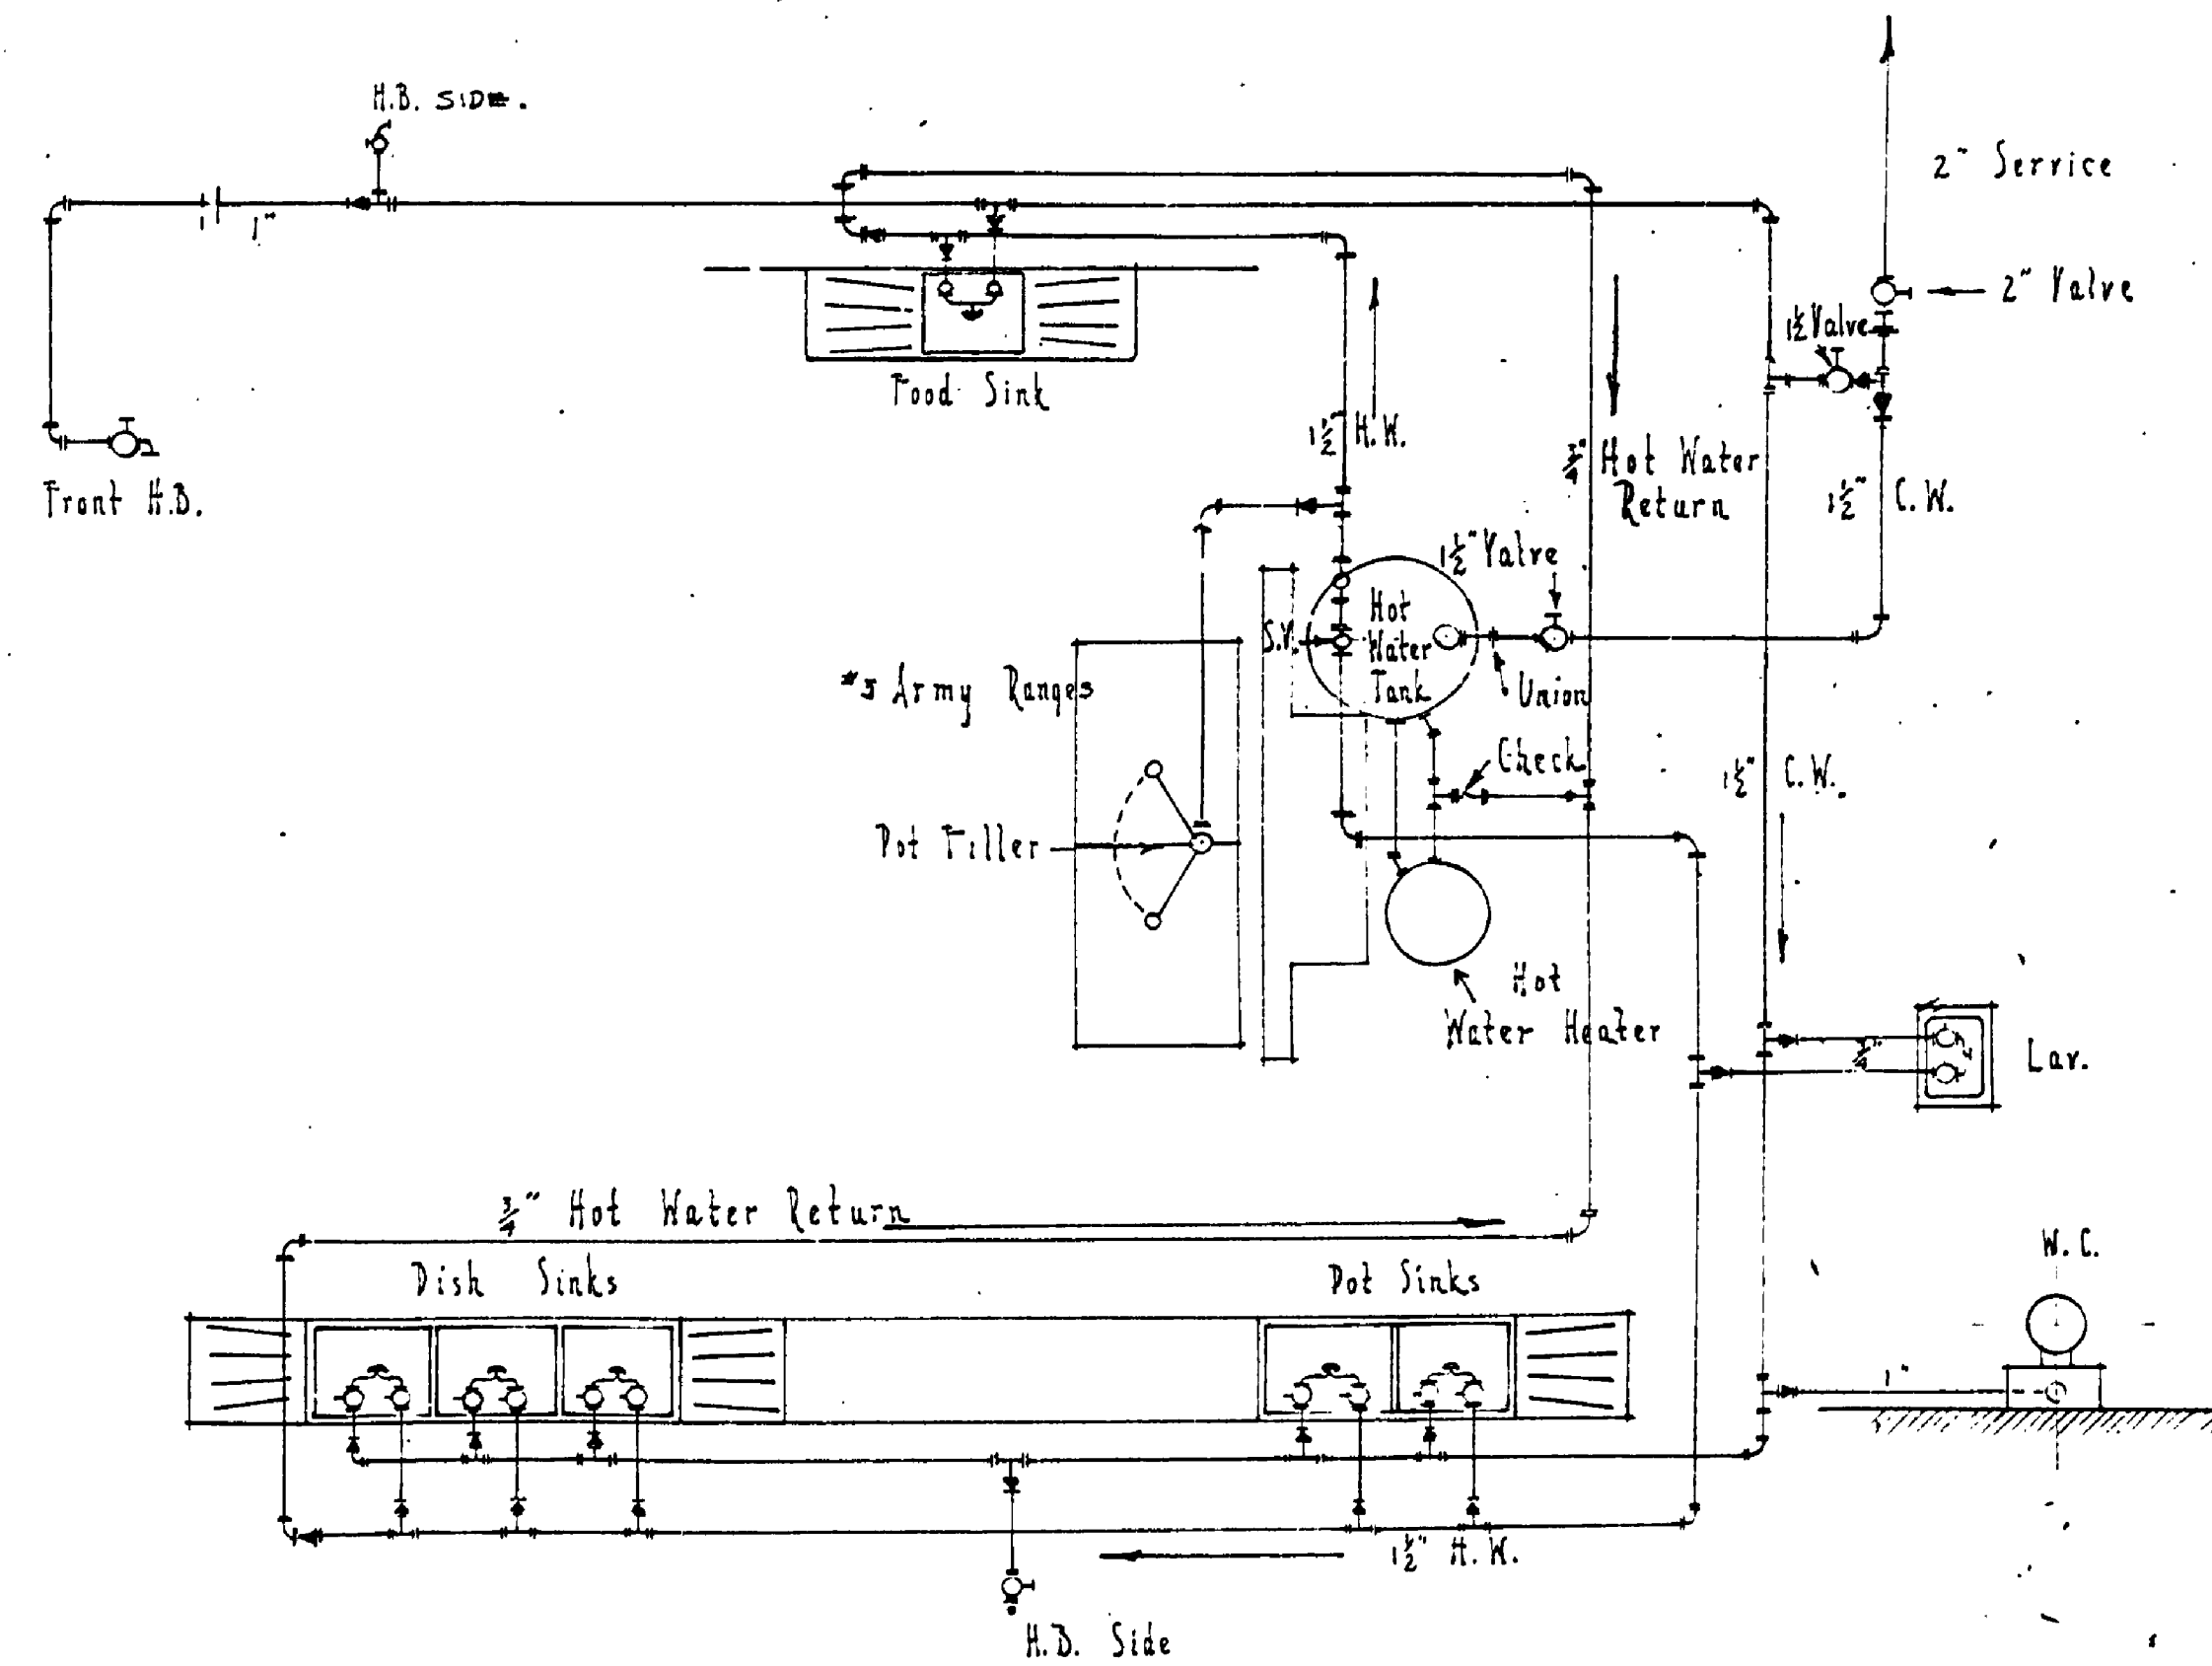

PLAN

UNITED STATES DEPARTMENT OF THE INTERIOR NATIONAL PARK SERVICE COOPERATING WITH MICHIGAN DEPARTMENT OF CONSERVATION		
DRAWN BY <i>E. W. G.</i>	PROJECT YANKEE SPRINGS PROJECT DINING HALL LONG LAKE ACRES 4-19-215	PLAN NO. 51 SCALE - 1/4" = 1'-0" D-D-M-6 DATE - 4-7-38
DESIGNED BY <i>E. W. G.</i>	PROJECT MANAGER 	DATE
CHECKED BY	INSPECTOR	DATE
PREPARED AND PRINTED BY	REGIONAL DIRECTOR	DATE

INSURANCE No. 25

JOB # 63

H-120