



WASTE PLUMBING PLAN

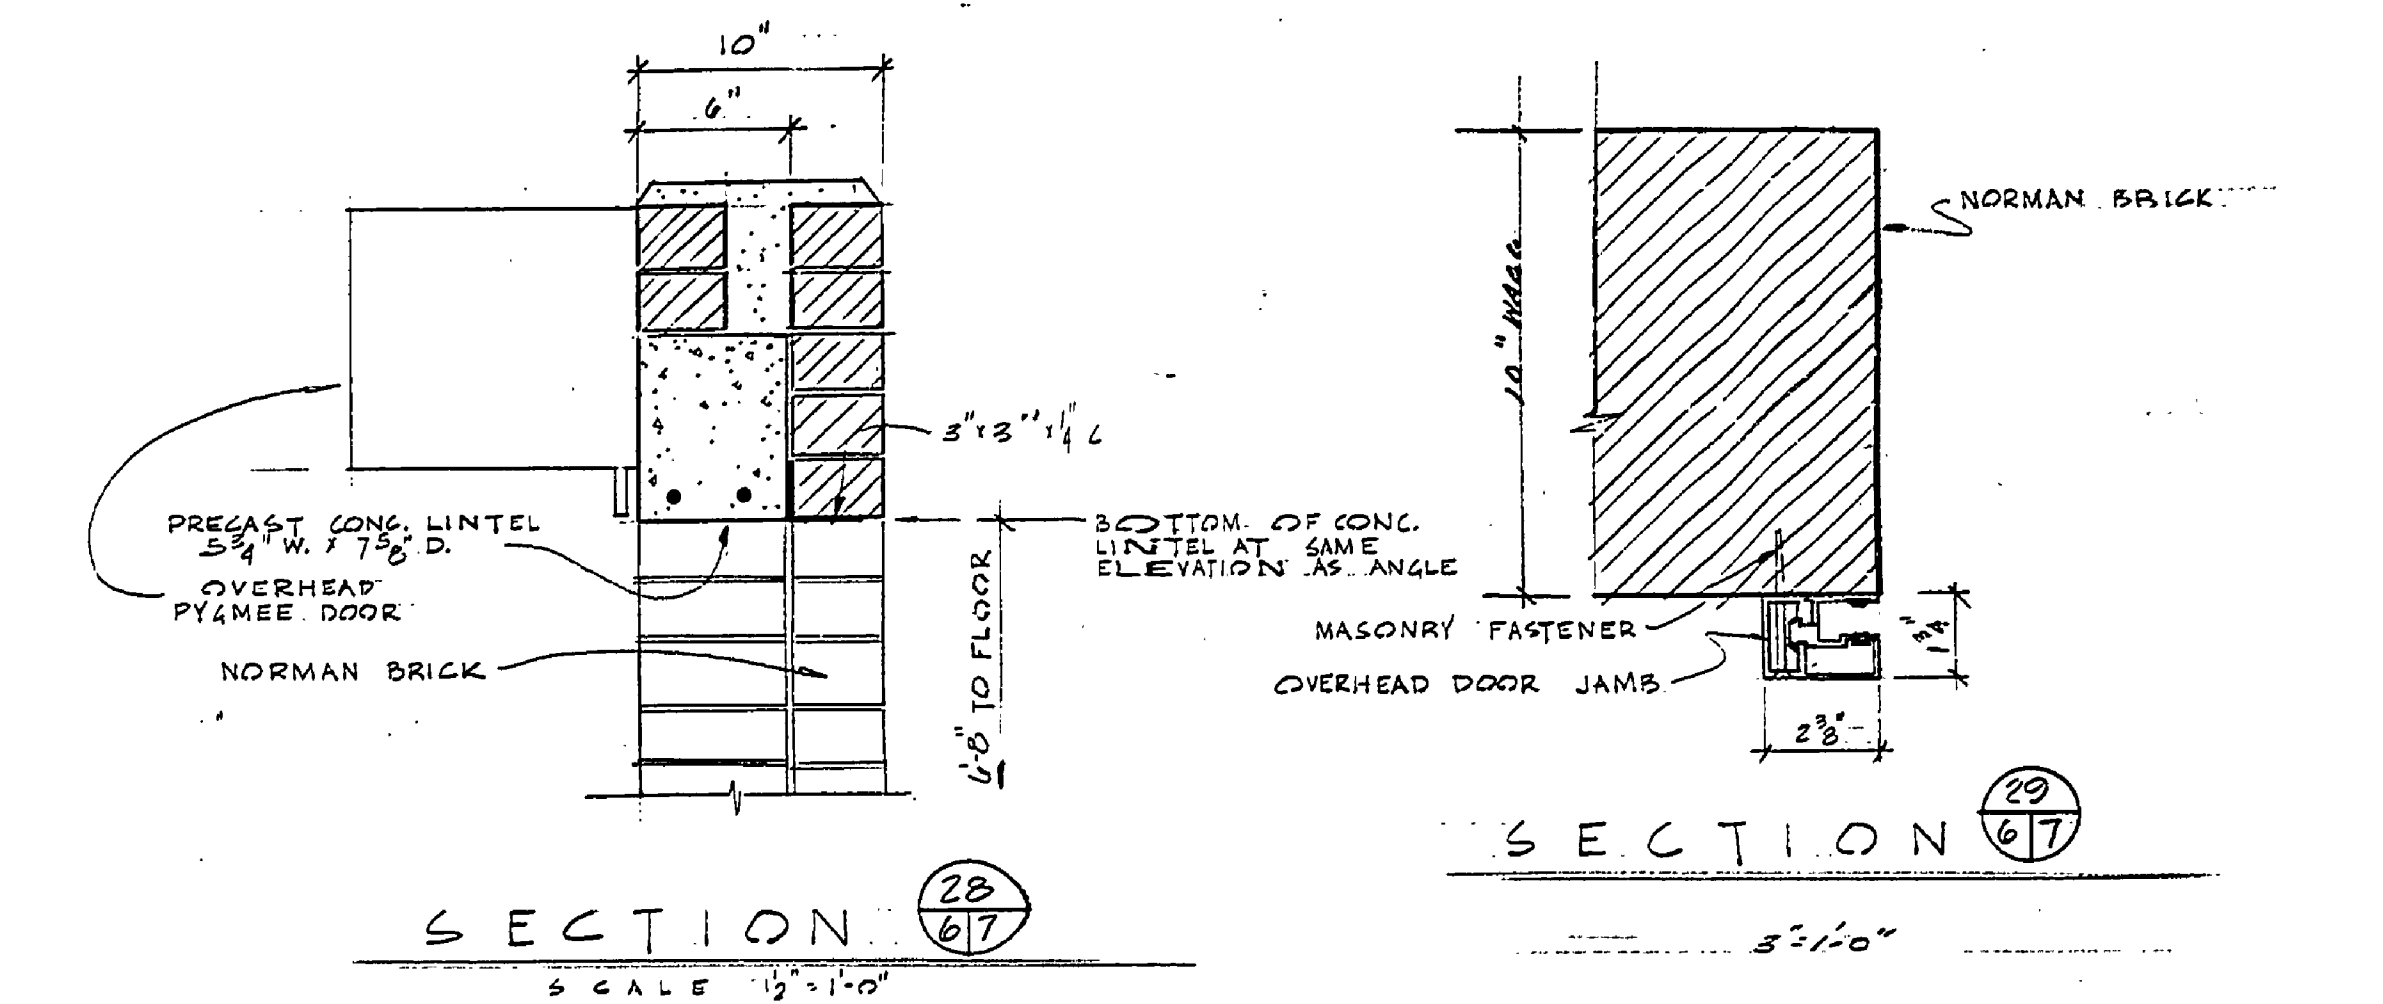


SECTION 28
SCALE 1/2"=1'-0"

SECTION 29
SCALE 1/2"=1'-0"

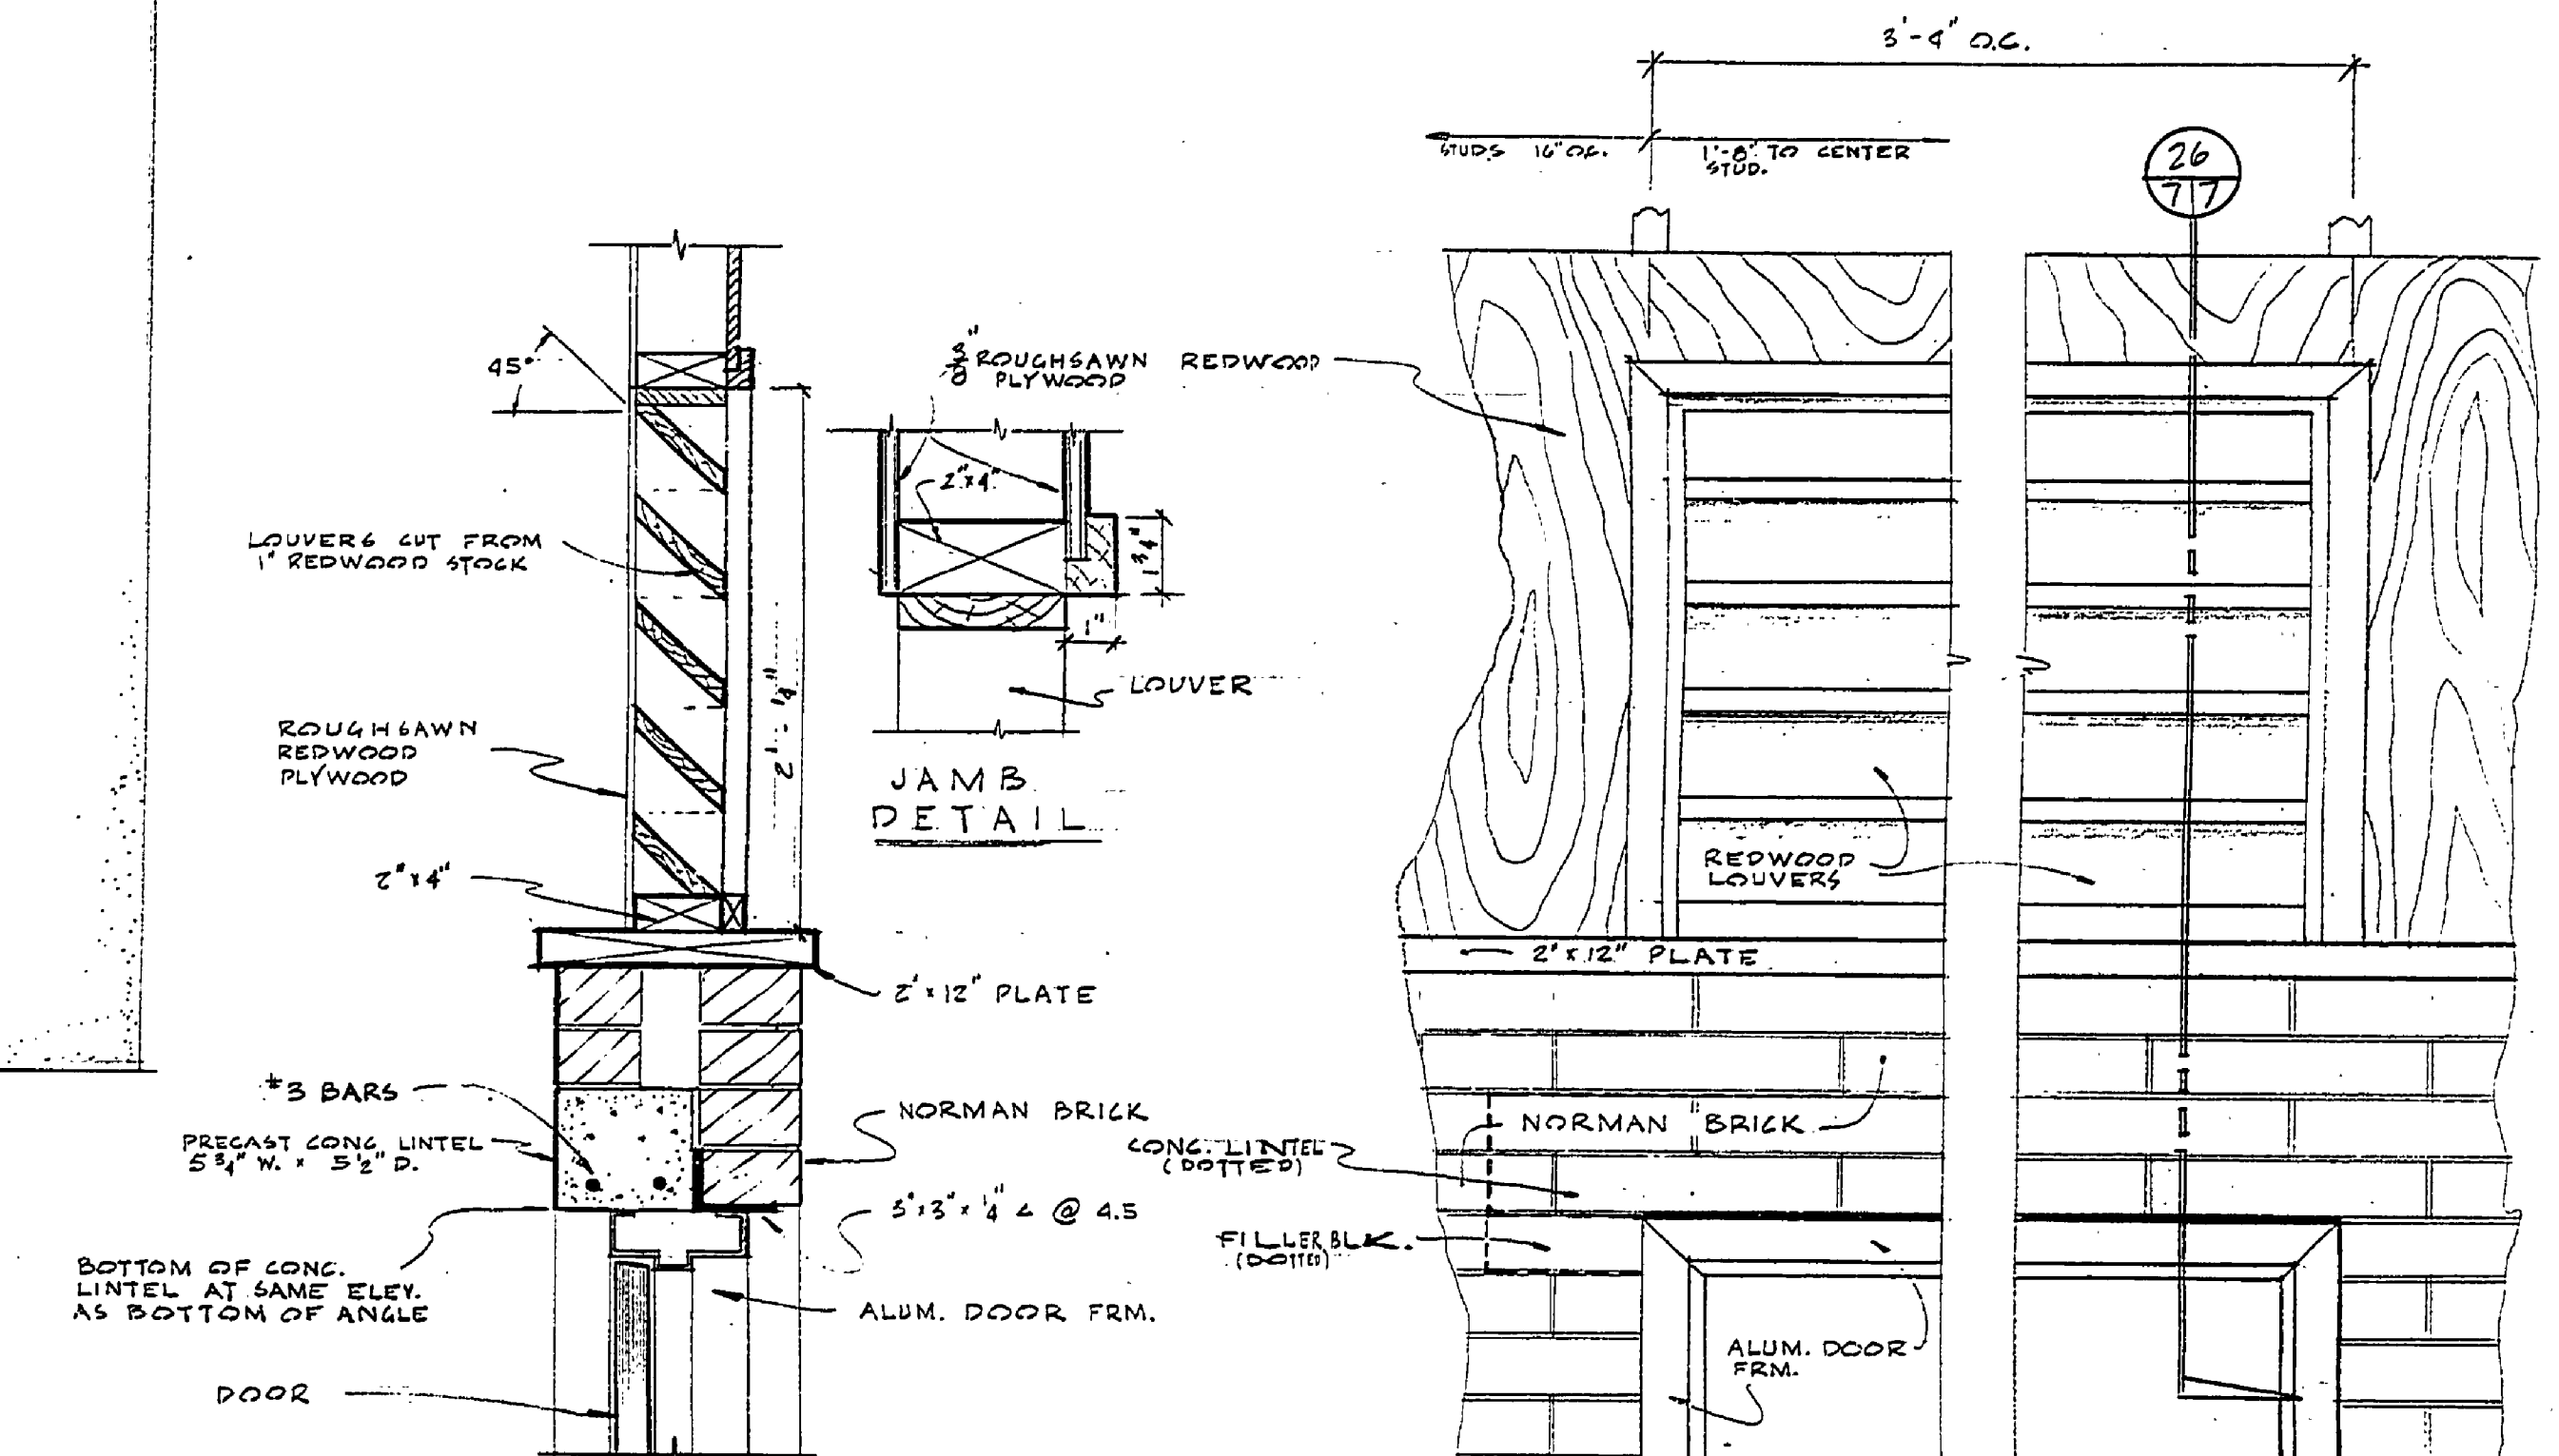


SECTION 20
SCALE 1/2"=1'-0"

PIPE ALLEY DOOR (TYP.) & LOUVER DETAIL

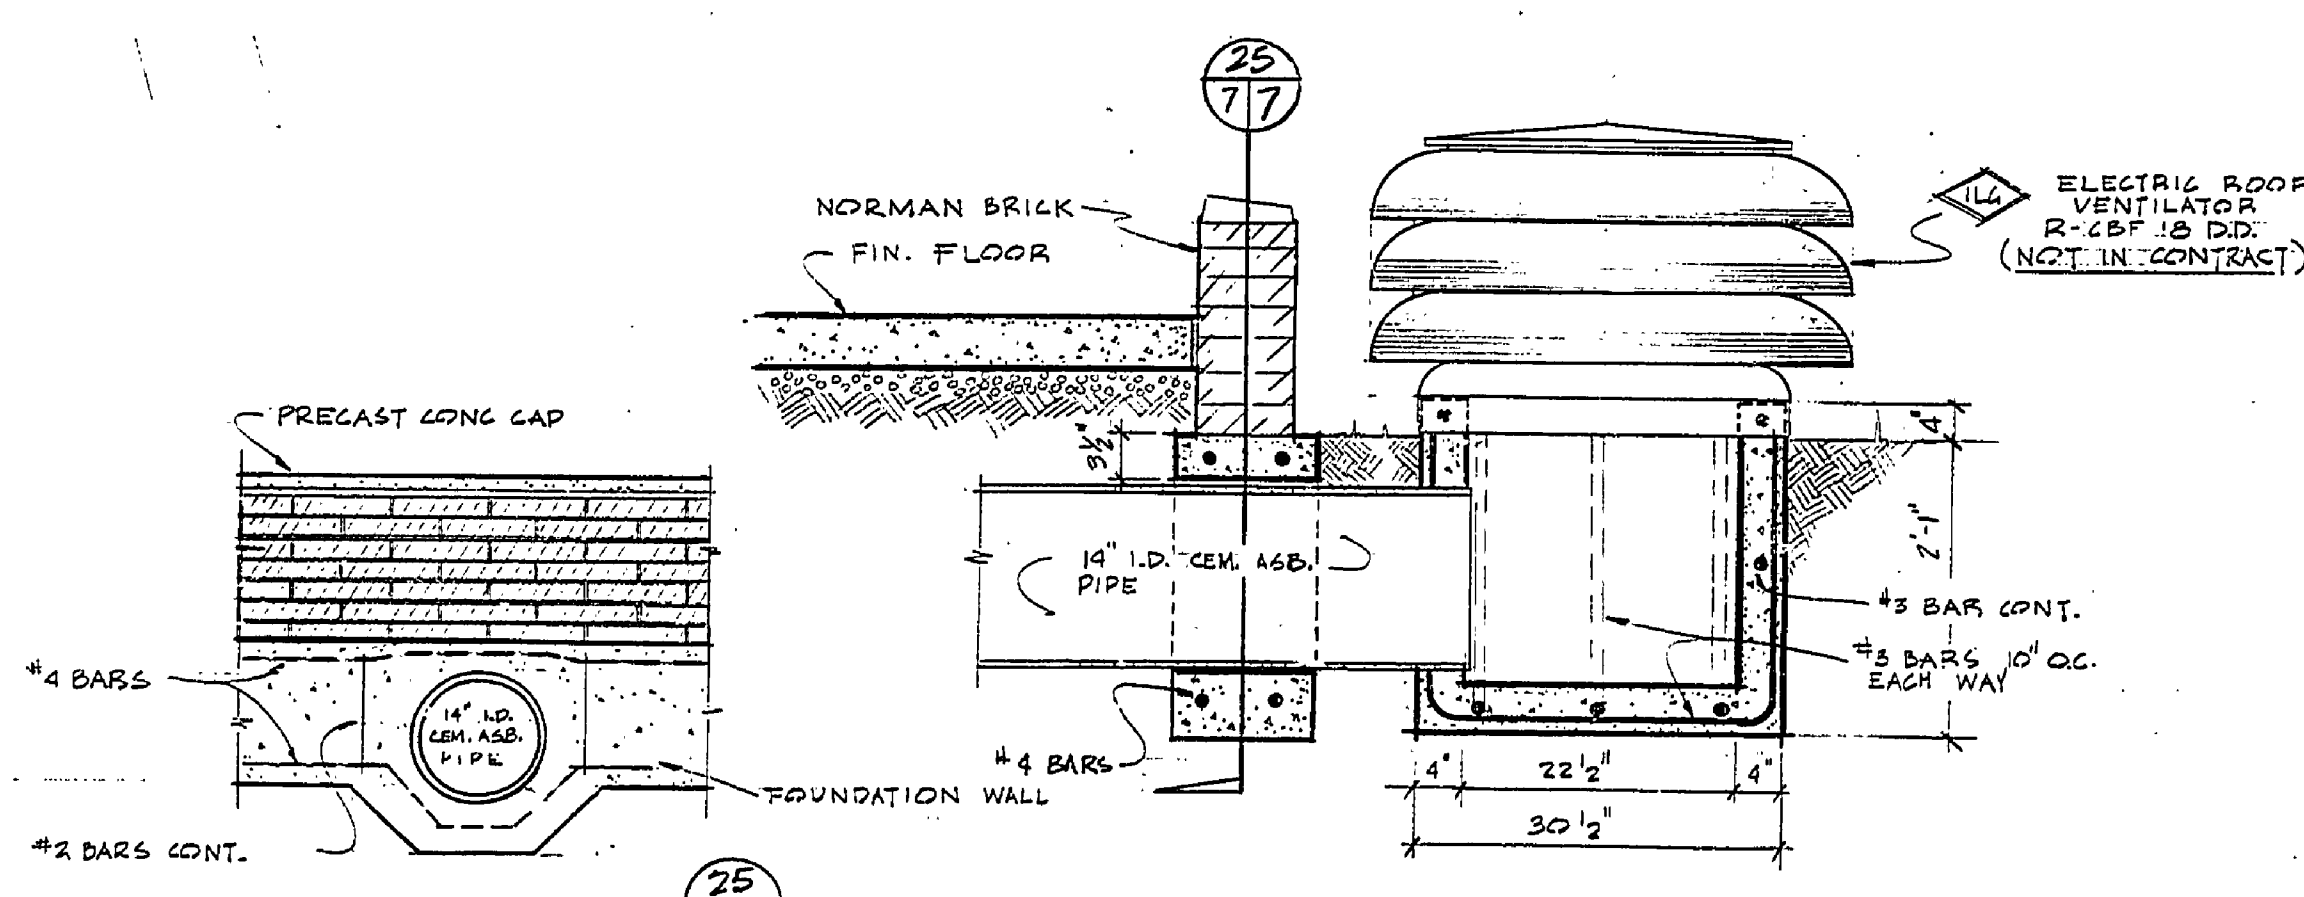


SECTION 25
SCALE 1/2"=1'-0"


EXHAUST FAN INSTALLATION DETAIL
SCALE 3/4"=1'-0"

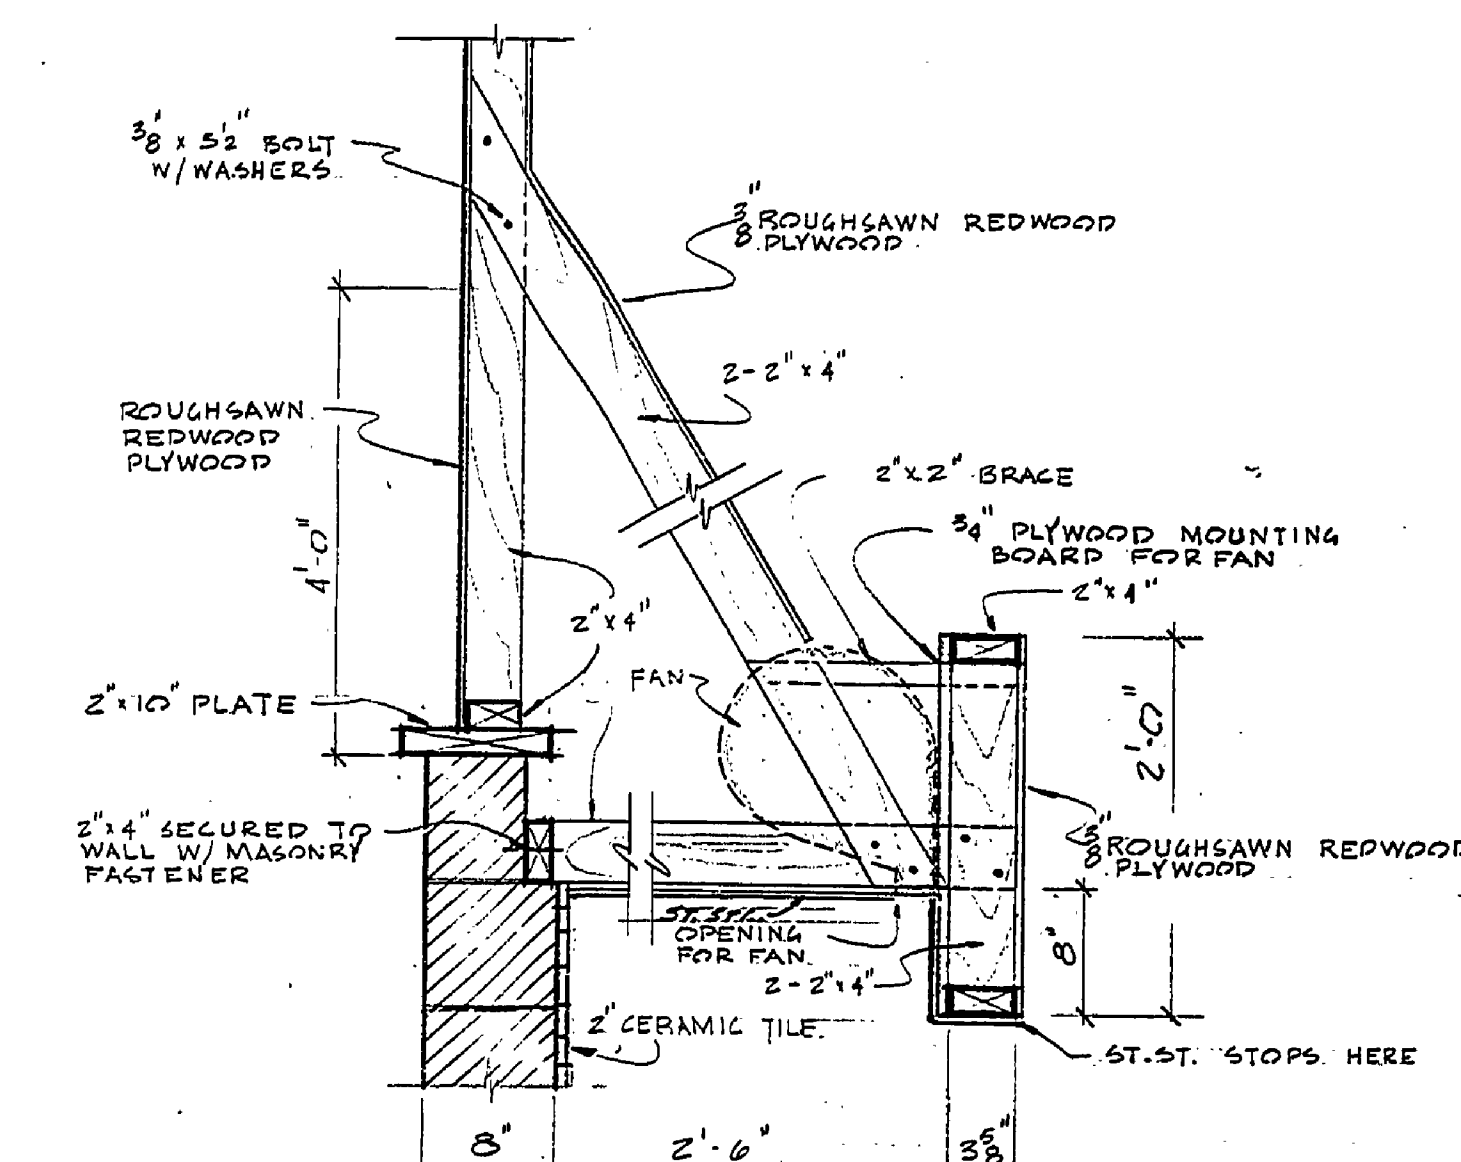

SECTION 27
SCALE 1"=1'-0"

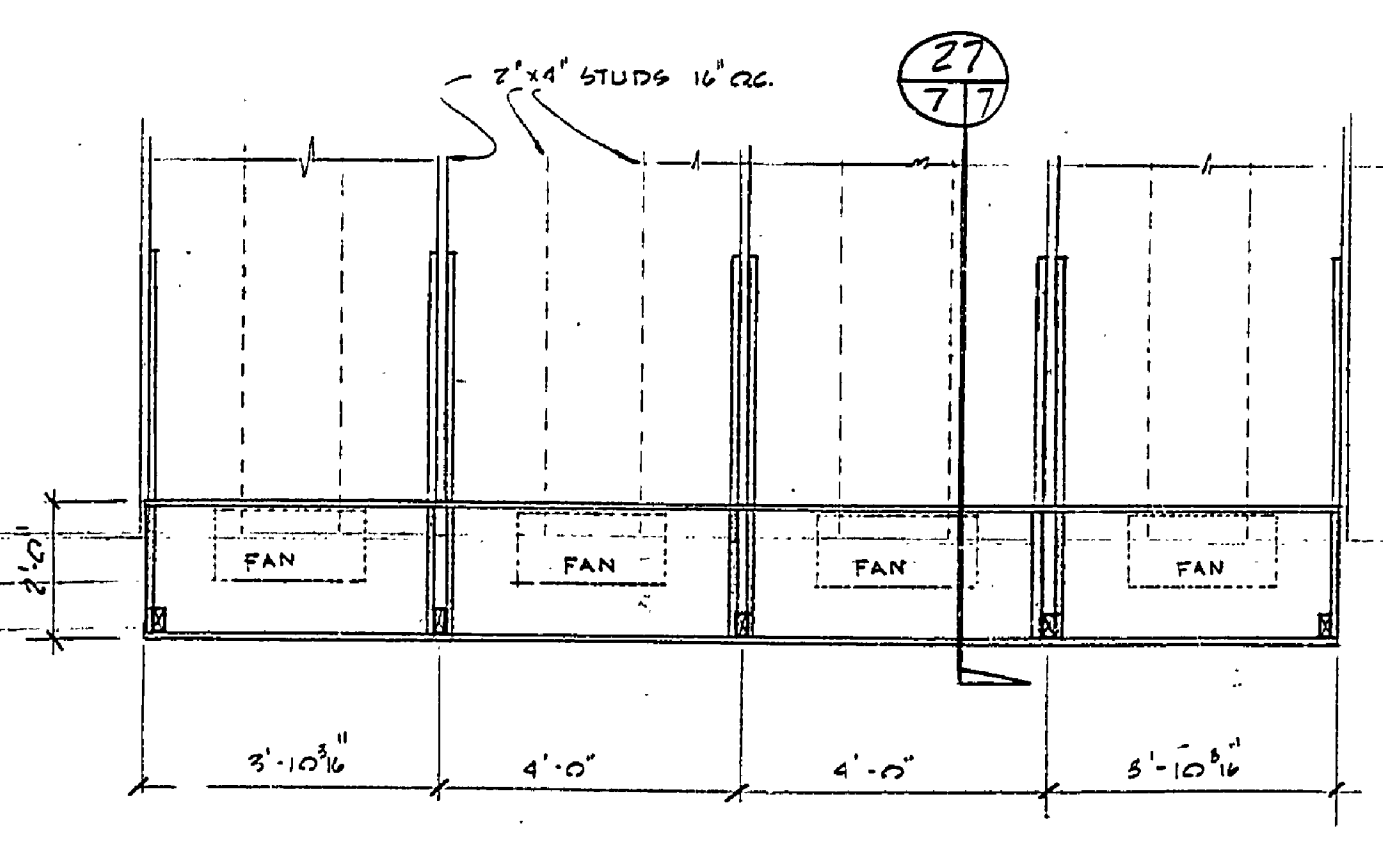

HOOD FRAMING DETAIL
SCALE 3/8"=1'-0"

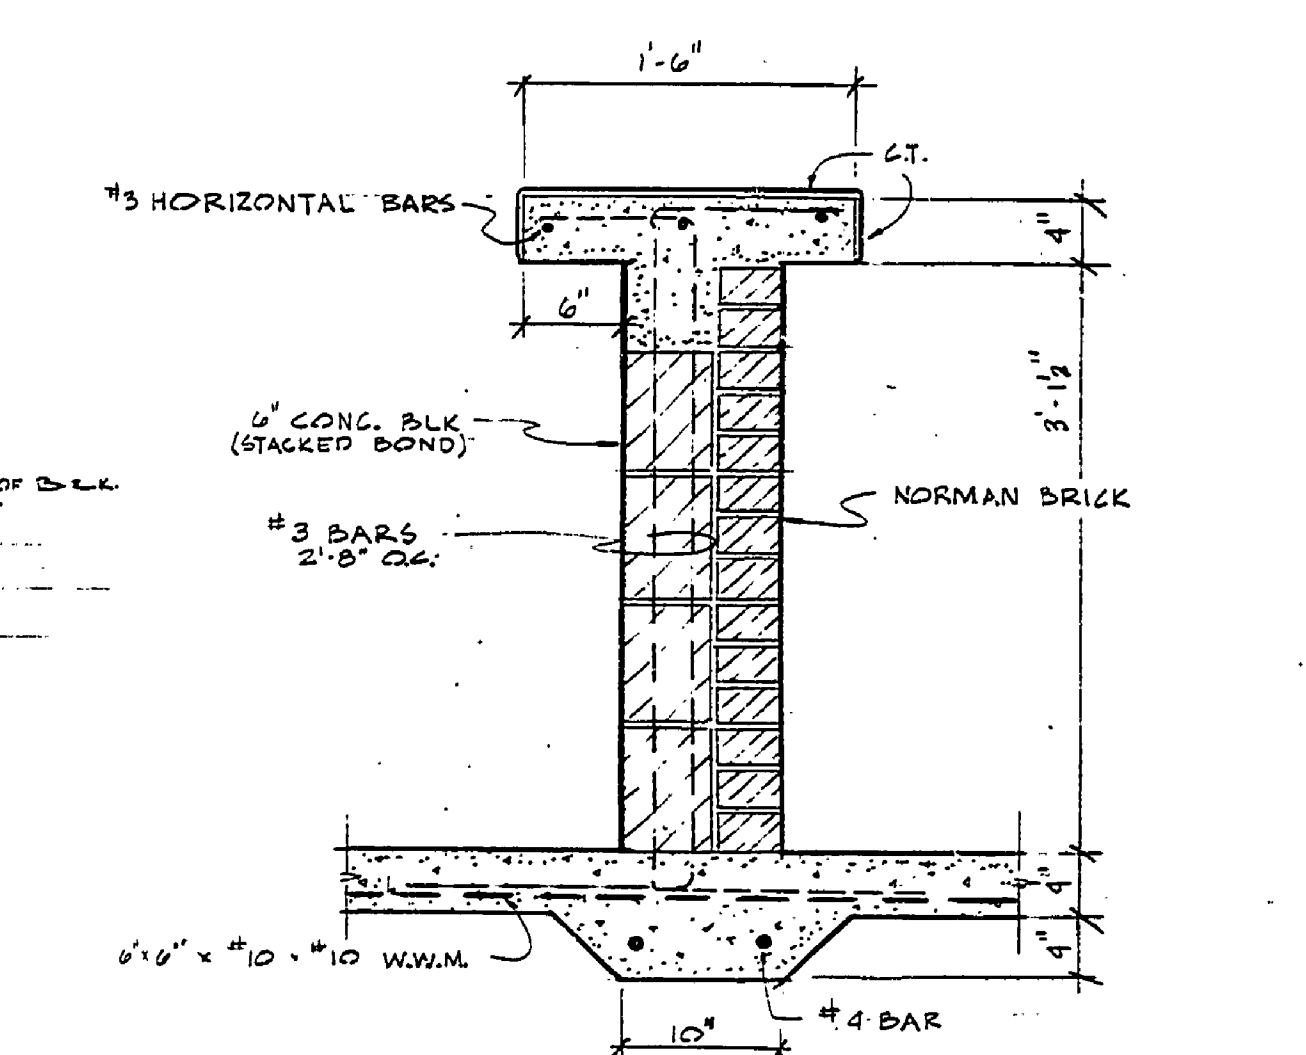

COUNTER SECTION
SCALE 1"=1'-0"

NOTE
FANS MOUNTED
4\"/>

SURVEYED BY	DRAWN BY	NO.	DATE	BY	REVISIONS	NO.	DATE	BY	REVISIONS	MICHIGAN DEPARTMENT OF CONSERVATION	YANKEE SPRINGS RECREATION AREA BEACHHOUSE & CONCESSION	SHEET NO. 7 OF 9 FOR PROJECT NO. 3-929-9272-372-023-01	UNDERGROUND PLUMBING DETAILS SHEET 7 OF 9 PLAN NO. A-139
DESIGNED BY	CHECKED BY	1.				2.							
	DATE	2.				4.							