




DESIGNED BY	DATE	REVIEWED	DATE	APPROVED	DATE	NO.	DATE	BY
W.A.C.	1/24/61	Ans	1/24/61	<i>[Signature]</i>	1	1	1-24-61	
DRAWN BY	1/24/61	E.S.P.	1/24/61		2	2	1-24-61	
CHECKED BY	1/24/61	LANDSCAPE	1/24/61	<i>[Signature]</i>	3	3	1-24-61	

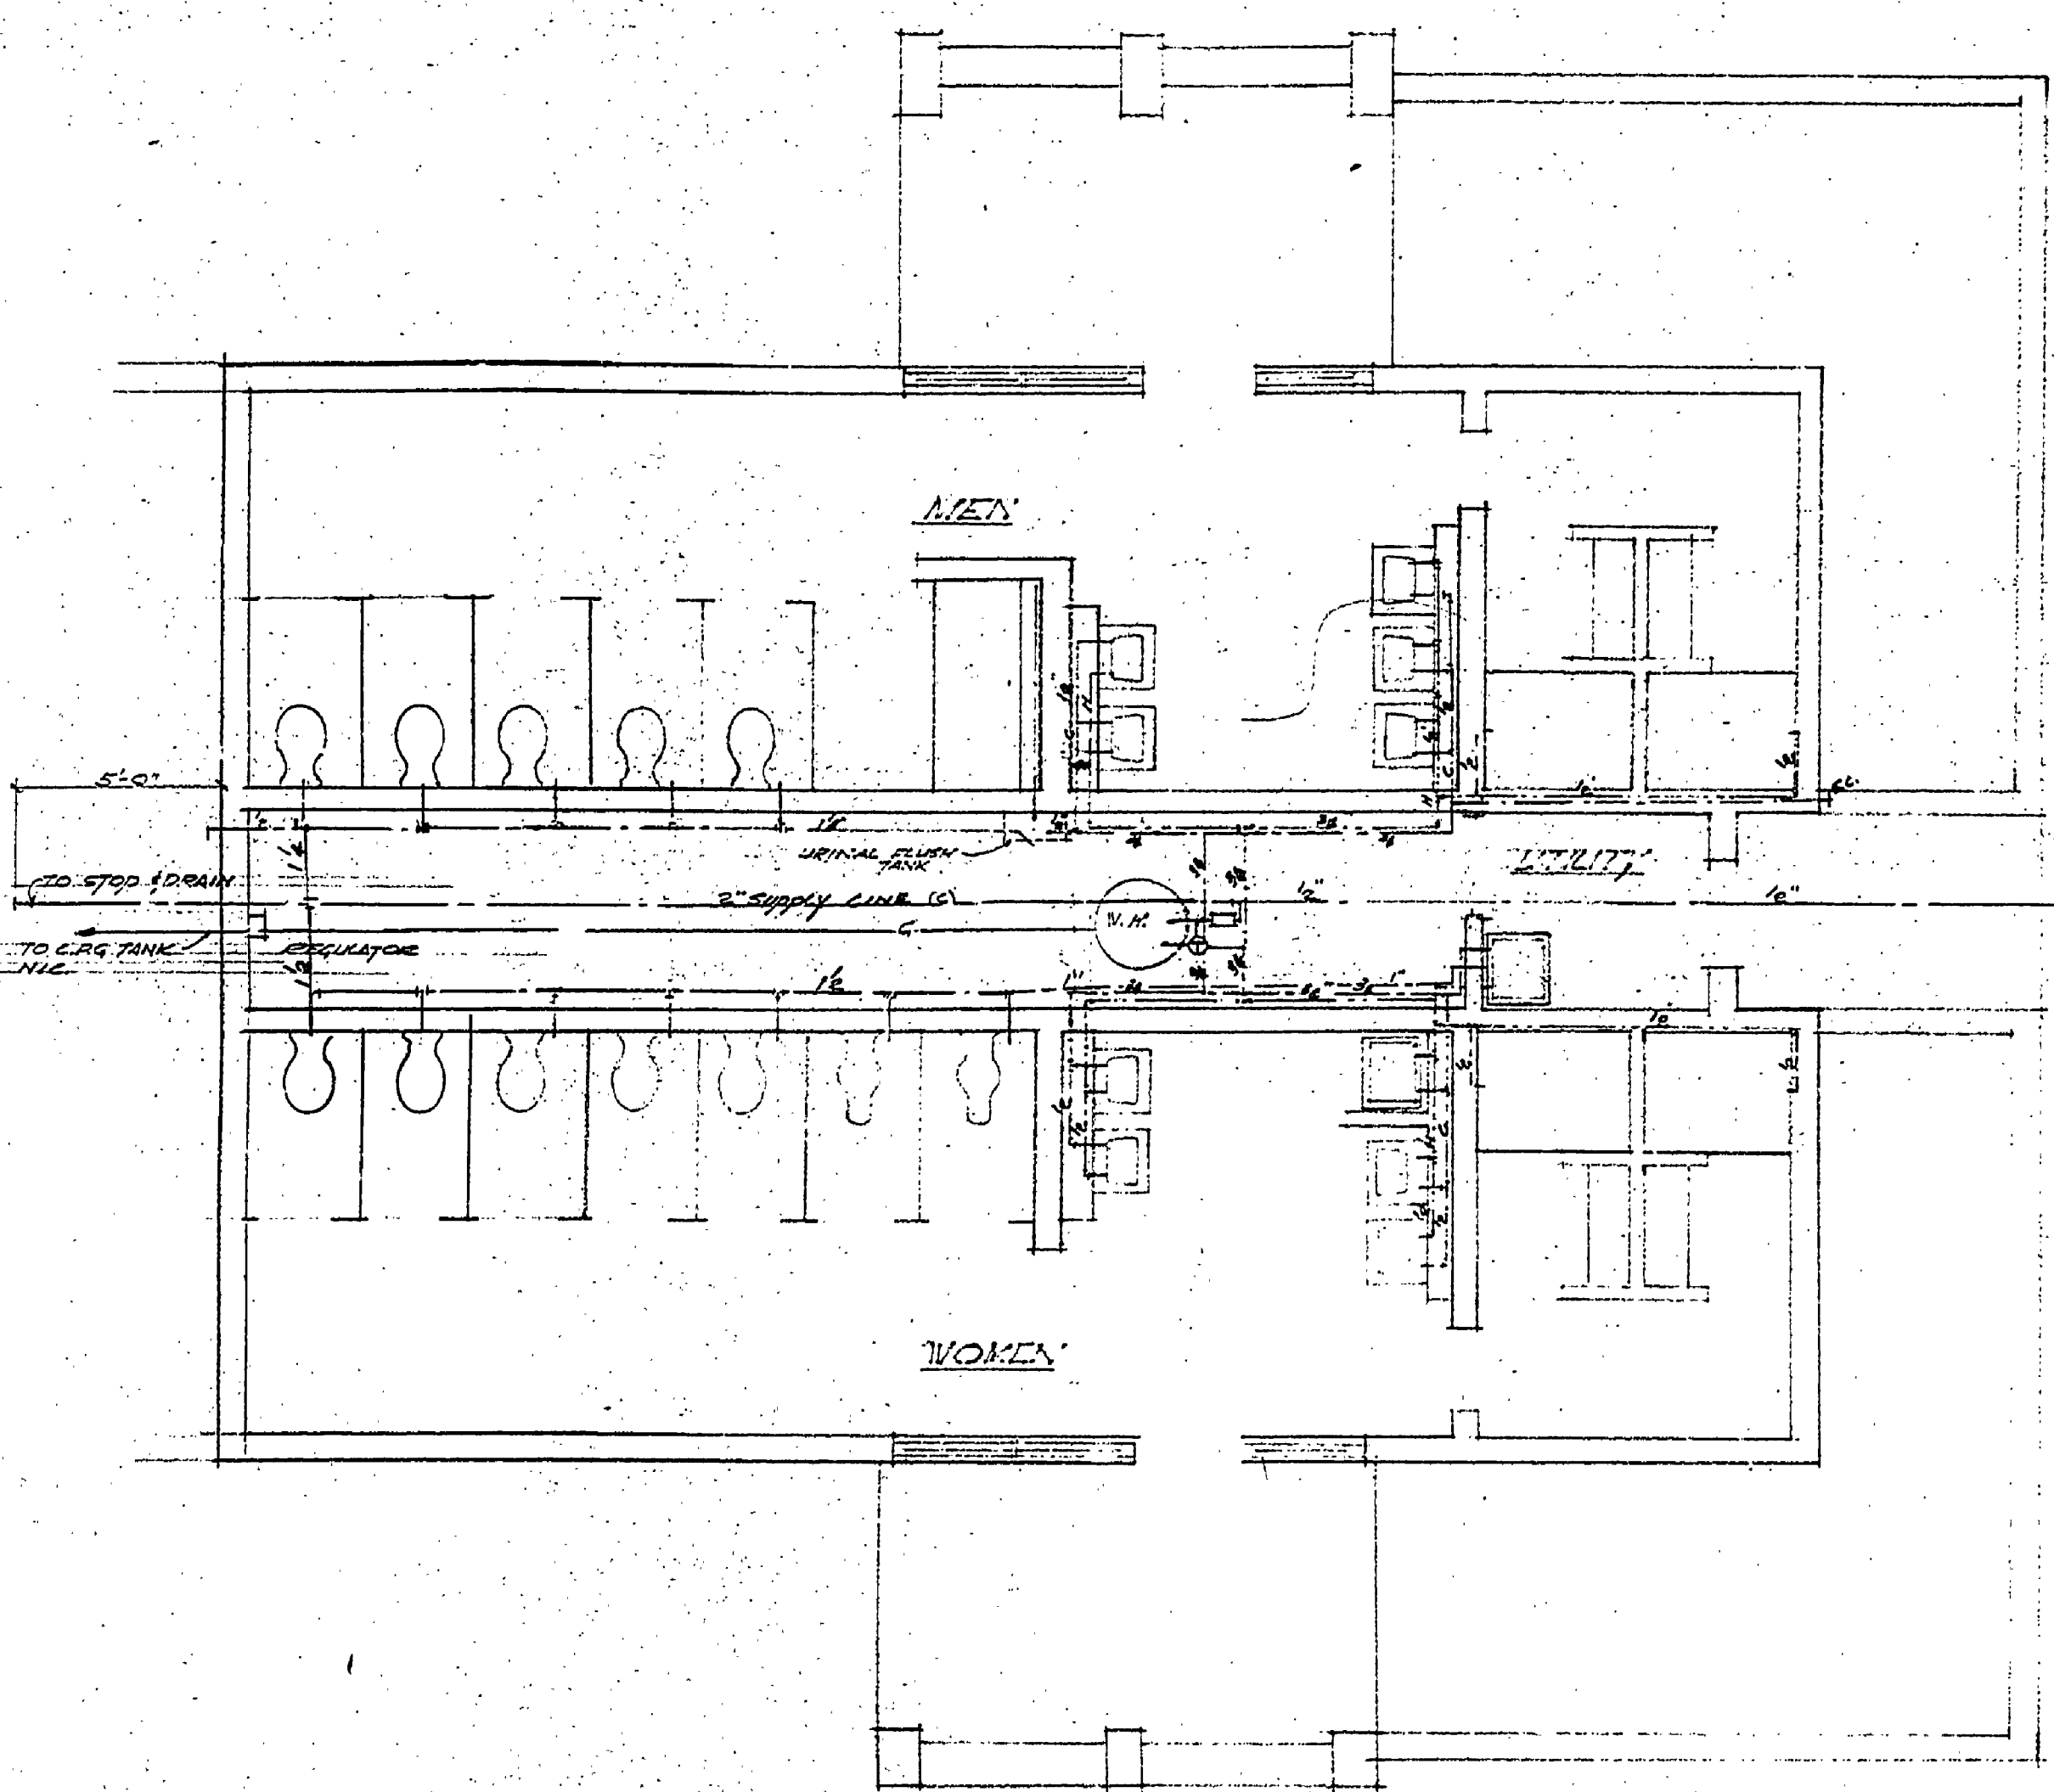


PLUMBING PLAN  
SCALE 1/4" = 1'-0"

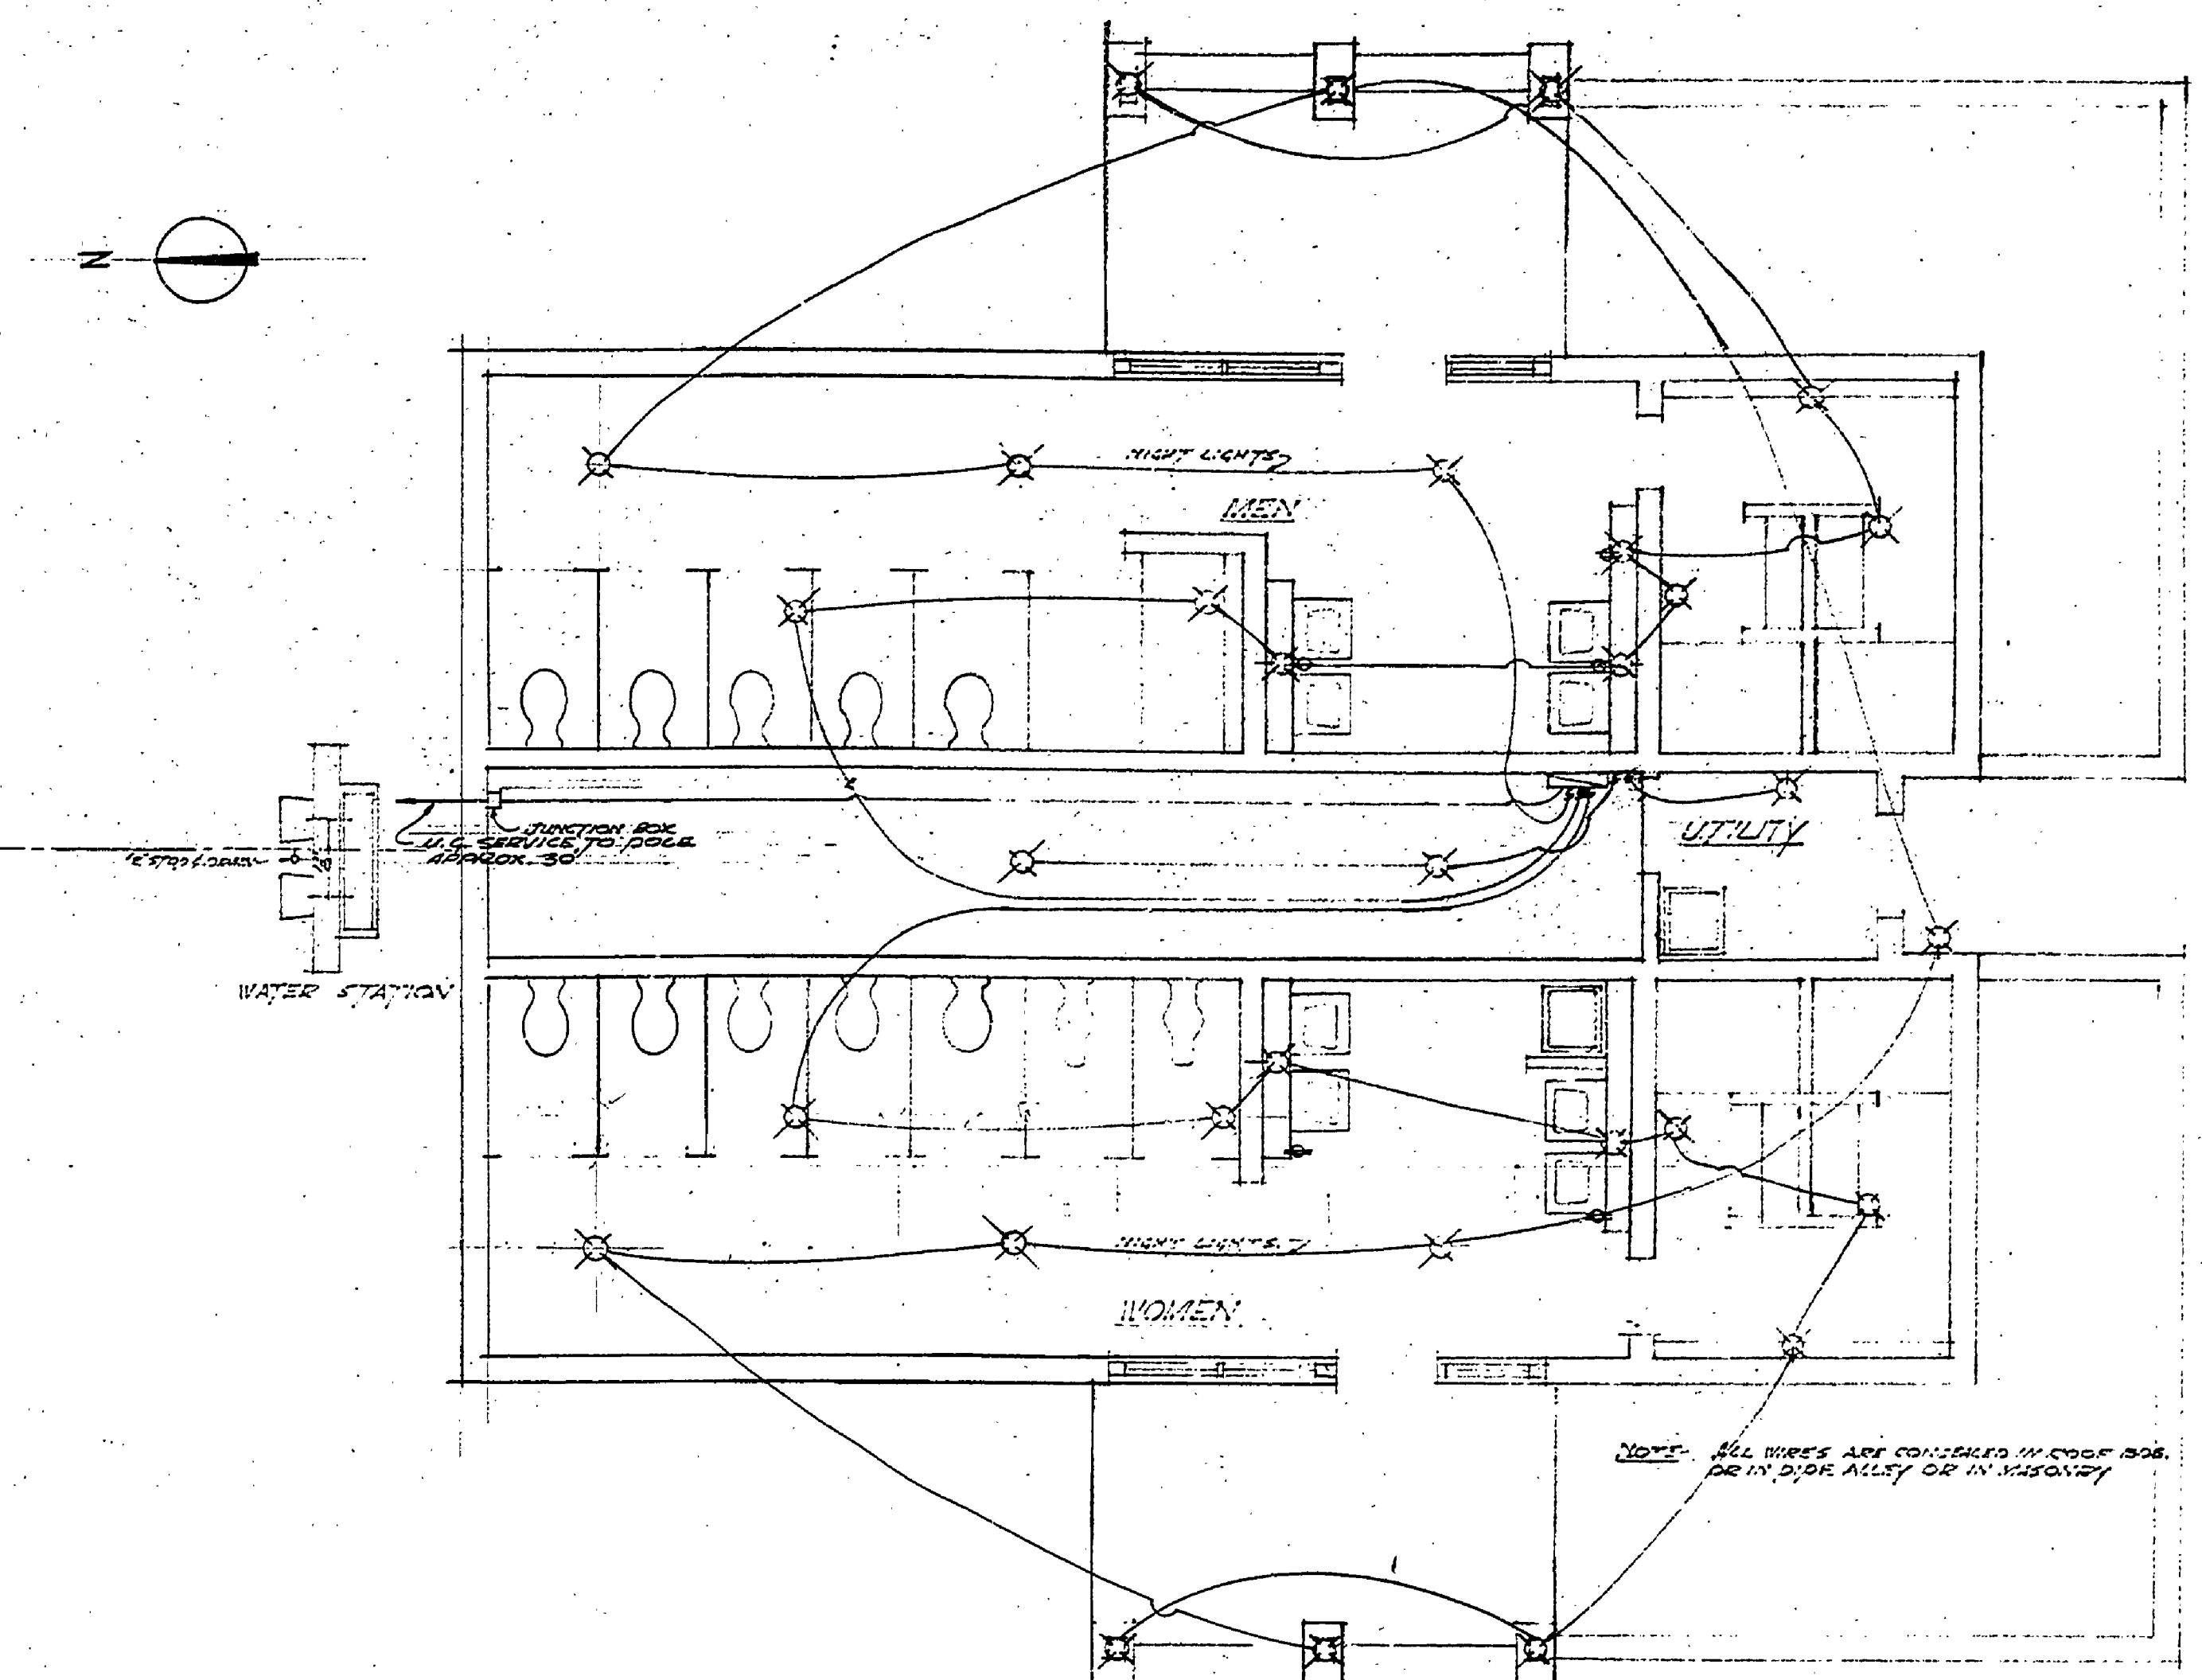


ELECTRICAL PLAN  
SCALE 1/4" = 1'-0"

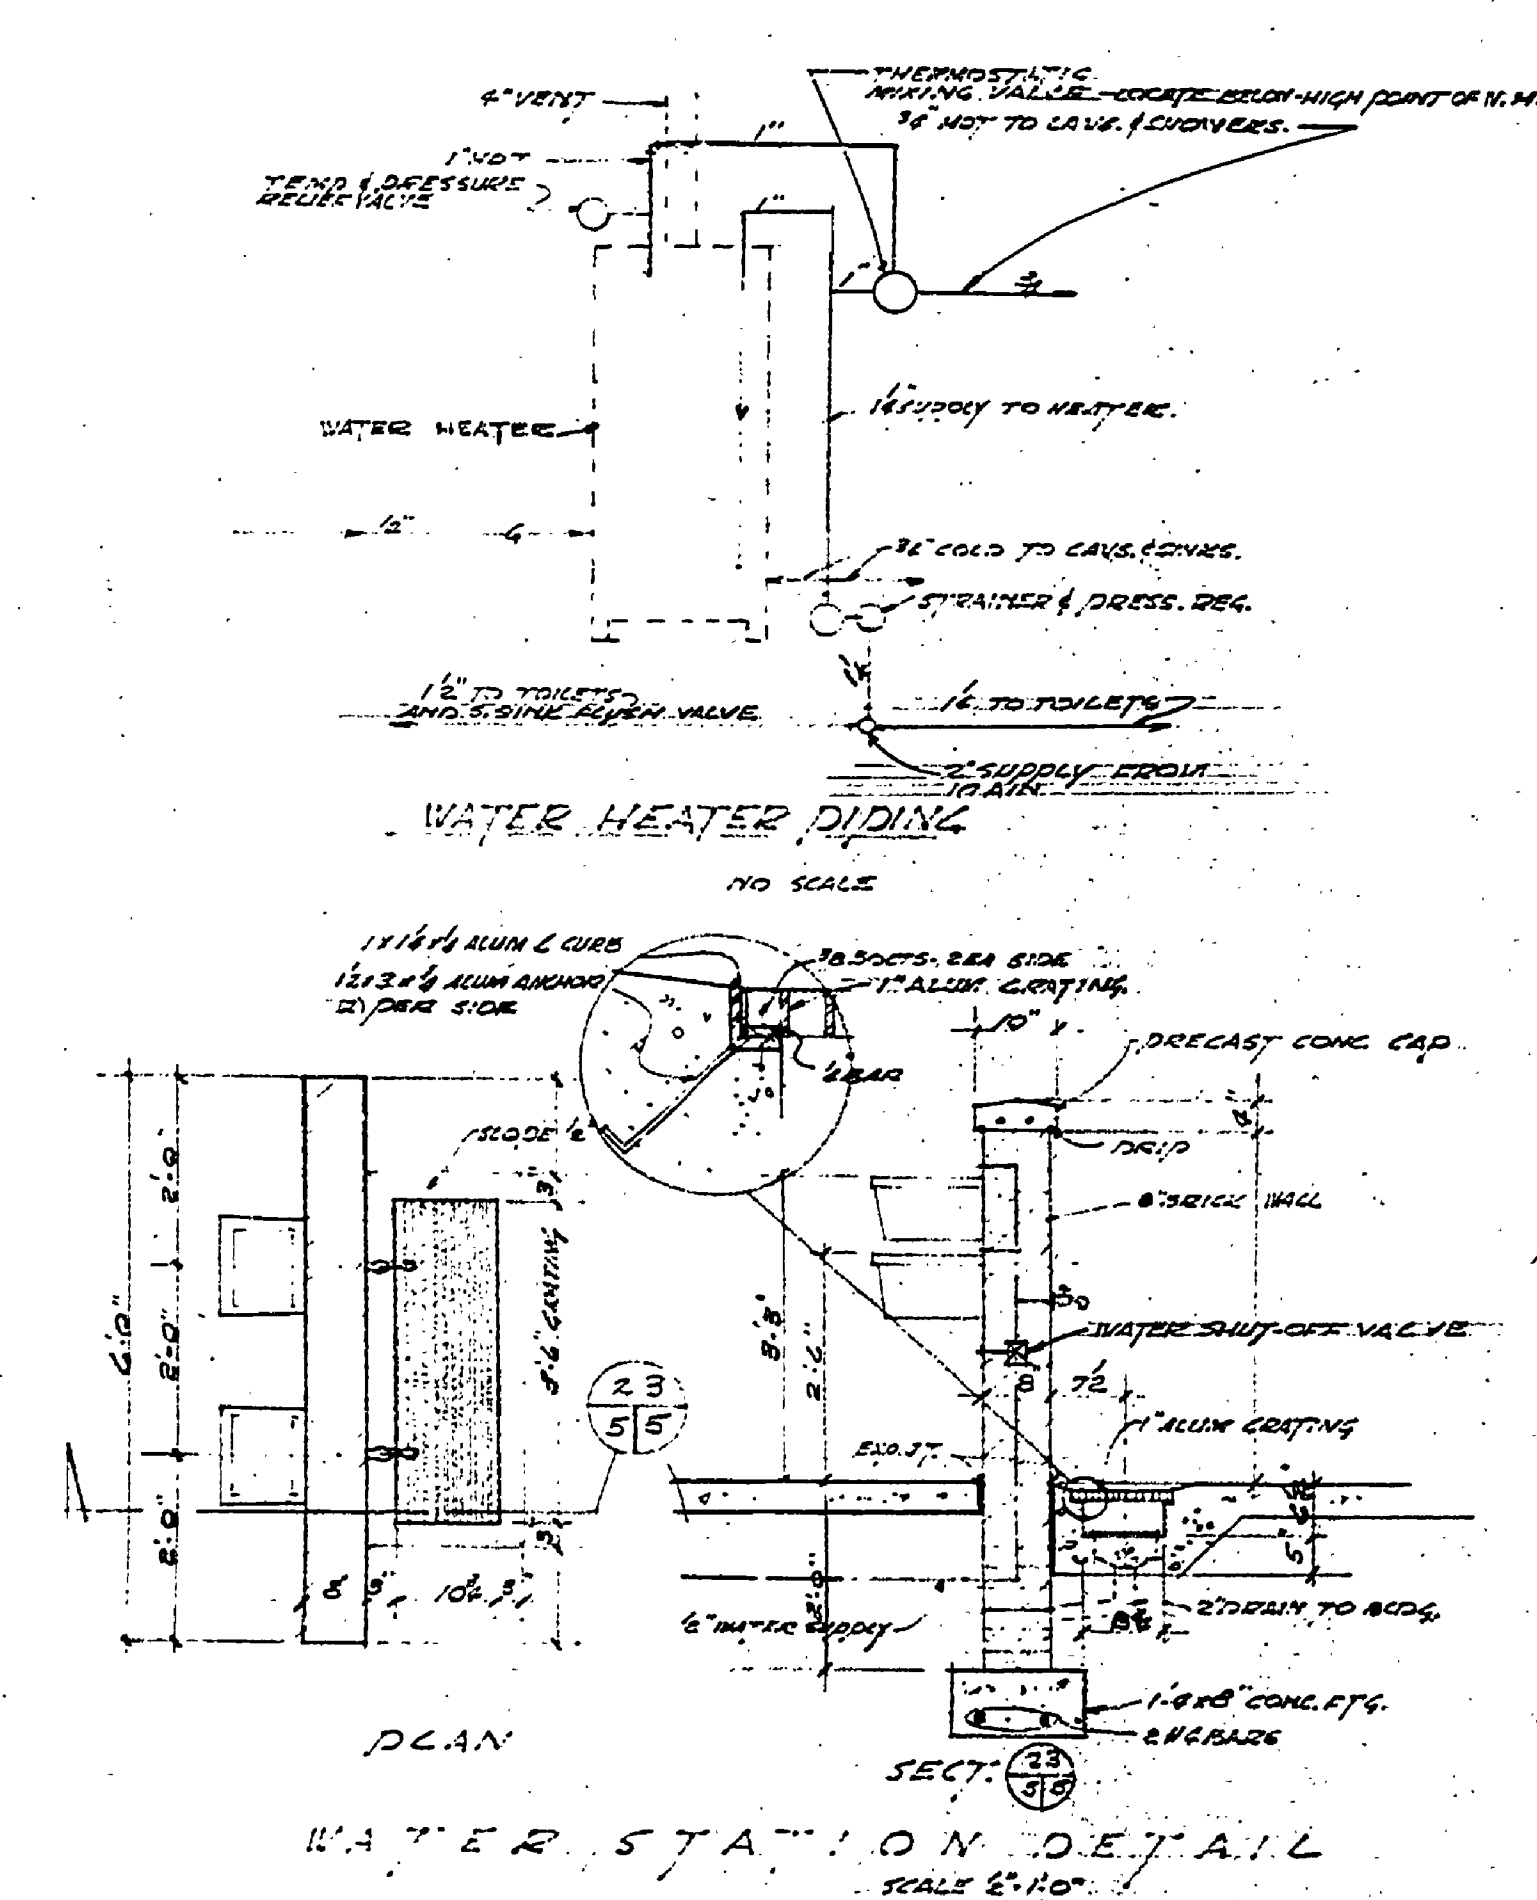


PLAN  
SECTION  
WATER STATION DETAIL  
SCALE 1/2" = 1'-0"

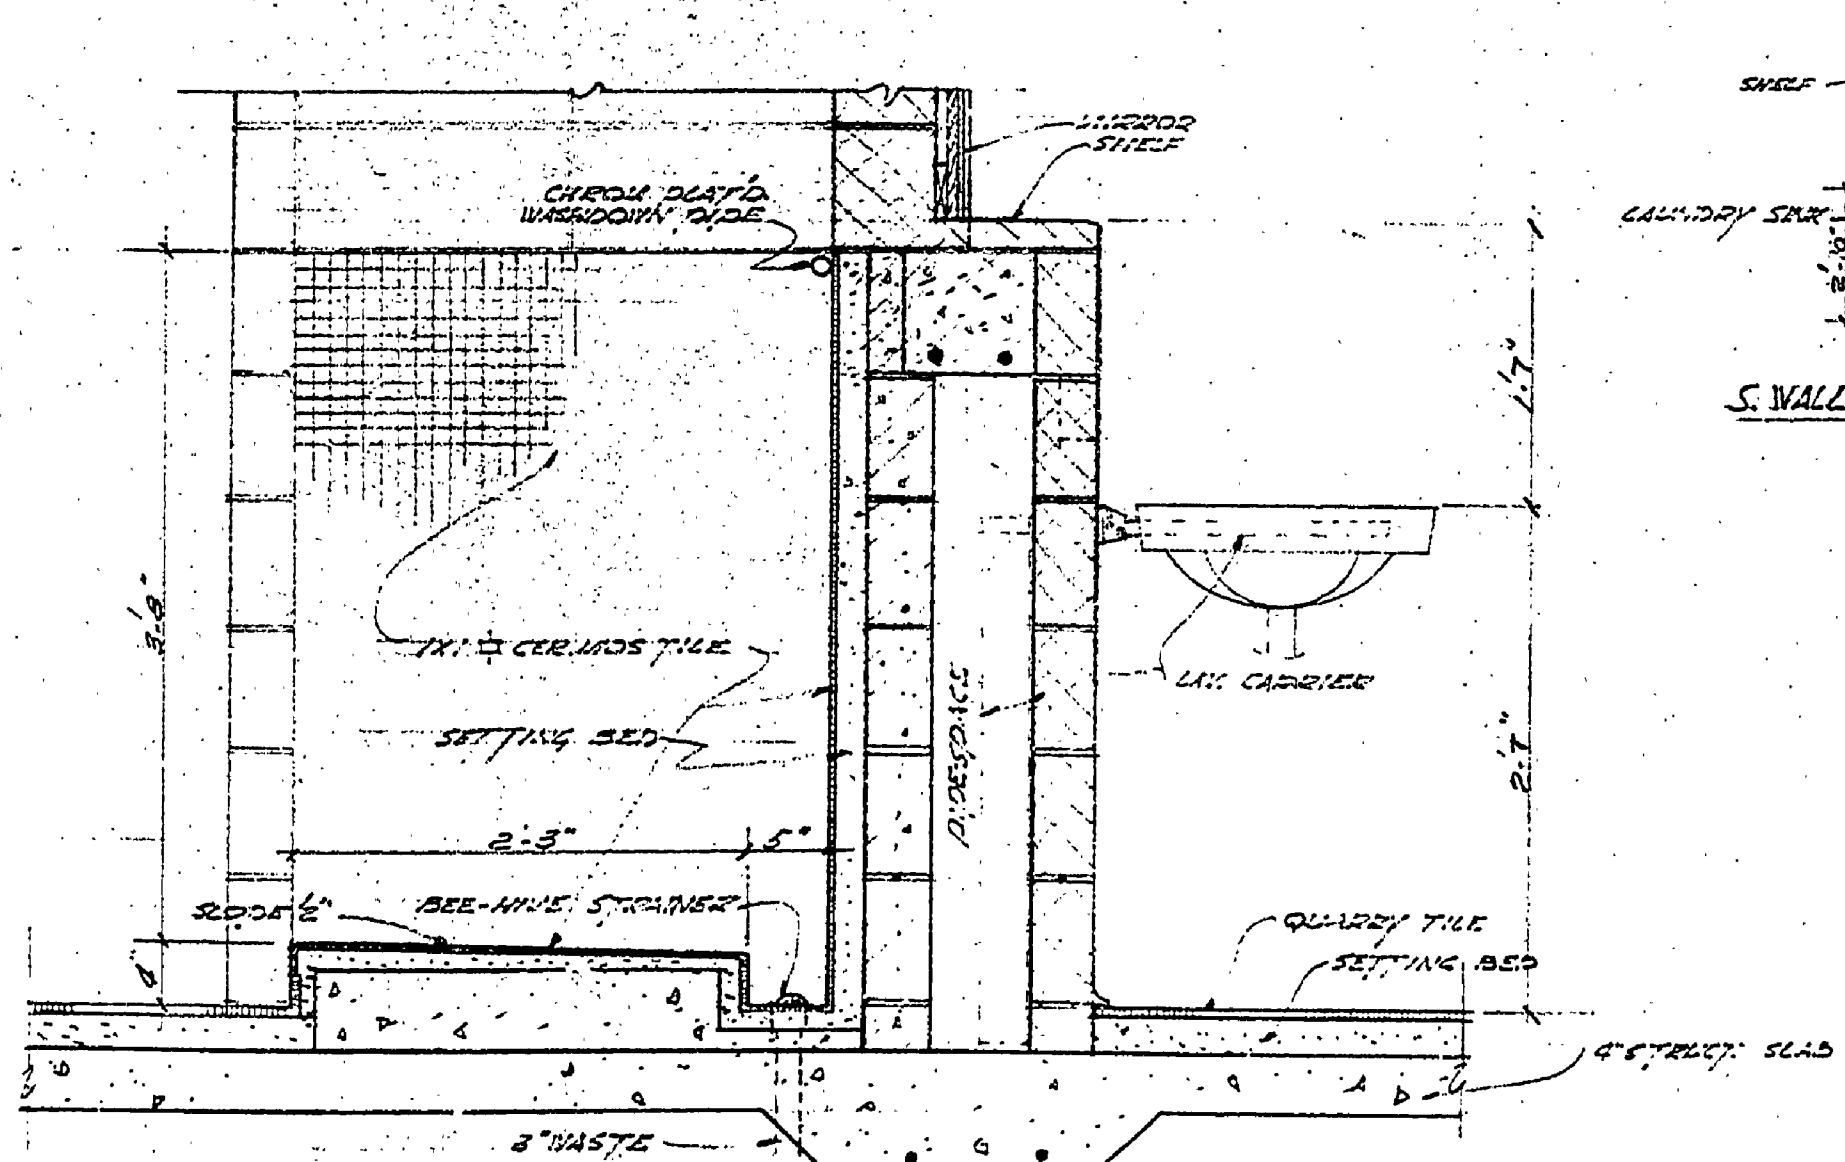


DET. 9/25  
SCALE 1/4" = 1'-0"

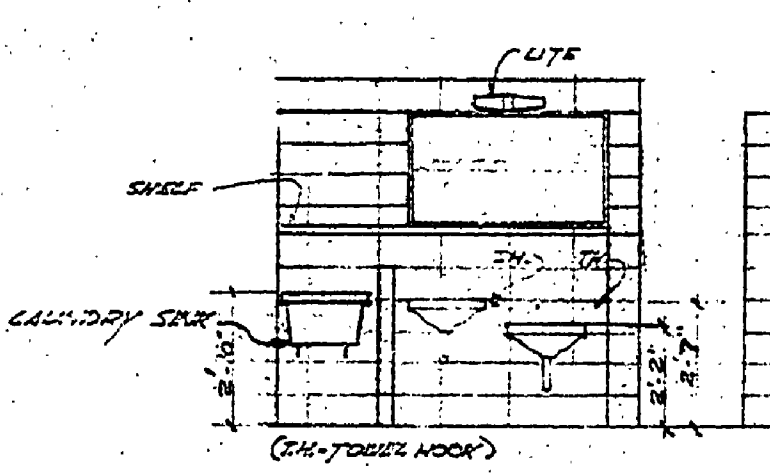

SMALL ELEV. WOMEN'S TOILET  
SCALE 1/4" = 1'-0"

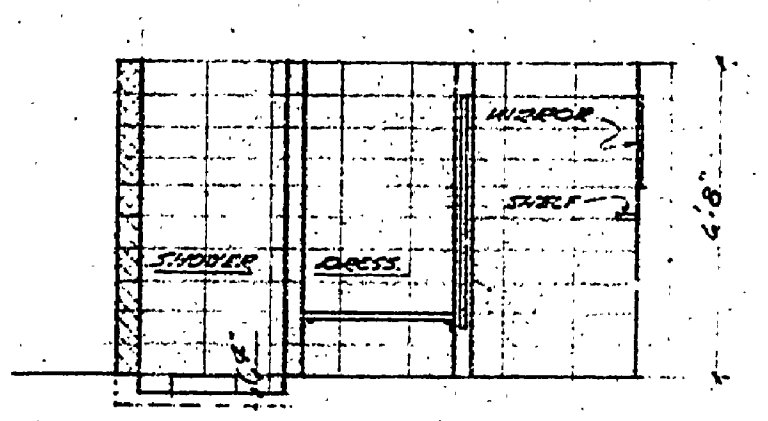

SMALL ELEV. WOMEN'S SHOWER  
SCALE 1/4" = 1'-0"

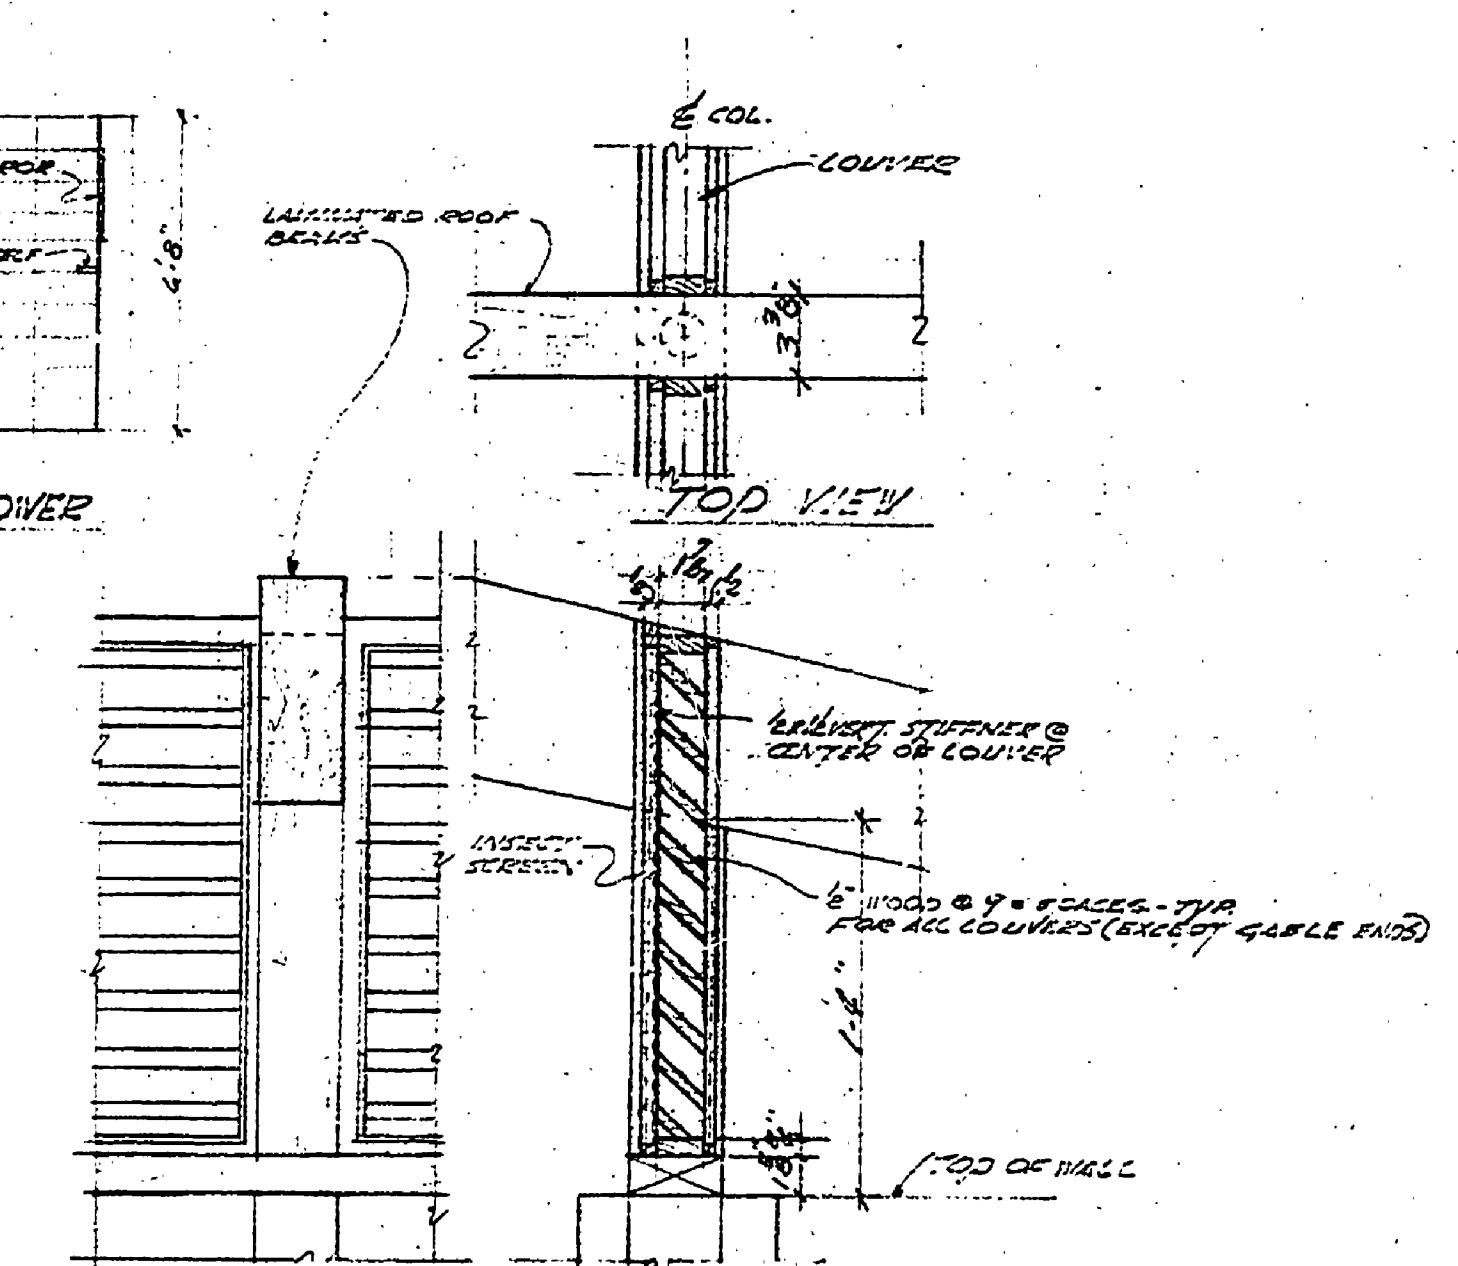

INTERIOR ELEVATION SECTION  
DET - PORCH ROOF TO MAIN BLDG. FT'D. LOWER  
(ROOF BOX NOT SHOWN)  
SCALE 1/2" = 1'-0"

MICHIGAN  
DEPARTMENT OF CONSERVATION  
PARKS AND RECREATION DIVISION

YANKEE SPRINGS RECREATION AREA GUN LAKE CAMPGROUND TOILET AND SHOWER BLDG # 48		SHEET NO. 2 OF 4	PLAN NO. A-141
--	--	------------------------	-------------------