


**LEGEND**

**CAMP STRUCTURES**

- ADMINISTRATION BUILDING
- CENTRAL LATRINE
- CAMPERS SLEEPING CABIN
- DINING HALL & KITCHEN
- HELPS QUARTERS
- INFIRMARY
- GARAGE
- CRAFT SHOP
- UNIT LATRINE
- COUNSELLORS SLEEPING CABIN
- UNIT LODGE
- STAFF QUARTERS
- PUMP HOUSE & STORAGE TANK
- ICE & FUEL STORAGE
- SEPTIC TANK
- OLD LOG CABIN

**FEATURES**

- A POWER LINE (AERIAL)
- B POWER LINE (UNDERGROUND)
- C TELEPHONE LINE (AERIAL)
- D TELEPHONE LINE (UNDERGROUND)
- E TELEPHONE STATION
- F WATER LINE
- G VALVE
- H DRINKING FOUNTAIN
- J HYDRANT
- K FIRE PLUG
- L SEWER LINE
- M CONCRETE BARRIER
- P DISPOSAL FIELD
- R EXISTING BUILDING
- S CONCRETE MONUMENT
- T POWER TRANSFORMER

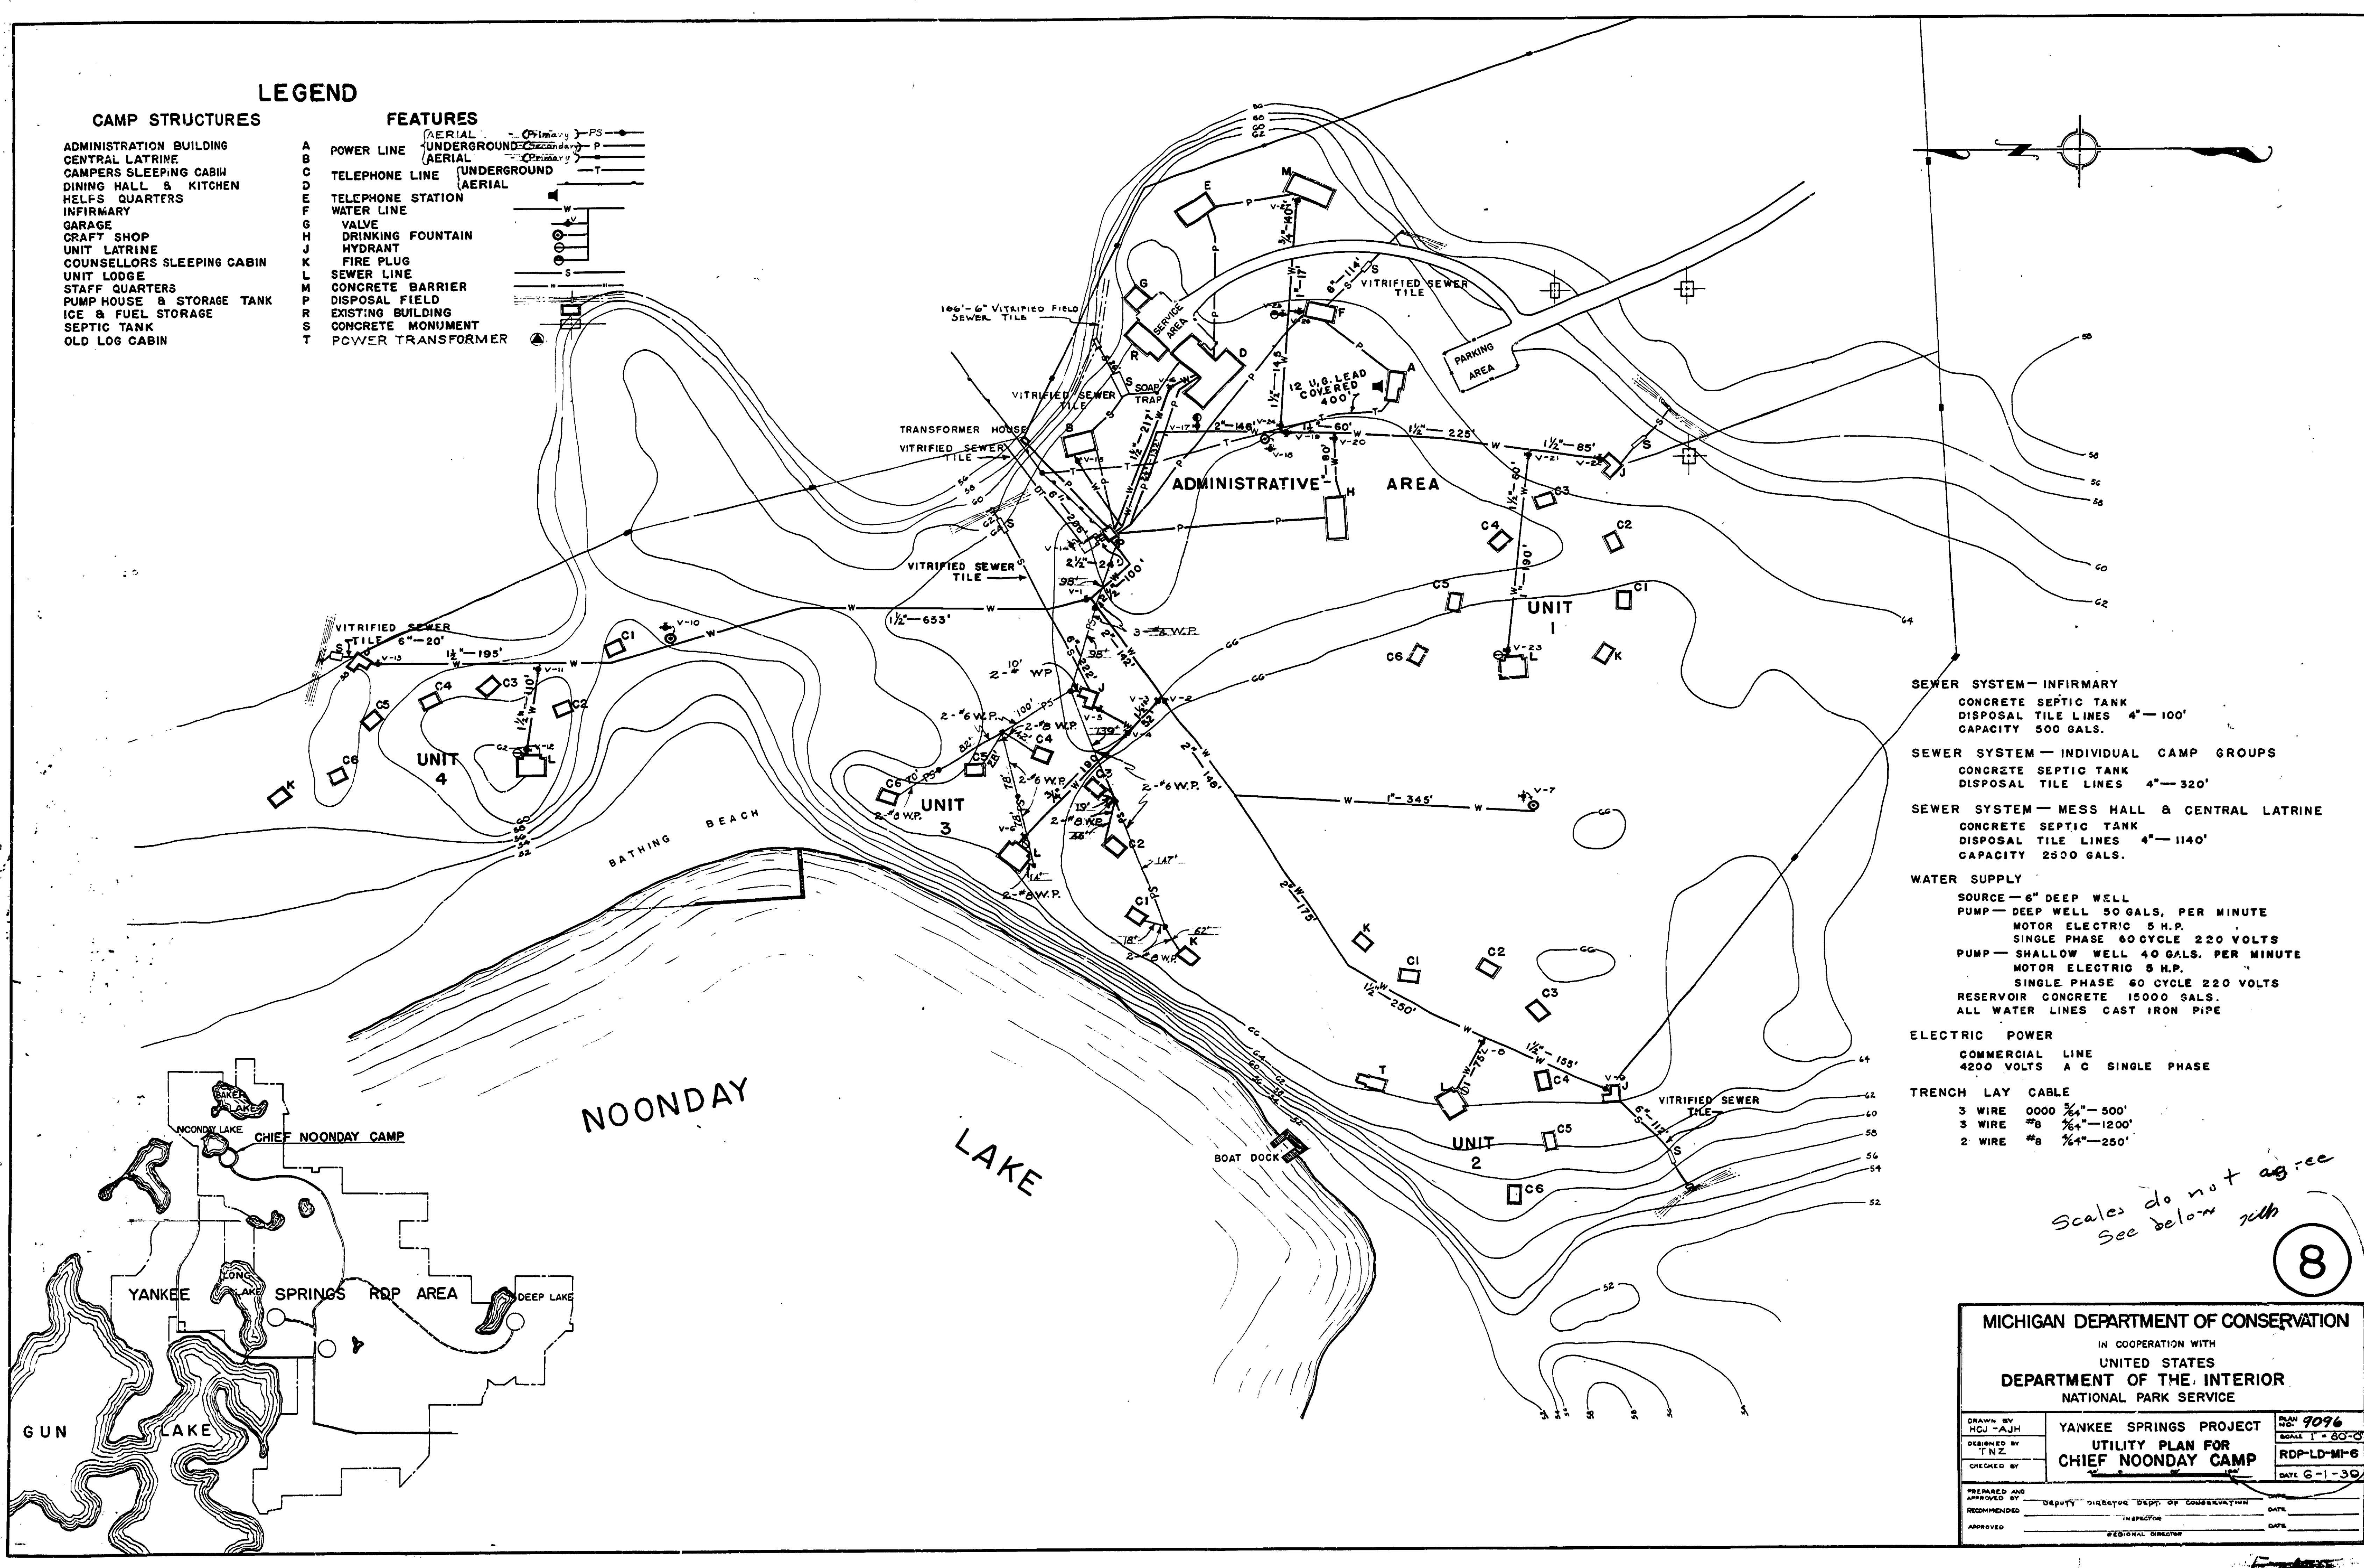

- SEWER SYSTEM - INFIRMARY**  
CONCRETE SEPTIC TANK  
DISPOSAL TILE LINES 4" - 100'  
CAPACITY 500 GALS.
- SEWER SYSTEM - INDIVIDUAL CAMP GROUPS**  
CONCRETE SEPTIC TANK  
DISPOSAL TILE LINES 4" - 320'
- SEWER SYSTEM - MESS HALL & CENTRAL LATRINE**  
CONCRETE SEPTIC TANK  
DISPOSAL TILE LINES 4" - 1140'  
CAPACITY 2500 GALS.
- WATER SUPPLY**  
SOURCE - 6" DEEP WELL  
PUMP - DEEP WELL 50 GALS. PER MINUTE  
MOTOR ELECTRIC 5 H.P.  
SINGLE PHASE 60 CYCLE 220 VOLTS  
PUMP - SHALLOW WELL 40 GALS. PER MINUTE  
MOTOR ELECTRIC 5 H.P.  
SINGLE PHASE 60 CYCLE 220 VOLTS  
RESERVOIR CONCRETE 15000 GALS.  
ALL WATER LINES CAST IRON PIPE
- ELECTRIC POWER**  
COMMERCIAL LINE  
4200 VOLTS A C SINGLE PHASE
- TRENCH LAY CABLE**  
3 WIRE 0000 3/4" - 500'  
3 WIRE #8 1/2" - 1200'  
2 WIRE #8 1/4" - 250'

*Scales do not agree  
See below*

8

<b>MICHIGAN DEPARTMENT OF CONSERVATION</b>		
IN COOPERATION WITH UNITED STATES DEPARTMENT OF THE INTERIOR NATIONAL PARK SERVICE		
DRAWN BY HCJ-AUH	PROJECT YANKEE SPRINGS PROJECT	PLAN NO. 9096
DESIGNED BY TNZ	UTILITY PLAN FOR CHIEF NOONDAY CAMP	SCALE 1" = 80'-0"
CHECKED BY		RDP-LD-M-6 DATE 6-1-39
PREPARED AND APPROVED BY	Deputy Director, Dept. of Conservation	DATE
RECOMMENDED BY		DATE
APPROVED BY	REGIONAL DIRECTOR	DATE