
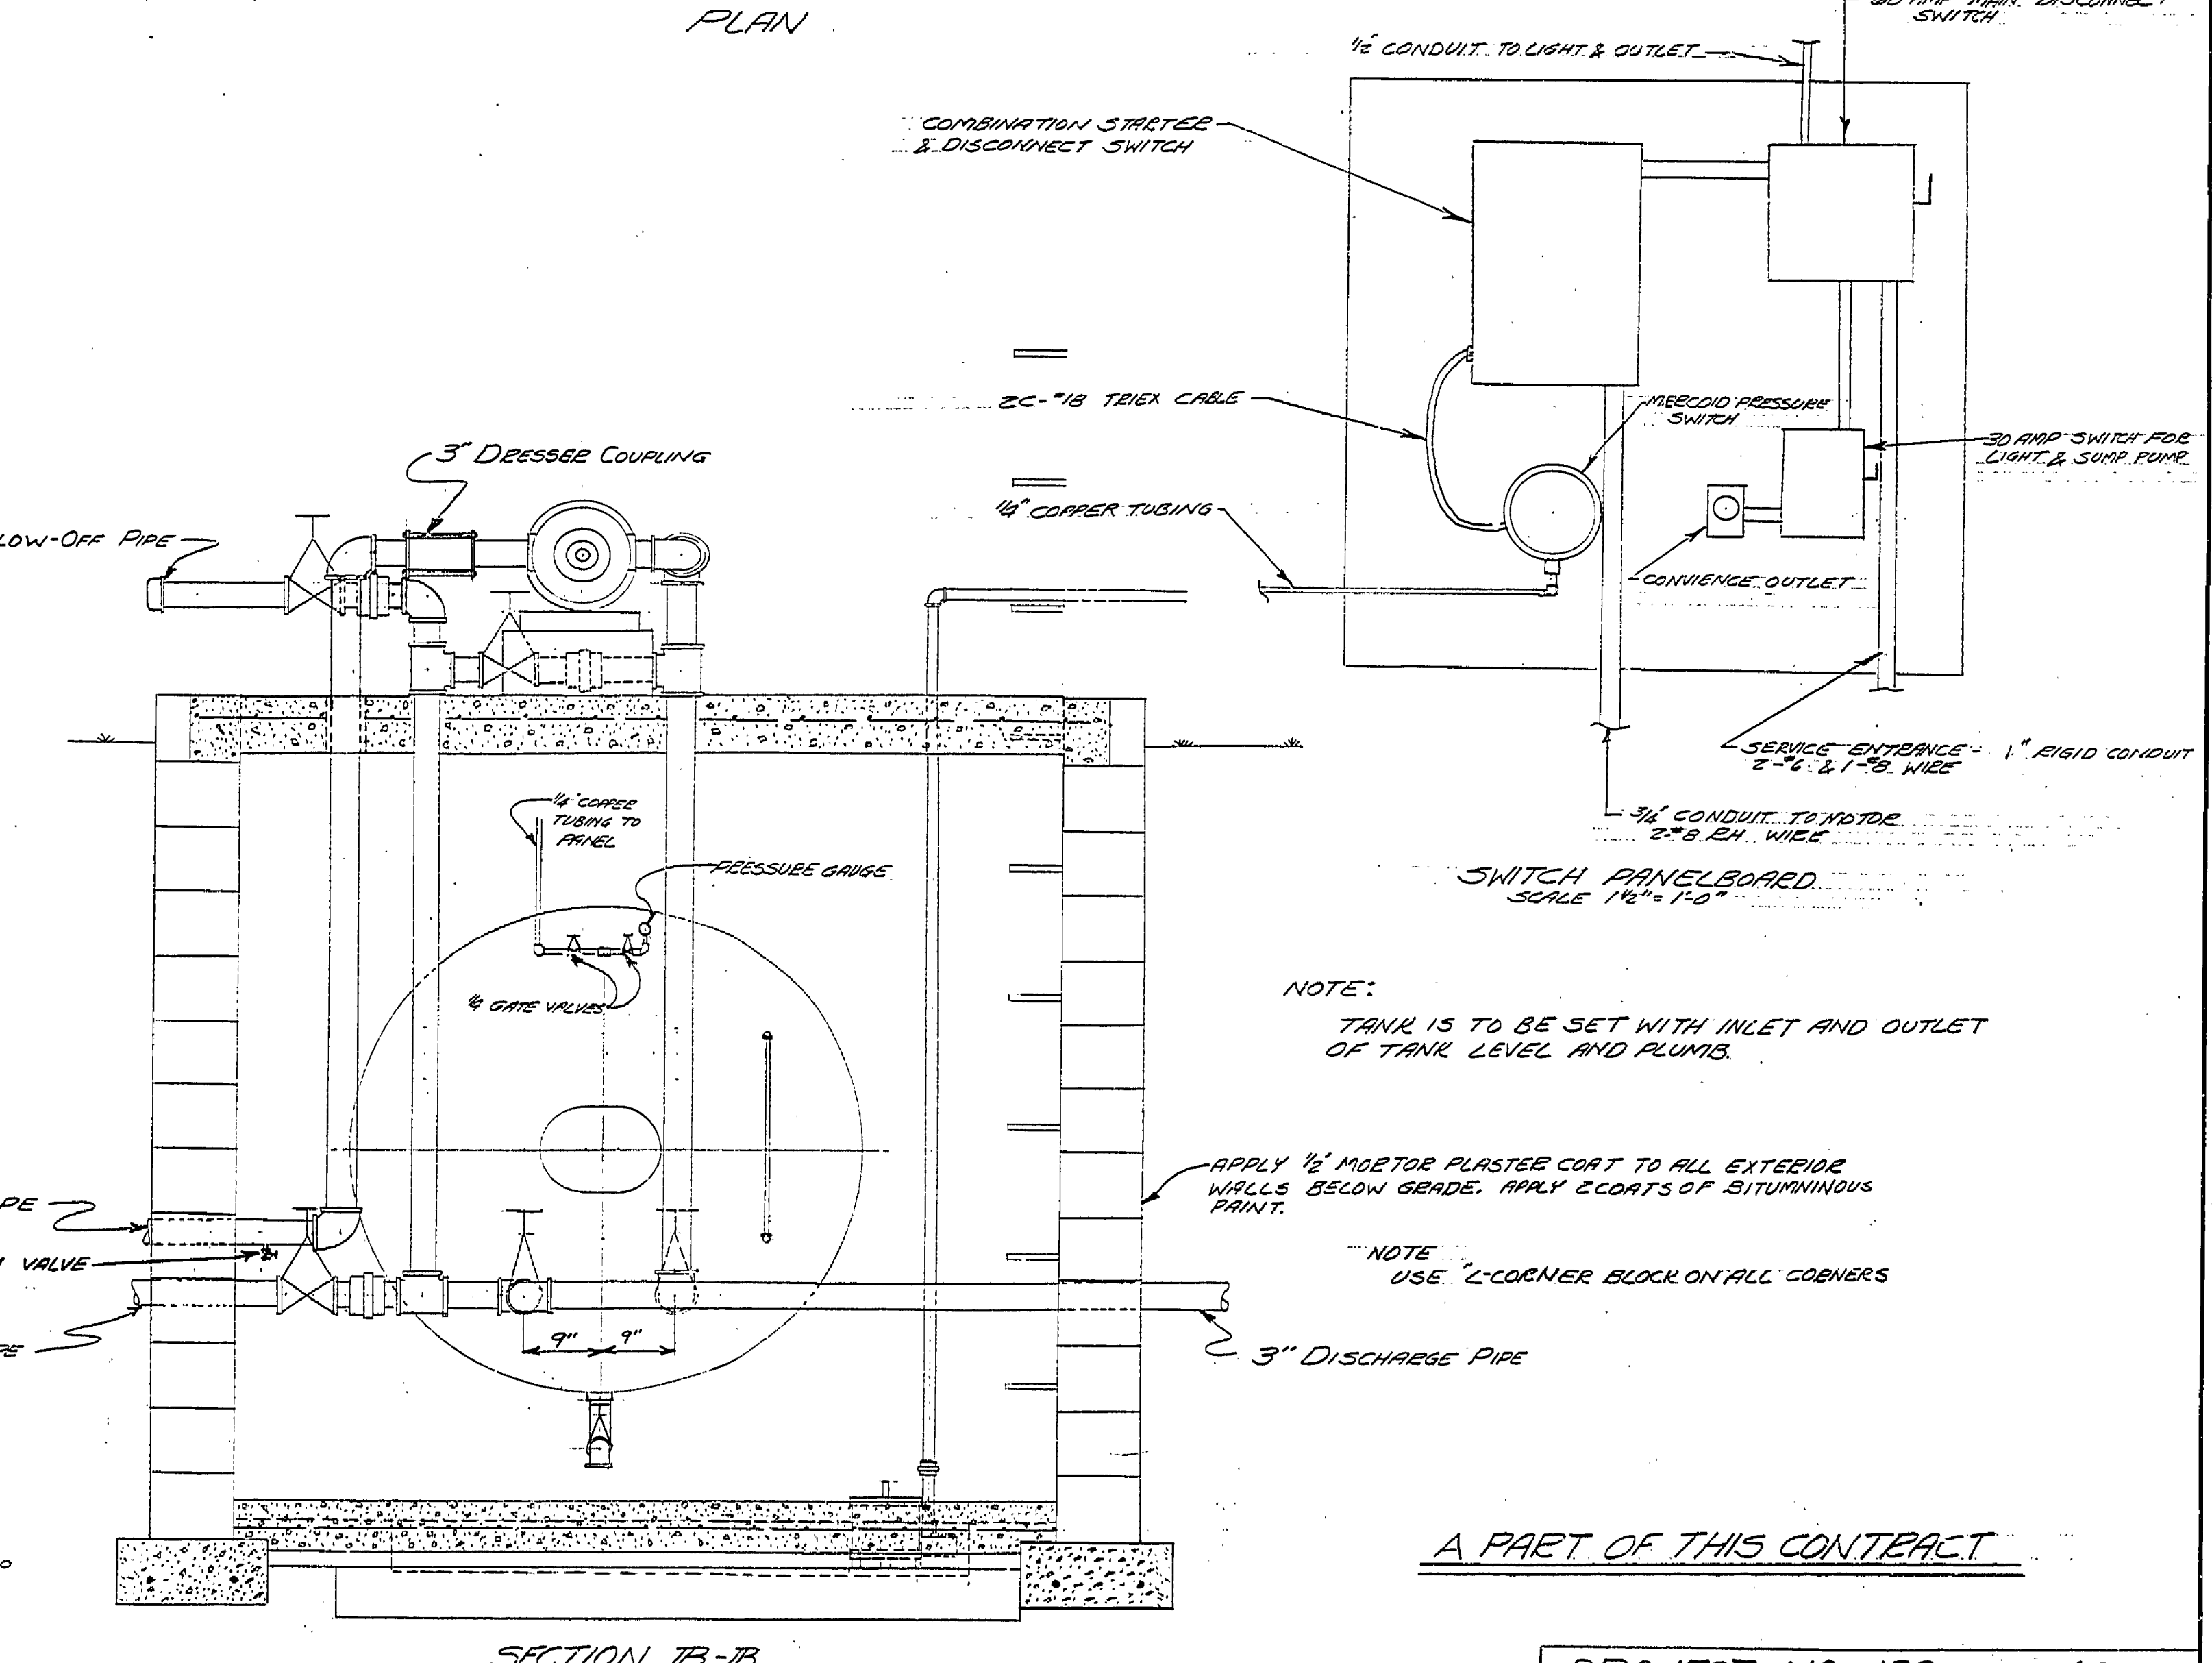
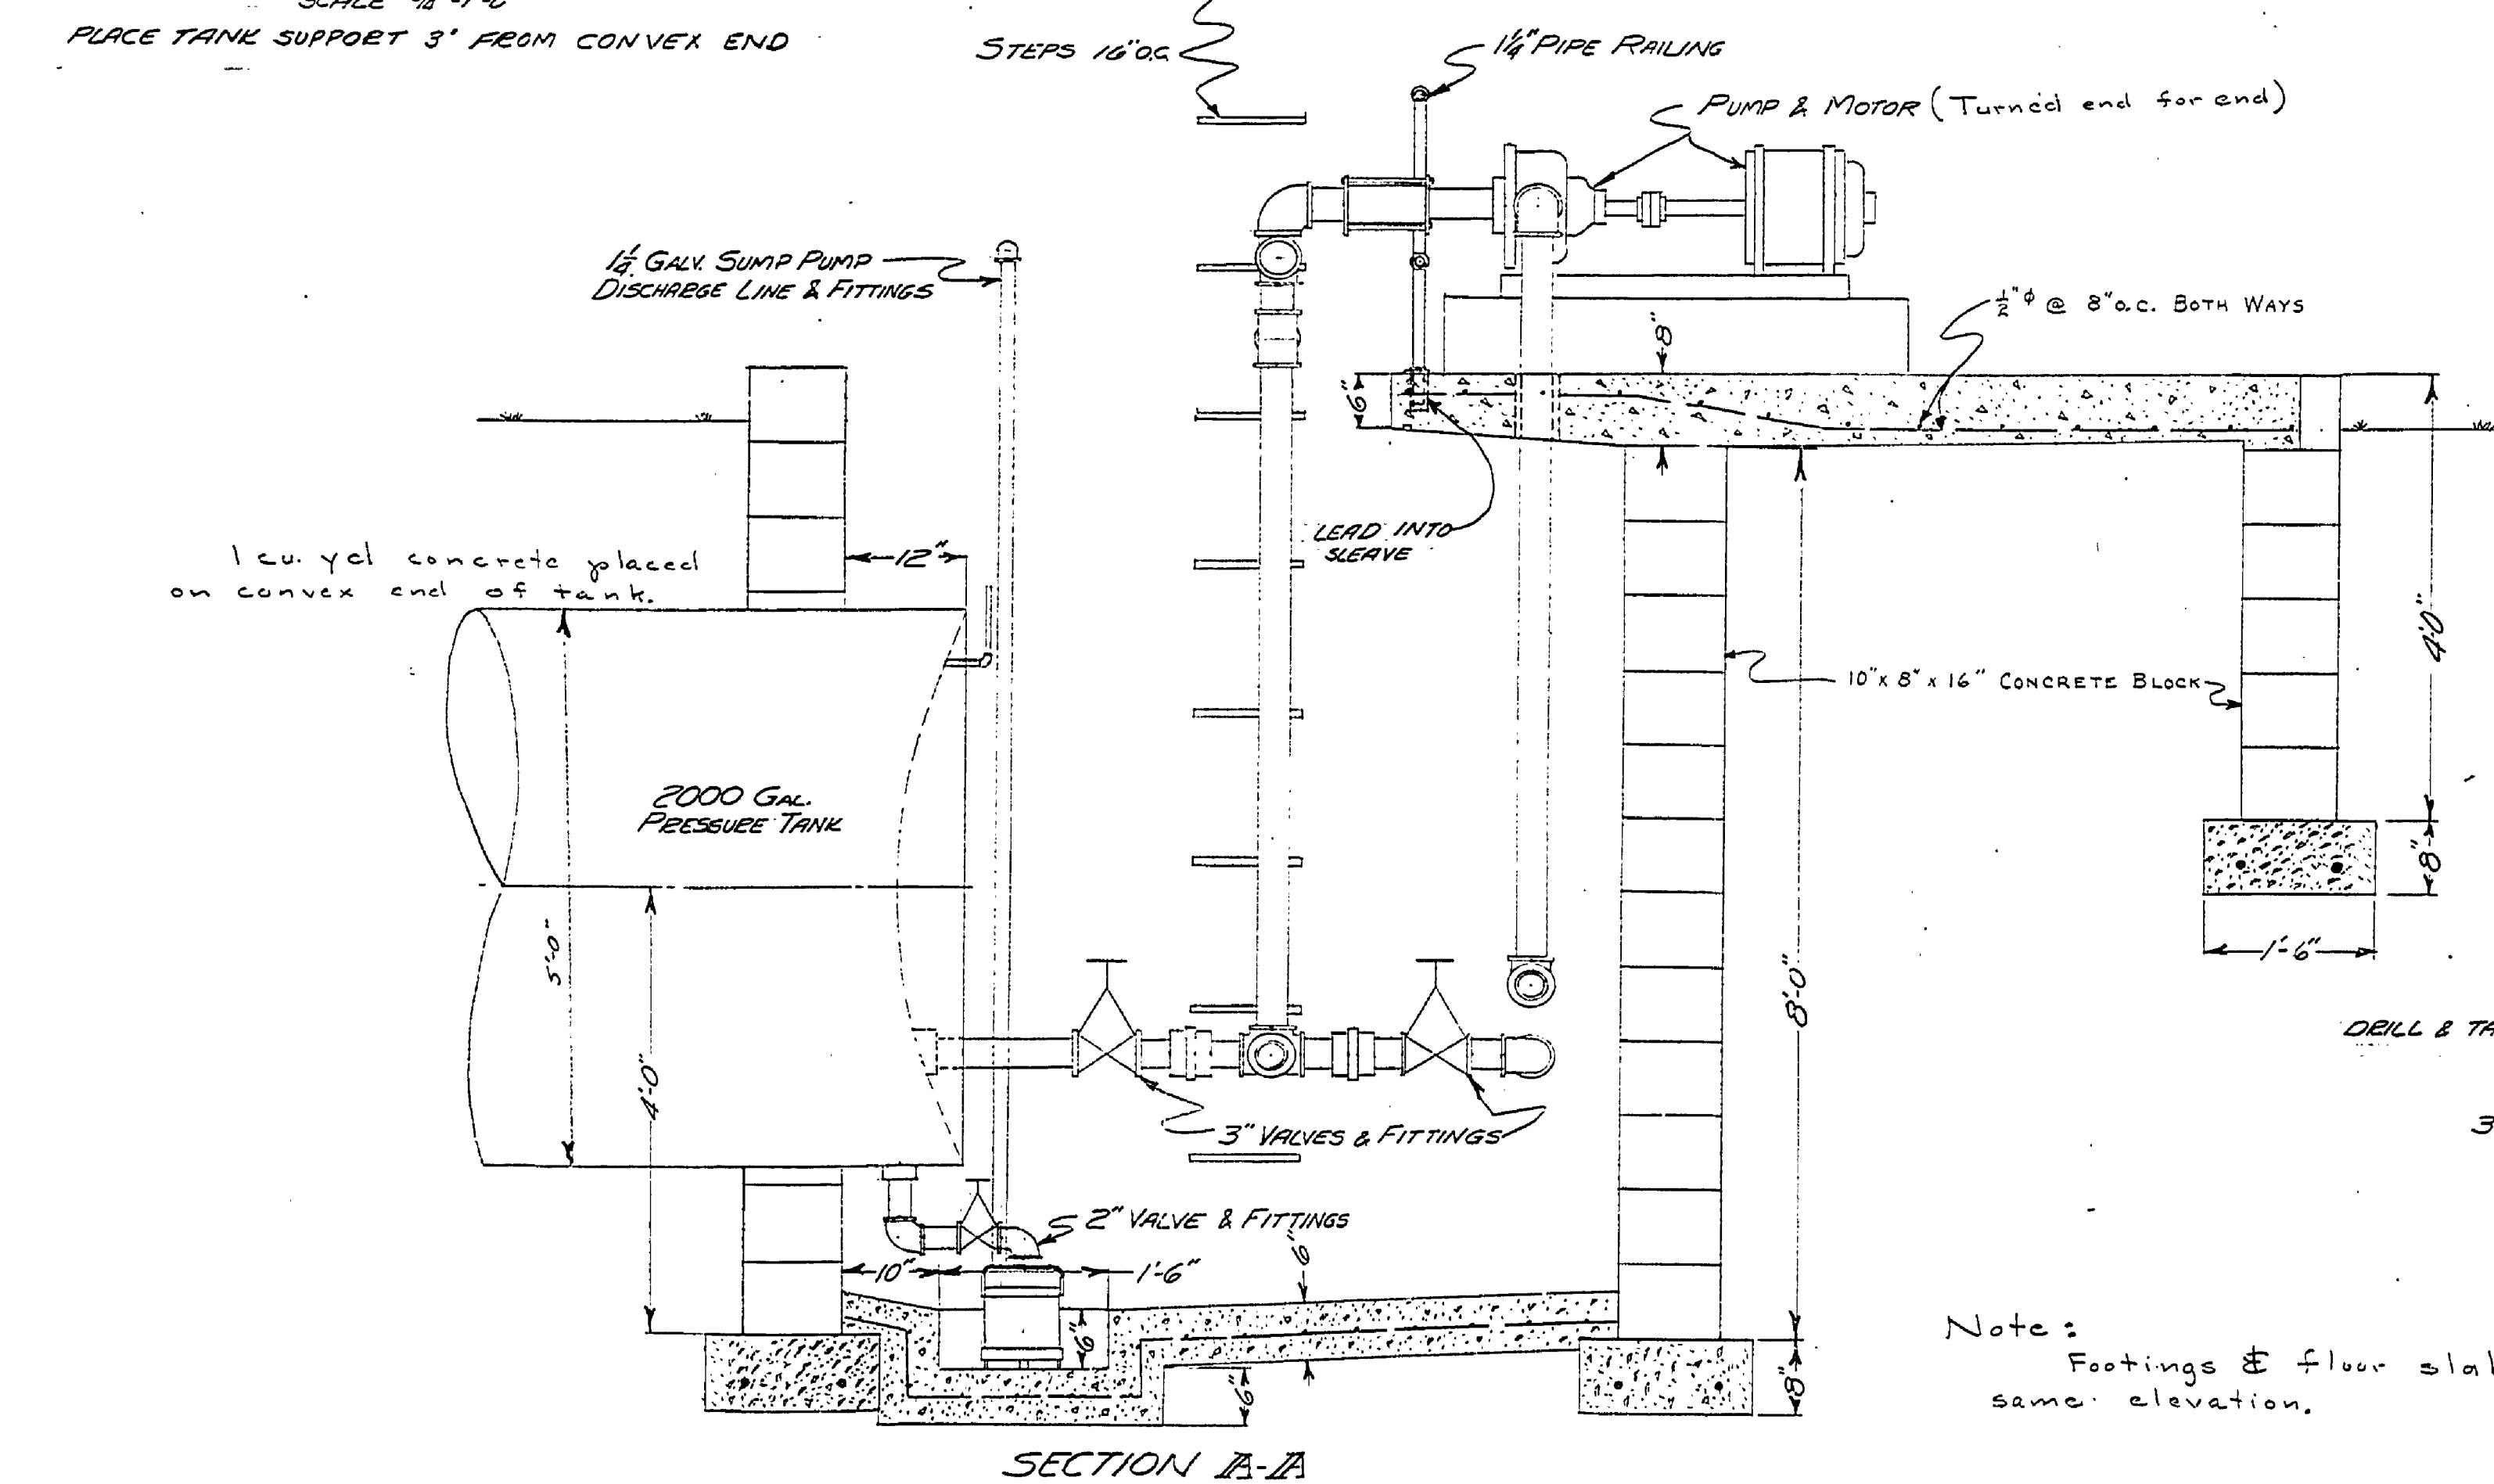
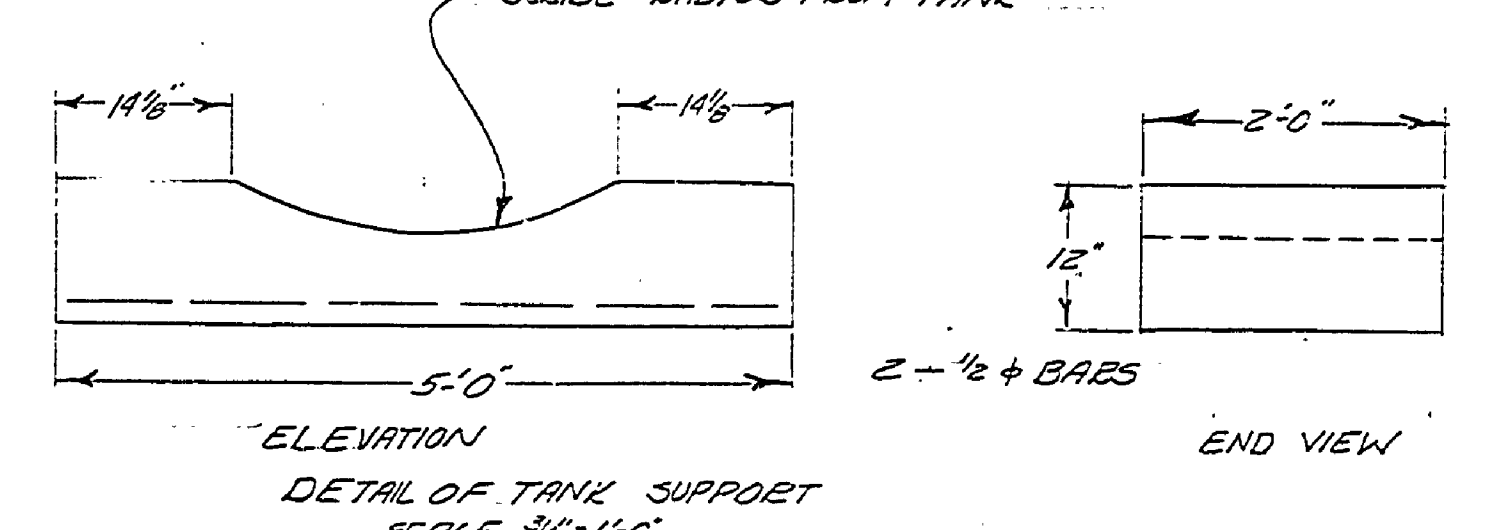
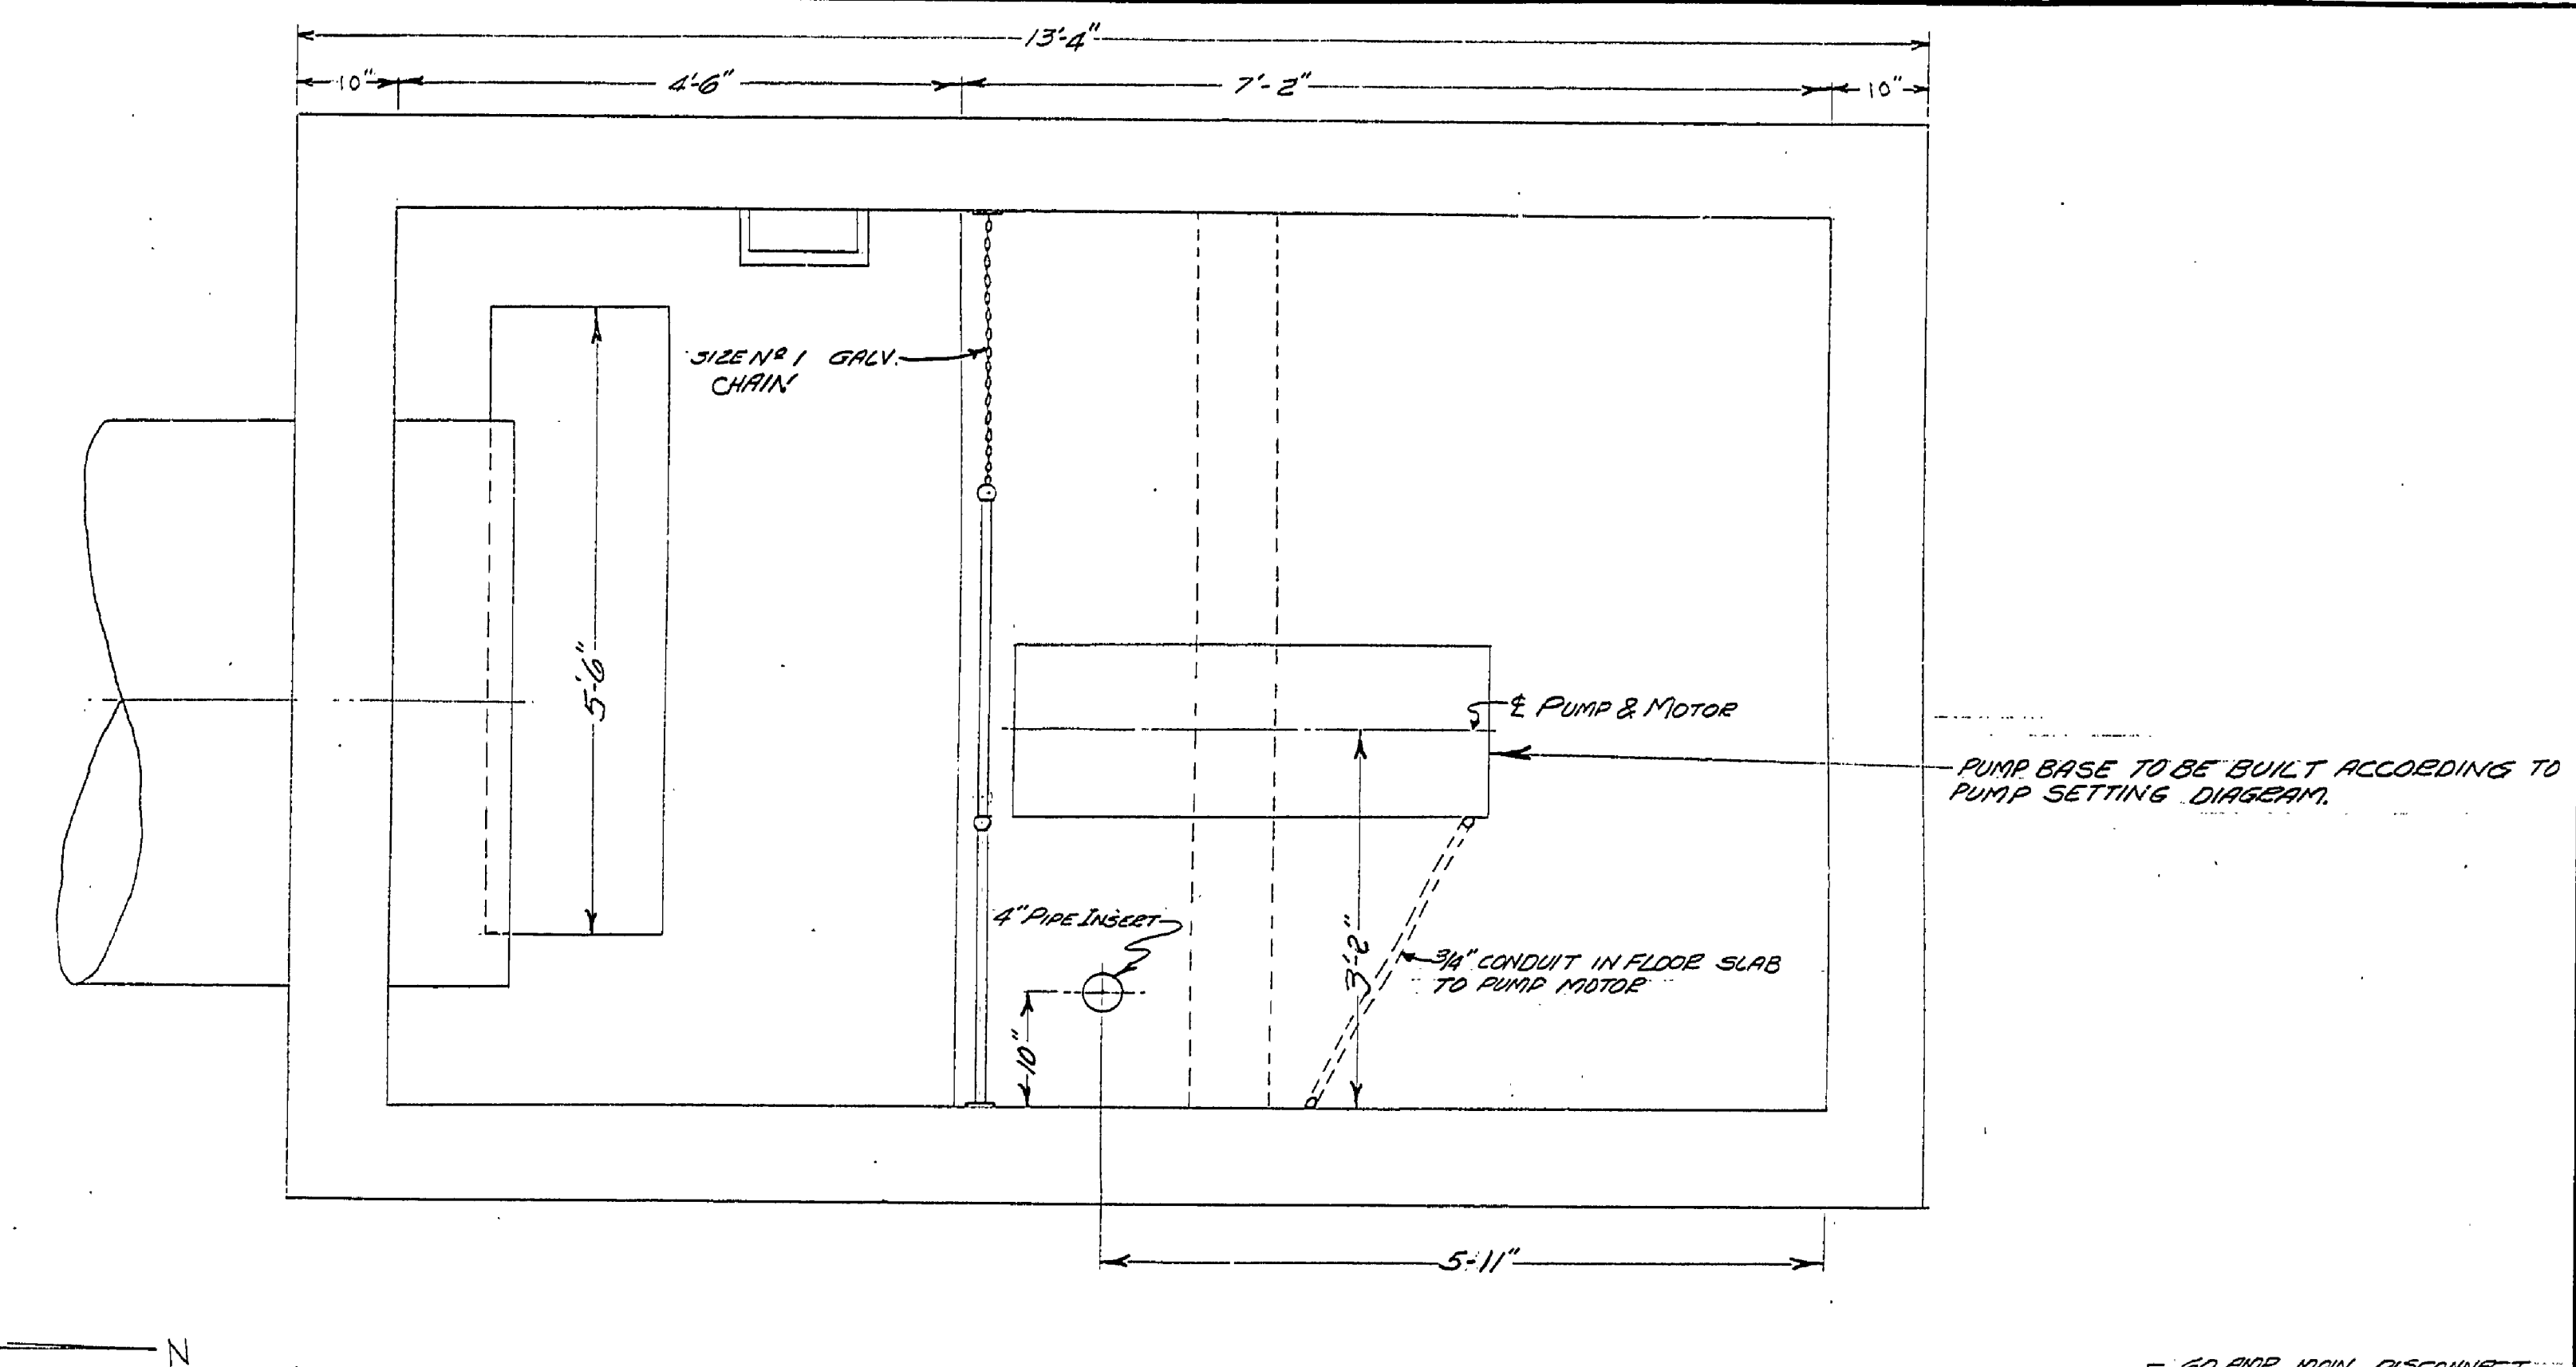


NO.	DATE	BY	REVISIONS
1	11-10-54	J.P.	1
2	8-22-56	J.P.	2
3	8-22-56	J.P.	3
4			4
5			5
6			6

Pump & piping changed
 APPROVED BY: *[Signature]*
 ASSISTANT CHIEF IN CHARGE
 DATE: 8-22-56
 OF DESIGN: 8-22-56
 REVIEWED BY SECTIONS:
 ARCHITECTURAL: J.P.
 ENGINEERING: J.P.
 LANDSCAPE: J.P.
 DRAWN BY: F.C. BENNETT
 TRACED BY: E.J.P.
 CHECKED BY: E.J.P.
 DATE: APRIL 12, 1956

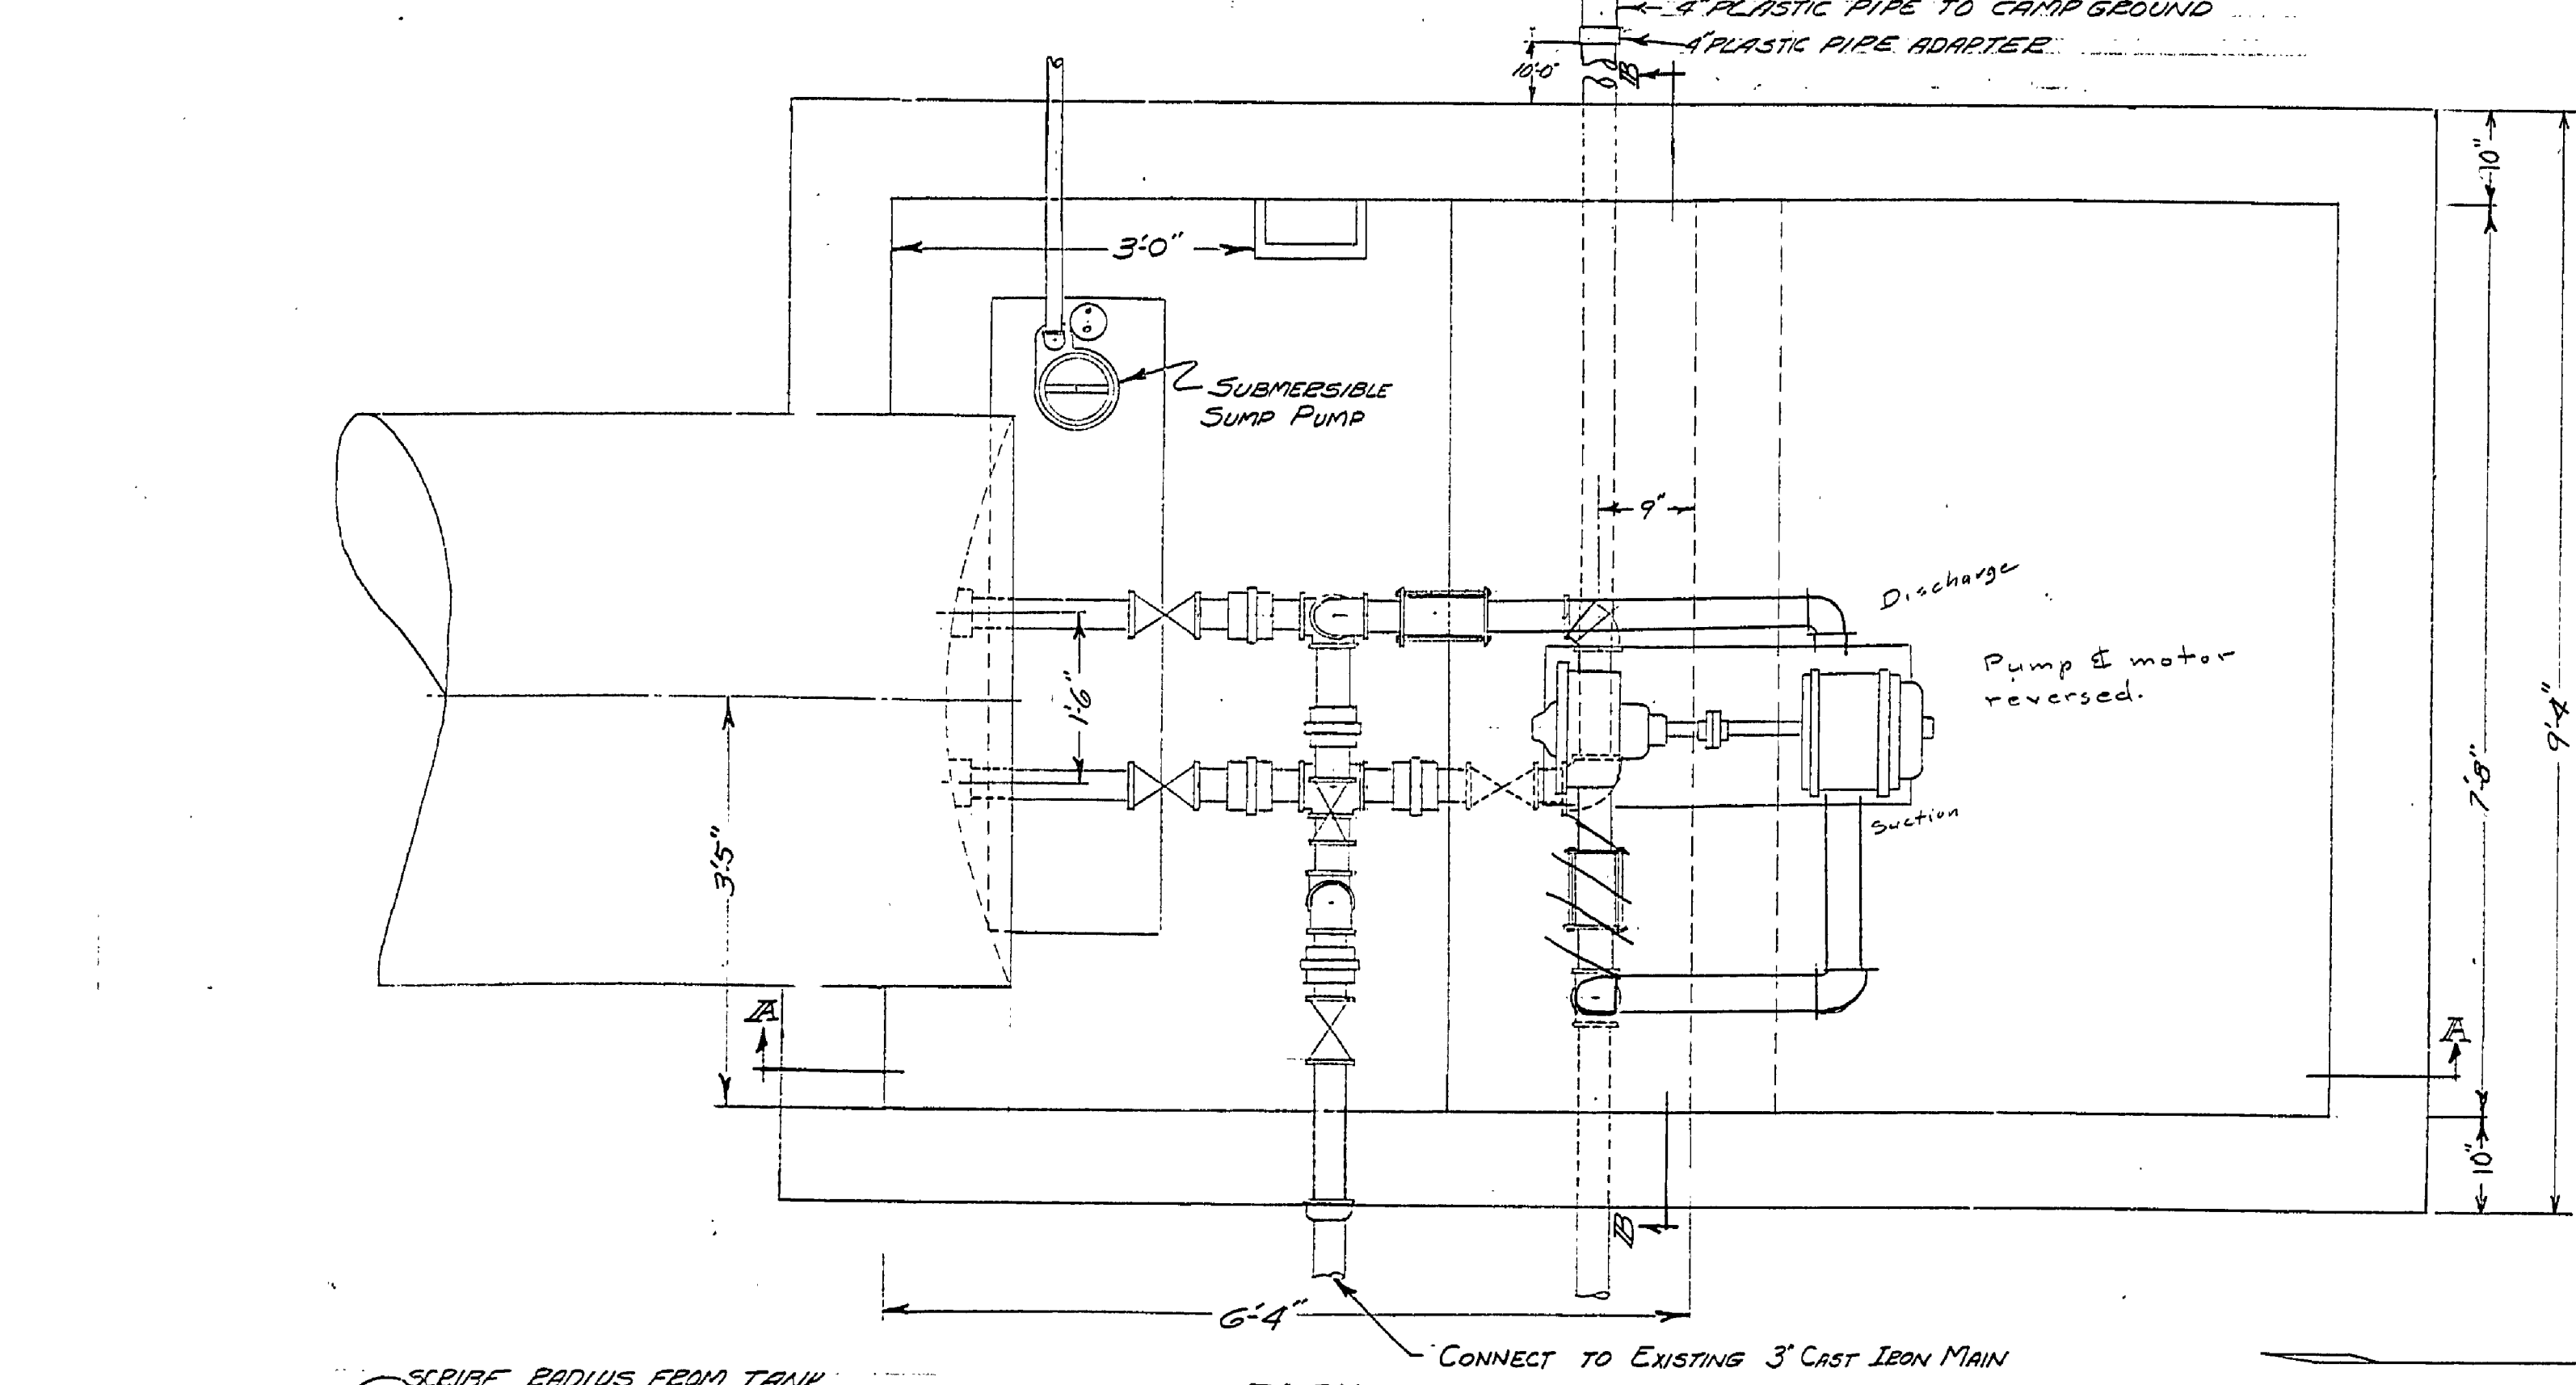

PUMP HOUSE NO. 1

MECHANICAL DETAILS
SCALE 3/4"=1'-0"

MICHIGAN DEPARTMENT OF CONSERVATION
PARKS AND RECREATION DIVISION

YANKEE SPRINGS RECREATION AREA WATER SYSTEM

PROJECT NO. 128-1C

SHEET NO. 5 OF 8
PLAN NO. E-134

A PART OF THIS CONTRACT