


DRAINAGE LAYOUT  
SCALE 1" = 1'-0"

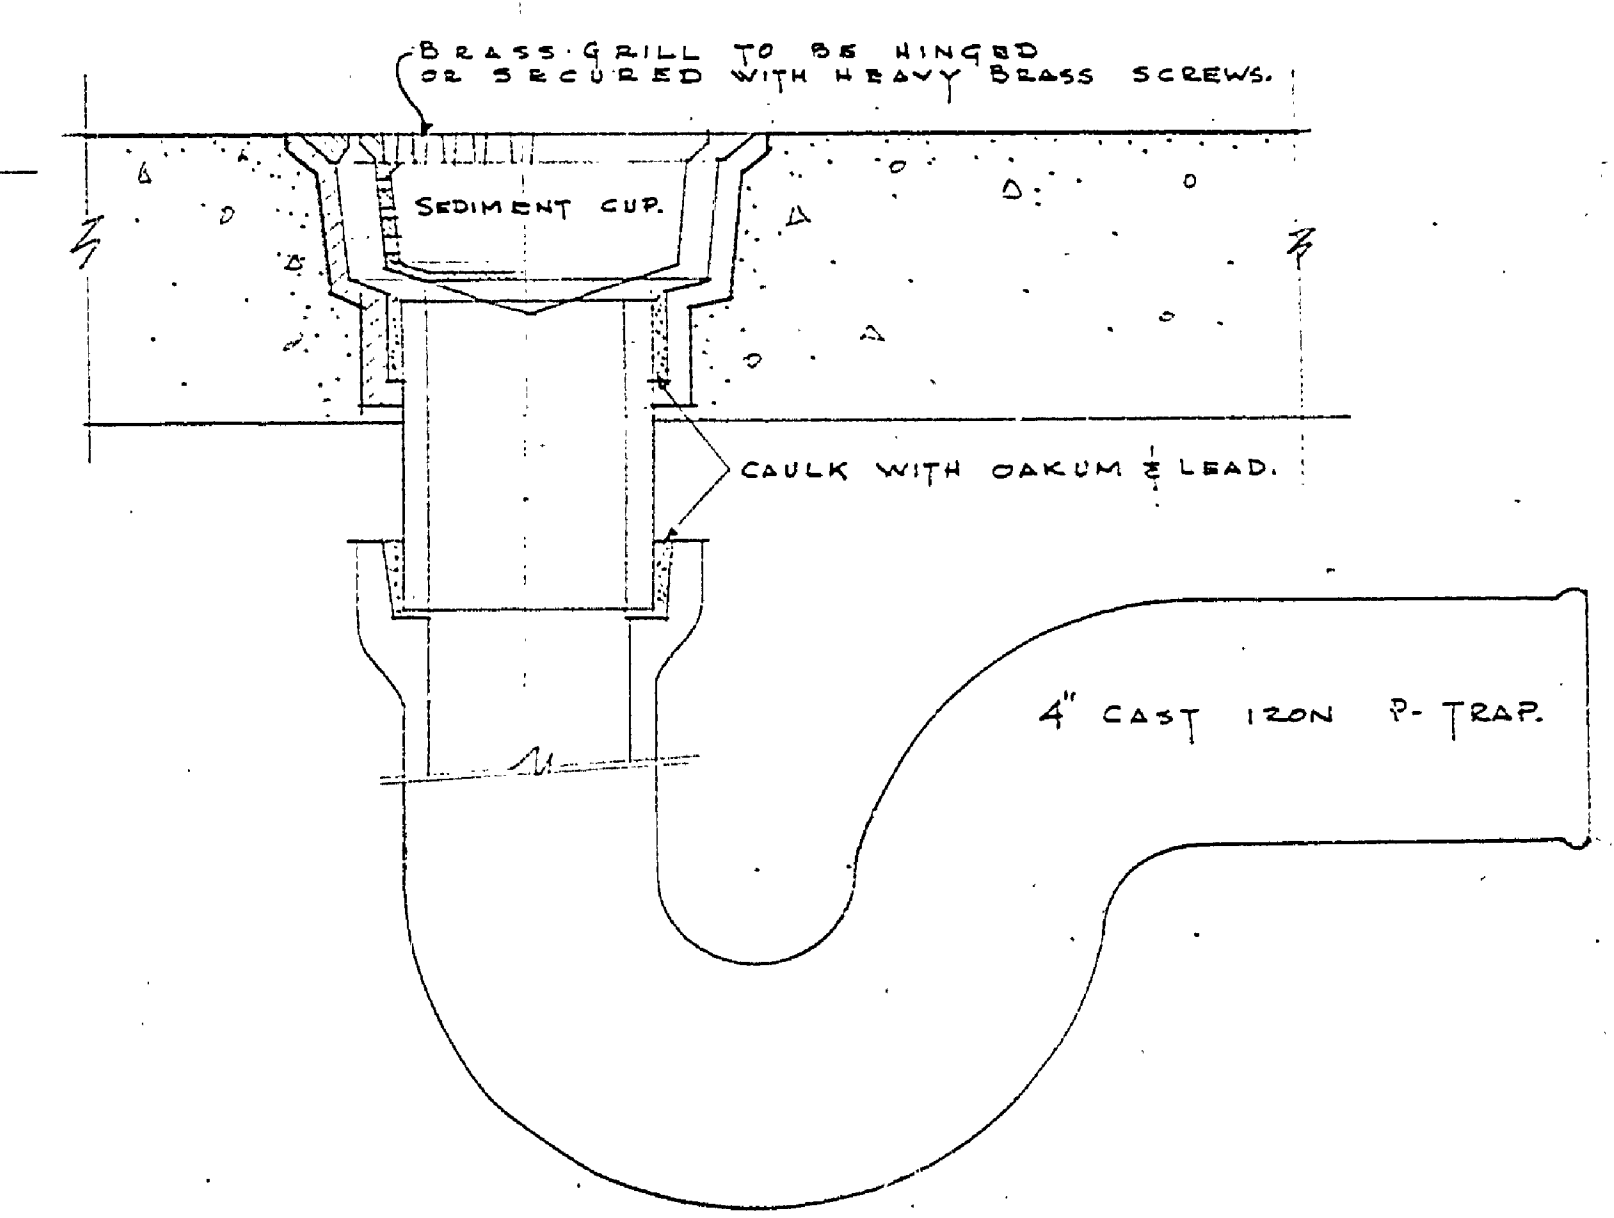

DETAIL OF FLOOR DRAINS

UNITED STATES DEPARTMENT OF THE INTERIOR NATIONAL PARK SERVICE COOPERATING WITH MICHIGAN DEPARTMENT OF CONSERVATION			
DRAWN BY C. J. RUDIN	LUDINGTON	PLAN NO. LUD. 90925-3	A-96
DESIGNED BY E. J. H.	STATE PARK No. 2 PUBLIC CAMP GROUND No. 2	SCALE AS SHOWN	
CHECKED BY [Signature]	TOILET BUILDING	DATE 9/10/39	
PREPARED BY [Signature]	APPROVED BY [Signature]	DATE 11/2/39	
RECOMMENDED [Signature]	INSPECTOR	DATE 1/6/40	

INSURANCE No. 10  
 MASTER PLAN 65