
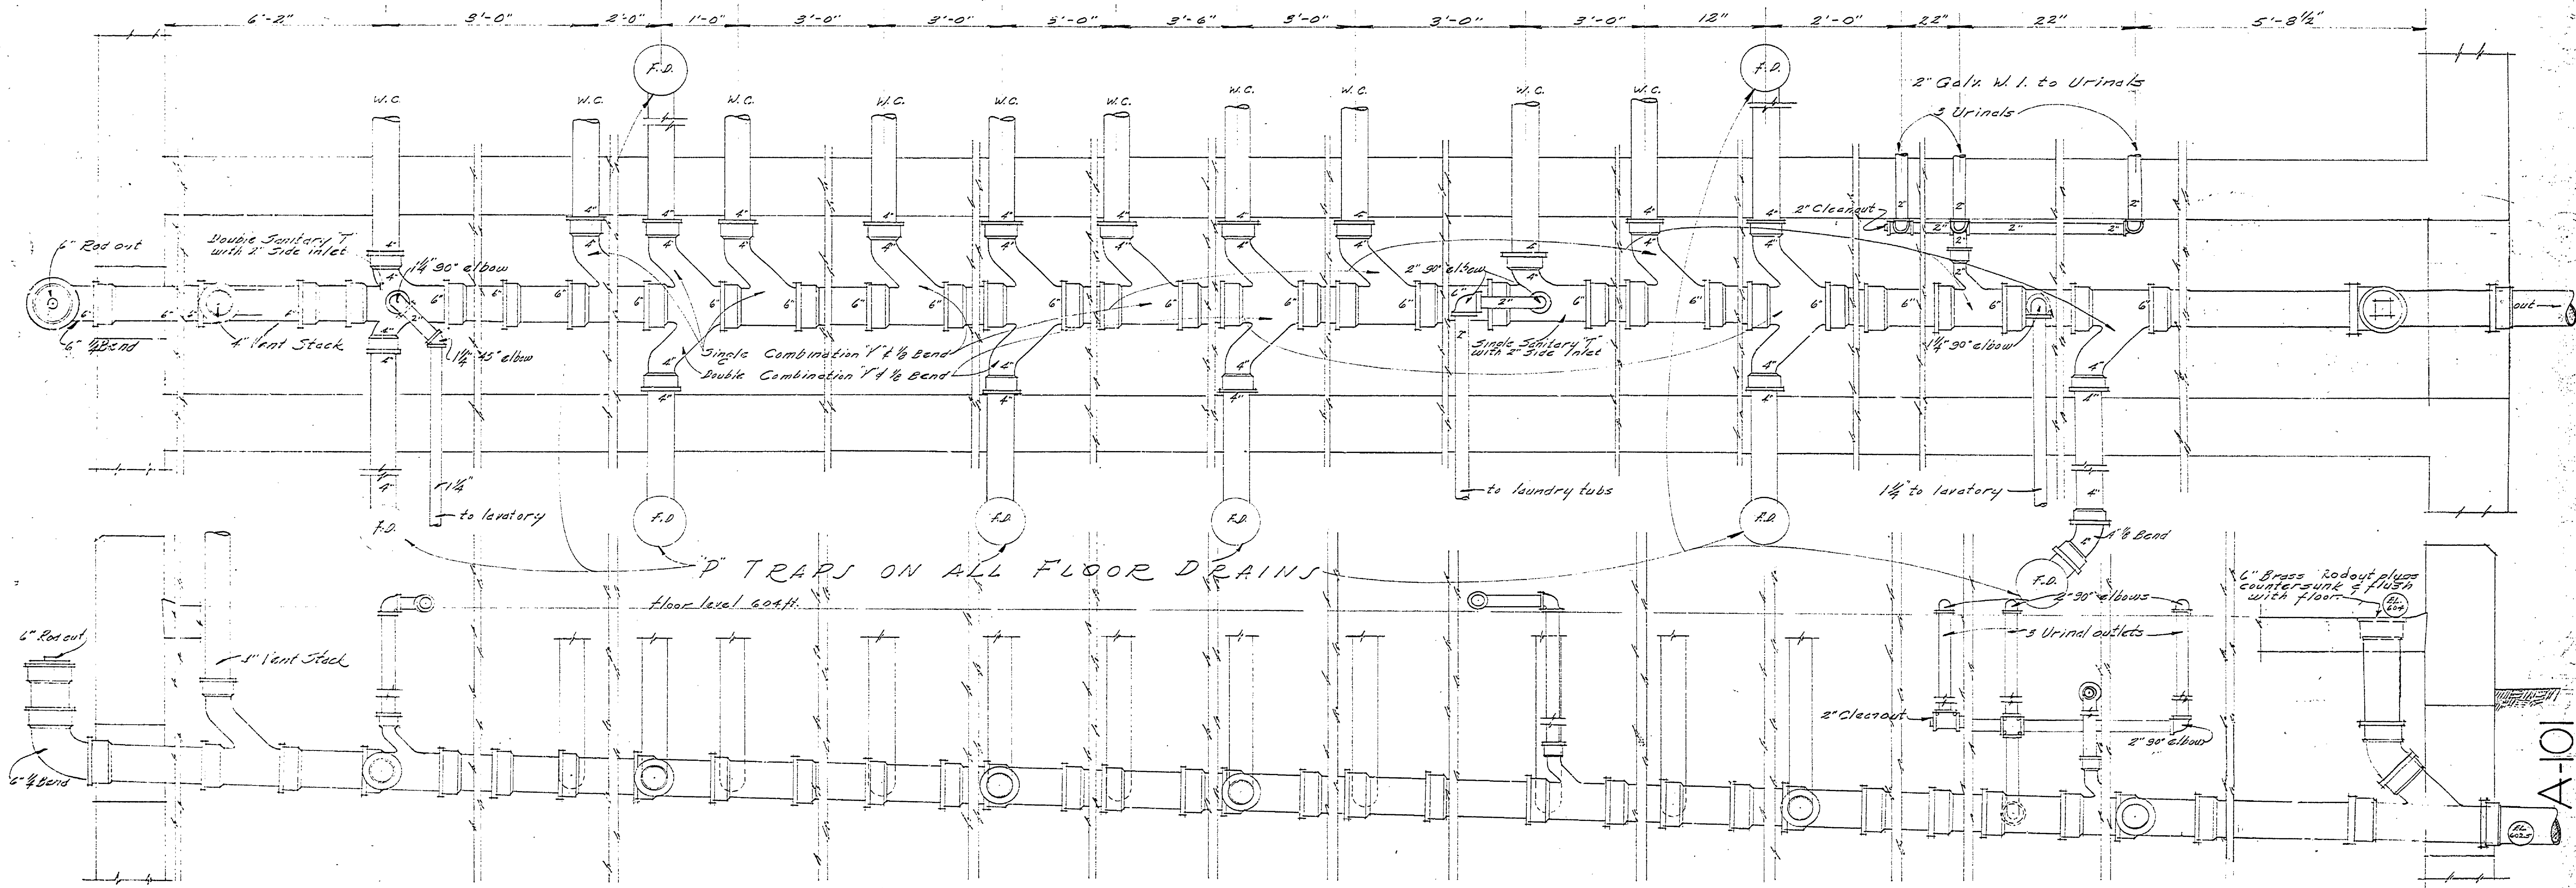


FOUNDATION PLAN  
and  
PLUMBING LAYOUT  
Scale 1/4"=1'-0"

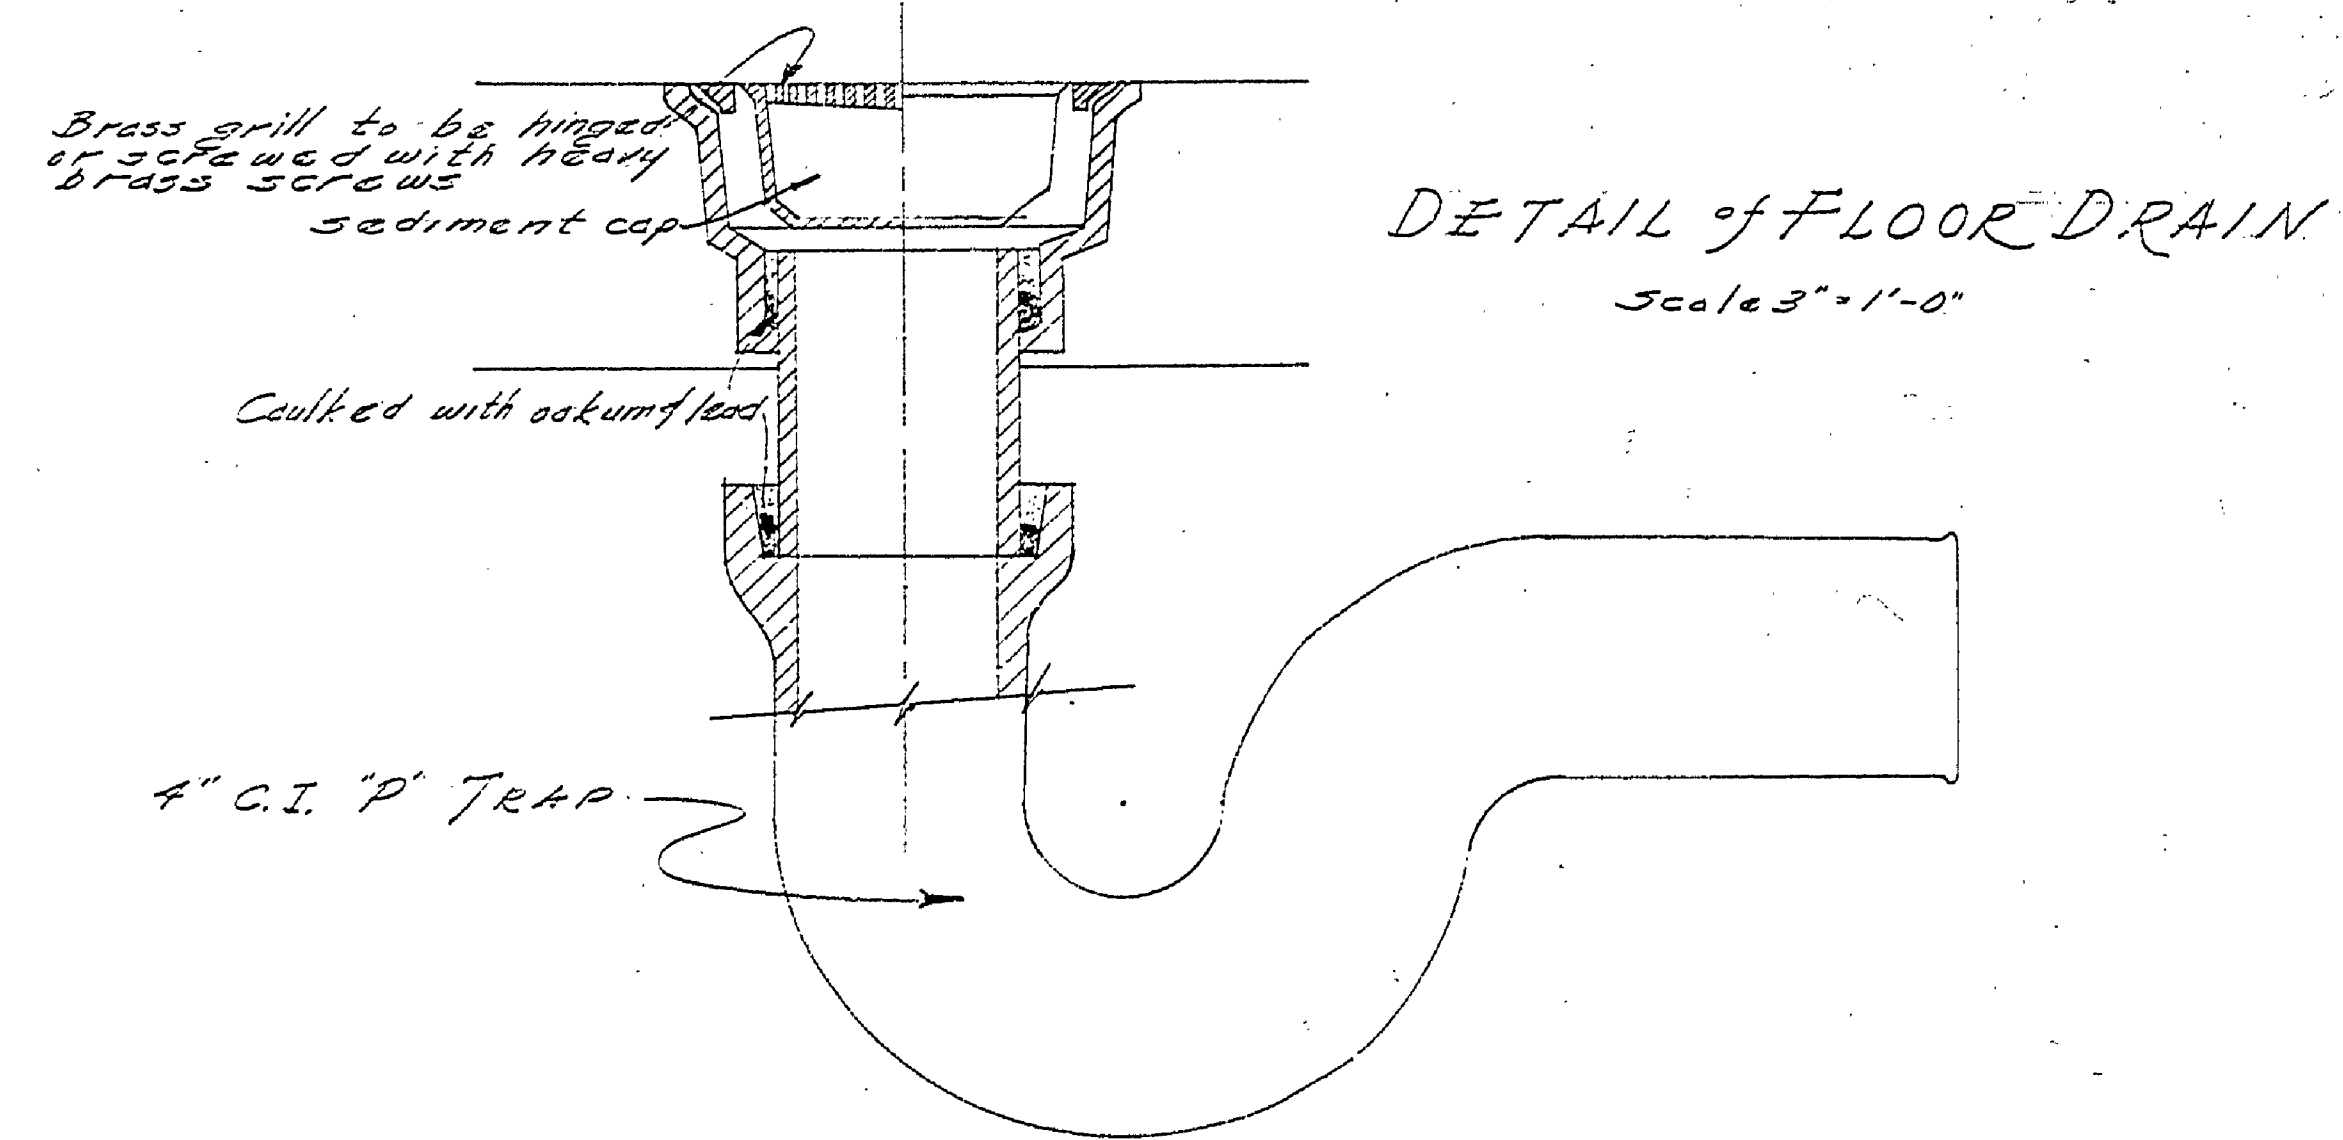

DETAILED LAYOUT OF DRAINAGE SYSTEM  
SCALE 1"=1'-0"

MICHIGAN DEPARTMENT OF CONSERVATION UNITED STATES DEPARTMENT OF INTERIOR NATIONAL PARK SERVICE COOPERATING		
DESIGNED BY E. H. SWICK	LUDINGTON STATE PARK	PARK BLDG SHEET NO. 44
DRAWN BY C. W. POLYKE	COMBINATION TOILET	SCALE: 1/4"=1'-0"
CHECKED BY	LAUNDRY BUILDING	DATE: 5-28-40
PREPARED BY	CHIEF PLUMBER DIVISION	DATE
APPROVED BY	SUPERVISOR	DATE
APPROVED BY	INSPECTOR	DATE

MASTER PLAN