




DESIGNED BY	DATE	REVIEWED	DATE	APPROVED	DATE	NO.	DATE	REVISIONS	DATE
U.S. GREENWOOD	5-61	ARCHITECTURAL	5-27-61	<i>[Signature]</i>	5/6	1		4	
CL	5-61	ENGINEERING	7-27-61	<i>[Signature]</i>	5/6	2		5	
CHECKED BY	7-61	LANDSCAPE	7-27-61	<i>[Signature]</i>	5/6	3		6	

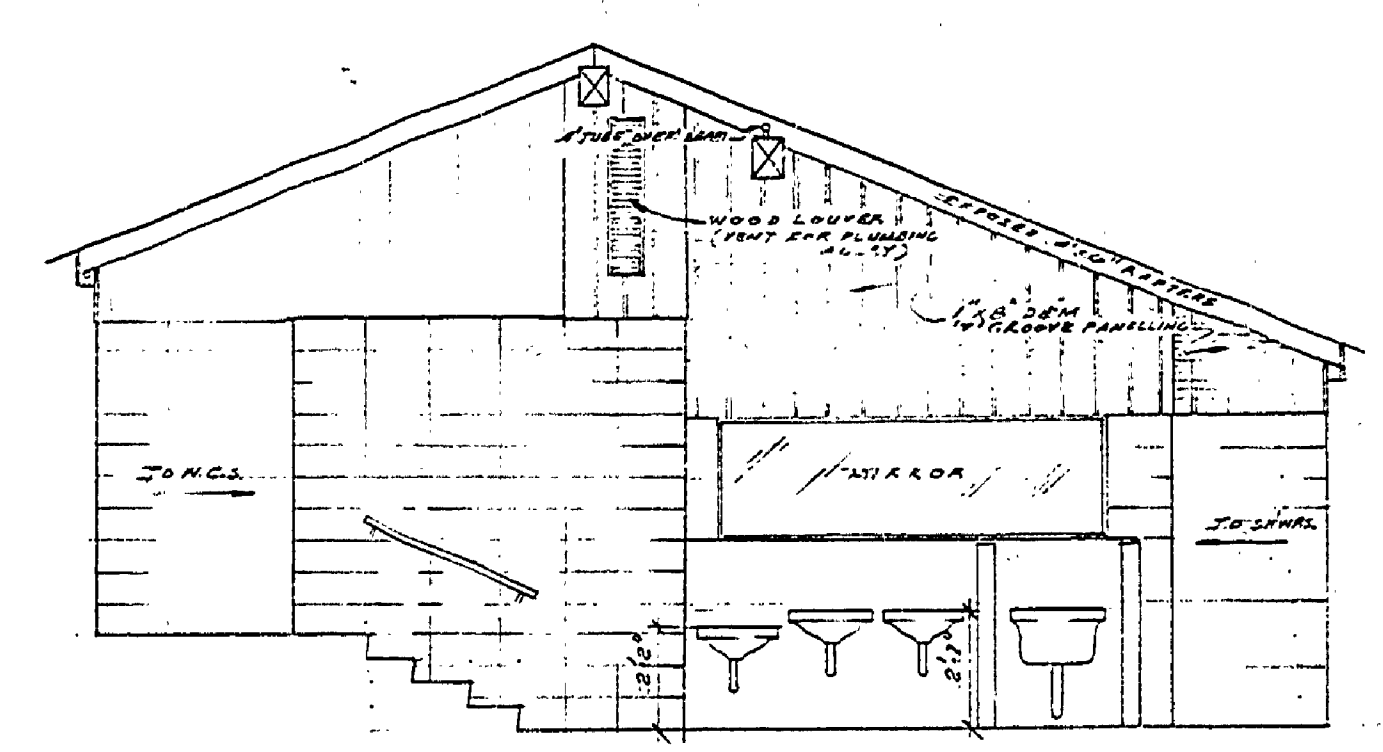


N.W. WALL - WOMENS TOILET  
SCALE 1/4" = 1'-0"

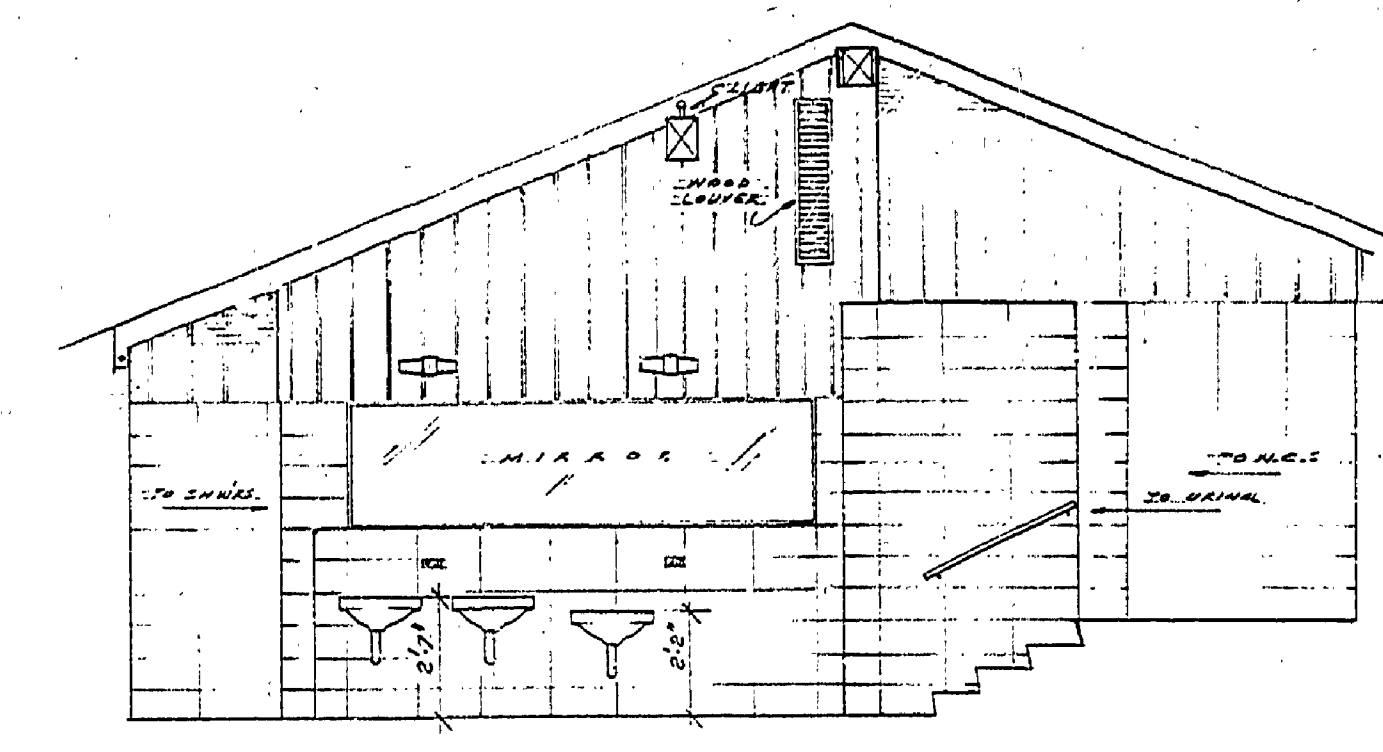


S.E. WALL - MENS TOILET  
SCALE 1/4" = 1'-0"

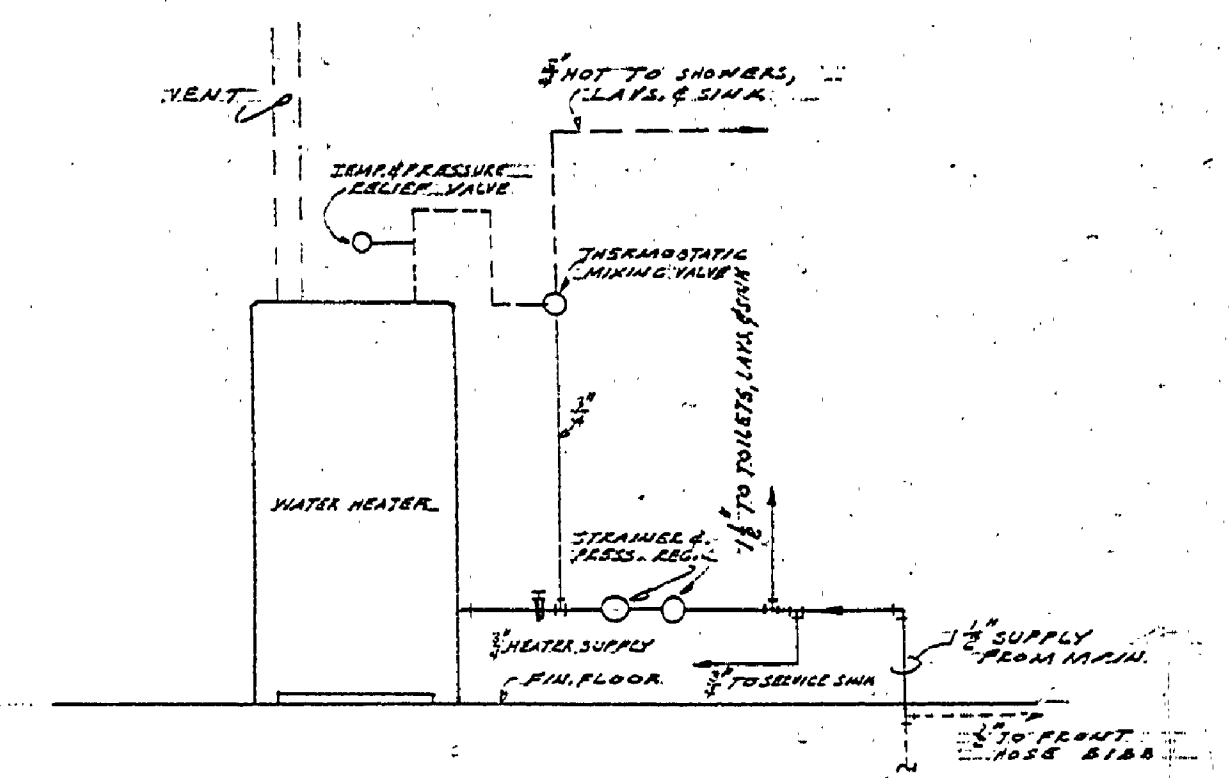

WATER HEATER PIPING  
NO SCALE

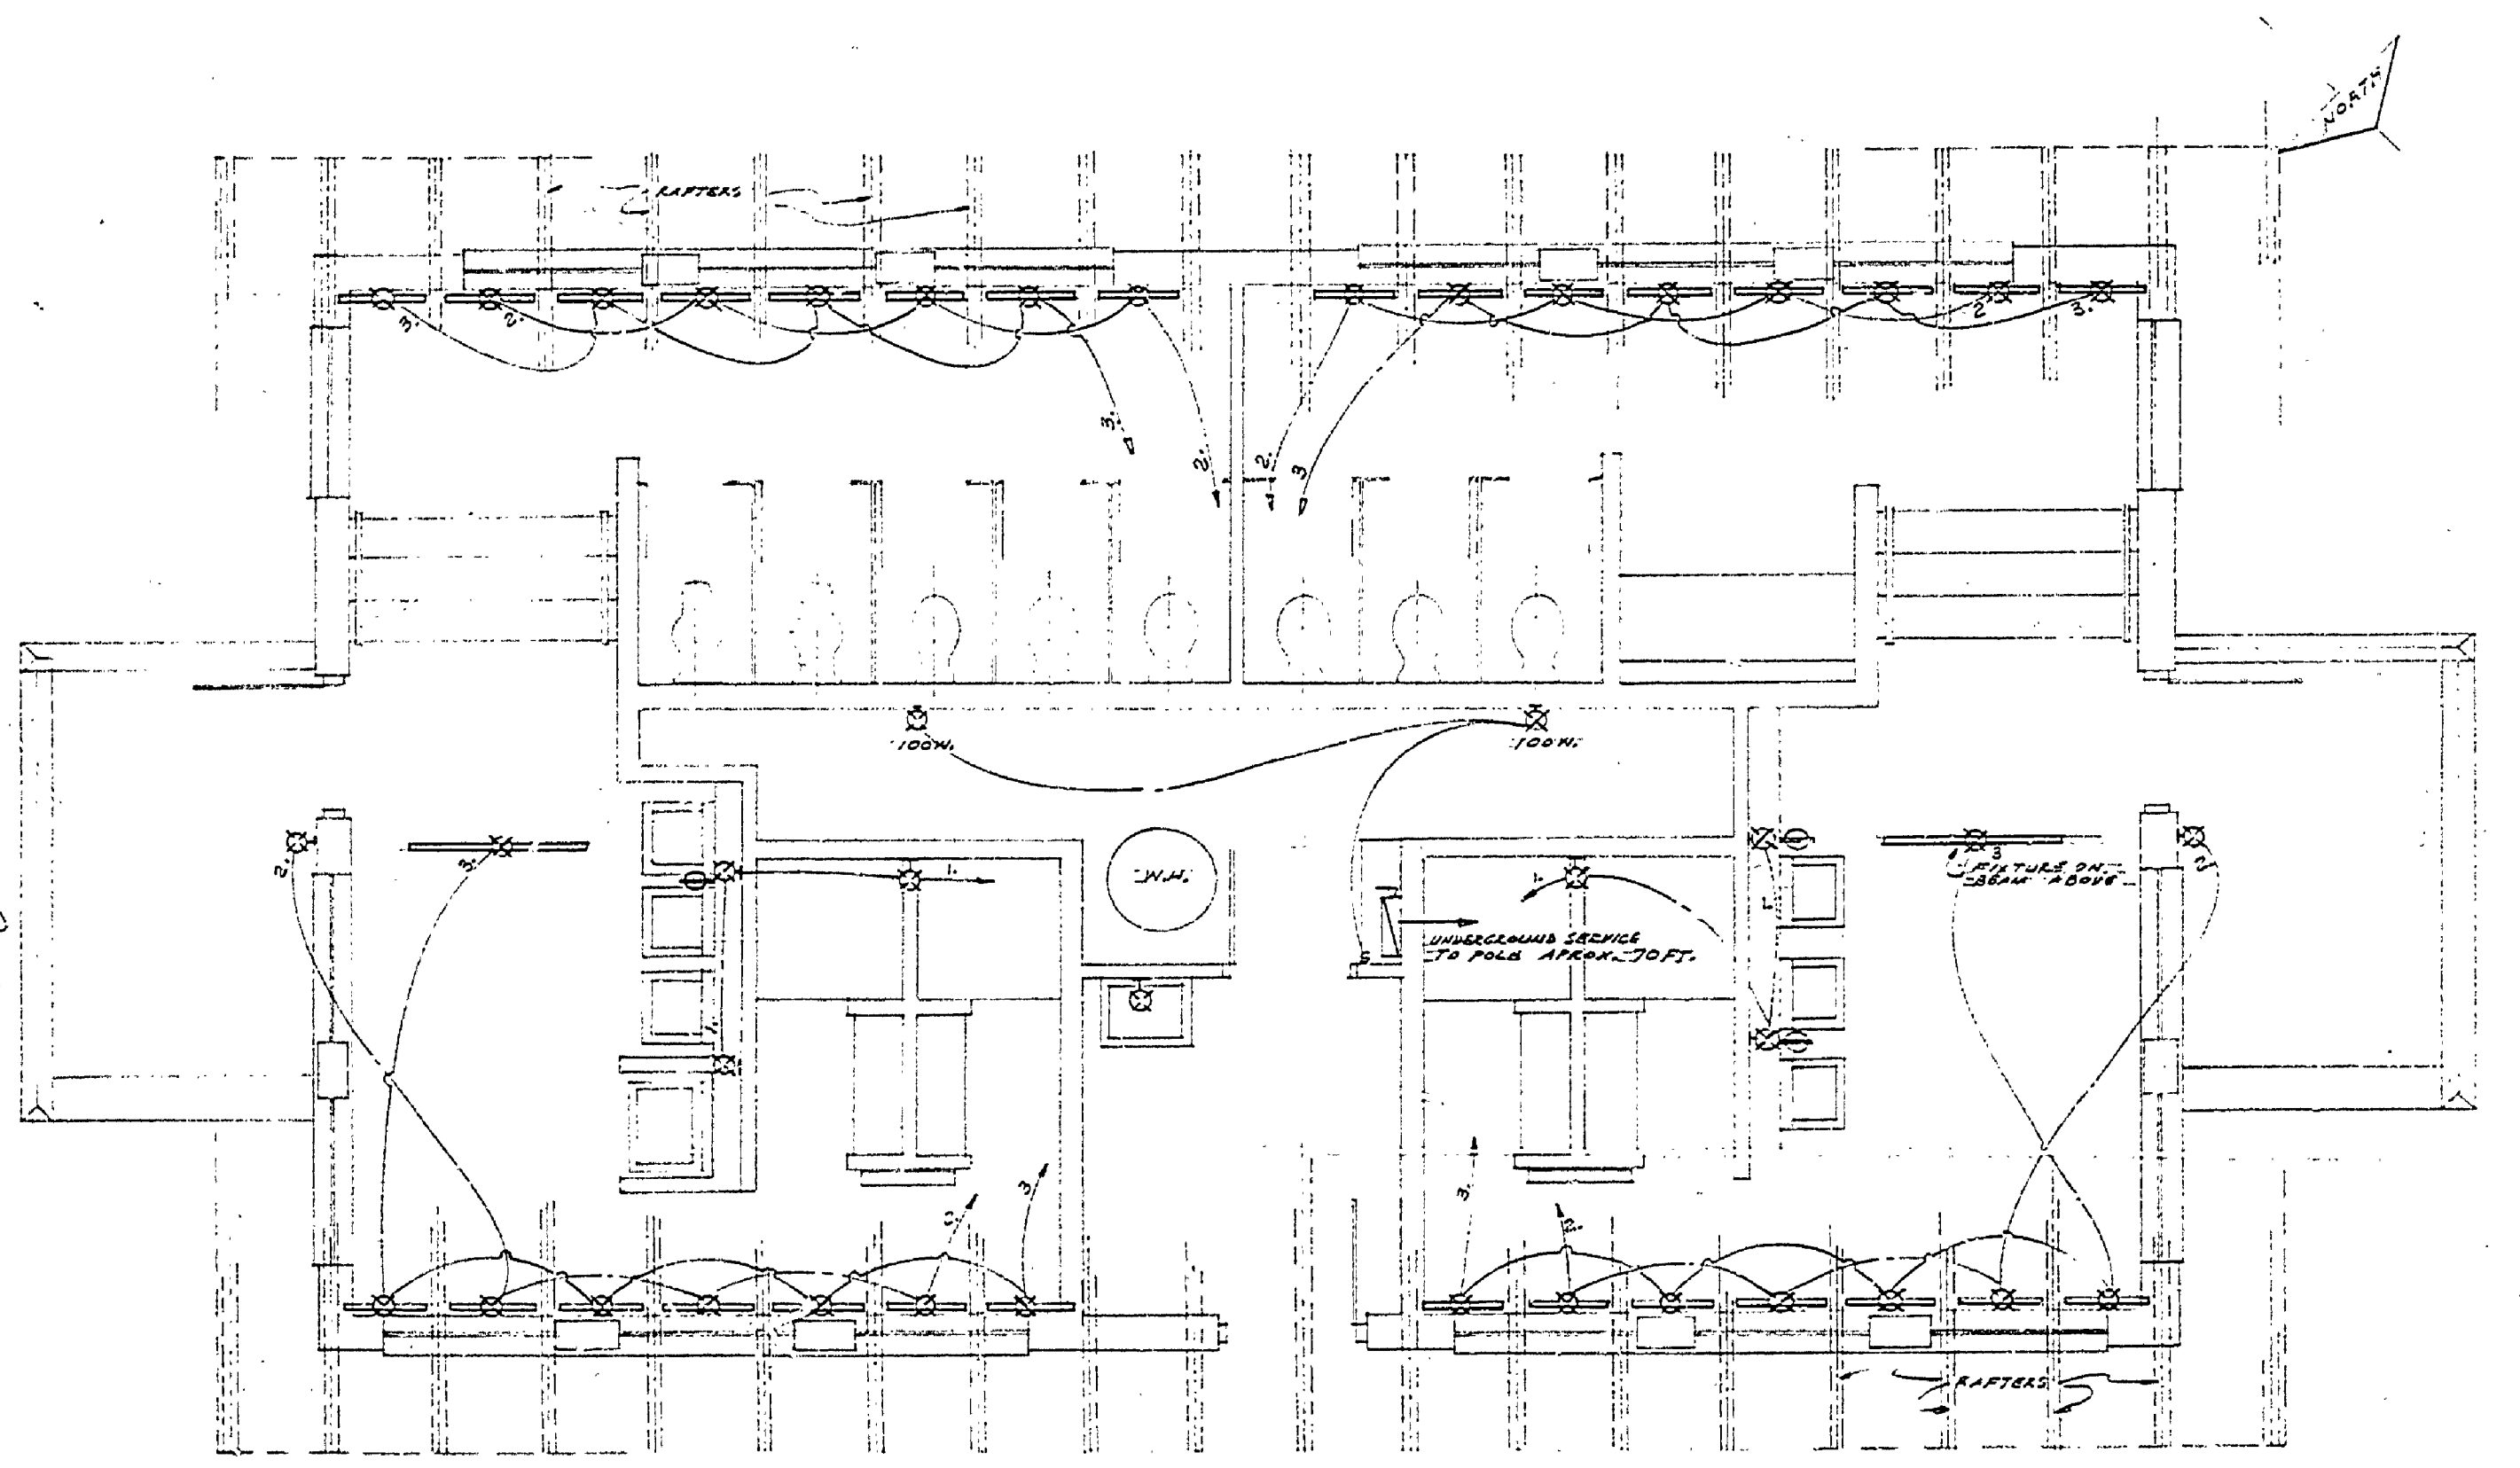

ELECTRICAL PLAN  
SCALE 1/4" = 1'-0"

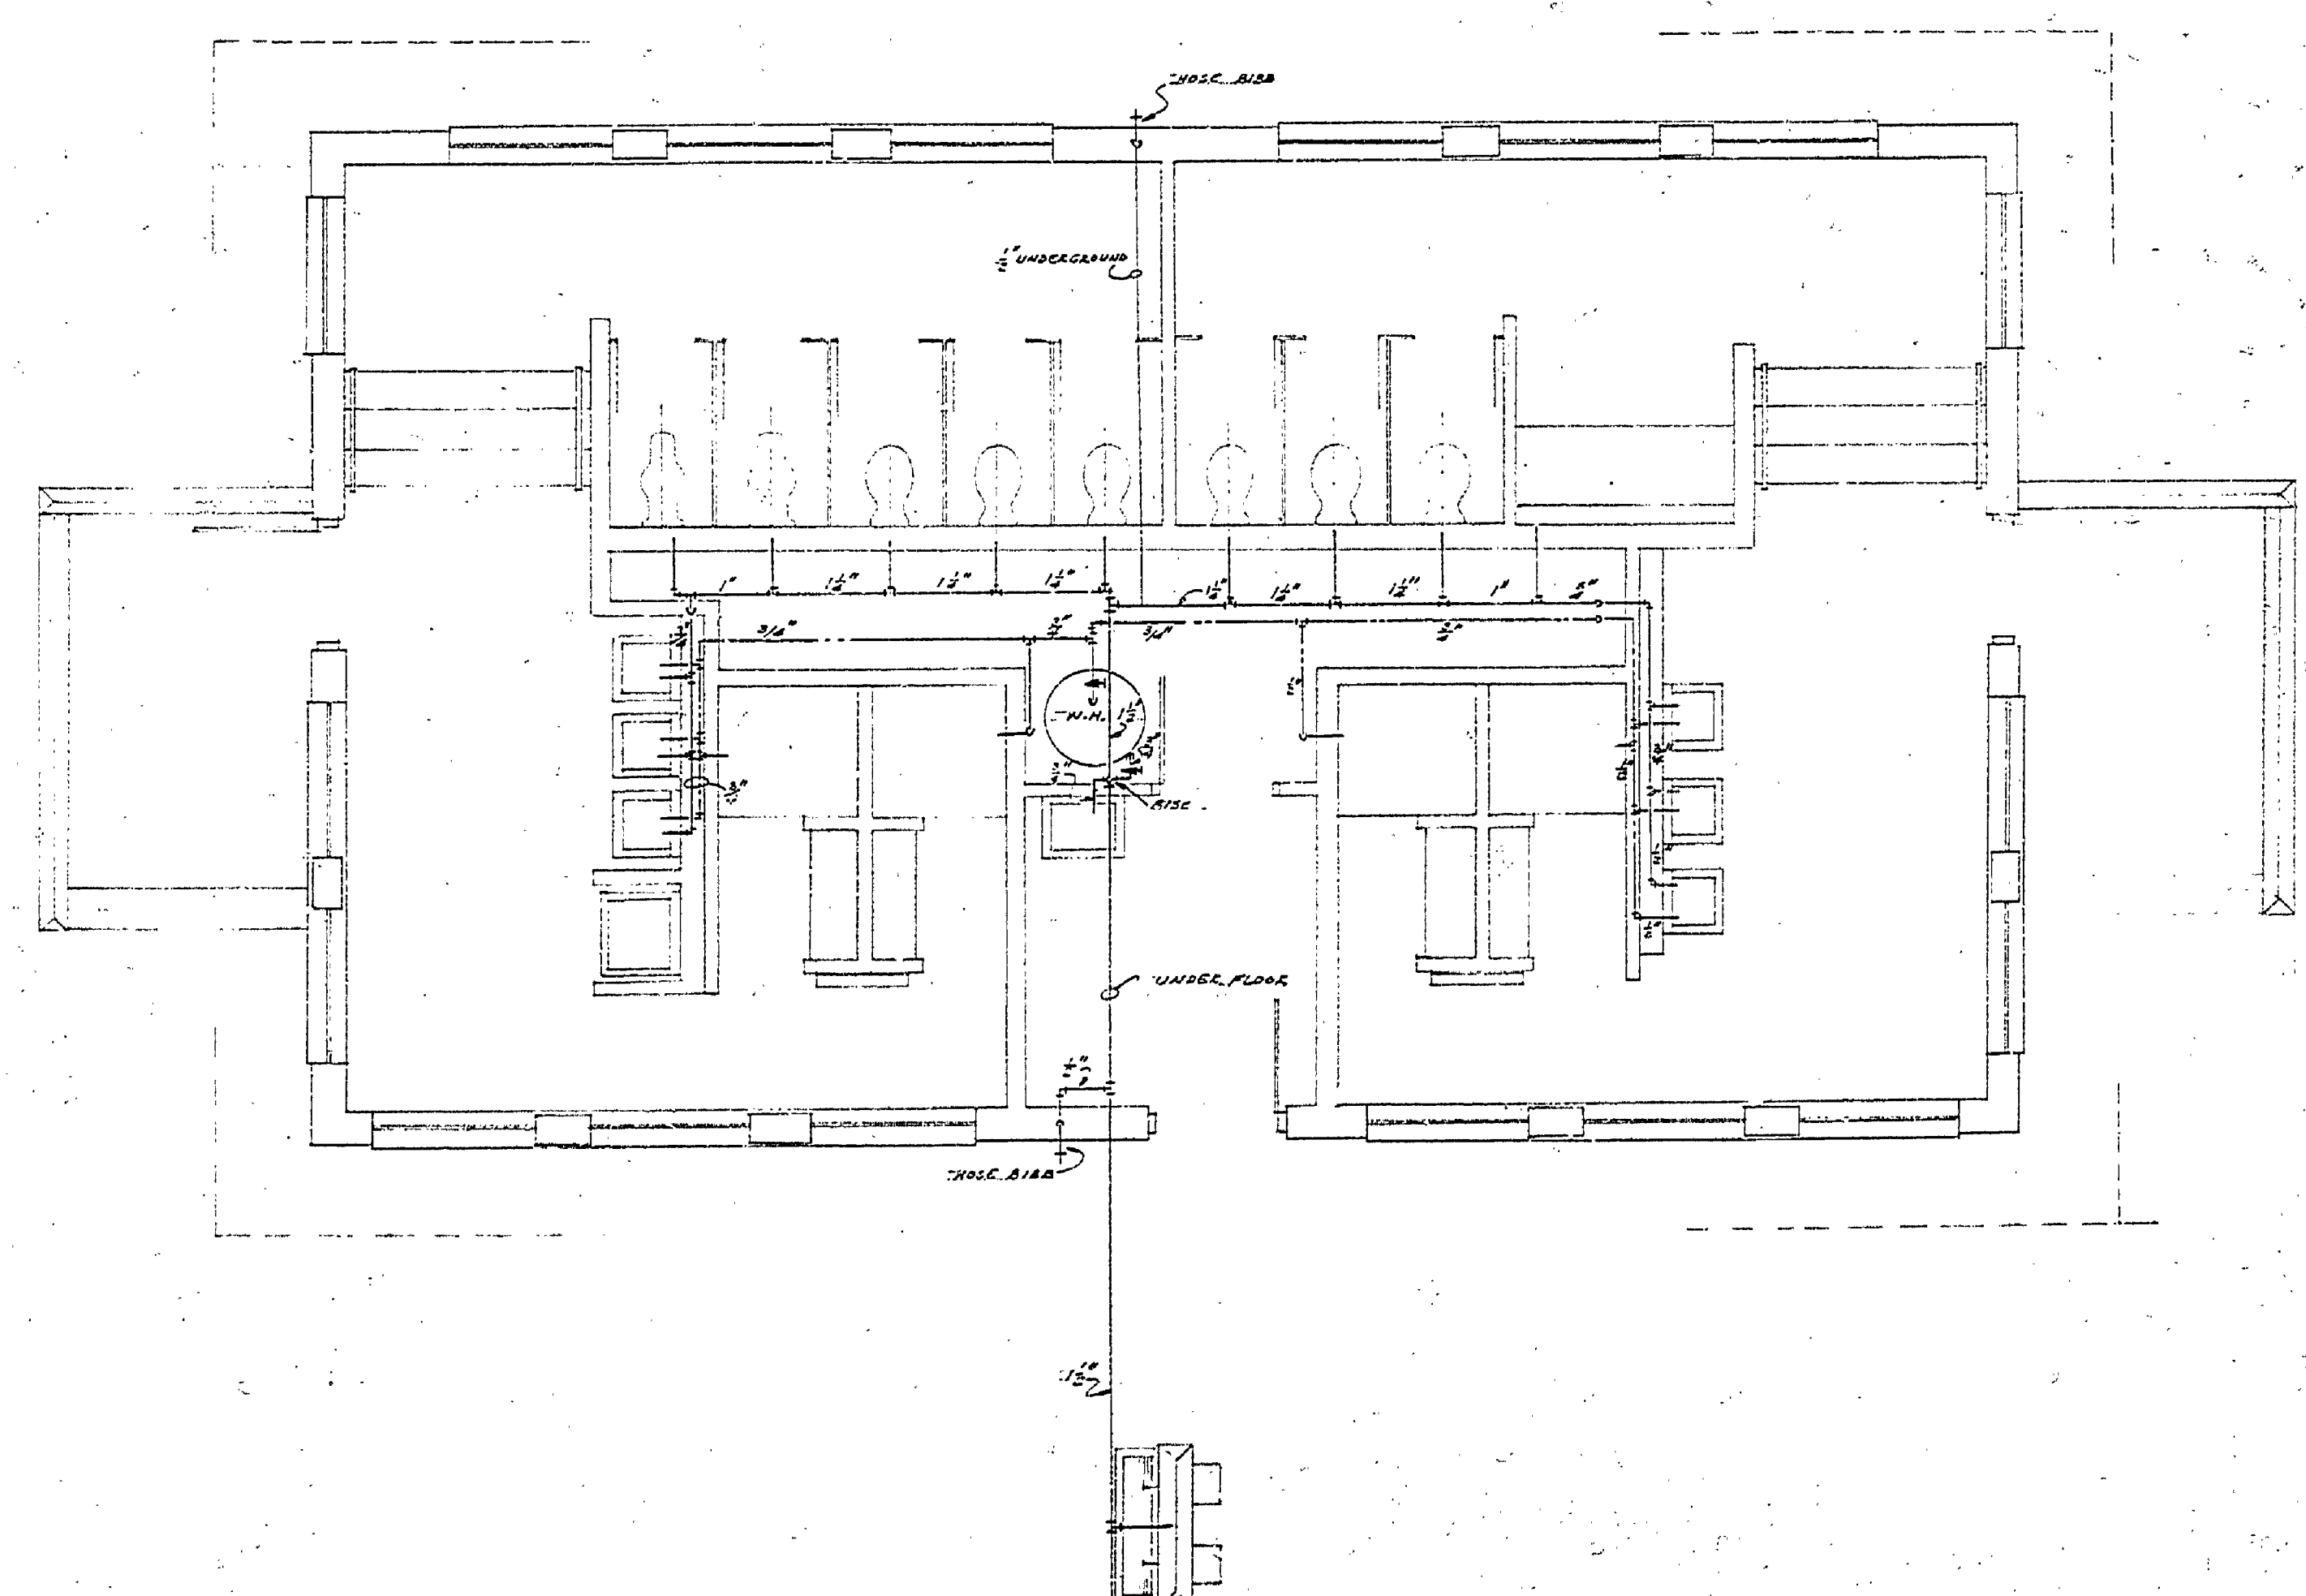

PLUMBING PLAN  
SCALE 1/4" = 1'-0"