



FINISHED FLOOR ELEV. = 100'-0" ASSUMED ELEVATION

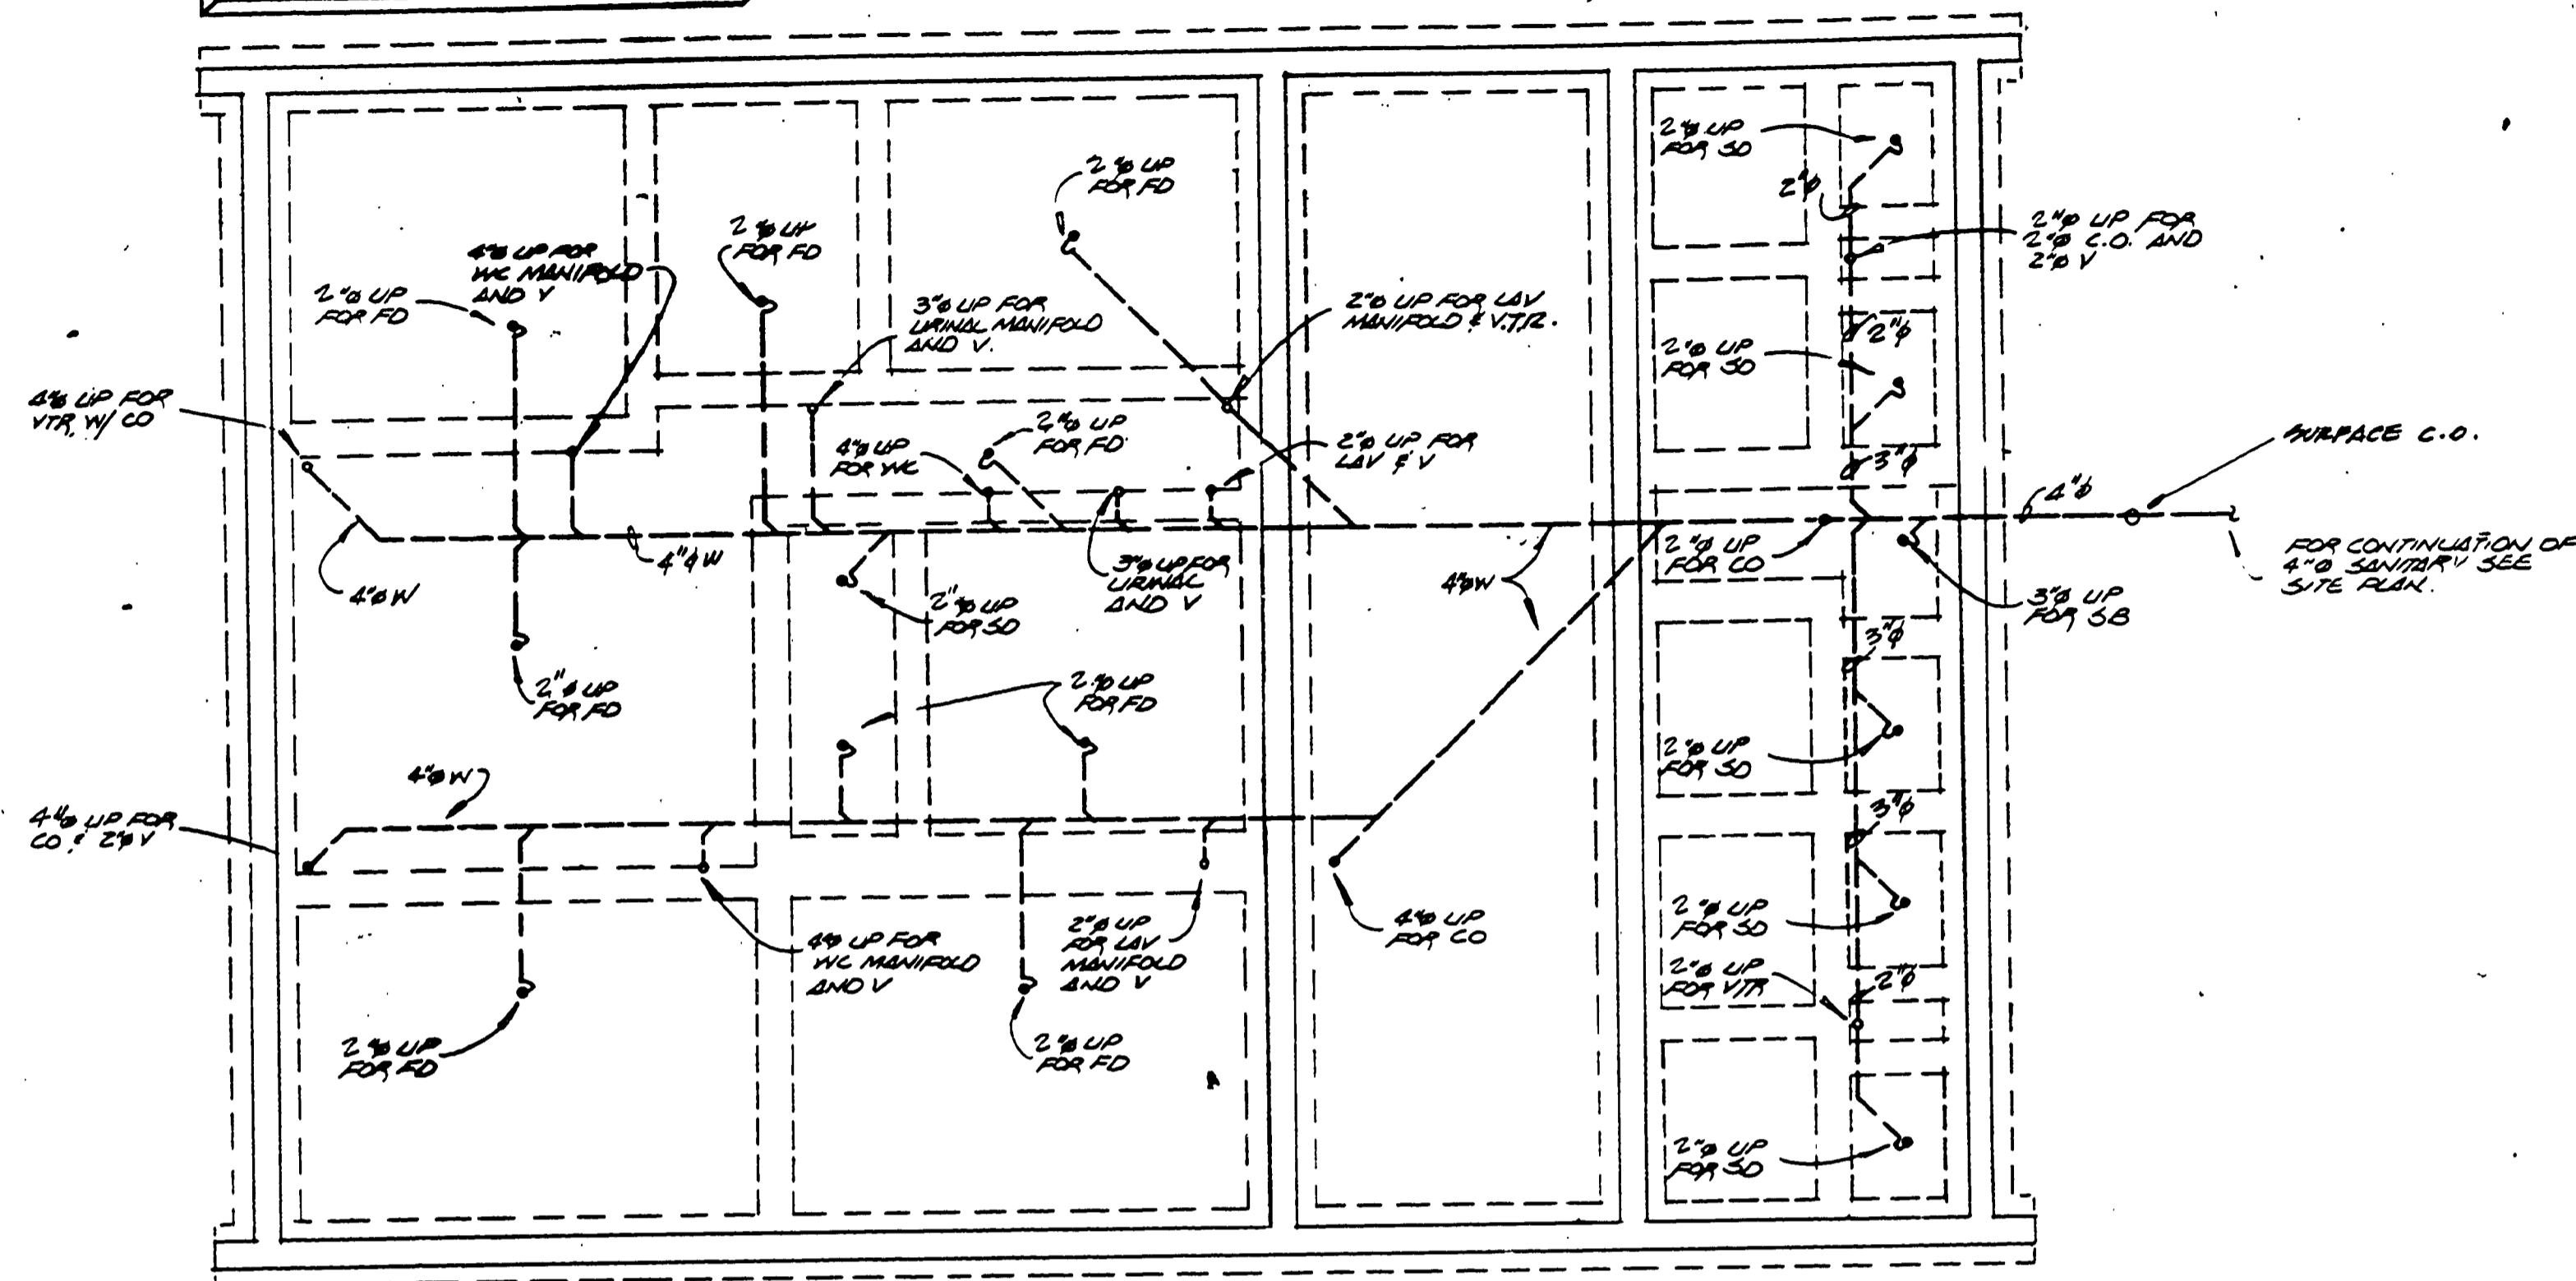

BELOW SLAB WASTE PLUMBING PLAN
SCALE 1/8" = 1'-0"

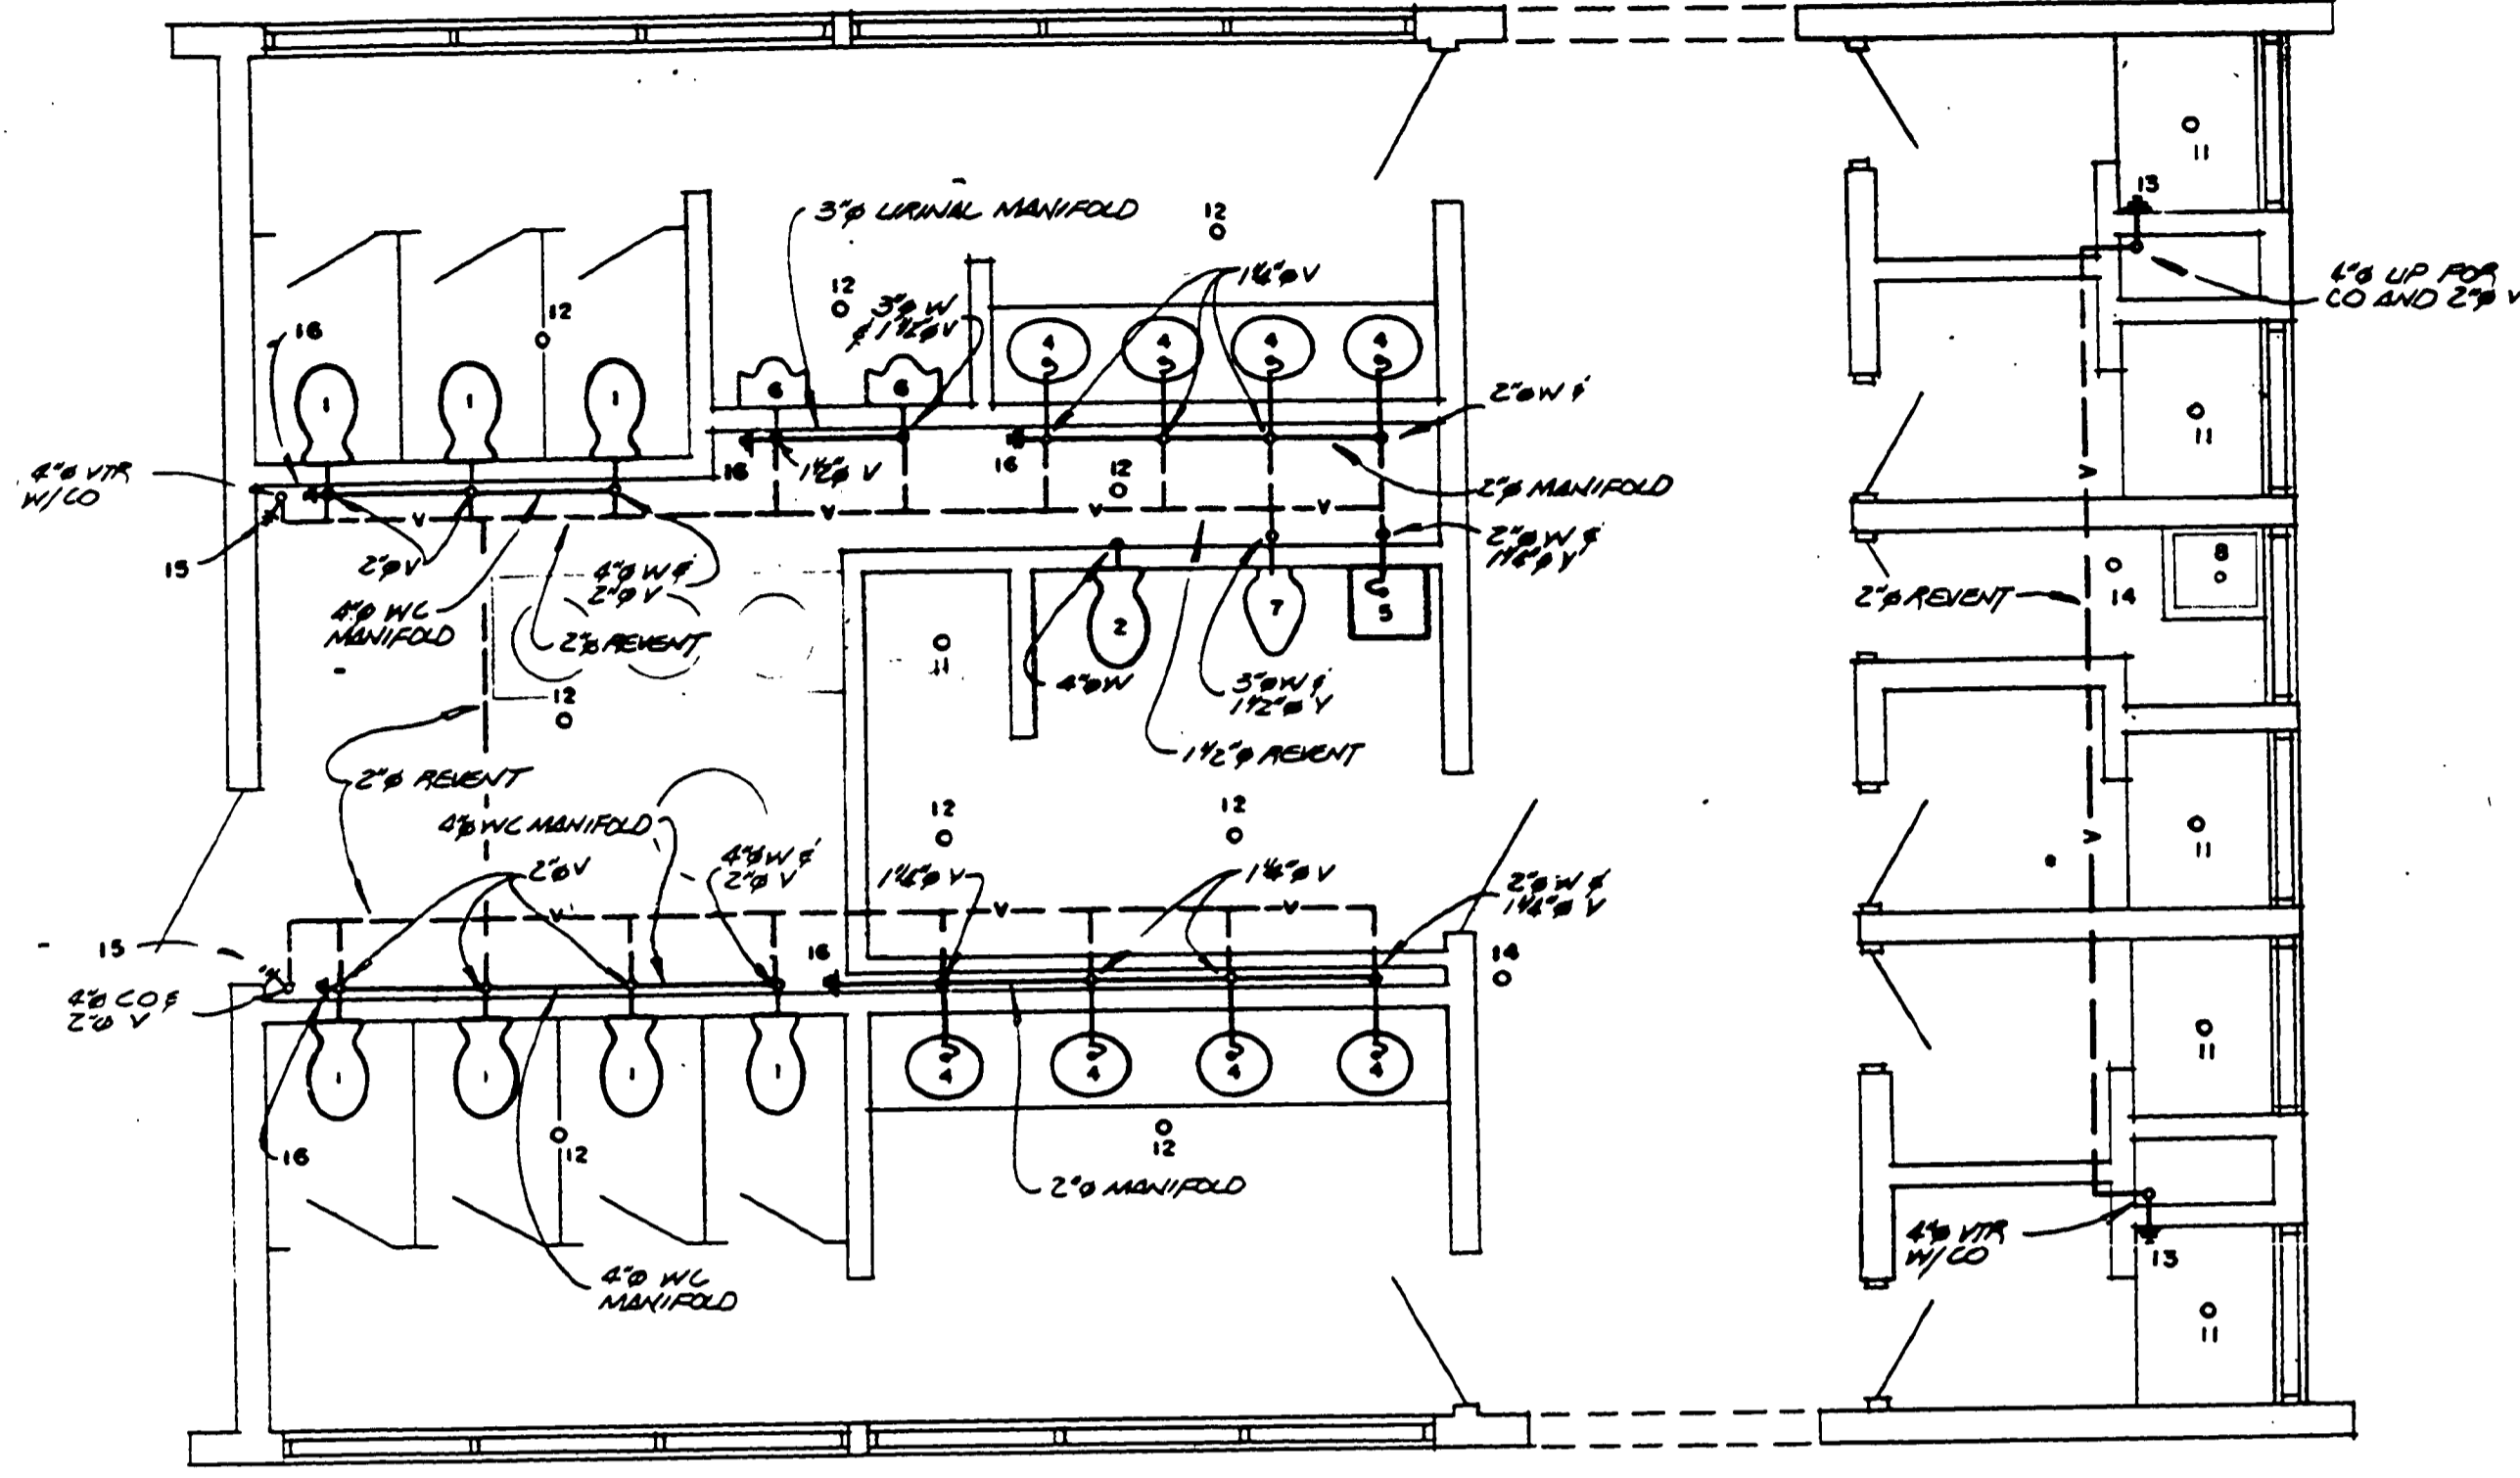

ABOVE SLAB WASTE PLUMBING PLAN
SCALE 1/8" = 1'-0"

NOTE: ALL VENTS TO BE ABOVE CEILING OR 7'-0" AFF MIN. IN EXPOSED AREAS.

PLUMBING SCHEDULE				
FIXTURE	NO.	WASTE	CW	HW
WATER CLOSET	1	4"	1"	—
WATER CLOSET	2	4"	1"	—
SHOWER CONTROL VALVES & HEAD	3	—	1/2"	1/2"
LAVATORY	4	1 1/2"	1/2"	1/2"
LAVATORY (BARRIER FREE)	5	1 1/2"	1/2"	1/2"
URINAL	6	3"	3/4"	—
URINAL (BARRIER FREE)	7	3"	1"	—
SERVICE BASIN	8	3"	1 1/2"	1 1/2"
WALL HYDRANT	9	—	3/4"	—
HOSE BIBB	10	—	1/2"	—
SHOWER DRAIN	11	2"	—	—
FLOOR DRAIN	12	2"	—	—
CONCEALED STACK CLEAN OUT	13	2"	—	—
FLOOR CLEAN OUT	14	4"	—	—
EXPOSED STACK CLEANOUT	15	4"	—	—
MANIFOLD CLEANOUT	16	*	—	—

* SAME SIZE AS MANIFOLD

PLUMBING SYMBOLS & ABBREVIATIONS	
	GATE VALVE
	UNION
	CHECK VALVE
	THERMOMETER
	CAPPED STANDPIPE
	STRAINER W/VALVE
	TRAP
	STACK CLEANOUT
	VENT LINE
	MIXING VALVE
	TEMPERATURE AND PRESSURE RELIEF VALVE
	COLD WATER LINE
	HOT WATER LINE
CO	CLEANOUT
CW	COLD WATER
DF	DRINKING FOUNTAIN
FD	FLOOR DRAIN
HW	HOT WATER
LAV	LAVATORY
SD	SHOWER DRAIN
V	VENT
VTR	VENT THRU ROOF
W	WASTE
WC	WATER CLOSET
WH	WATER HEATER
SB	SERVICE BASIN