


PLUMBING SCHEDULE				
FIXTURE	NO.	WASTE	CW	H/W
WATER CLOSET	1	4"	1"	—
WATER CLOSET	2	4"	1"	—
SHOWER	3	—	1/2"	1/2"
LAVATORY	4	1/4"	1/2"	1/2"
LAVATORY	5	1/4"	1/2"	1/2"
URINAL	6	3"	3/4"	—
URINAL	7	3"	1"	—
SERVICE BASIN	8	3"	1/2"	1/2"
WALL HYDRANT	9	—	3/4"	—
HOSE BIB	10	—	1/2"	—
SHOWER DRAIN	11	4"	—	—
FLOOR DRAIN	12	4"	—	—
CONDENSED STACK CLEANOUT	13	4"	—	—
FLOOR CLEANOUT	14	4"	—	—
EXPOSED STACK CLEANOUT	15	4"	—	—
MANIFOLD CLEANOUT	16	*	—	—

* SAME SIZE AS MANIFOLD
 NOTE: FOR MOUNTING HT'S SEE ELEVATIONS, SMT. NO'S 3 & 4
 THIS SCHEDULE (N.I.C.)

SEE SHEET P-1 FOR PLUMBING SCHEDULE USED WITH THIS PROJECT

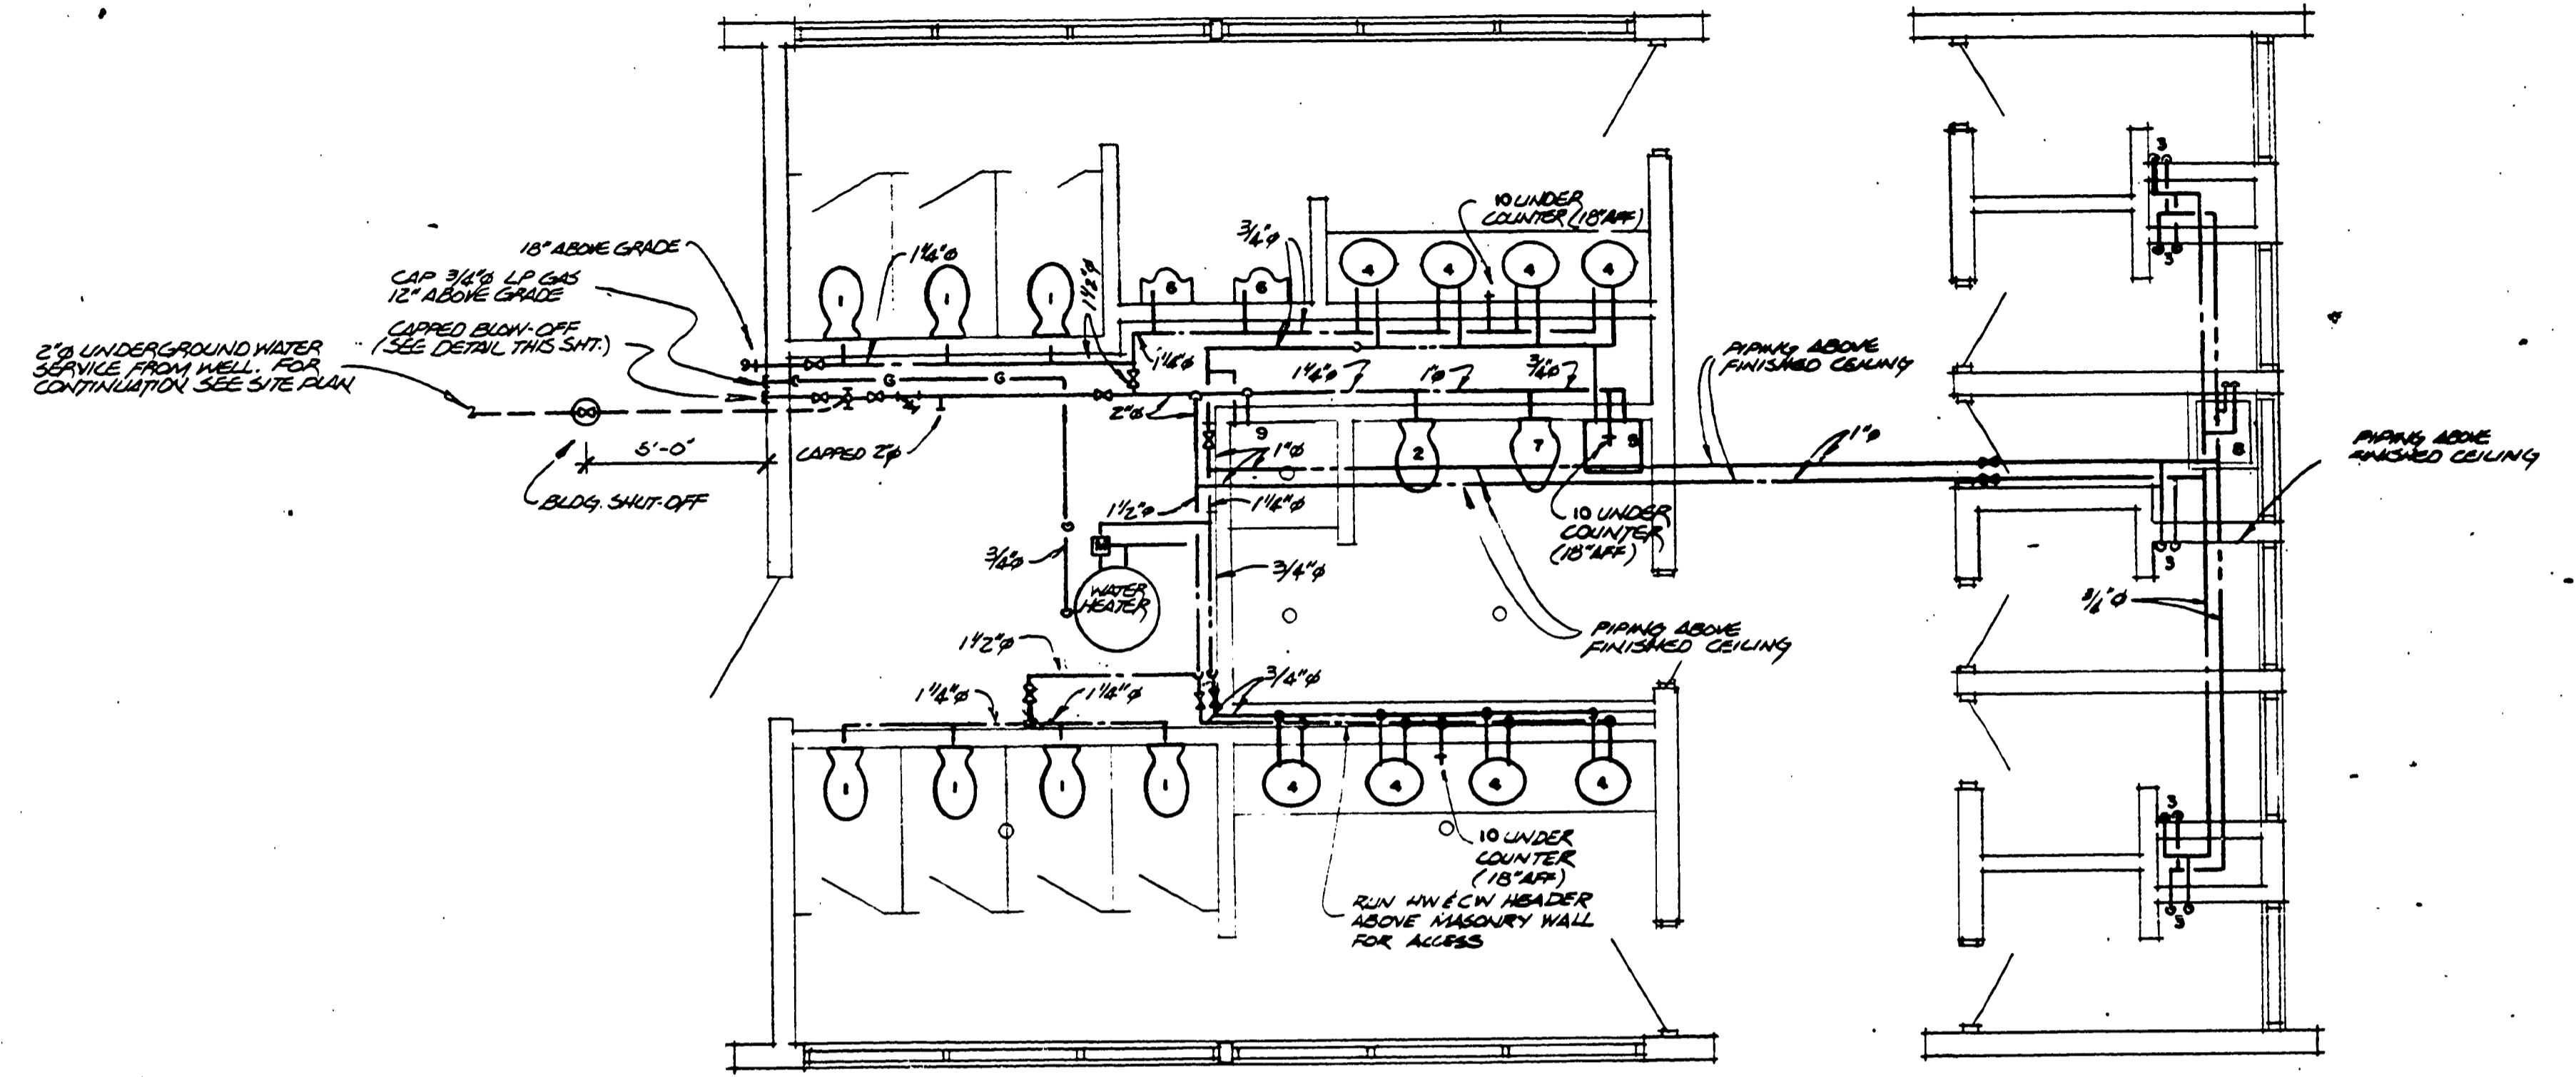

DOMESTIC WATER SUPPLY SYSTEM PIPING SCALE 1/4" = 1'-0"

