

TOILET AND SHELTER BUILDING BAY CITY STATE PARK



STATE OF MICHIGAN
DEPARTMENT OF NATURAL RESOURCES
PARKS DIVISION



PROTECTING MICHIGAN'S FUTURE BOND PROGRAM
ACCT. NO. 607-75-2450-400


SHEET INDEX

- A-1 TITLE SHEET & LOCATION MAPS
- S-1 EXISTING SITE SURVEY
- S-2 SITE DIMENSIONING & UTILITIES PLAN
- S-3 SITE GRADING
- A-2 FOUNDATION PLAN & DETAILS
- A-3 FLOOR PLAN & SCHEDULES
- A-4 EXTERIOR ELEVATIONS
- A-5 BUILDING SECTIONS & INTERIOR ELEVATIONS
- A-6 WALL SECTIONS
- A-7 ROOF FRAMING PLAN
- P-1 SUPPLY PLUMBING PLAN
- P-2 WASTE PLUMBING PLAN
- M-1 MECHANICAL PLAN
- E-1 ELECTRICAL PLAN

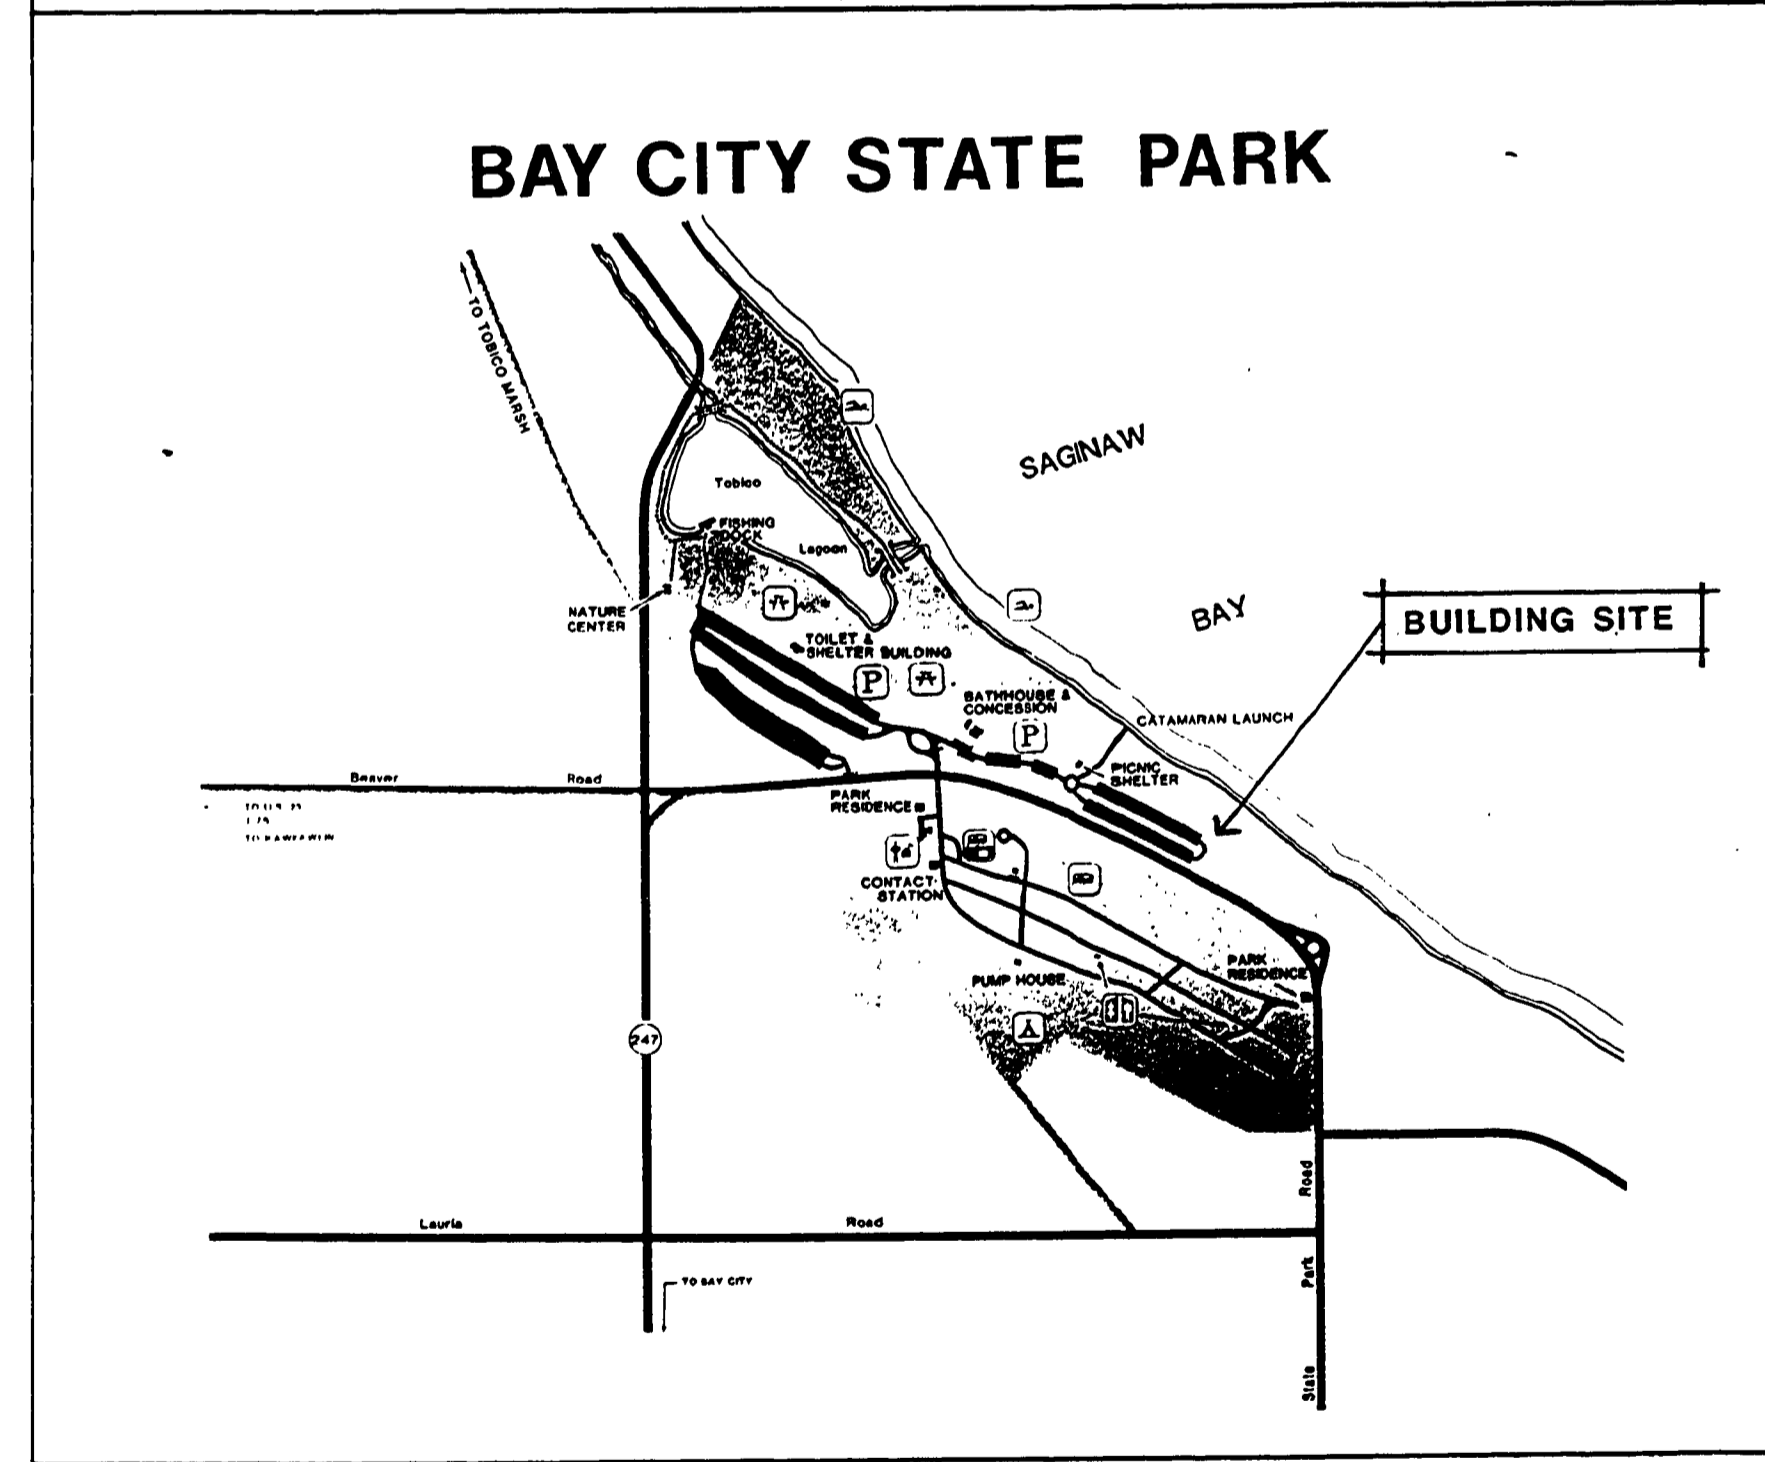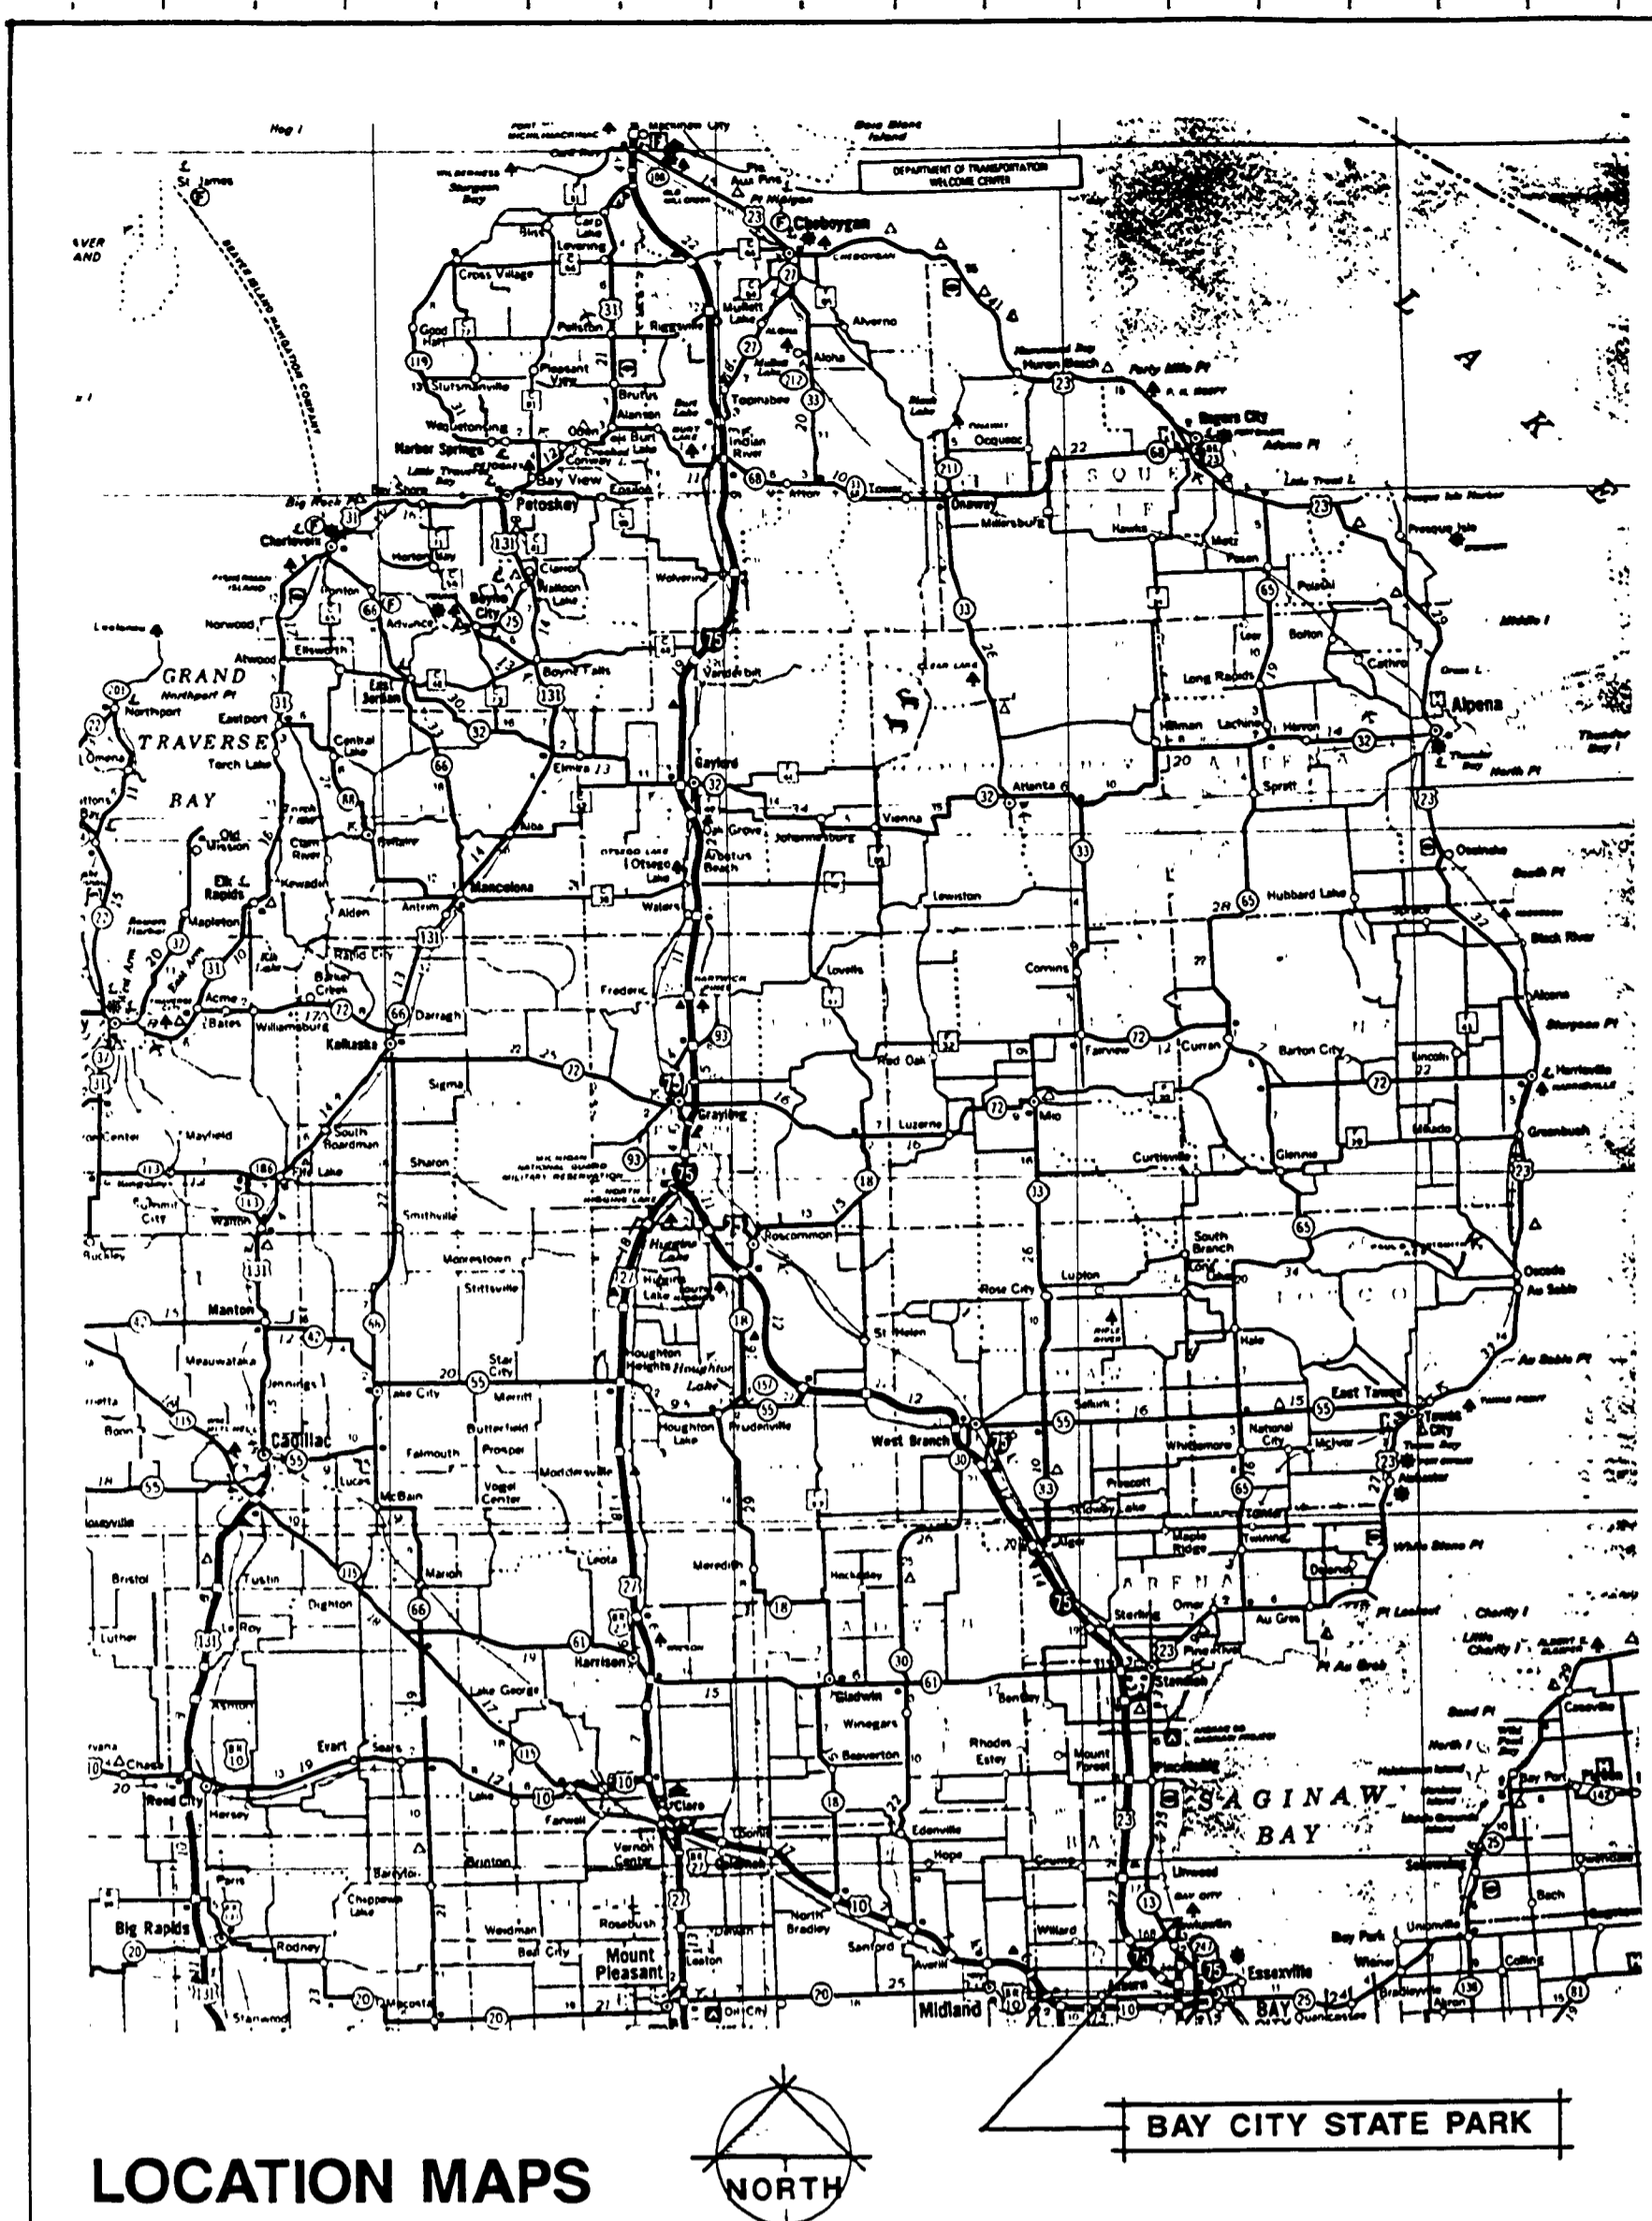

APPROVED
Kenneth J. Gurburg 8.8.90
CHIEF, Parks Division Date

Bernath-Coakley Associates, Architects
4104 W. St. Joseph Hwy.
Lansing, Michigan 48917
(517) 321-9525

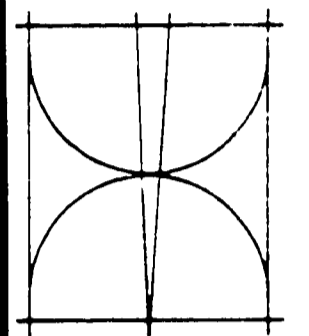

STATE OF MICHIGAN
DEPARTMENT OF MANAGEMENT AND BUDGET
Office of Facilities

TOILET AND SHELTER BUILDING
BAY CITY STATE PARK
STATE OF MICHIGAN
DEPARTMENT OF NATURAL RESOURCES
PARKS DIVISION
PROTECTING MICHIGAN'S FUTURE BOND PROGRAM ACCT. NO. 607-75-2450-400

Revisions
Date JULY 27, 1990
Comm No 9034
Sheet No

A1
L-123