


FOUNDATION PLAN PLUMBING

SCALE = 1/8" = 1'-0"

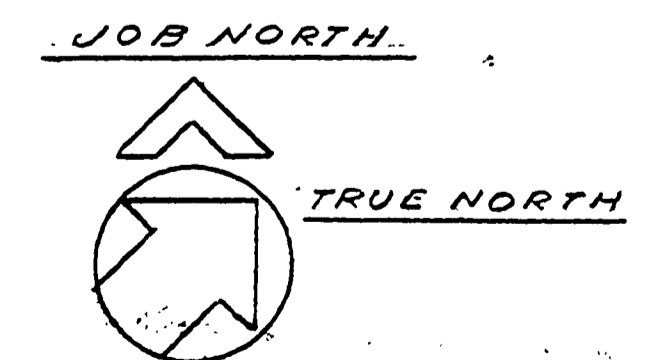

SURVEYED BY	DRAWN BY: <i>J. FORTON</i>	NO.	DATE	BY	REVISIONS	NO.	DATE	BY	REVISIONS	MICHIGAN DEPARTMENT OF NATURAL RESOURCES	FOUNDATION PLAN PLUMBING	BALD MOUNTAIN RECREATION AREA AREA OR PARK	PROJECT NO. 22-4100
DESIGNED BY	CHECKED BY: <i>J. FORTON</i>	1.				3.				DEPARTMENT OF NATURAL RESOURCES	FOUNDATION PLAN PLUMBING	SHOOTING RANGE FACILITY PROJECT	SHEET 10 OF 16 PLAN NO. E114
DATE	DATE: 12-16-76	2.				4.					SHEET TITLE		

S.F. SONK ASSOCIATES, INC.
Consulting Engineers
43450 Grand River - Novi, Mich.