

REVISED ELECTRICAL DISTRIBUTION WIRING SIZES:


RANGE BLDG	2 #4 + GFD
SHEET ①	2 #3 + GFD
SHEET ②	2 #4 + GFD
SHEET ③	2 #3 + GFD
TRAP ①	2 #4 + GFD
TRAP ②	2 #3 + GFD
TRAP ③	2 #2 + GFD

NOTE:

- ELEC. CONTS. TO PROVIDE ENOUGH EXTRA WIRE TO MAKE NECESSARY CONNECTIONS IN FUTURE CORE BLDG.
- PROVIDE CONDUIT UNDER ALL WALKS AND DRIVES.
- SEE DRAWING NOS 17 & 18 FOR OTHER PORTIONS OF ELEC. CONTRACT.

LEGEND

- EXISTING CONTOUR
- (xxxx) EXISTING SPRT ELEVATION
- PROPOSED CONTOUR
- xxxx PROPOSED SPRT ELEVATION
- EXISTING TREES AND BRUSH
- EXISTING TREES AND BRUSH - REMOVE
- COLLECT CORRUGATED STEEL PIPE
- WATER EDGE
- 6" CONC. WALL
- LIMIT OF GRADING
- DETAIL NUMBER
- LOCATION SHEET
- LOCATION PLAN SHEET
- EXPANSION JOINTS
- MONUMENTS
- V.C. STAKES

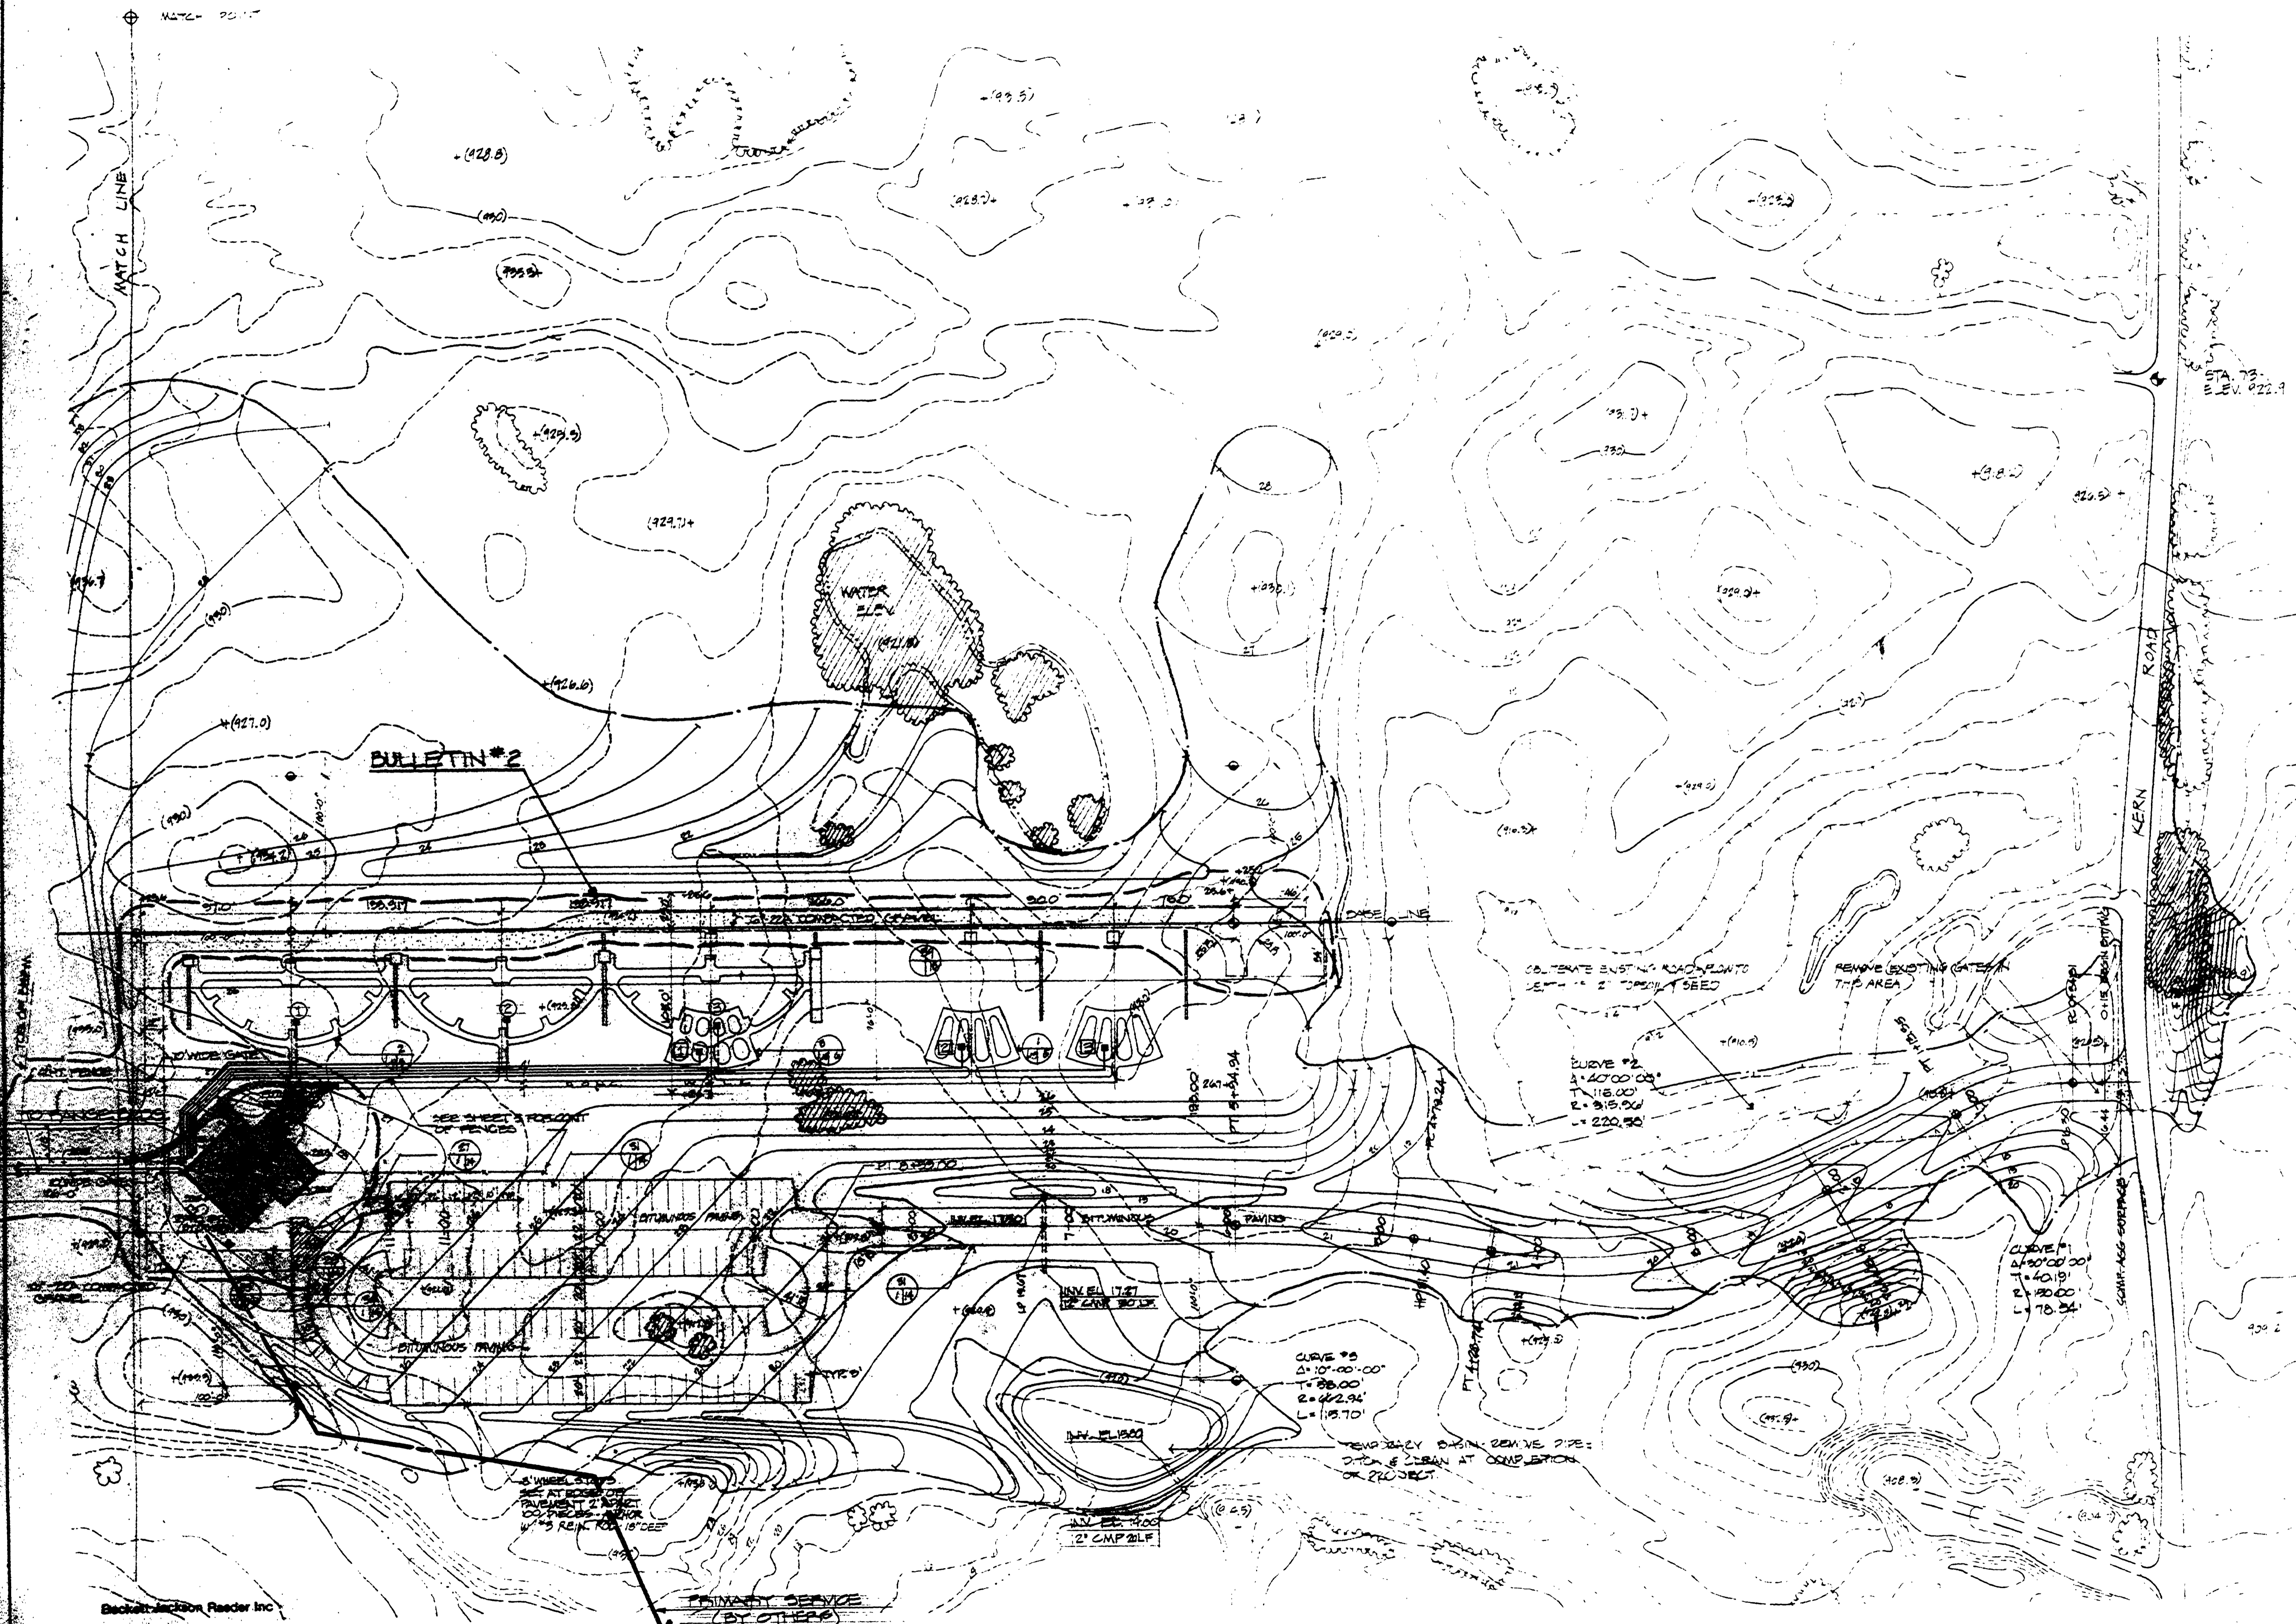

Beckett-Jackson Reader Inc.
230 Huronview Boulevard
Ann Arbor, Michigan 48103
MATCH POINT

REVISED ELECTRICAL DISTRIBUTION - 10.20.76

SURVEYED BY:	DRAWN BY:	NO. DATE BY REVISIONS	NO. DATE BY REVISIONS	MICHIGAN DEPARTMENT OF NATURAL RESOURCES	SITE GRADING PLAN A	Bald Mountain Recreation Area AREA OR PARK	PROJECT NO. 22-4073
CHECKED BY:	CHECKED BY:	1. 9-15-76 GRAVEL ACCESS ROAD - CORE BLDG. PLAN 3.	4.		SHEET TITLE	Shooting Facility	SHEET 1 OF 10 PLAN NO. E-111
DATE:	DATE:						