


BALD MOUNTAIN RECREATION AREA

TROUT LAKE UNIT PICNIC TOILET

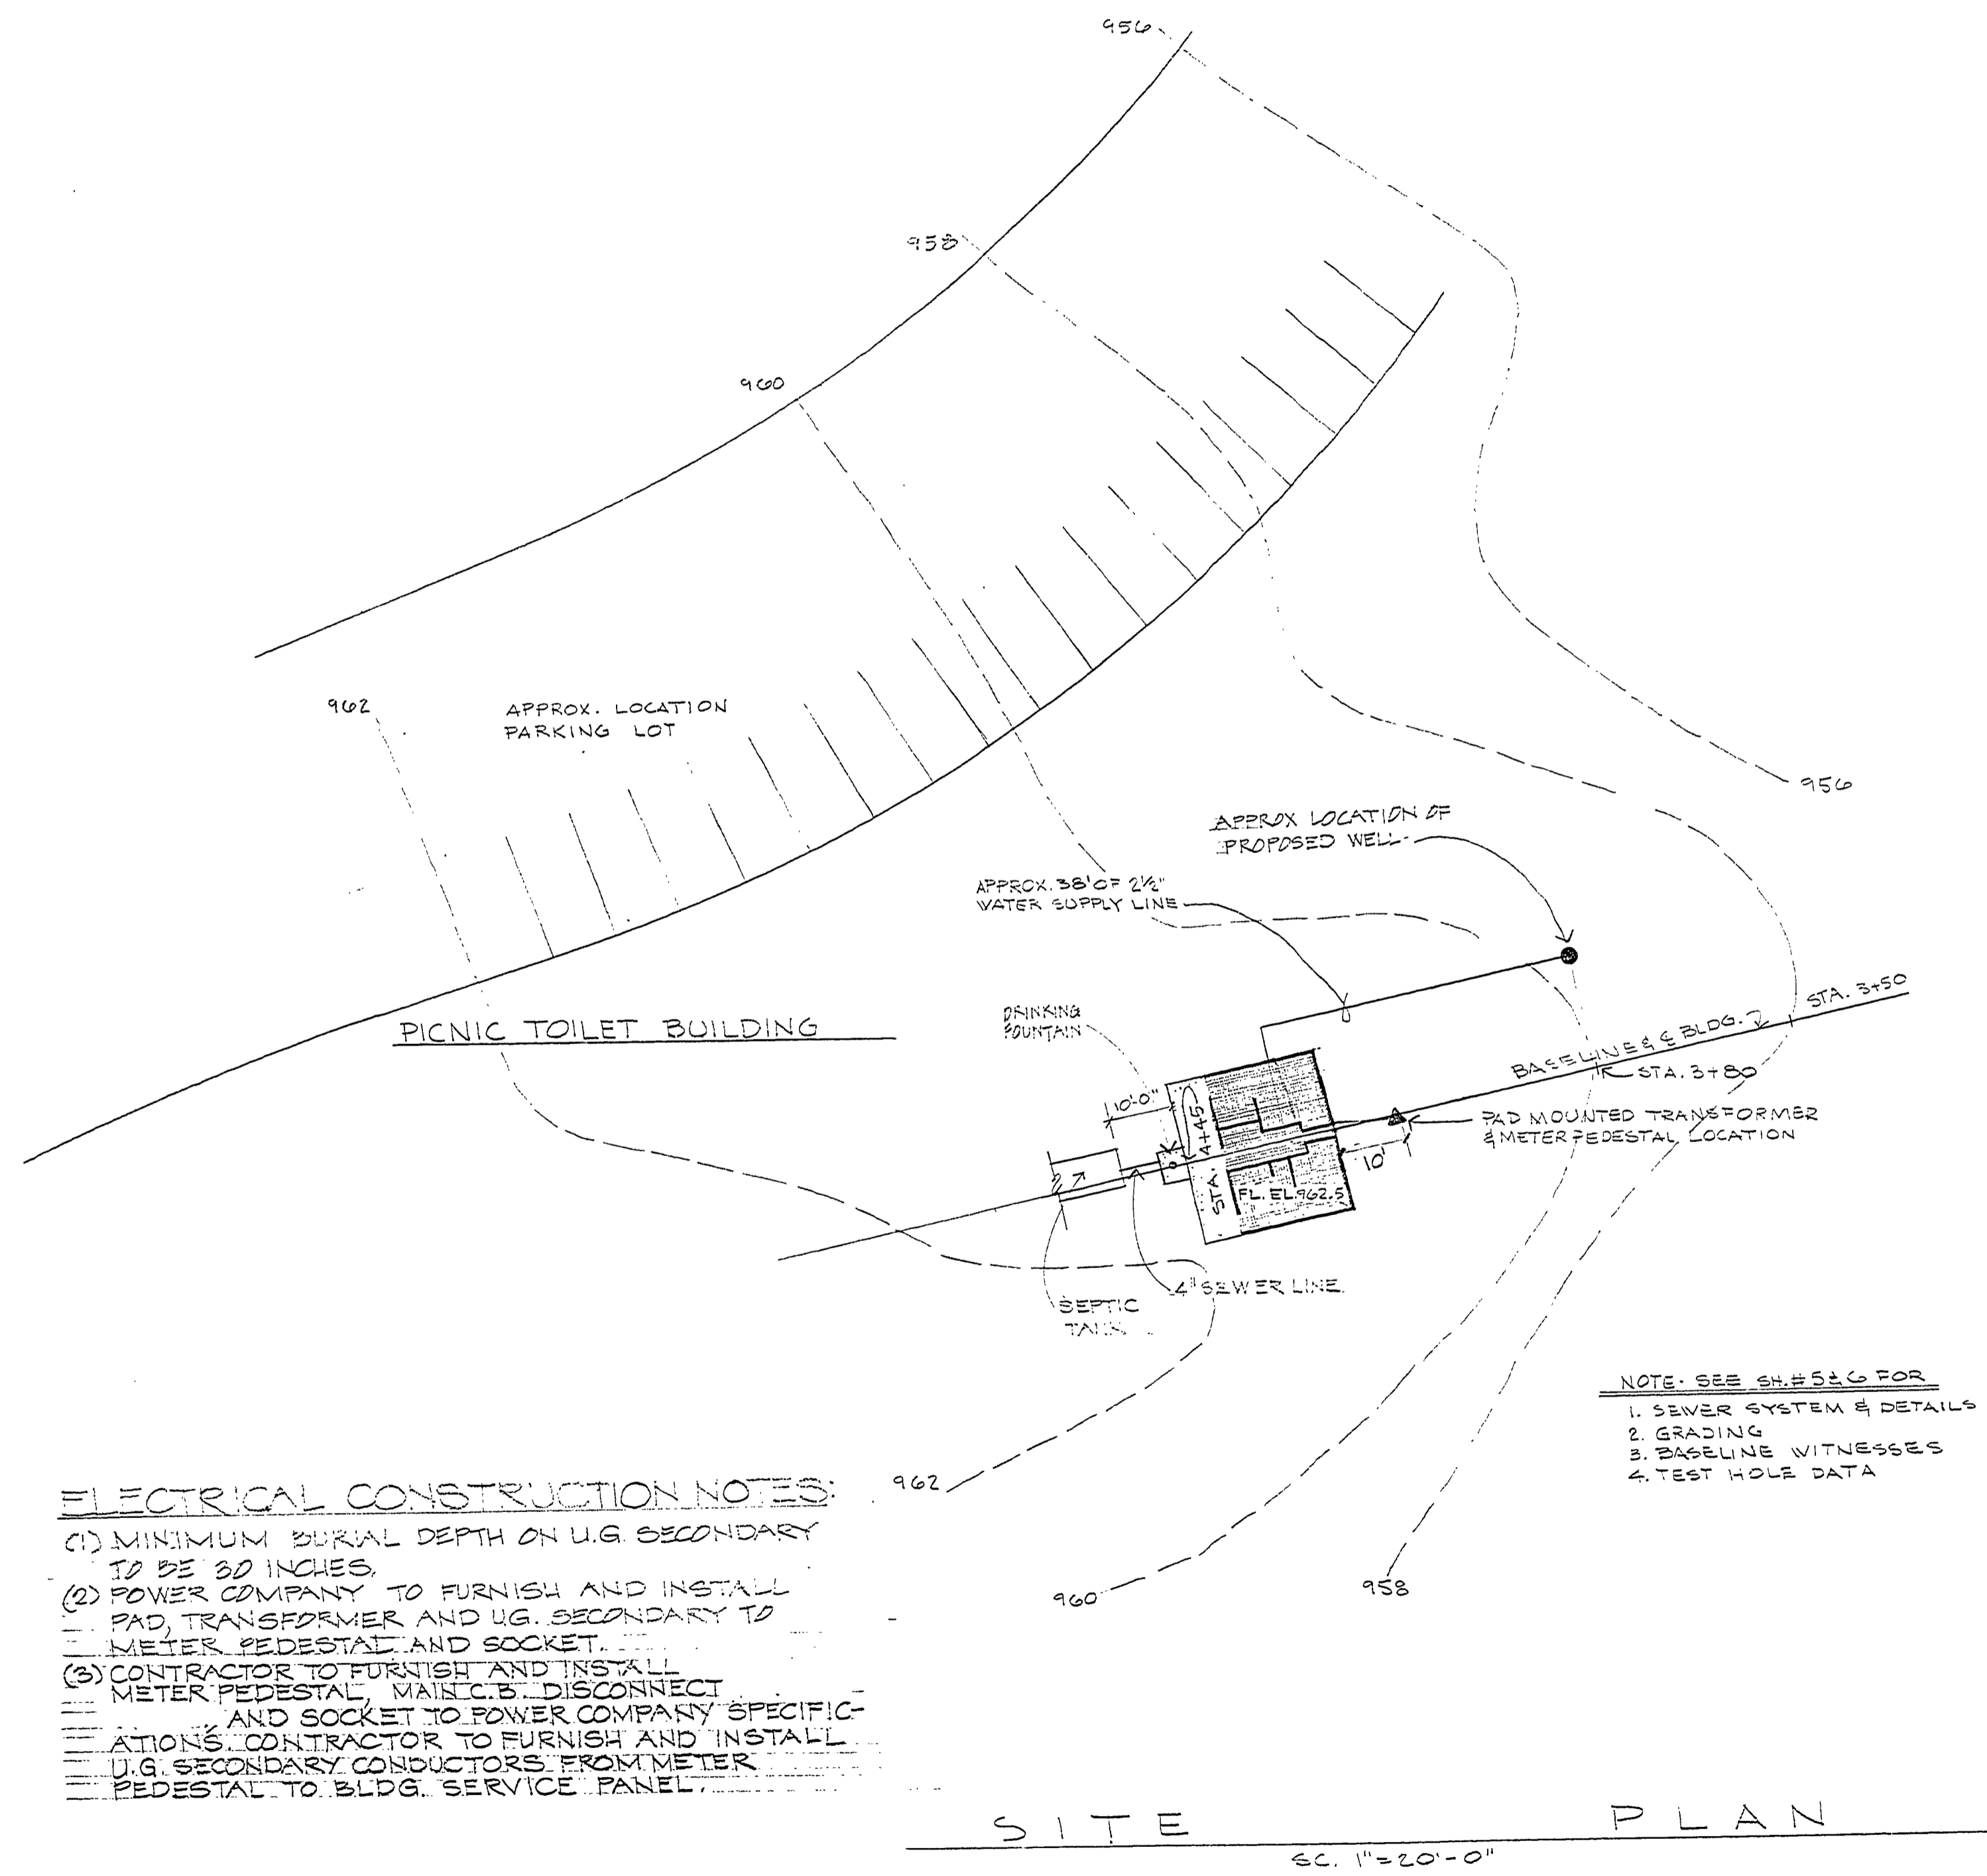

ELECTRICAL CONSTRUCTION NOTES:

- (1) MINIMUM BURIAL DEPTH ON U.G. SECONDARY TO BE 30 INCHES
- (2) POWER COMPANY TO FURNISH AND INSTALL PAD, TRANSFORMER AND U.G. SECONDARY TO METER PEDESTAL AND SOCKET.
- (3) CONTRACTOR TO FURNISH AND INSTALL METER PEDESTAL, MAIN C.B. DISCONNECT AND SOCKET TO POWER COMPANY SPECIFICATIONS. CONTRACTOR TO FURNISH AND INSTALL U.G. SECONDARY CONDUCTORS FROM METER PEDESTAL TO BLDG. SERVICE PANEL.


NOTE: SEE SHEET 2 FOR

1. SEWER SYSTEM & DETAILS
2. GRADING
3. BASELINE WITNESSES
4. TEST HOLE DATA


NOTES

--- EXISTING CONTOURS

— NEW CONTOURS

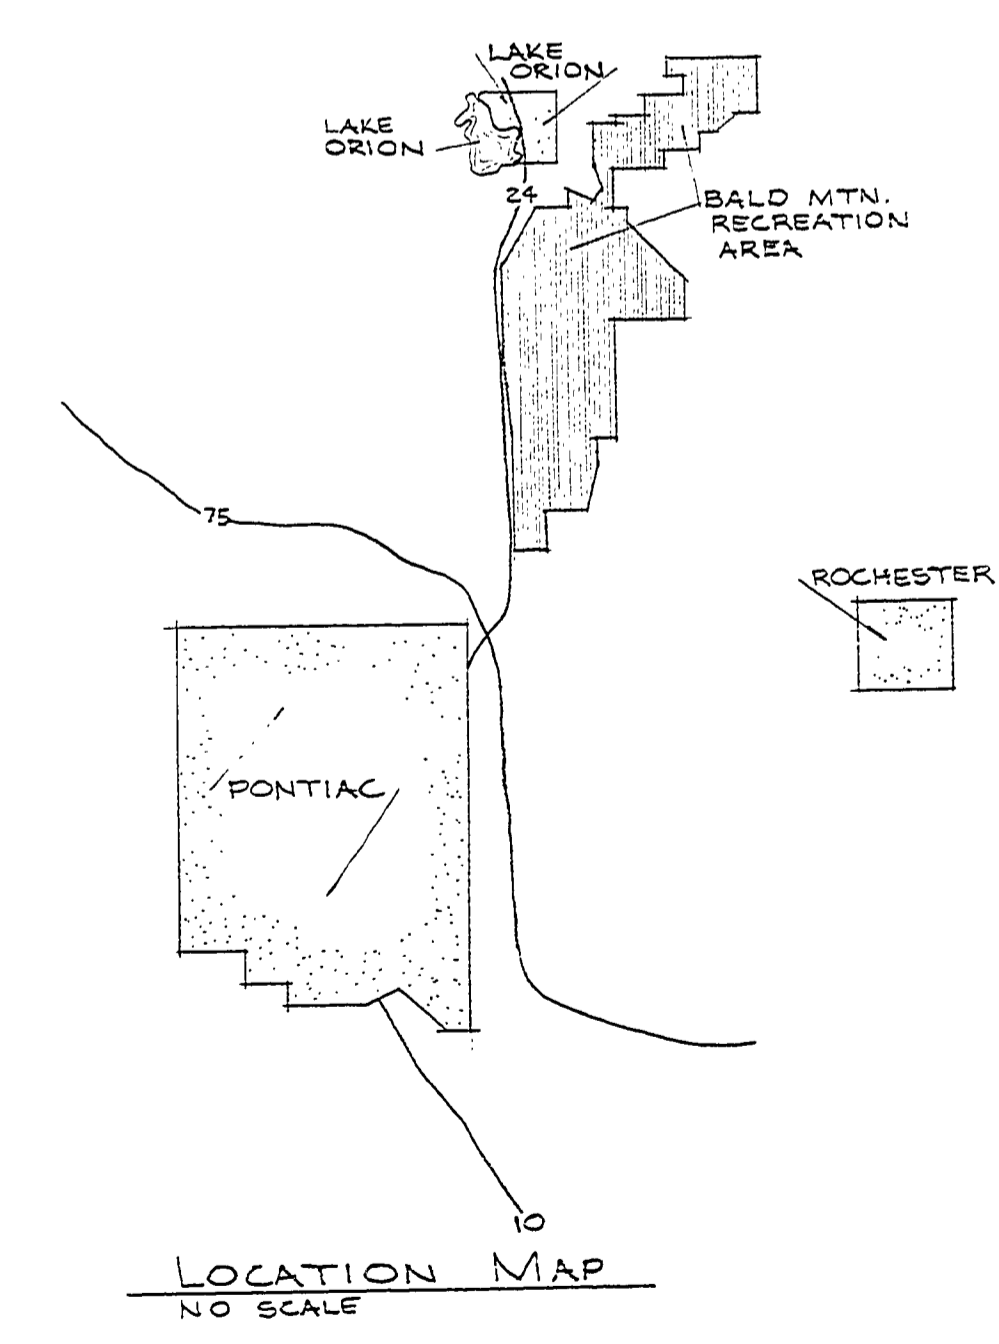

SITE PLAN
SC. 1"=20'-0"

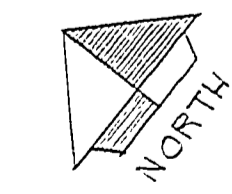

DRAWING INDEX	
SHEET NO.	TITLE
1	TITLE SHEET & SITE PLAN
2	PLANS, ELEVATIONS + SCHEDULES
3	ELEVATIONS + DETAILS
4	PLUMBING, ELECTRICAL PLANS + SCHEDULES
5	SEWAGE SYSTEM, PUMP CONTROLS + PITLESS ADAPTER TANK
6	SEWAGE SYSTEM DETAILS

BUILDING COMMITTEE APPROVAL

BY: _____ CHAIRMAN DATE: _____

RECOMMENDED FOR APPROVAL: *[Signature]* 12/15/77
ENGINEERING OR ARCHITECTURAL SUPERVISOR DATE

RECOMMENDED FOR APPROVAL: _____ PROGRAM AND PLAN COORDINATOR DATE

DIVISION/REGION APPROVAL

BY: *Jack R. [Signature]* 12-15-77
DIVISION CHIEF/REGIONAL MANAGER DATE

ENGINEERING DIVISION

APPROVED: *William [Signature]* 12-15-77
CHIEF ENGINEER DATE

SURVEYED BY	DRAWN BY G. TOMPKINS	NO.	DATE	BY	REVISIONS	NO.	DATE	BY	REVISIONS
		1.				3.			
DESIGNED BY	CHECKED BY	2.				4.			
			DATE				DATE		

MICHIGAN
DEPARTMENT OF NATURAL RESOURCES

TITLE SHEET & SITE PLAN
SHEET TITLE

BALD MOUNTAIN RECREATION AREA
OR PARK
TROUT LAKE UNIT PICNIC TOILET
PROJECT

PROJECT NO. 24-1661

SHEET 1 OF 6 PLAN NO. A-102