


WASTE PLUMBING PLAN
SCALE 1/4" = 1'-0"

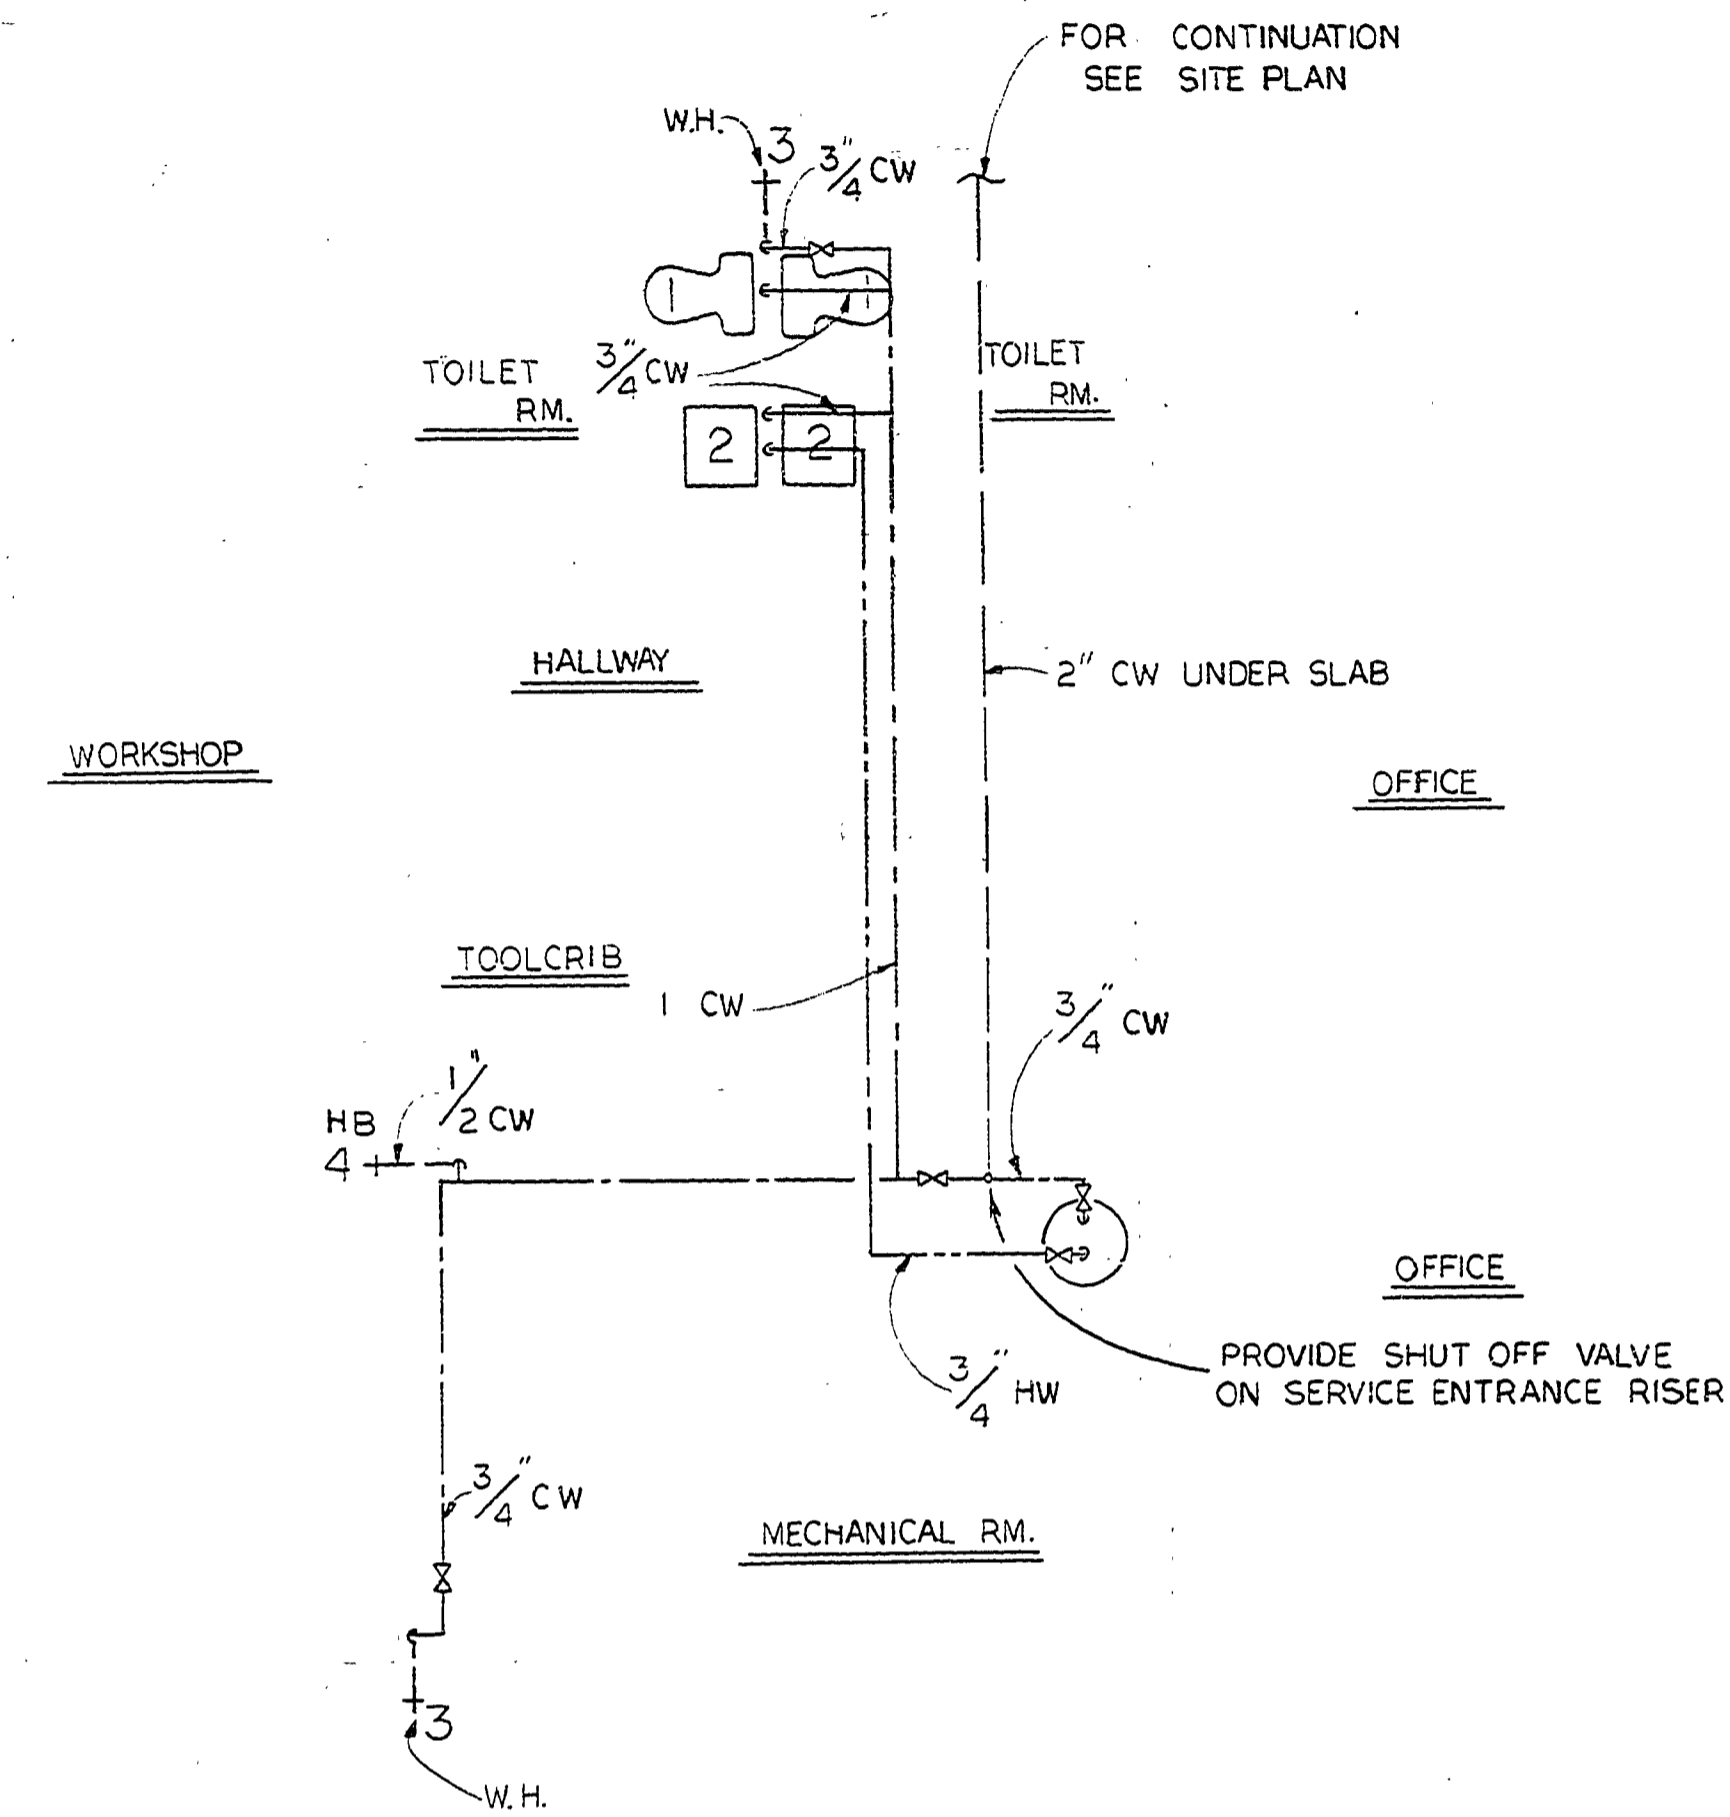

WATER SUPPLY PLAN
SCALE 1/4" = 1'-0"

PLUMBING LEGEND

- STORM SANITARY BELOW GRADE
- - - VENT
- CW COLD WATER
- HW HOT WATER
- WH WATER HYDRANT
- HB HOSE BIBB
- ⊗ GATE VALVE
- || UNION
- ⊗ GAS COCK
- ⊕ PRESSURE TEMP. RELEASE VALVE
- CI CAST IRON
- VC VITREOUS CROCK
- CO CLEAN OUT

PLUMBING FIXTURE SCHEDULE

| FIXTURE | FIXTURE NO. | WASTE | CW | HW |
|---------------|-------------|-------|-----|-----|
| Water Closet | 1 | 4 | 1/4 | — |
| Lavatory | 2 | 1 | 1/2 | 1/2 |
| Water Hydrant | 3 | — | 3/4 | — |
| Hose Bibb | 4 | — | 1/2 | — |
| Floor Drain | — | 4 | — | — |

| | | | | | | | | | | | | | | |
|-----------------------|------------------|-------|-------|------|----|-----------|-------|------|----|-----------|--|------------------------------|-------------------------------|-----------------------------|
| SURVEYED BY | DRAWN BY K STAHL | 10-78 | NO. 1 | DATE | BY | REVISIONS | NO. 3 | DATE | BY | REVISIONS | MICHIGAN DEPARTMENT OF NATURAL RESOURCES | SUPPLY & WASTE PLUMBING PLAN | AREA BALD MOUNTAIN RES. AREA | PROJECT NO. 24-2024 |
| DESIGNED BY J. BARKER | CHECKED | 10-78 | NO. 2 | DATE | BY | REVISIONS | NO. 4 | DATE | BY | REVISIONS | DEPARTMENT OF NATURAL RESOURCES | SHEET TITLE | PROJECT GARAGE, OFFICE & SHOP | SHEET 5 OF 7 PLAN NO. 1-104 |