
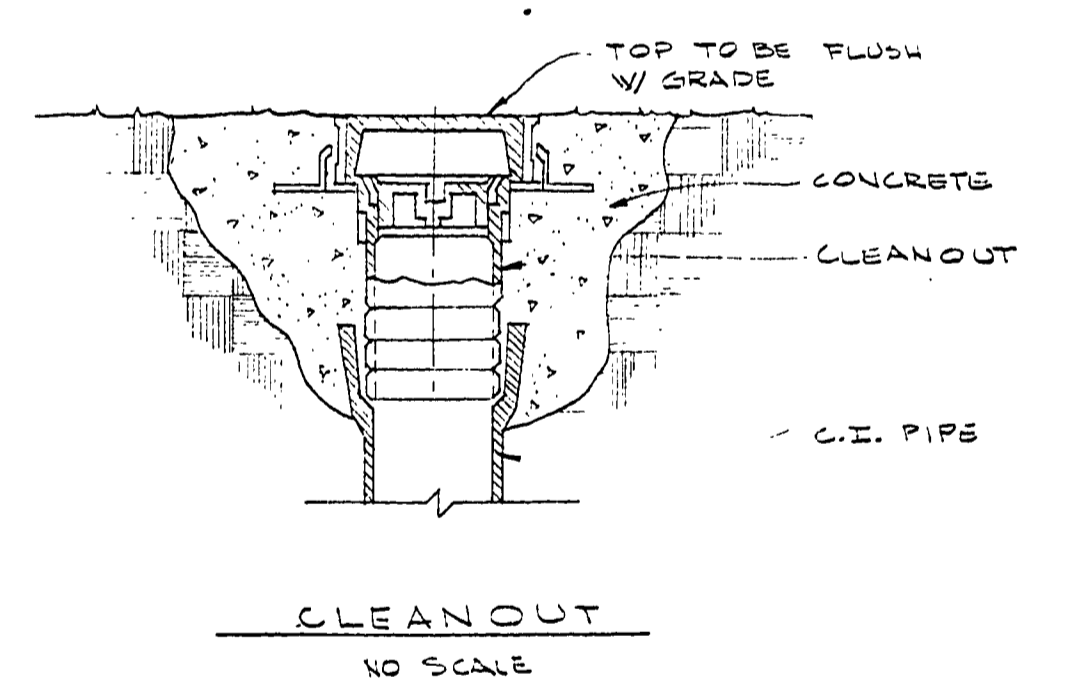
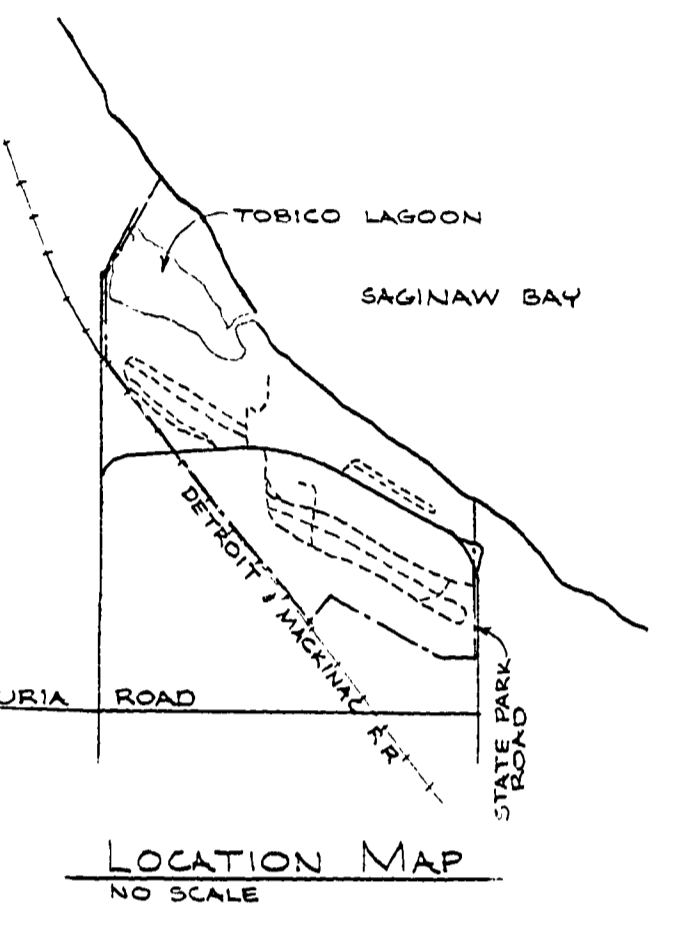


# BAY CITY STATE PARK

## FOUR BUILDINGS

DRAWING SCHEDULE	
SH. NO.	DESCRIPTION
1	TITLE SHEET & BEACHHOUSE SITE PLAN
2	TOILET BLDGS - SITE PLANS
<b>BLDG. #1 - DAY USE TOILET BLDG.</b>	
3	FLOOR & FOUNDATION PLANS & SCHEDULES
4	ELEVATIONS & WALL SECTIONS
5	ROOF FRAMING PLAN, SECTIONS & DETAILS
6	ELECTRICAL & WATER SUPPLY PLANS
7	WASTE PLUMBING PLANS
<b>BLDG. #2 - CAMPGROUND TOILET &amp; SHOWER</b>	
8	FLOOR & FOUNDATION PLANS & SCHEDULES
9	ELEVATIONS & DETAILS
10	ROOF FRAMING PLAN, SECTIONS & DETAILS
11	WALL SECTIONS & DETAILS
12	SECTIONS & DETAILS
13	ELECTRICAL & WATER SUPPLY PLANS
14	WASTE PLUMBING PLANS
<b>BLDG. #3 - CAMPGROUND TOILET &amp; SHOWER</b>	
15	FLOOR & FOUNDATION PLANS & SCHEDULES
16	ELEVATIONS & DETAILS
17	ROOF FRAMING PLAN, SECTIONS & DETAILS
18	WALL SECTIONS & DETAILS
19	SECTIONS & DETAILS
20	ELECTRICAL & WATER SUPPLY PLANS
21	WASTE PLUMBING PLANS
<b>BEACHHOUSE</b>	
22	FOUNDATION PLAN
23	FLOOR PLAN & DETAILS
24	ELEVATIONS & SECTIONS
25	BUILDING SECTIONS, INTERIOR & EXTERIOR ELEVATIONS
26	WALL SECTIONS & DETAILS
27	WALL SECTIONS
28	FRAMING PLAN, DETAILS & TRUSS ELEVATIONS
29	FRAMING PLAN & TRUSS ELEVATIONS
30	MECHANICAL EQUIPMENT & DETAILS
31	ELECTRICAL PLAN & SCHEDULE
32	WATER SUPPLY
33	WASTE PLUMBING - BELOW FIN. FLR.
34	WASTE PLUMBING - ABOVE FIN. FLR.
<b>UTILITIES PLANS PROJECT NO. 24-1582 PLAN NO. B-118</b>	
1	WATER & SEWER ADDITION
2	UNDERGROUND ELECTRICAL DISTRIBUTION SYSTEM
3	STANDARD MANHOLE

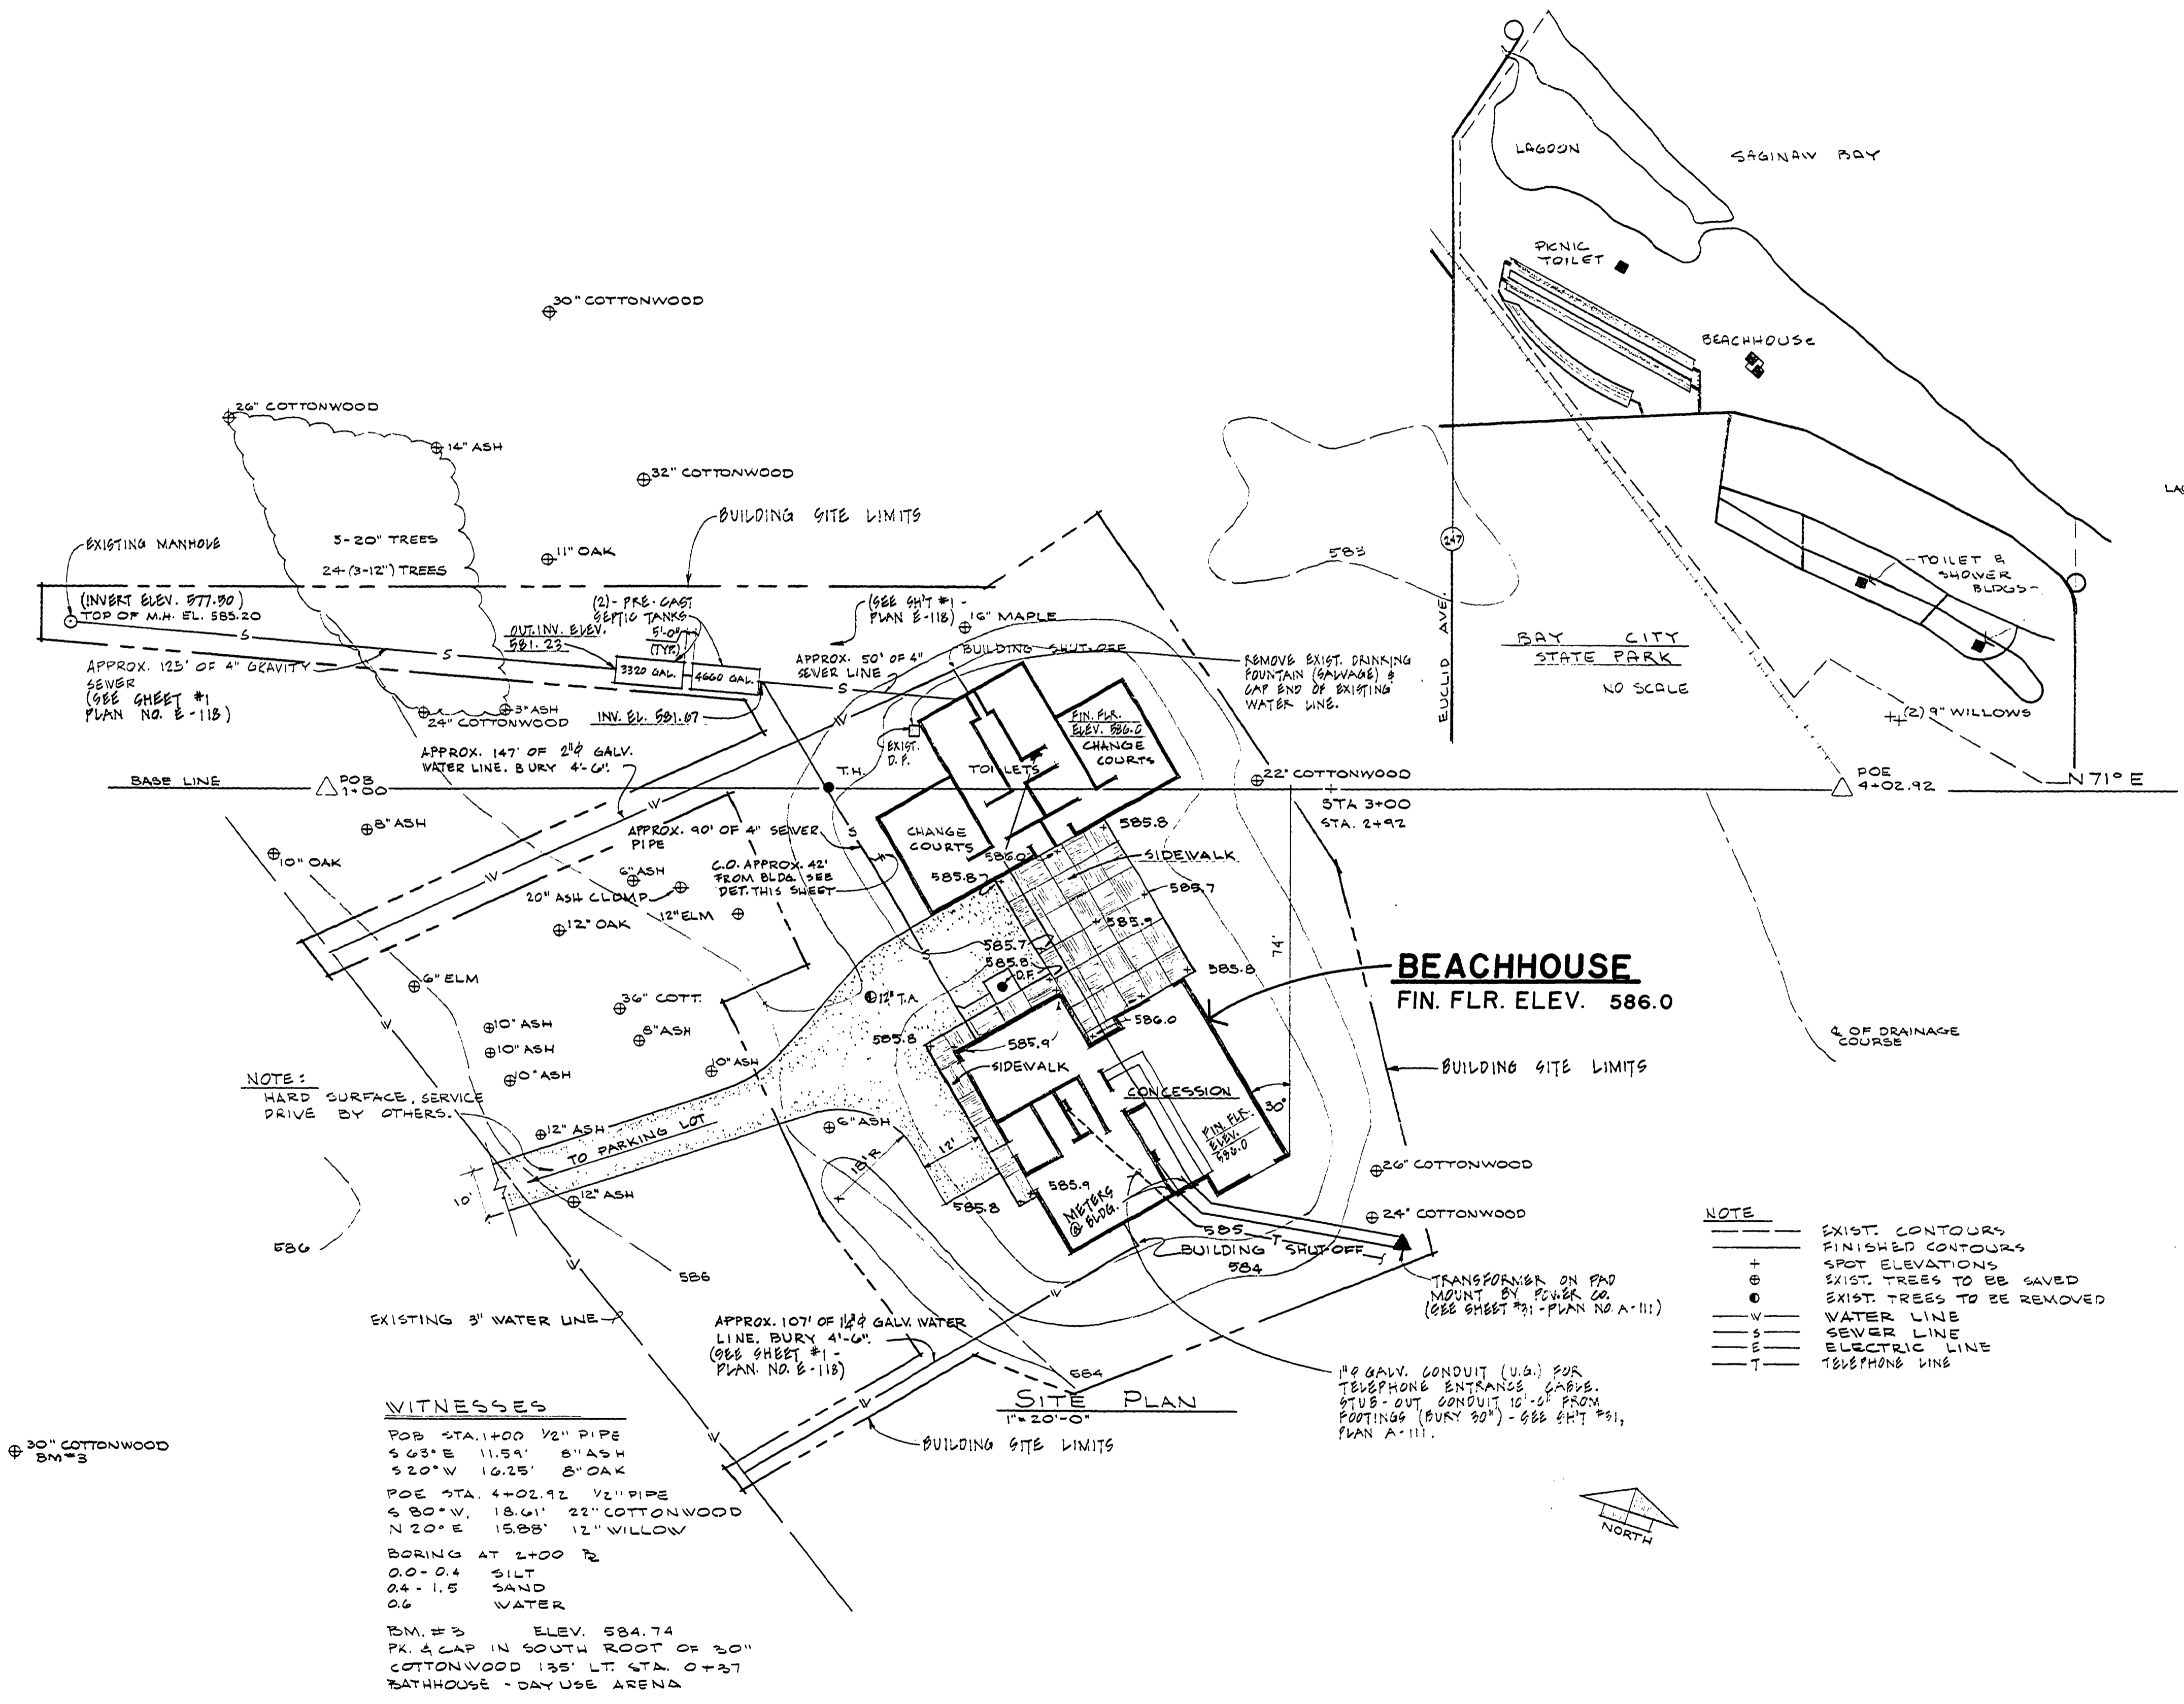

- NOTE**
- - - EXIST. CONTOURS
  - FINISHED CONTOURS
  - SPOT ELEVATIONS
  - ⊙ EXIST. TREES TO BE SAVED
  - ⊙ EXIST. TREES TO BE REMOVED
  - - - WATER LINE
  - - - SEWER LINE
  - - - ELECTRIC LINE
  - - - TELEPHONE LINE

**WITNESSES**

POB STA. 1+00 1/2" PIPE  
 5 63' E 11.5' 8" ASH  
 5 20' W 10.25' 5" OAK

POE STA. 4+02.92 1/2" PIPE  
 4 80' W 18.61' 22" COTTONWOOD  
 N 20° E 15.88' 12" WILLOW

BORING AT 2+00 72  
 0.0-0.4 SILT  
 0.4-1.5 SAND  
 0.6 WATER

BM #3 ELEV. 584.74  
 PK. & CAP IN SOUTH ROOT OF 30"  
 COTTONWOOD 135' LT. STA. 0+37  
 BATHHOUSE - DAY USE ARENA

BUILDING COMMITTEE APPROVAL	
BY: _____	DATE: 12/18/75
RECOMMENDED FOR APPROVAL: <i>[Signature]</i> 3/1/77	
ENGINEERING OR ARCHITECTURAL SUPERVISOR DATE	
RECOMMENDED FOR APPROVAL: _____	
PROGRAM AND PLAN COORDINATOR DATE	
DIVISION/REGION APPROVAL	
BY: <i>[Signature]</i> 3-1-77	DATE
ENGINEERING DIVISION	
APPROVED: _____	
CHIEF ENGINEER DATE	
PROJECT NO. 24-1582	
SHEET 1 OF 34 PLAN NO. A-111	

SURVEYED BY	DRAWN BY S. P. G. TOMPKINS	NO. DATE BY	REVISIONS	NO. DATE BY	REVISIONS	MICHIGAN DEPARTMENT OF NATURAL RESOURCES	TITLE SHEET BEACHHOUSE & SITE PLAN SHEET TITLE	BAY CITY STATE PARK AREA OR PARK 4 BUILDINGS PROJECT
DESIGNED BY	CHECKED BY	1.		3.				
DATE	DATE	2.		4.				