



WASTE PLUMBING LEGEND

SYMBOLS	ABBREVS	DESCRIPTION
	C.O.	CLEANOUT
		REVENT LINE
		WASTE LINE
	V.T.R.	VENT THRU ROOF
	F.D.	FLOOR DRAIN
	DN.	DOWN

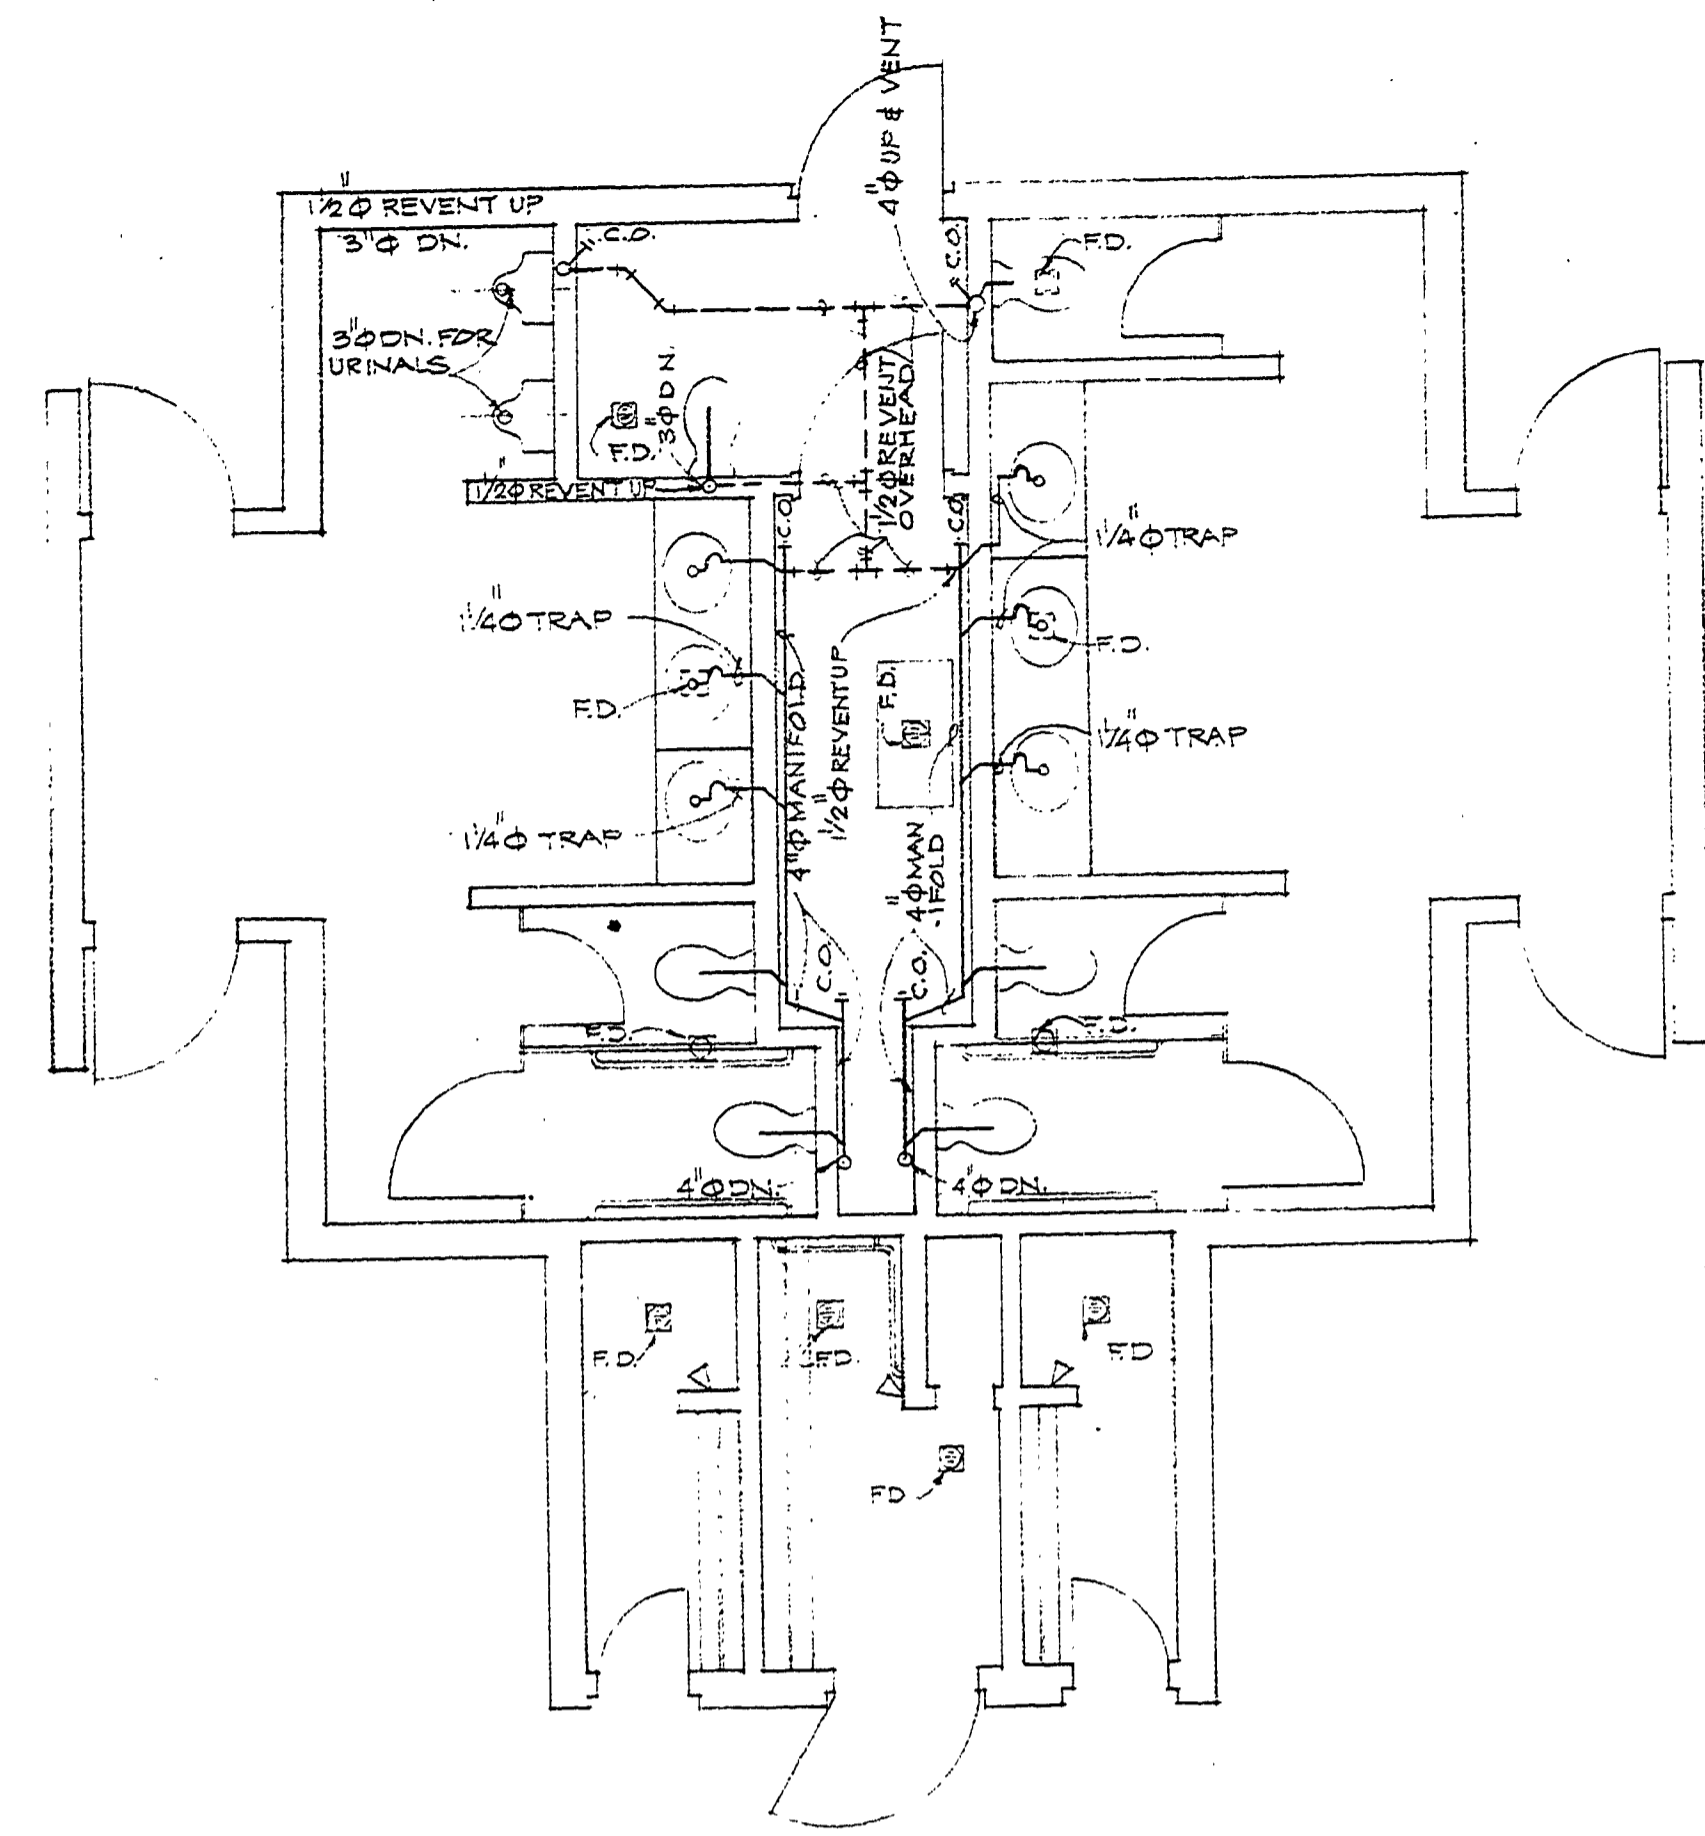

WASTE PLUMBING ABOVE FIN. FL.

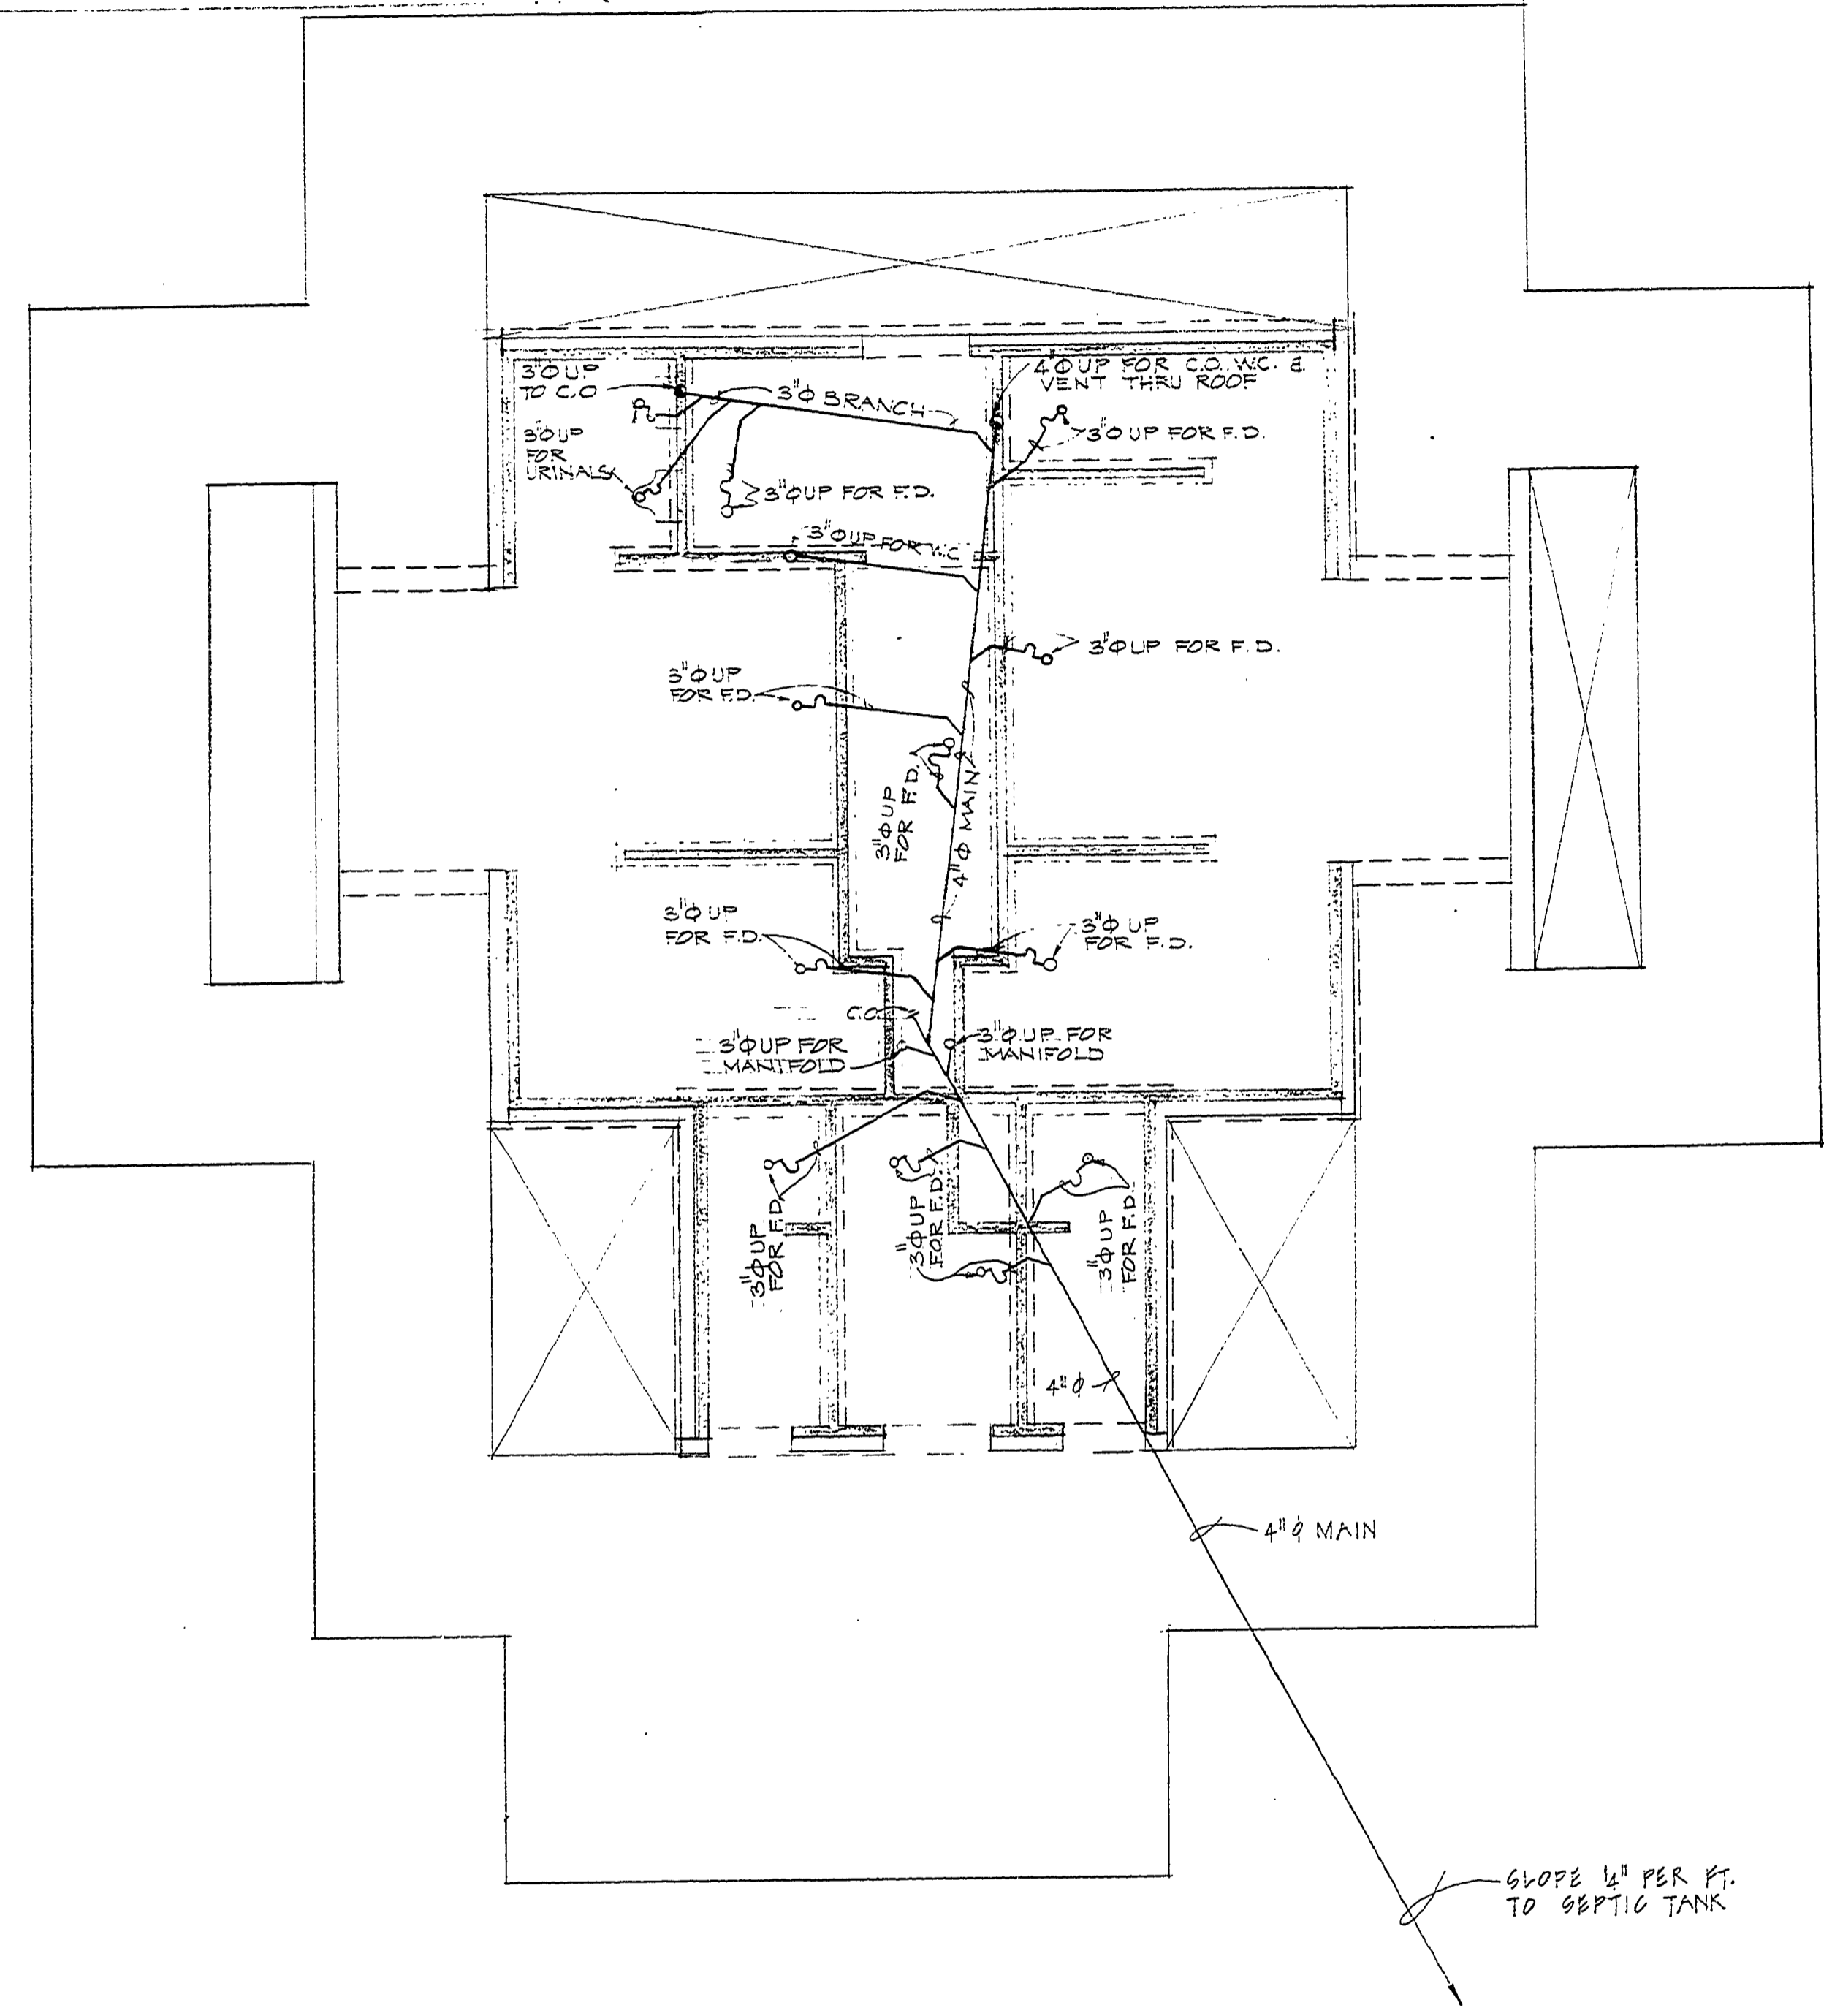

SLOPE 1/8" PER FT. TO SEPTIC TANK

SURVEYED BY	DRAWN BY M.H. & DDP	NO.	DATE	BY	REVISIONS	NO.	DATE	BY	REVISIONS	MICHIGAN DEPARTMENT OF NATURAL RESOURCES	WASTE PLUMBING & SCHEDULES	BAY CITY STATEPARK AREA OR PARK	PROJECT NO. 24-1582
DESIGNED BY	CHECKED BY	1.				3.					SHEET TITLE	PROJECT TOILET & SHOWER BLDG. NO. 2	SHEET 14 OF 34
DATE	DATE	2.				4.							PLAN NO. A-111