



ABOVE SLAB WASTE PLUMBING
SCALE 1/4" = 1'-0"

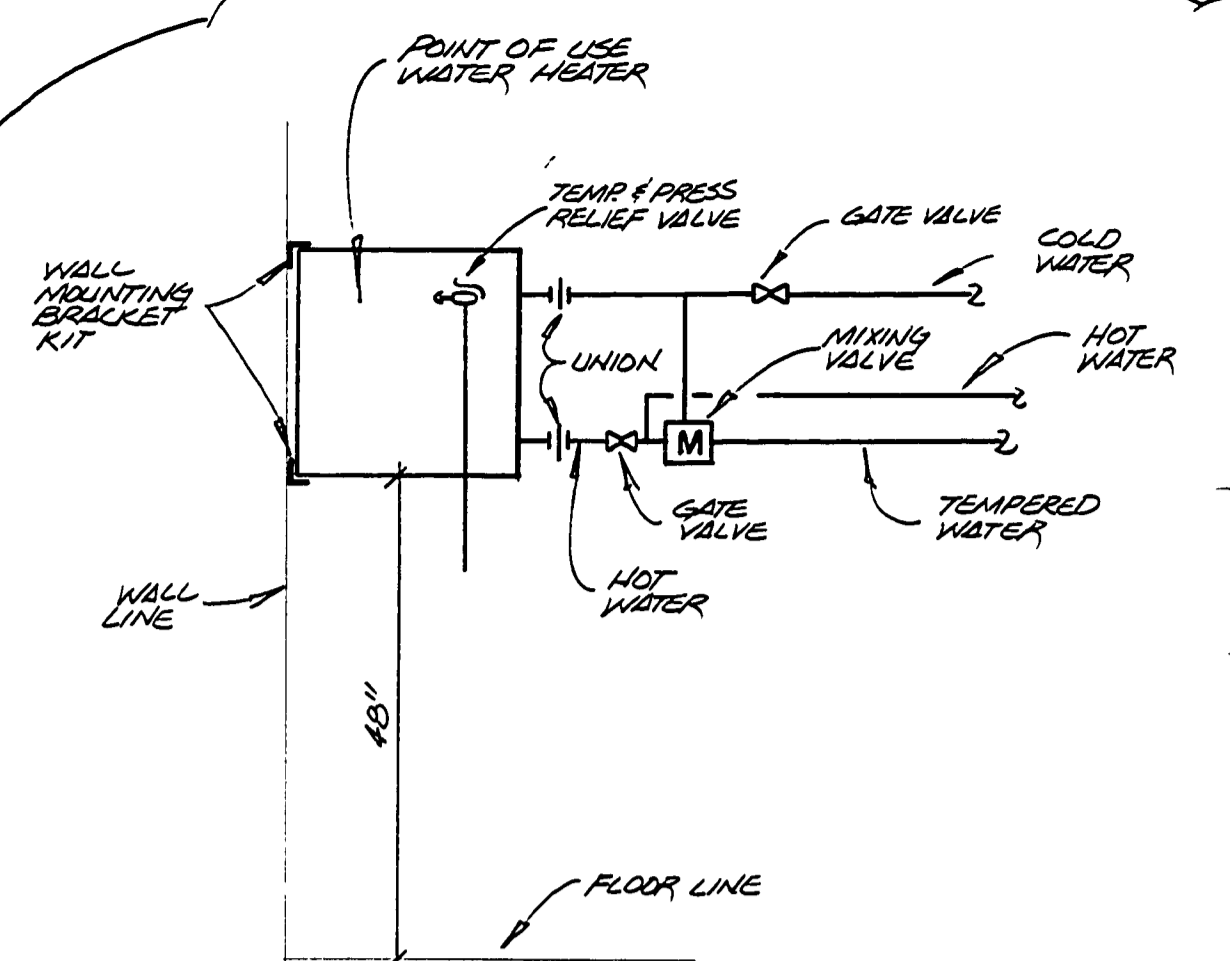


ELECTRIC WATER HEATER DETAIL
NOT TO SCALE

PLUMBING SCHEDULE					
FIXTURE	FIXTURE #	WASTE	C.W.	T.W.	H.W.
WATER CLOSET	1	4"	1"	---	---
LAVATORY	2	1/4"	1/2"	---	---
URINAL	3	3"	3/4"	---	---
DRINKING FOUNTAIN	4	1/4"	1/2"	---	---
HOSE BIBB	5	---	1/2"	---	---
HOSE BIBB	6	---	3/4"	---	* 3/4"
FLOOR DRAIN	7	4"	---	---	---
CLEAN OUT (FLOOR)	8	4"	---	---	---
CLEAN OUT (STICK)	9	4"	---	---	---


1. MOUNT HOSE BIBB (FIXTURE NO. 5) 24" ABOVE FINISHED FLOOR.
2. MOUNT HOSE BIBB (FIXTURE NO. 6) IN MEN'S AND WOMEN'S TOILET ROOM 18" ABOVE FINISHED FLOOR. (COLD WATER SUPPLY)
3. MOUNT HOSE BIBB (FIXTURE NO. 6) IN PIPE ALLEY 30" ABOVE FINISHED FLOOR. (TEMPERED WATER SUPPLY)

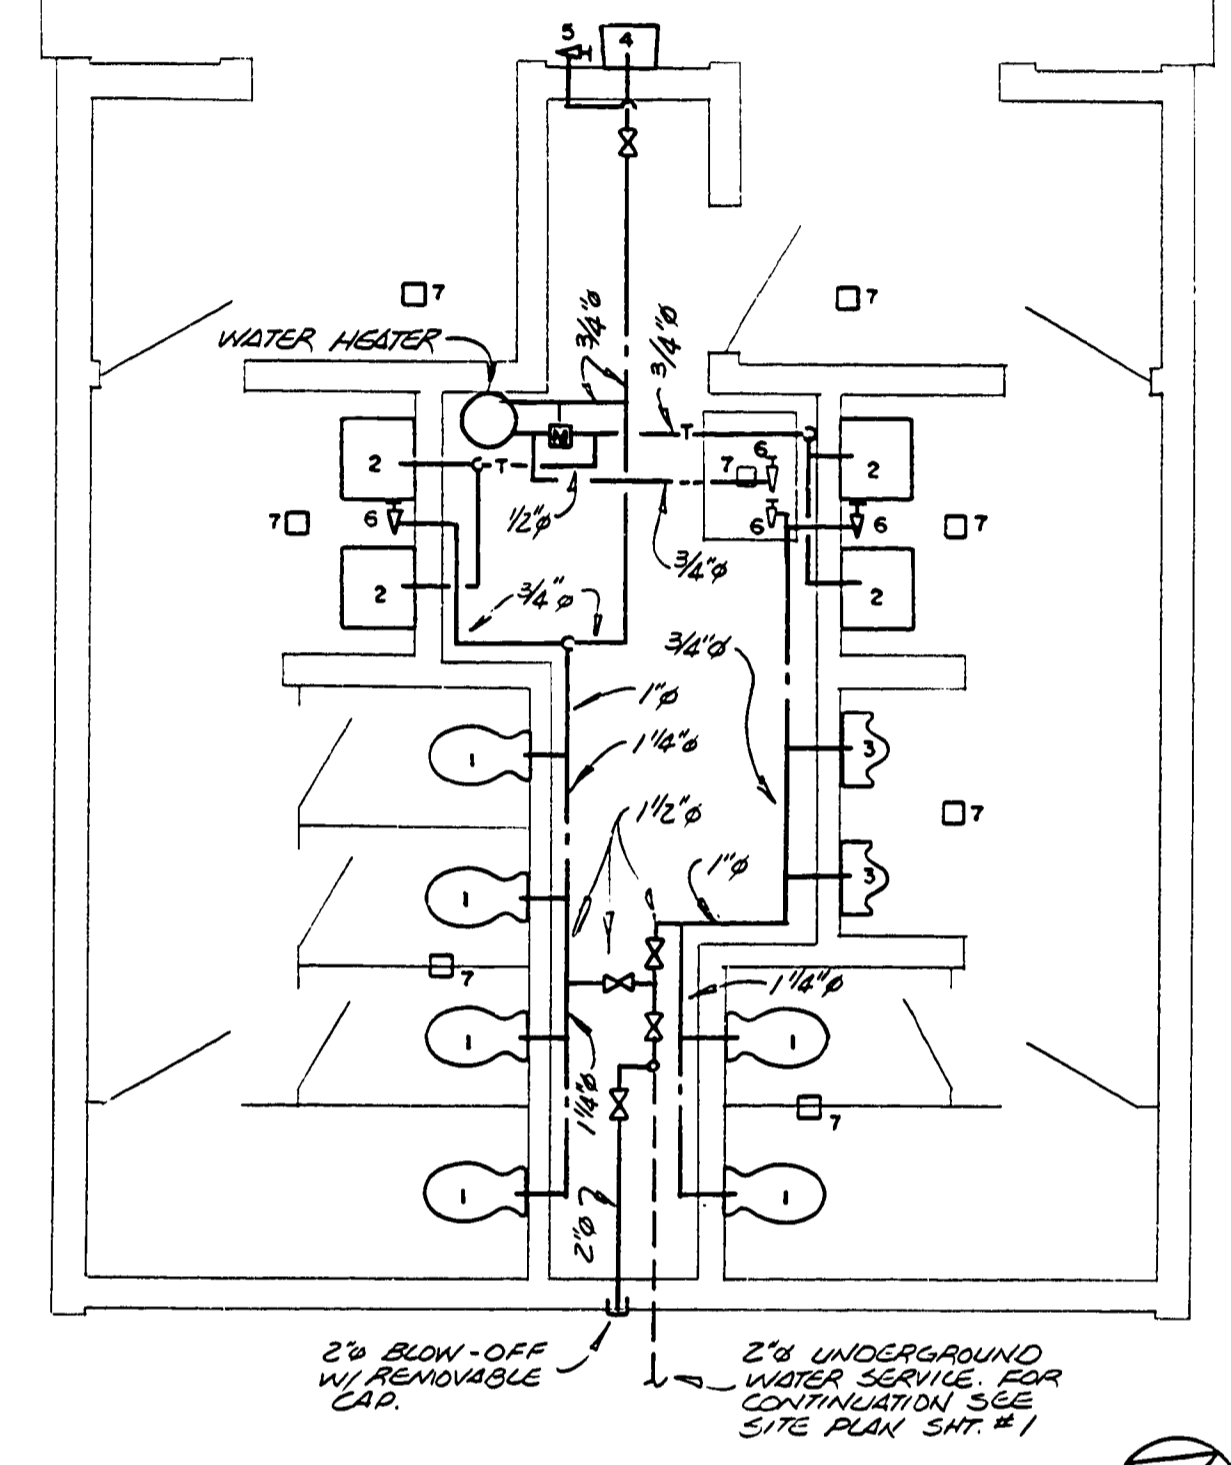

SUPPLY PLUMBING FLOOR PLAN
SCALE 1/4" = 1'-0"

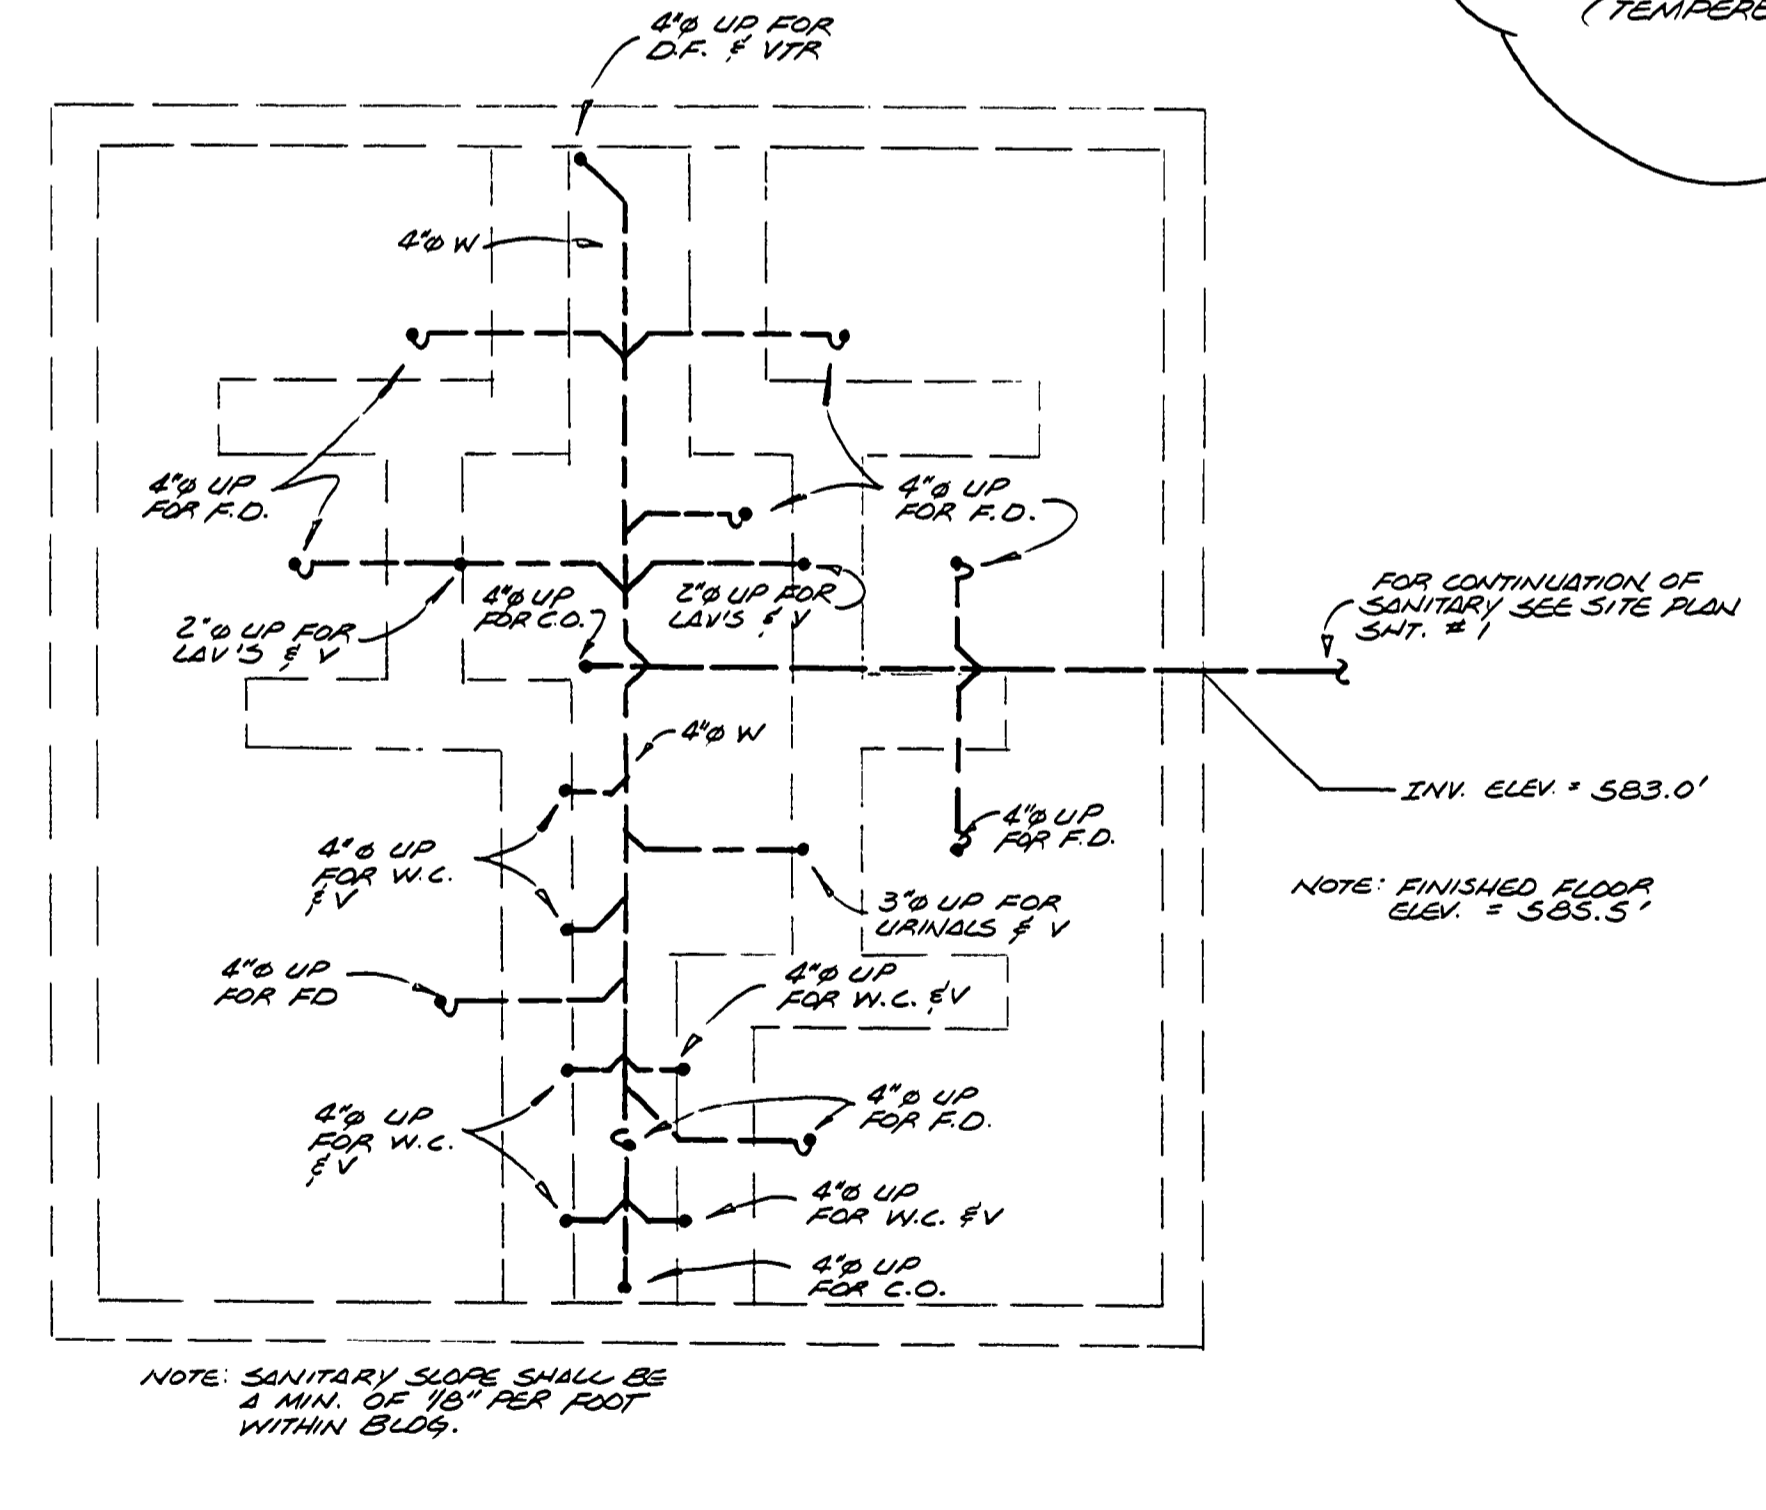

BELOW SLAB WASTE PLUMBING
SCALE 1/4" = 1'-0"

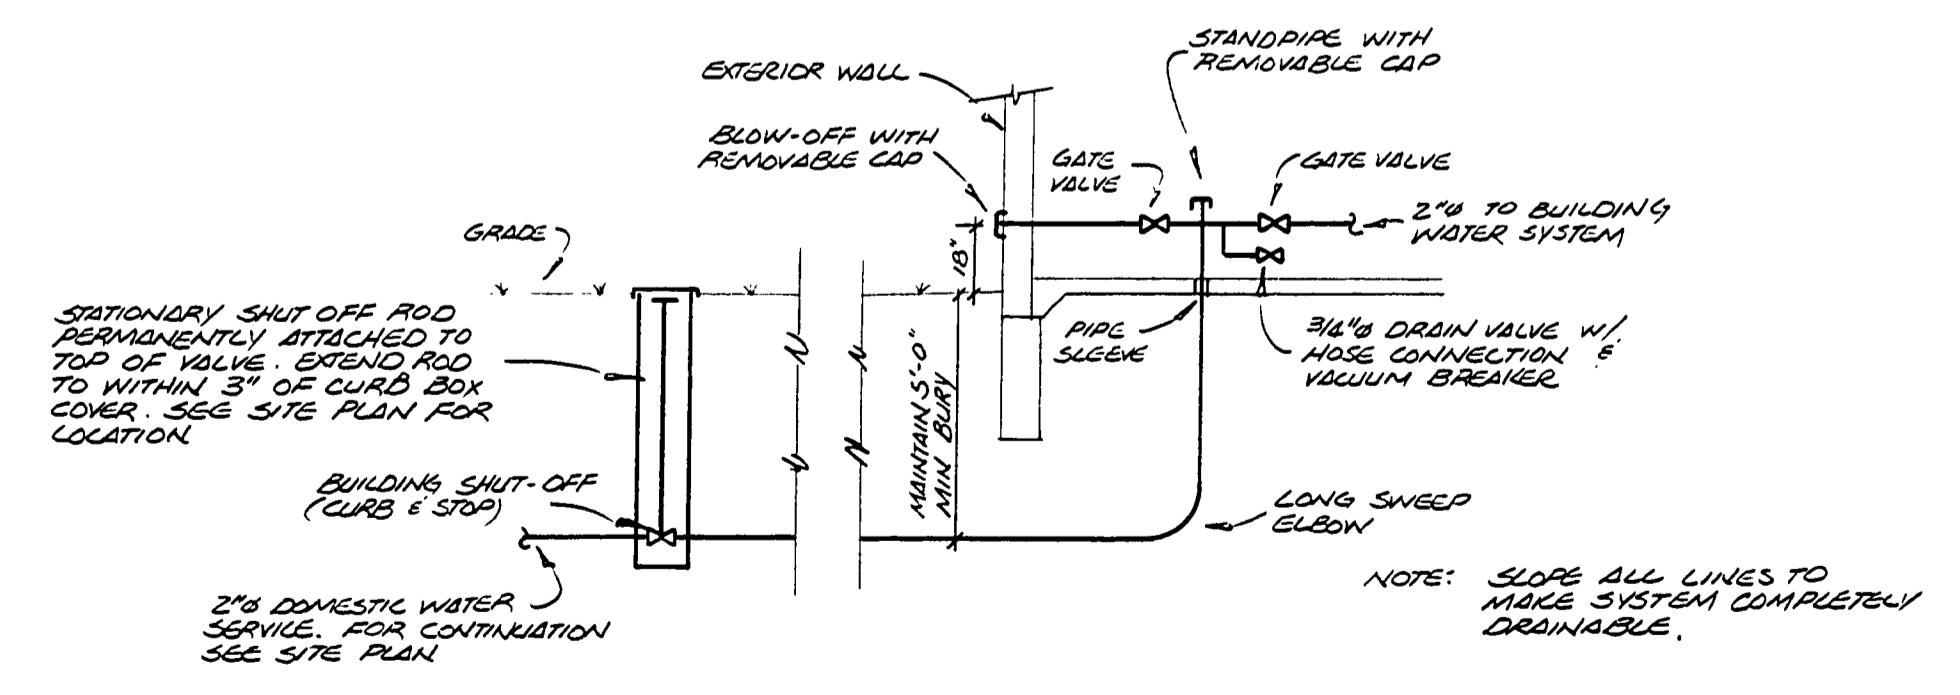

WATER SERVICE ENTRANCE
NO SCALE

PLUMBING LEGEND

---	TEMPERED WATER
---	HOT WATER
---	COLD WATER LINE
---	REVENT
⊗	GATE VALVE
CO	CLEAN OUT
D.F	DRINKING FOUNTAIN
FD	FLOOR DRAIN
INV. ELEV.	INVERT ELEVATION
LAV	LAVATORY
V	VENT
VTR	VENT THRU ROOF
W	WASTE
WC	WATER CLOSET
⊥	HOSE BIBB
⊕	MIXING VALVE
T.W	TEMPERED WATER
H.W	HOT WATER