


RISER DIAGRAM  
NOT TO SCALE

ELECTRICAL NOTES

1. CIRCUIT NUMBERS REPRESENT SINGLE POLE SPACES IN THE PANEL AND DO NOT CORRESPOND TO ACTUAL PANEL PHASING.
2. LOADS ON PANELS ARE TO BE BALANCED BY THE ELECTRICAL CONTRACTOR AT TIME OF INSTALLATION.
3. CONTRACTOR TO PHYSICALLY ARRANGE ALL CIRCUIT BREAKERS WITH ALL LIGHTING CIRCUITS SEPARATELY GROUPED AT THE TOP OF THE PANEL AND ALL SPACES AND SPACES SEPARATELY GROUPED AT THE BOTTOM OF THE PANEL.
4. DEVICE BOXES IN PIPE ALLEY MAY BE SURFACE MOUNTED. ALL OTHERS SHALL BE FLUSH MOUNTED.

ELECTRICAL LEGEND

- WALL MOUNTED HID LIGHTING FIXTURE
- WALL MOUNTED INCANDESCENT FIXTURE
- CONVENIENCE OUTLET
- A.F.F. ABOVE FINISHED FLOOR
- C CONDUIT
- CCF CIRCUIT
- G.F.I. GROUND FAULT INTERRUPTERS
- WP WEATHER PROOF

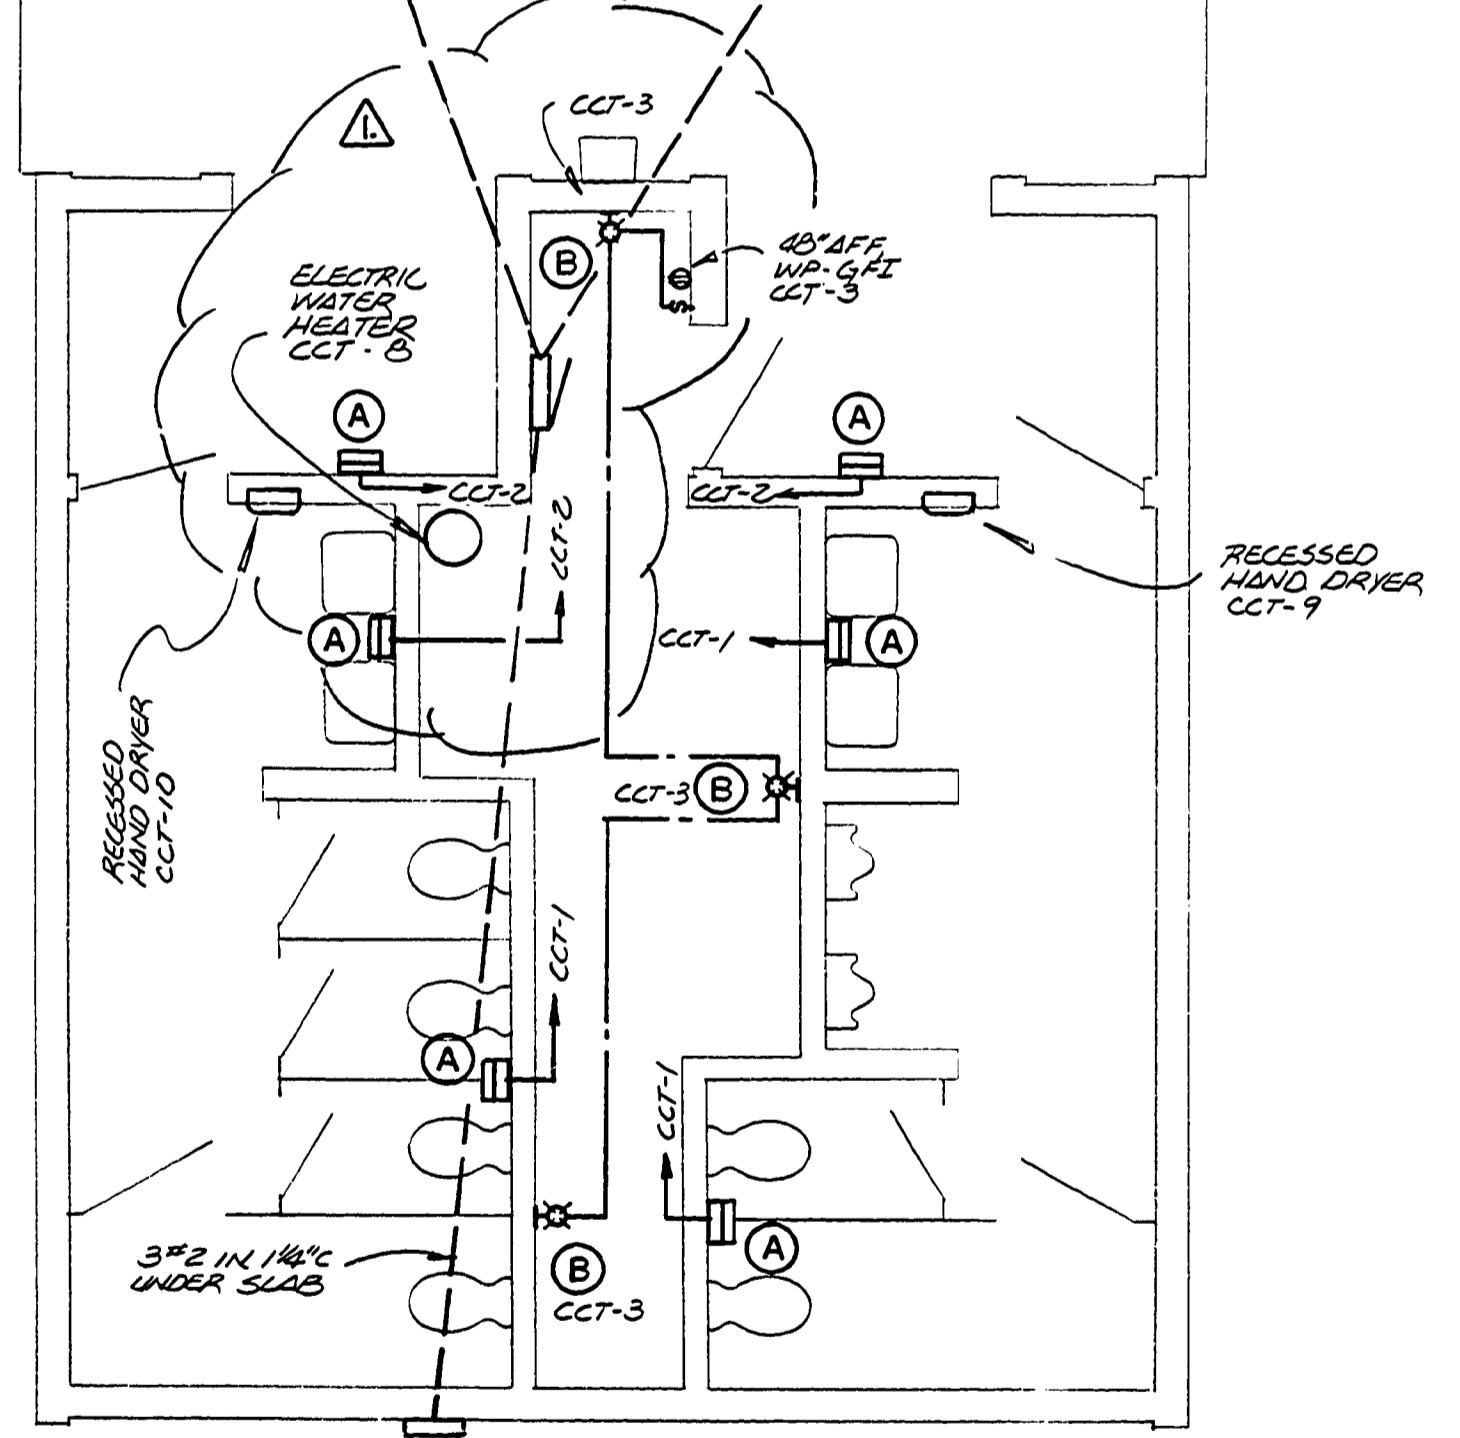

ELECTRICAL FLOOR PLAN  
SCALE 1/4" = 1'-0"

LIGHTING FIXTURE SCHEDULE						
MARK	MFR.	CATALOG NO.	DESCRIPTION	LAMPS	DIFFUSER	REMARKS
A	MCGRAW EDISON	W 2031	MONITOR WALL LIGHT	(1) LU35/MED	HIGH IMPACT SHATTER RESISTANT POLYCARBONATE	PROVIDE WITH TAMPER PROOF SCREWS. WALL MOUNT 9'-0" A.F.F. UNLESS OTHERWISE NOTED.
B	LEVITON	9875	STANDARD PORCELAIN FIXTURE	(1) 100 WATT, A-19	NONE	WALL MOUNT 8'-0" A.F.F.